

PORT OF TACOMA FILE: D:\OneDrive\Vector\Clients\04-Cardno\Maintenance\Mezzanine\CAD\Sheet Files\MID 101140.01 COVER\_SHED

BINDING EDGE

# PORT OF TACOMA

## MAINTENANCE SHED HEATING

PROJECT NO. 101140.01  
CONTRACT NO. 070735

### PORT COMMISSIONERS:

CONSTANCE T. BACON  
DON MEYER  
DONALD C. JOHNSON  
RICHARD P. MARZANO  
CLARE PETRICH

### PORT STAFF:


JOHN WOLFE  
Chief Executive Officer  
  
DAKOTA CHAMBERLAIN  
Director of Facilities  
Development

JANE VANDENBERG, PE  
Director of Engineering


STANLEY RYTER, PE  
Project Manager


### CONSULTANTS:

 **Cardno**  
Shaping the Future  
  
SEATTLE  
801 SECOND AVENUE, STE 700, SEATTLE, WA. 98104  
TEL: (206) 269 - 0104  
www.cardno.com

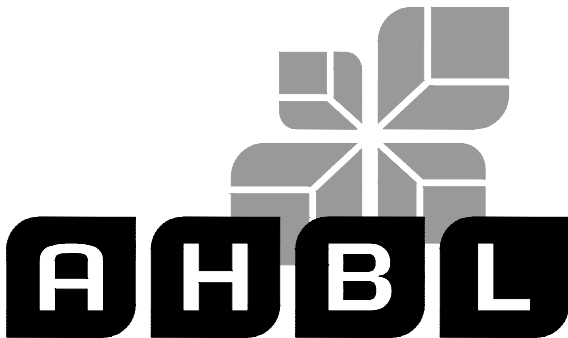 **AHBL**


2215 North 30th Street,  
Suite 300,  
Tacoma, WA 98403  
253.383.2422 TEL  
253.383.2572 FAX

 **BLE**  
bce engineers, inc.  
p: (253) 922-0446  
f: (253) 922-0896  
6021 12th street east, suite 200, fife, wa 98424

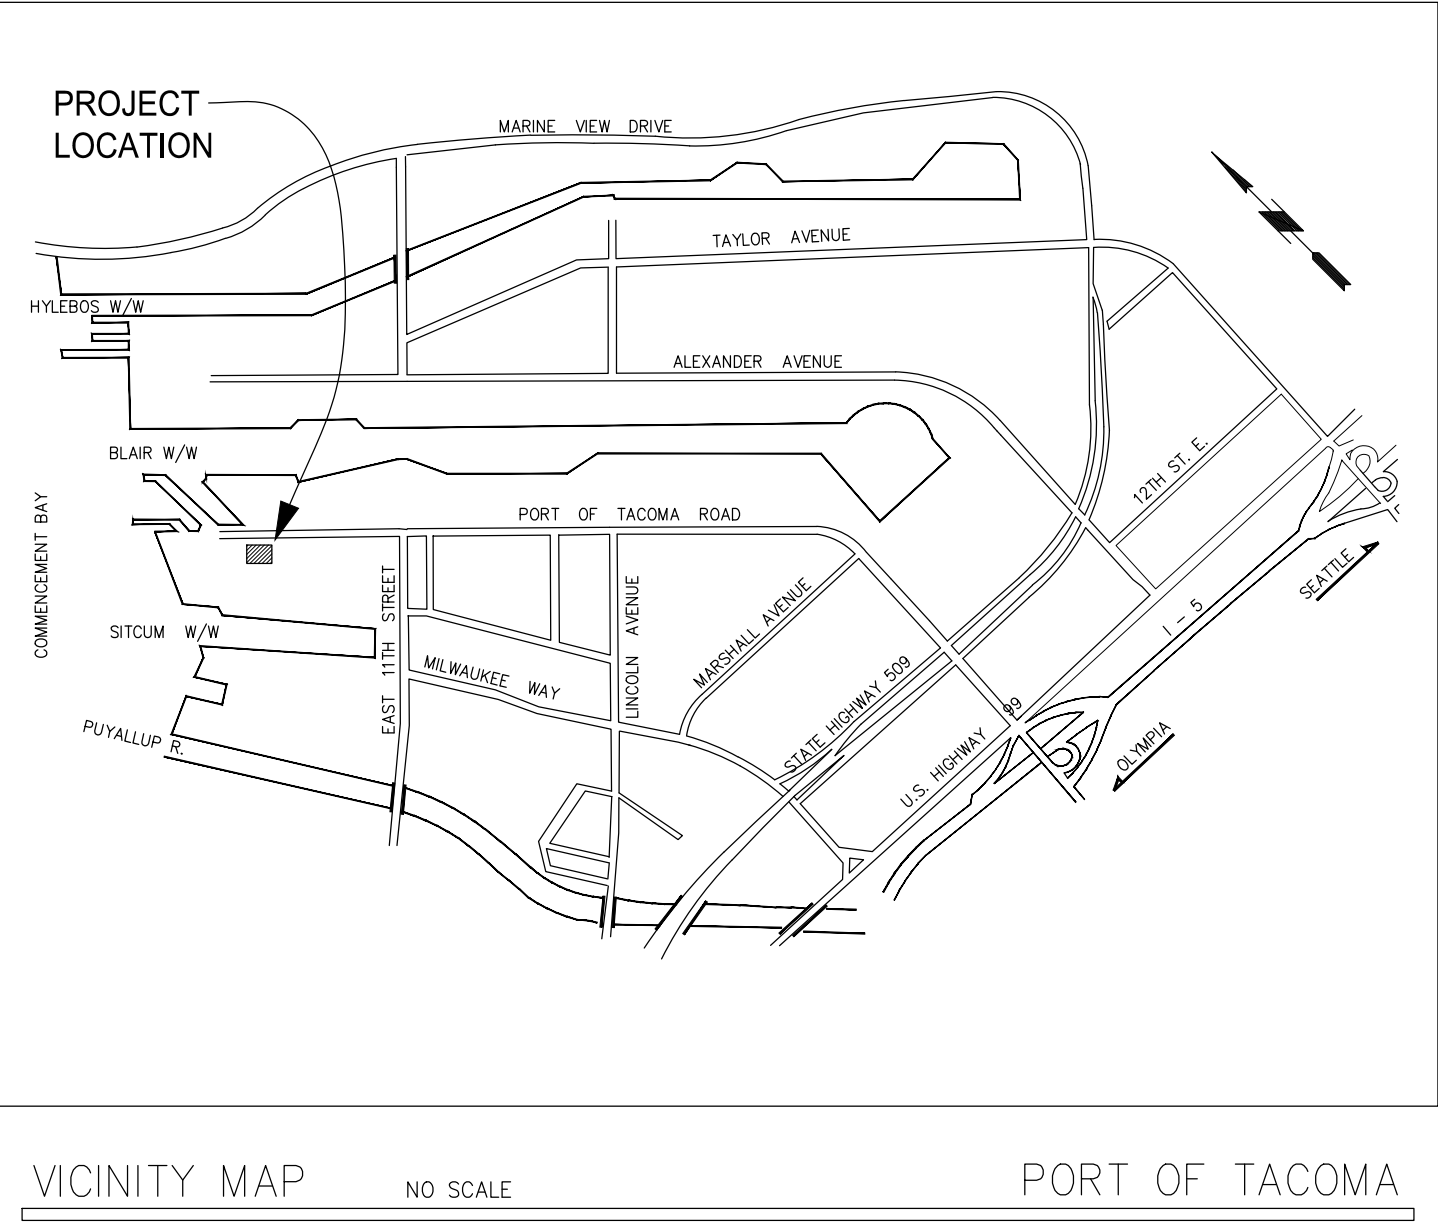


DRAWING LIST			
SHEET DESIGNATION	SHEET #	SHEET TITLE	REVISION
G1.1	1	COVER SHEET	0
A1.1	2	SHED FLOOR PLAN	1
A1.2	3	SHED ELEVATION	0
M1.3	4	MECHANICAL SHED PLAN	0
EO.2	5	ELECTRICAL LEGEND AND POWER RISER DIAGRAM	0
E4.1	6	SHED ELECTRICAL PLAN	0


SPECIAL INSPECTION



Port of Tacoma  
P.O. BOX 1837 TACOMA, WA 98401 (253)383-3441



Cardno  
Shaping the Future

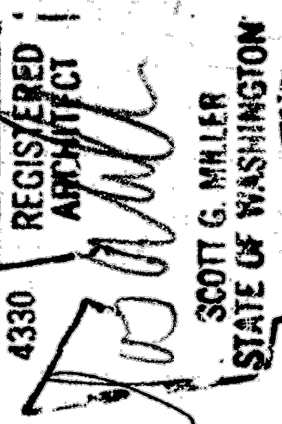

4330 REGISTERED ARCHITECT  
SCOTT G. MILLER  
STATE OF WASHINGTON

SCM 12-19-17  
CHECKED BY DATE

APPROVED:

DIRECTOR ENG. DATE  
PRINTED BY: vecto Jan 23, 2018  
PORT ADDRESS: T001 PORT OF TACOMA RD  
TACOMA, WA 98421

6582  
G1.1  
SH 1 OF 6

CONT/CONS: 070735  
M. ID: 101140.01  
PHASE: BID SET


MAINTENANCE SHED HEATING  
COVER SHEET

TOWNSHIP: 21N RANGE: 3E SECTION: 34  
DAT-HRZ: WA83-SF VERT: MLLW 19.18' @ Tide 22 1933  
PARCEL: 2275200610 DRAWING SCALE: AS NOTED

THIS DRAWING IS THE PROPERTY OF THE PORT OF TACOMA AND SHALL NOT BE USED ON OTHER WORK, DISCLOSED, COPIED, IN WHOLE OR IN PART, WITHOUT WRITTEN PERMISSION

NOTE: CONTRACTOR TO REMOVE AND PROPERLY DISPOSE OF ALL EXISTING INSULATION @ WALLS & CEILING. CONTRACTOR TO VERIFY & INFORM OWNER IF CURRENT INSULATION IS PLACED UNDER EXISTING ROOF STRUCTURE @ ROOF BEAMS. THE ENGINEER WILL DETERMINE IF RESULT OF INVESTIGATION POSES A STRUCTURAL INTEGRITY THREAT TO CURRENT ROOF ATTACHMENT.

NOTE: ALL NEW INSULATION TO HAVE VINYL PROTECTIVE COVER ON INTERIOR BUILDING SIDE OF INSULATION (SIMILAR TO EXISTING)

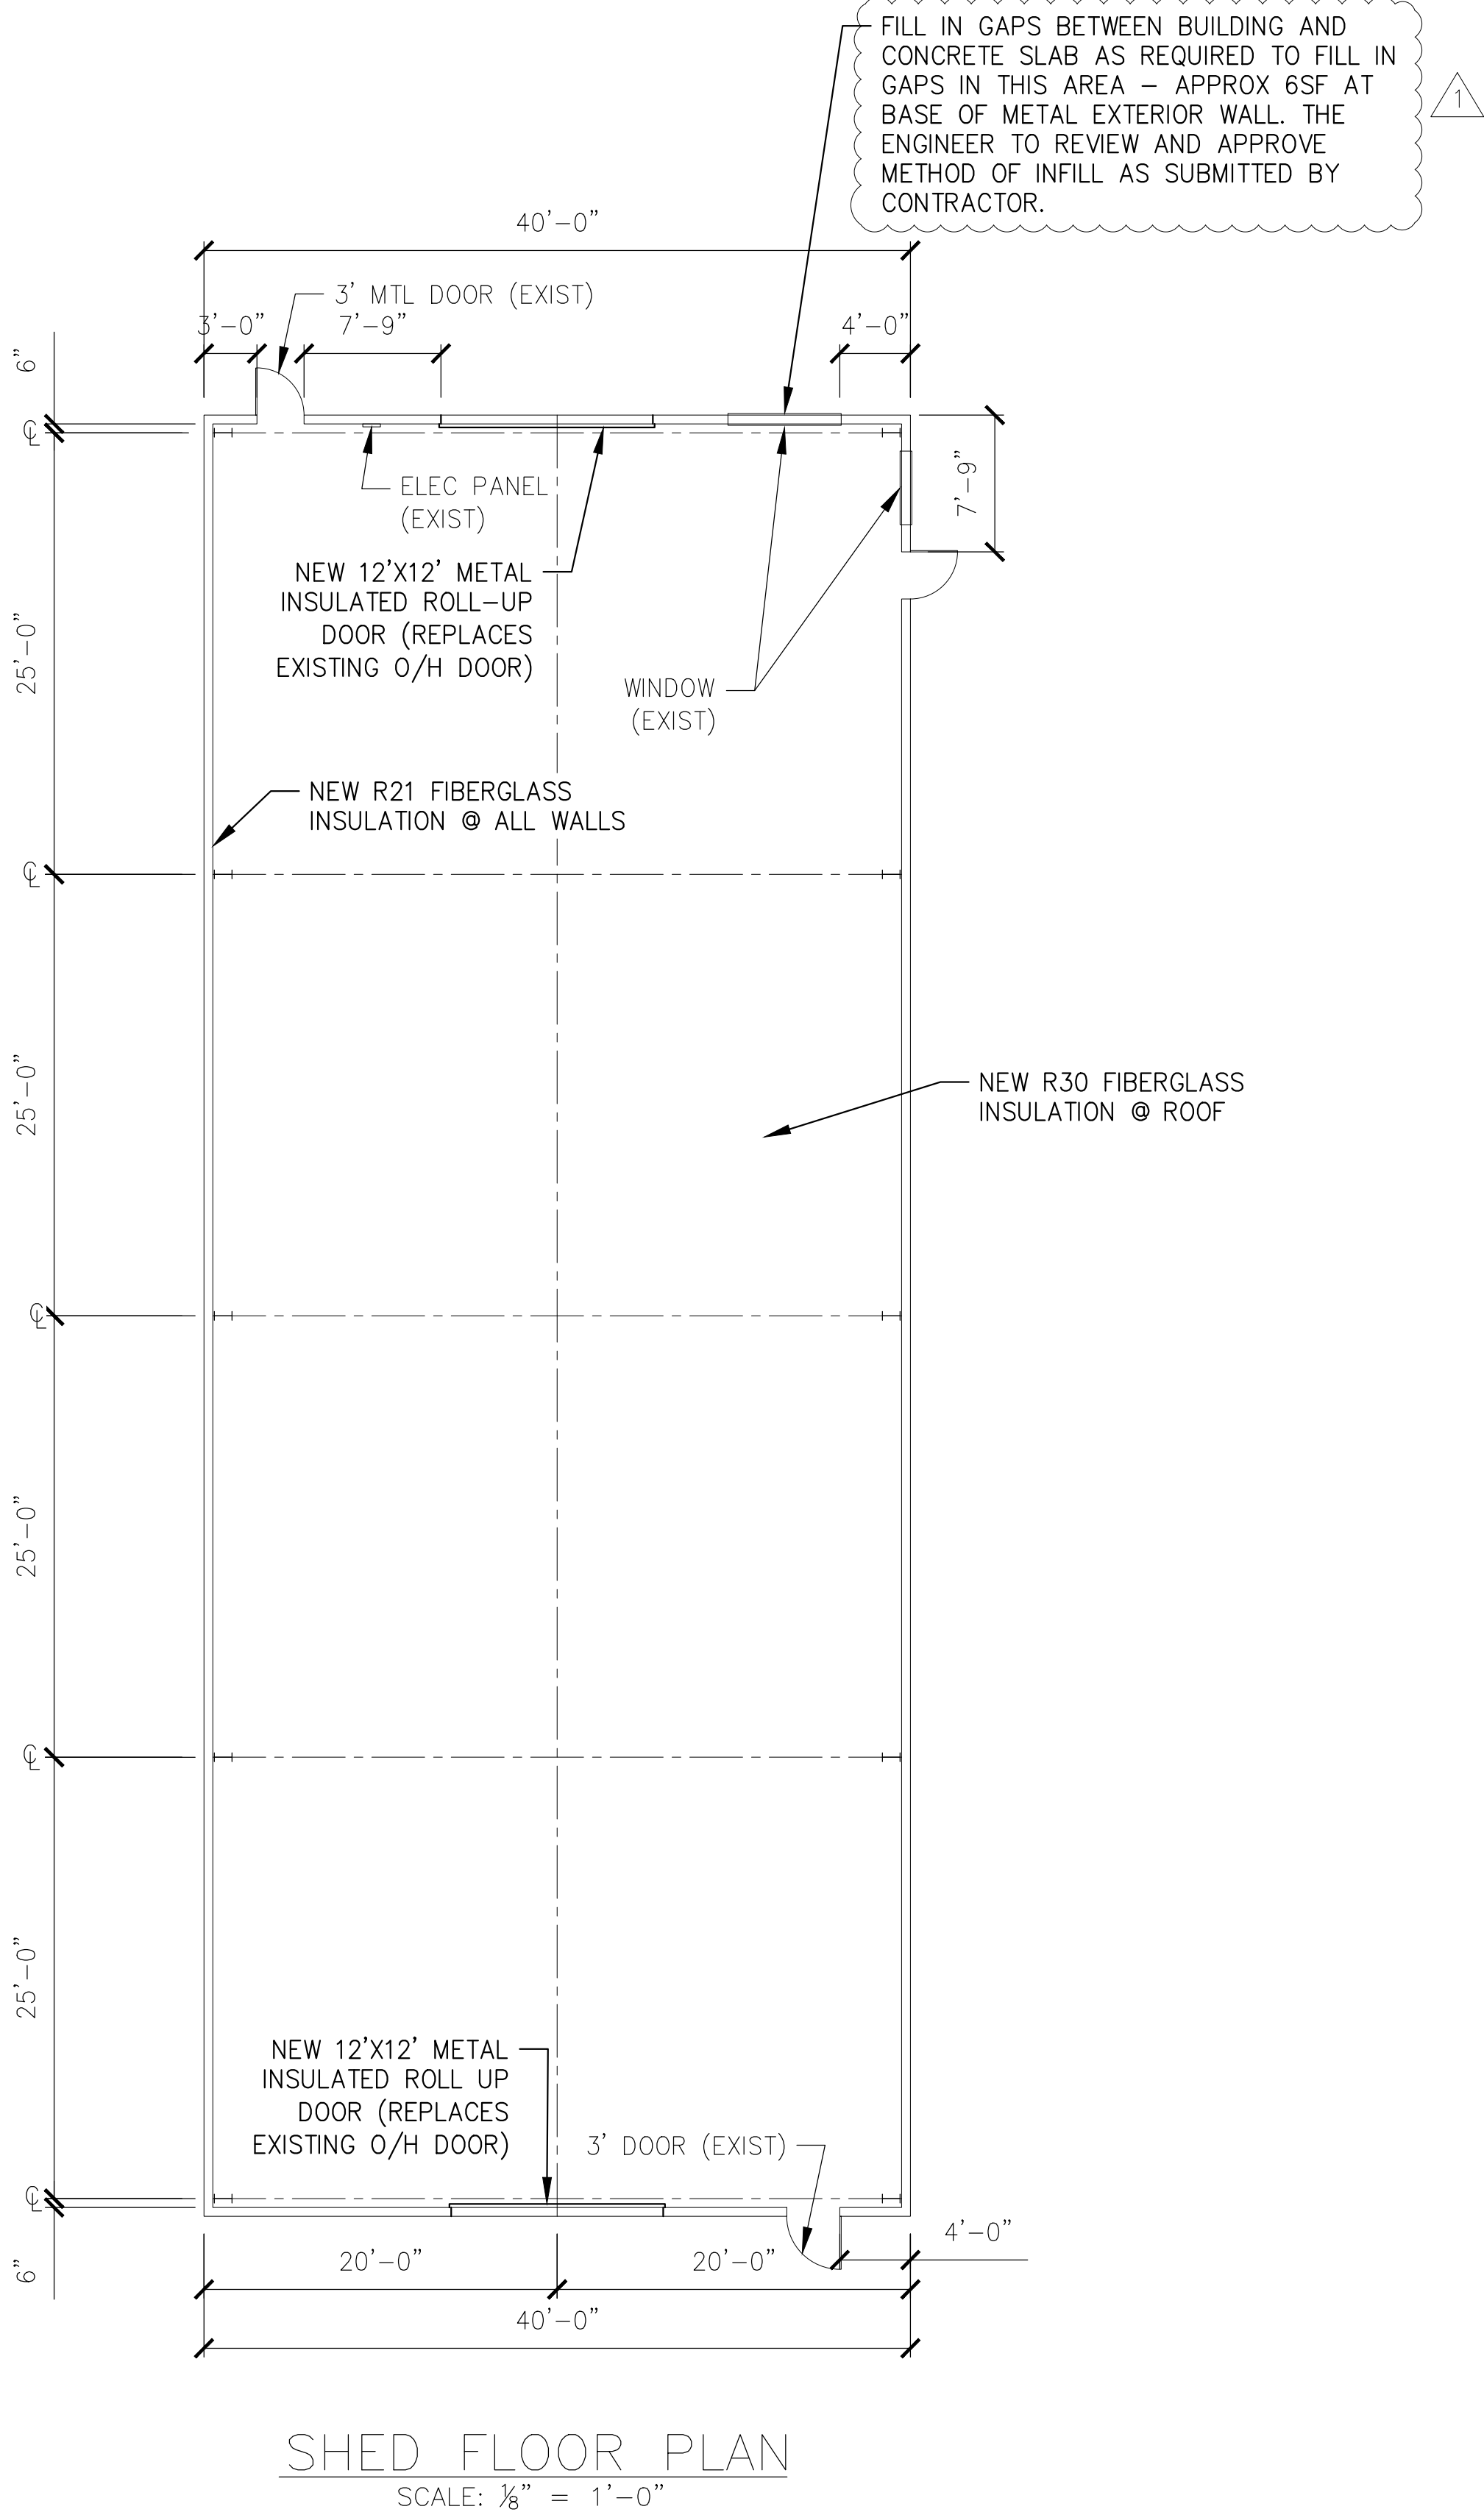

6582 <b>A1.1</b> SH 2 OF 6	MAINTENANCE SHED HEATING				APPROVED:				SGM		12-19-17						
	SHED FLOOR PLAN				CHECKED BY:				DATE								
					DIRECTOR ENG. DATE				PROJ. ENGR		DATE						
					PRINTED BY: vecto				Jan 23, 2018								
CONTR/CONS: 070735		TOWNSHIP: 21N		RANGE: 3E		SECTION: 34		PORT ADDRESS: 1001 PORT OF TACOMA RD									
M. ID: 101140.01		DATE-HRZ: WA83-SF		VERT: MLLW 19.18' @ Tide 22 1933						TACOMA, WA 98421							
PHASE: BID SET		PARCEL: 2275200610		DRAWING SCALE: AS NOTED													
												MARK:		REVISION:		DATE:	
												/A		BLDG. DEPT. REVISIONS SGM		APPR:	
																DATE:	