


GENERAL NOTES


- 1. ALL 15KV DUCTBANK AND VAULT WORK SHALL BE INSTALLED PER TACOMA POWER STANDARD REQUIREMENTS.
- 2. SEE ONE LINE DIAGRAM FOR SEPARATION OF WORK OF 15KV SYSTEM BETWEEN TACOMA POWER AND CONTRACTOR.
- 3. SEE SHEET E1.23 FOR CONDUIT SCHEDULE AND MANHOLE SCHEDULE.
- 4. INSTALL PULL ROPE IN ALL CONDUITS.

ELECTRICAL NOTES

- 1 SERVICE DROP FOR TACOMA POWER FEED TO TRANSFORMERS T-1 AND T-2. PROVIDE ONE 4" SCH 80 CONDUIT FROM EXISTING TACOMA POWER POLE #45310 TO VAULT M-001. COORDINATE WITH TACOMA POWER FOR CONDUIT RISER UP EXISTING POLE.
- 2 EXISTING TACOMA POWER POLE.
- 3 NEW POLE BY TACOMA POWER. PROVIDE (2) NEW 4" SCH 80 PVC CONDUITS WITH PULL ROPES FROM TACOMA POWER POLE TO NEW TRANSFORMER VAULT. COORDINATE WITH TACOMA POWER FOR CONDUIT RISERS UP THE POLE.
- 4 PROVIDE DUCTBANK PER E1.10, DETAIL 1. CONDUCTORS PROVIDED BY TACOMA POWER.

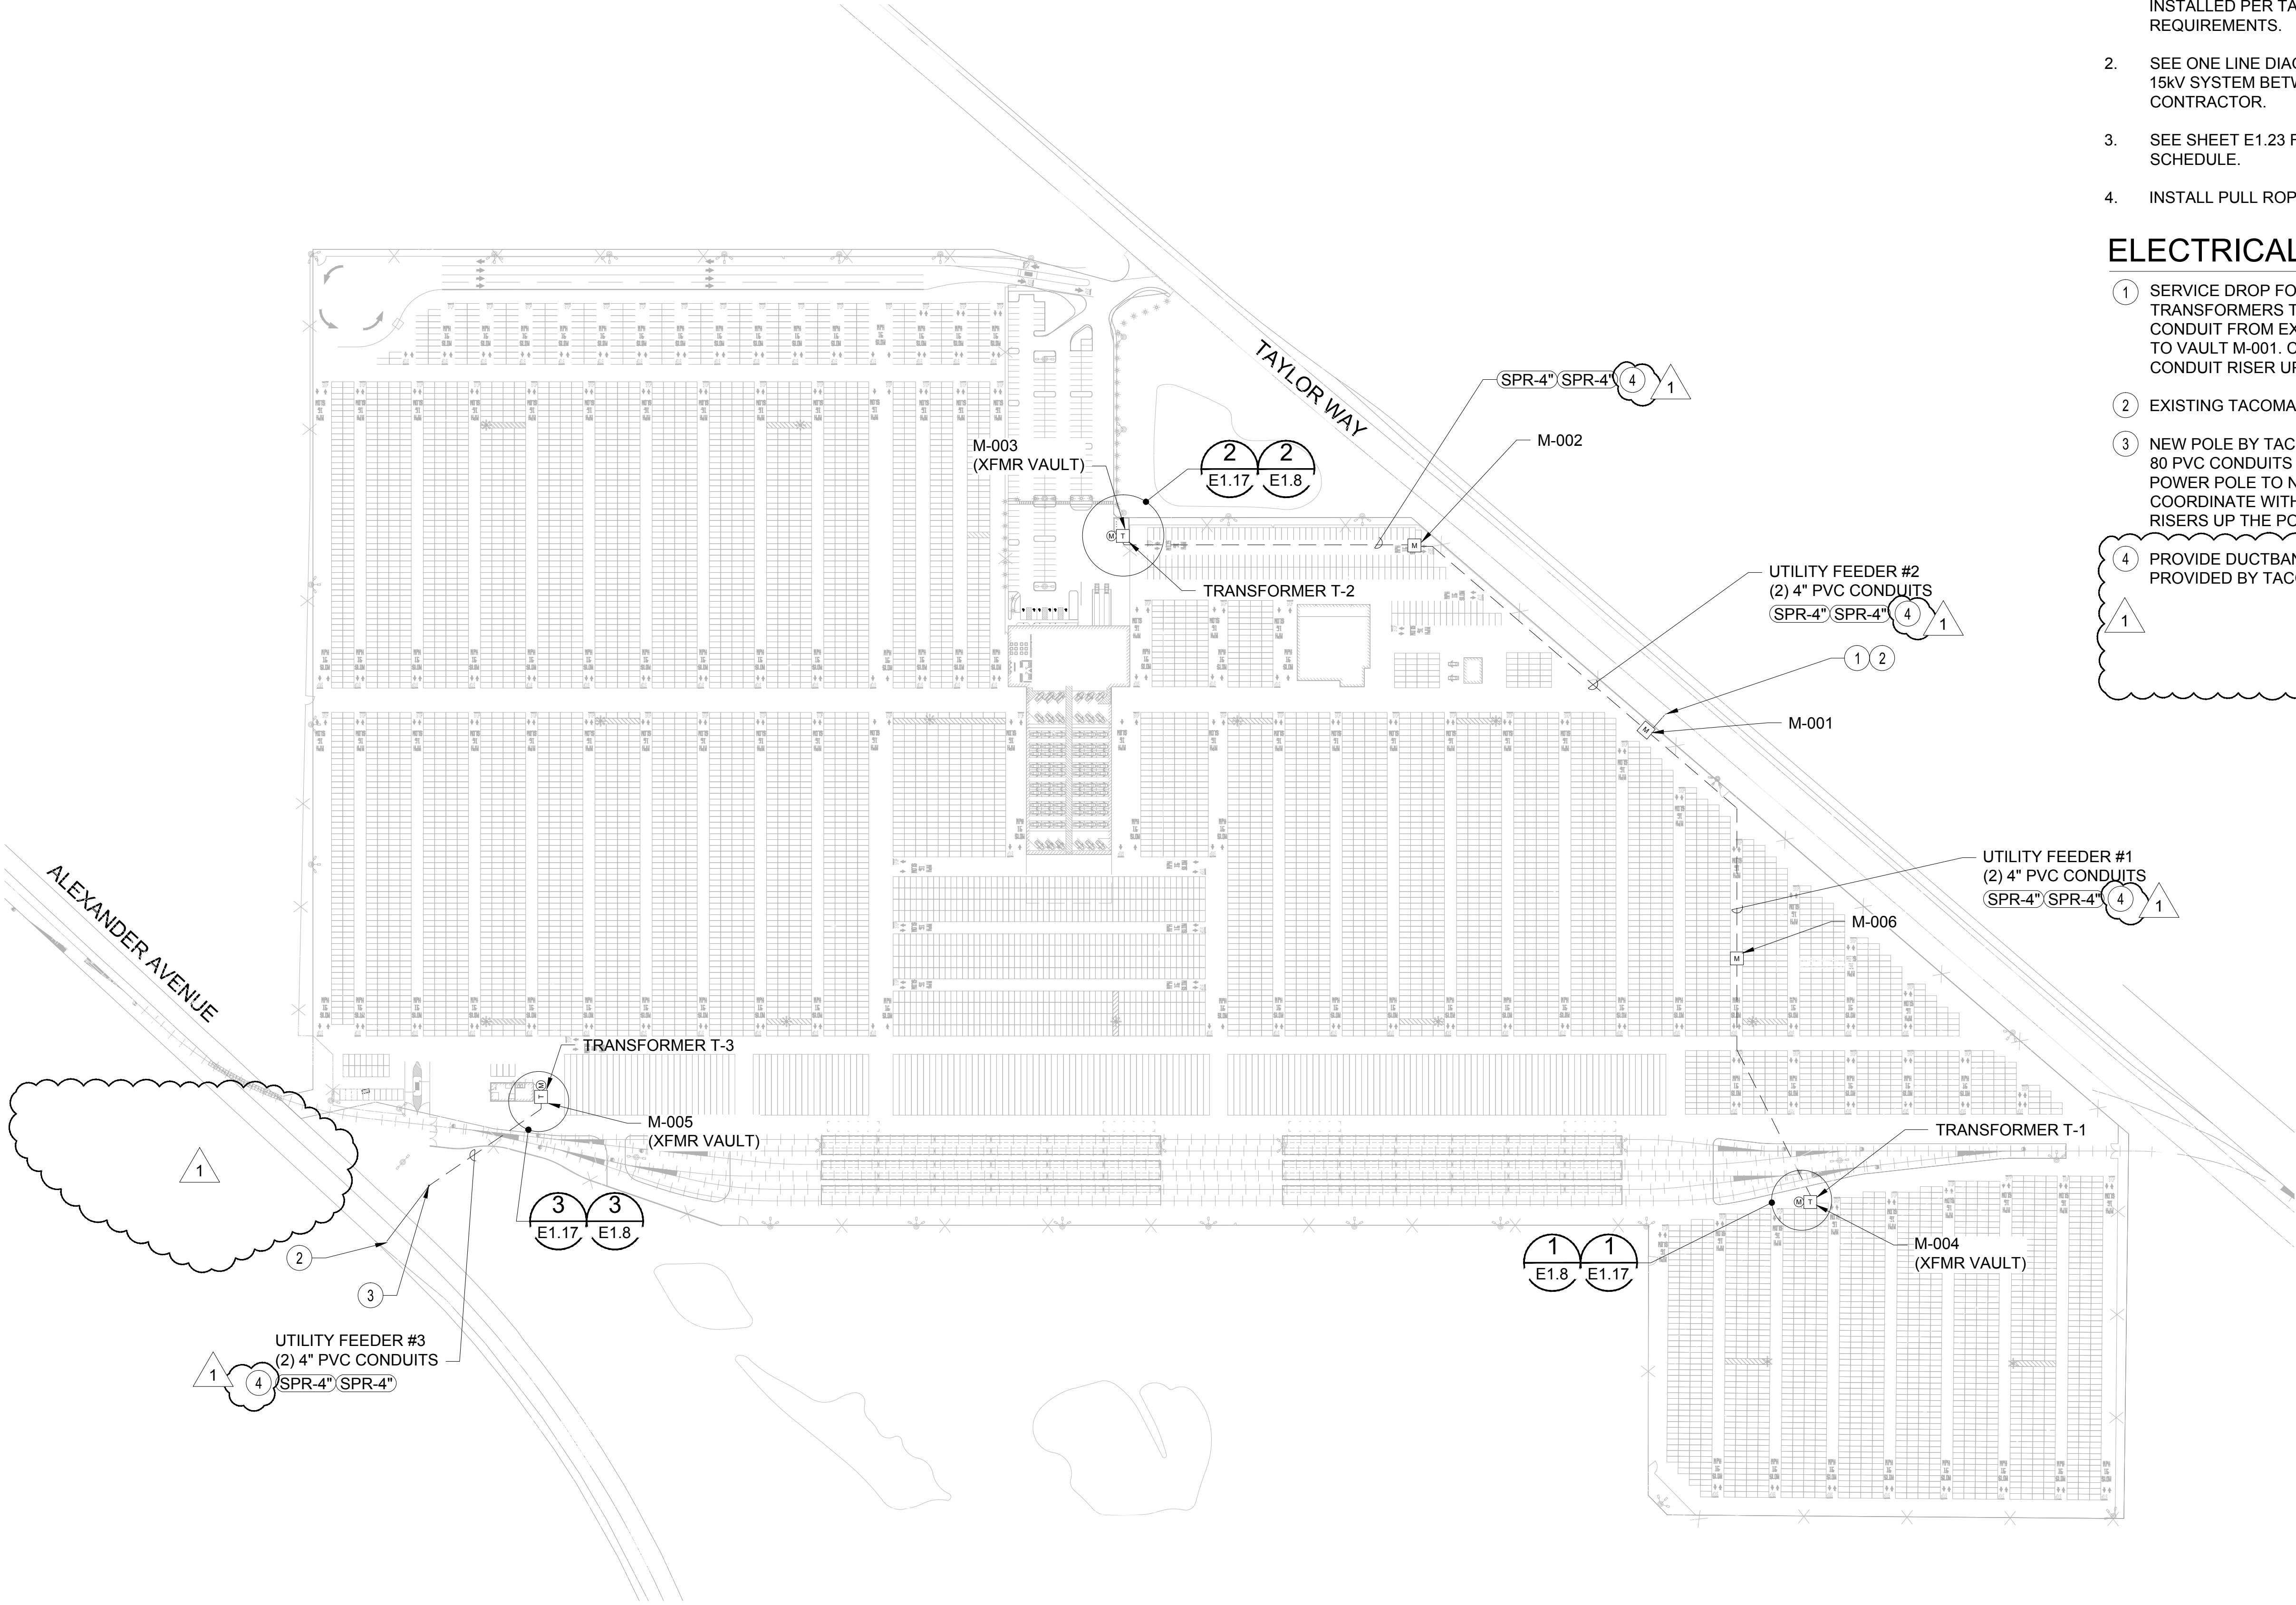

MATCH LINE SEE SHEET E1.2

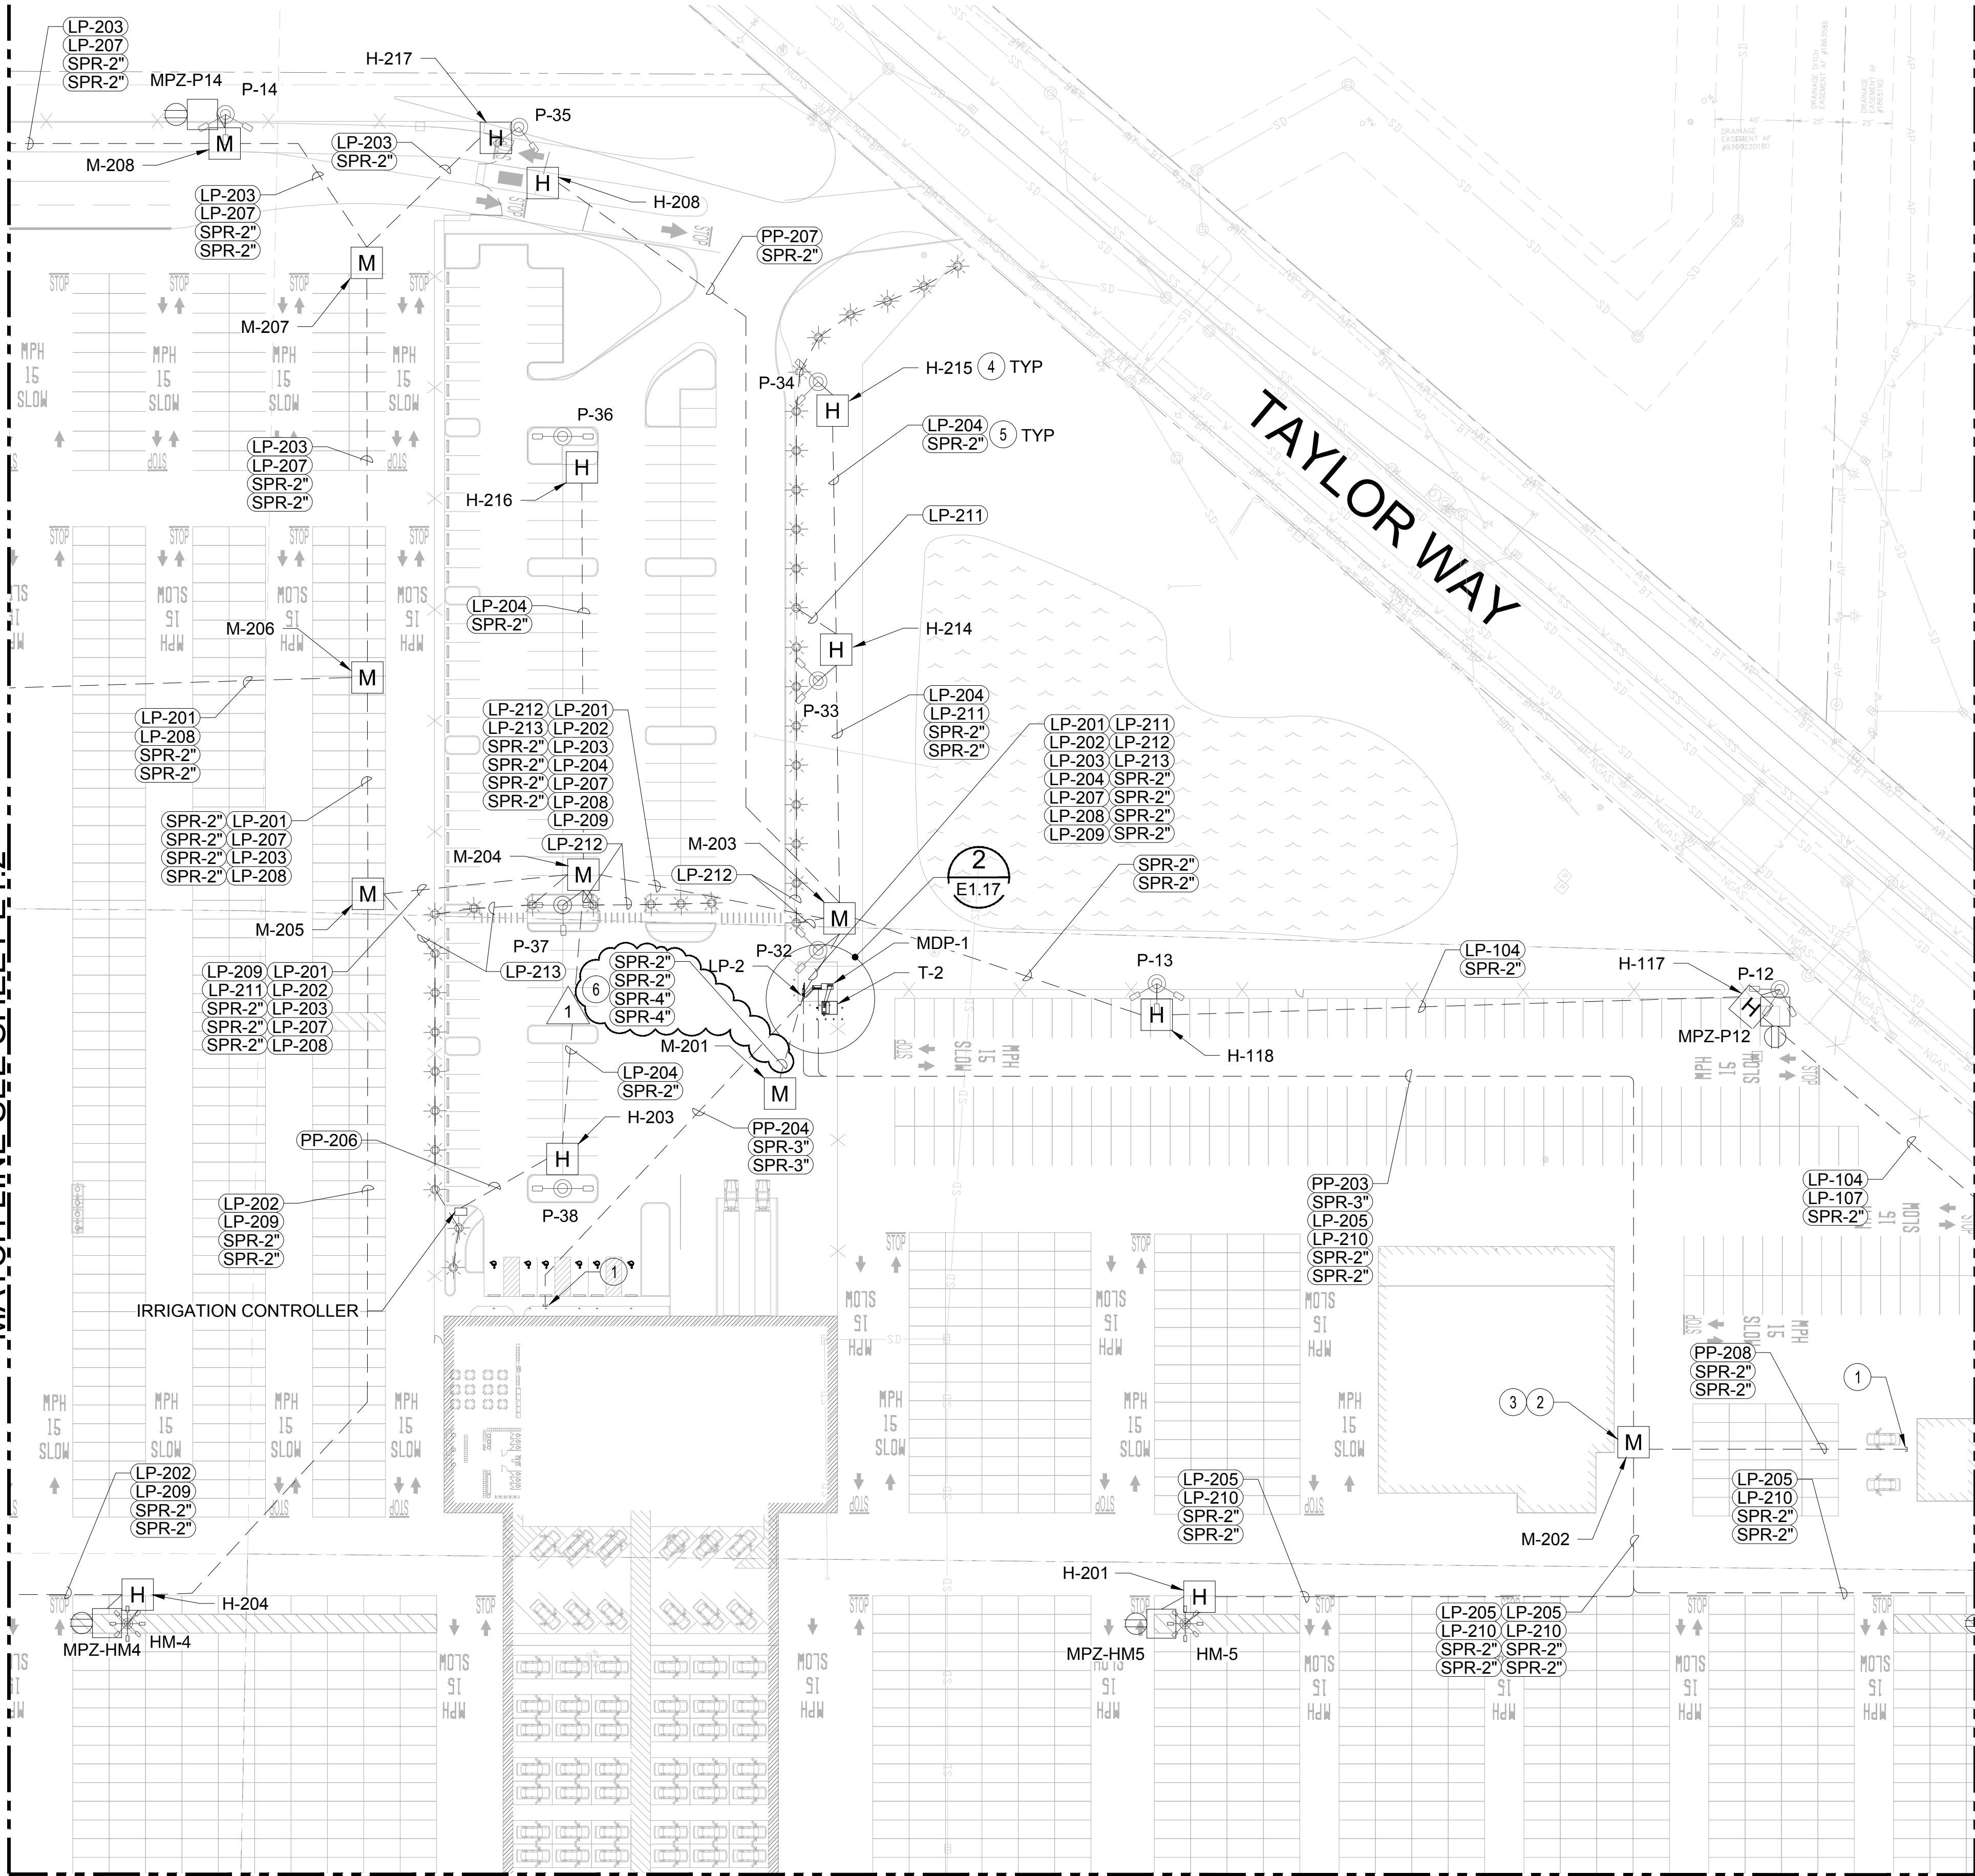

MATCH LINE SEE SHEET E1.5

MATCH LINE SEE SHEET E1.6


GENERAL NOTES

1. INCLUDE PULL ROPE IN ALL CONDUIT.
2. ALL CONDUIT BELOW GRADE SHALL BE SCHEDULE 80 PVC UNLESS OTHERWISE NOTED.
3. REFER TO SHEET E1.23 FOR CONDUIT AND CABLE SCHEDULE.
4. REFER TO CIVIL SHEETS U1.18-U1.24 FOR ALL VAULT, MANHOLE, AND POLE LOCATIONS.

ELECTRICAL NOTES

1. CAP CONDUIT 5' FROM BUILDING FOUNDATION.
2. INSTALL MANHOLE WITH WALL FACING BUILDING 5' FROM BUILDING FOUNDATION.
3. SPLICE HIGH MAST LIGHT CIRCUITS IN MANHOLE.
4. PROVIDE HANDHOLE AND POLE CONNECTION PER SHEET E1.18 DETAIL. TYPICAL ALL HANDHOLES THIS SHEET.
5. PROVIDE CONDUIT/DUCTBANK PER DUCTBANK DETAIL 2, SHEET E1.19. TYPICAL ALL DUCTBANKS THIS SHEET.
6. RUN 2 SPARE 2" CONDUITS TO LP-2. RUN 2 SPARE 4" CONDUITS TO MP-1.

N

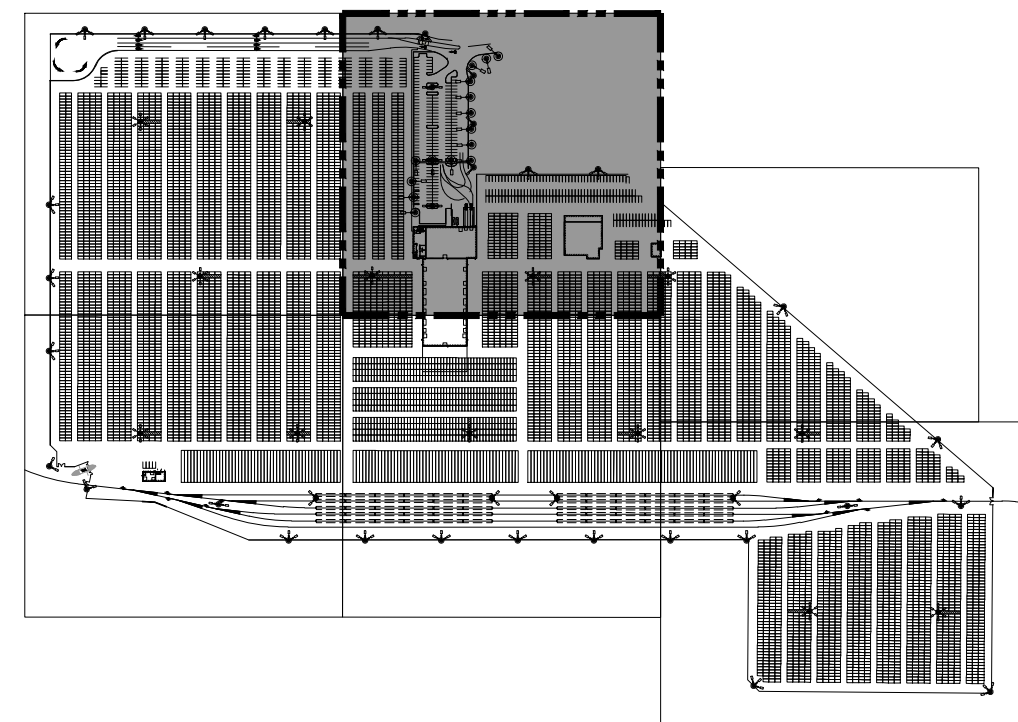

KEY PLAN
NTS

E1.3
-122 OF 163

PARCEL 77 AUTO IMPORT TERMINAL

ELECTRICAL LOW VOLTAGE POWER DISTRIBUTION PLAN
AREA 2

CONT./CONS:	070770	TOWNSHIP:	21N	RANGE:	3E	SECTION:	36
M. ID:	201020.01	DAT-HR:	W83-SF	VERT:	PORT OF TACOMA BM#		
PHASE:	PRELIMINARY	PARCEL:	MULTIPLE	DRAWING SCALE:	AS SHOWN		

APPROVED:	DCR	5/7/18
CHECKED BY:	DATE	
DKS	5/9/18	
DIRECTOR	ENG. DATE	PROJ. ENGR DATE
PRINTED BY:	jeff Jun 05, 2018	
PORT ADDRESS:	ONE SITCOM PLAZA	
	TACOMA WA 98401-1837	



MARK:	REVISION:	BY:	DATE:
1	ADDENDUM #4	J.T.	6/5/18

GENERAL NOTES


1. INCLUDE PULL ROPE IN ALL CONDUIT.

2. ALL CONDUIT BELOW GRADE SHALL BE SCHEDULE 80 PVC UNLESS OTHERWISE NOTEDL.

3. REFER TO SHEET E1.23 FOR CONDUIT AND CABLE SCHEDULE.
4. REFER TO TACOMA POWER STANDARDS FOR MEDIUM VOLTAGE INSTALLATIONS.

5. SEE ONE LINE DIAGRAM E1.16 FOR CONDUIT AND WIRE SIZES TO THIS EQUIPMENT.

6. SEE SHEET E1.8 FOR GROUNDING DETAILS..

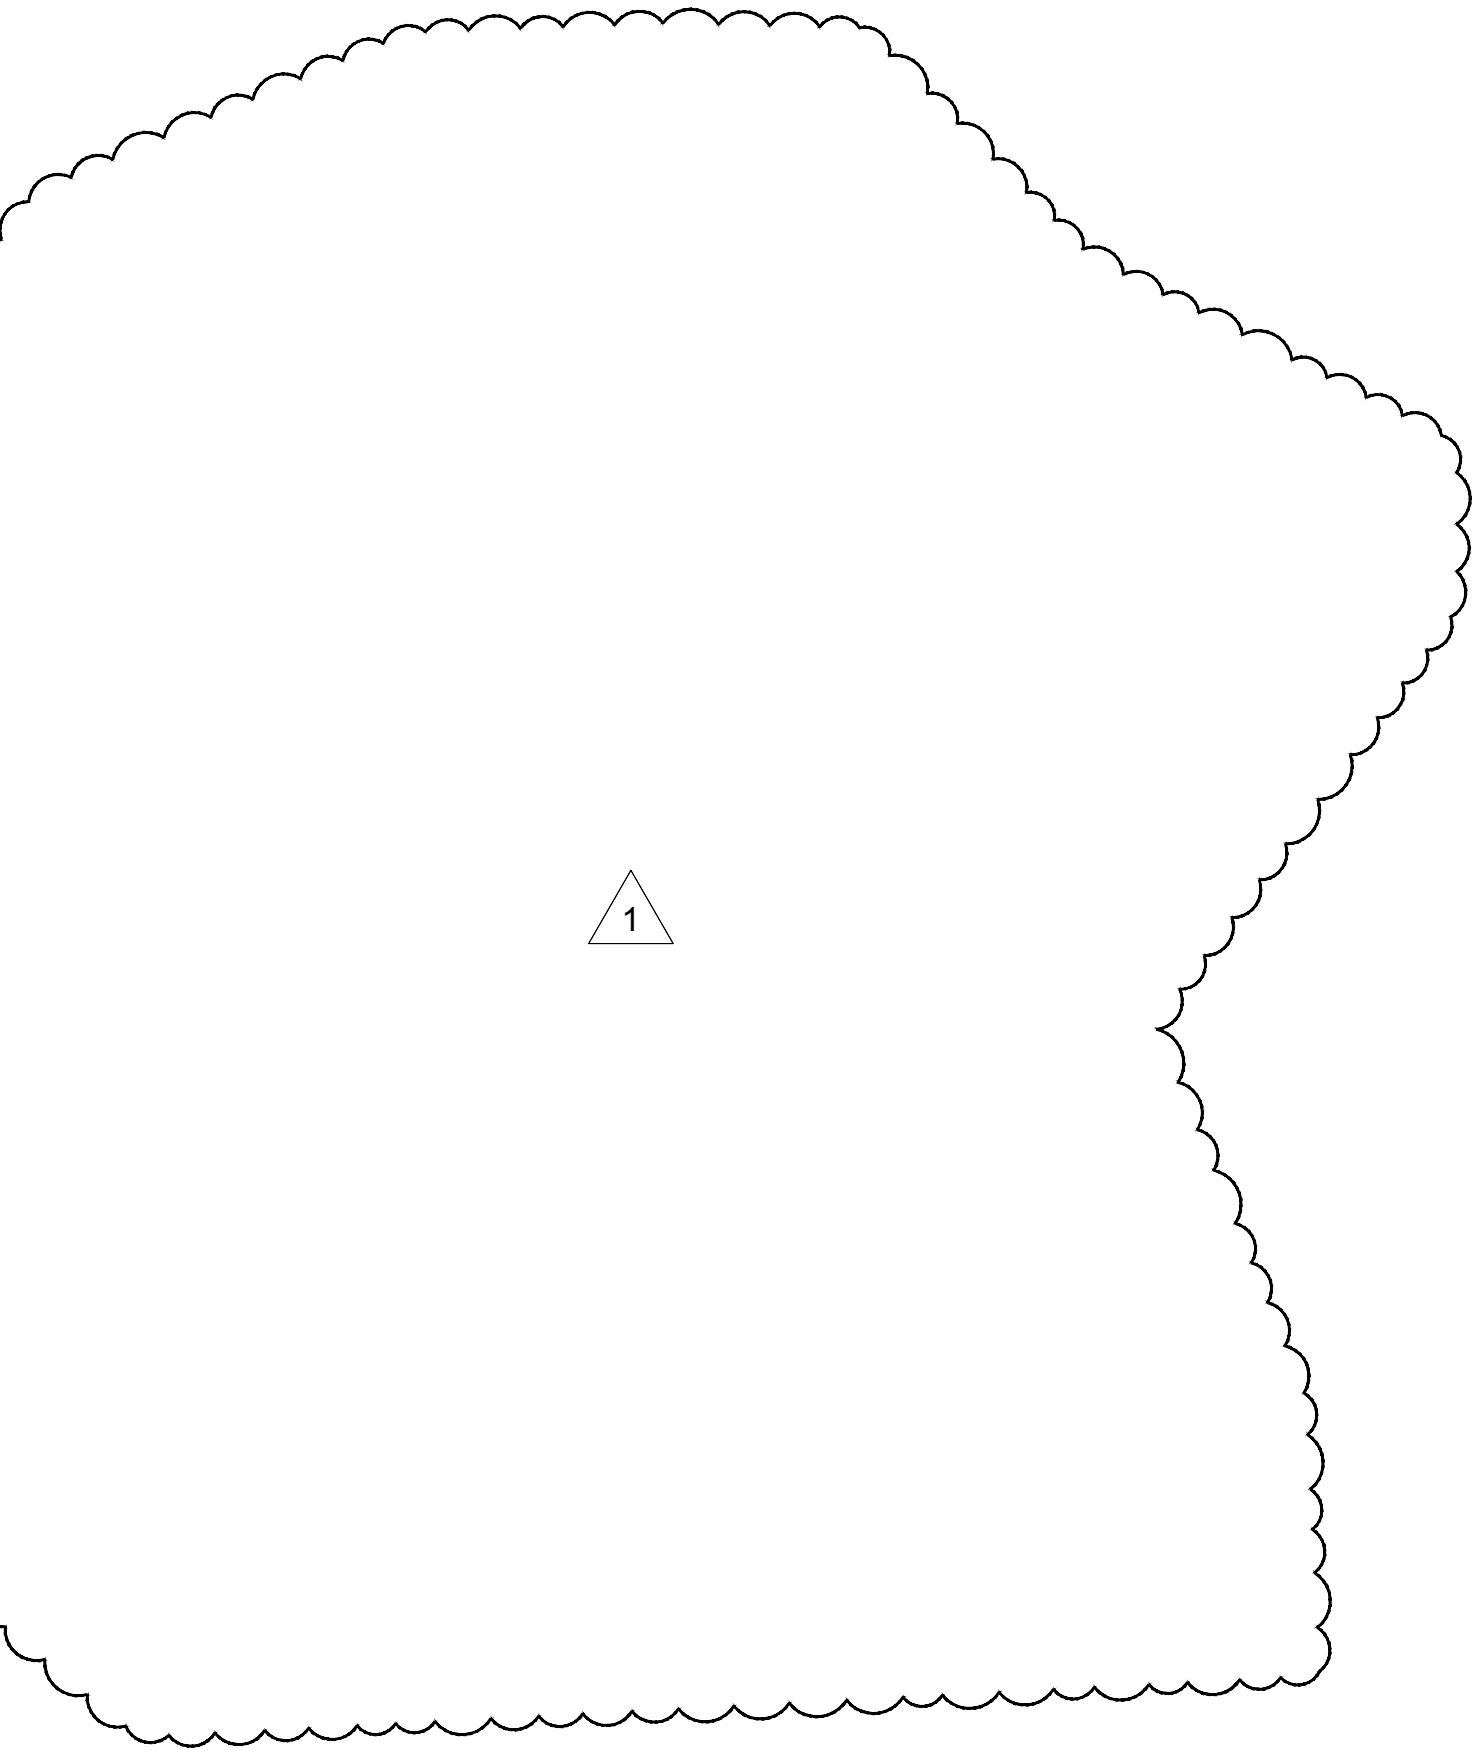

ELECTRICAL NOTES




1. REFER TO CIVIL DRAWINGS FOR BOLLARD DETAILS.

2. REFER TO CIVIL DRAWINGS FOR BOLLARD SPACING AND LOCATIONS PER TACOMA POWER STANDARDS.


3. TRANSFORMER PROVIDED AND INSTALLED BY TACOMA POWER.

4. TRANSFORMER VAULT PROVIDED AND INSTALLED BY CONTRACTOR PER TACOMA POWER SERVICE STANDARDS.


5. TACOMA POWER FEEDER CABLES PROVIDED AND INSTALLED BY TACOMA POWER. CONDUIT PROVIDED AND INSTALLED BY CONTRACTOR.

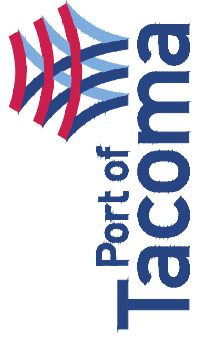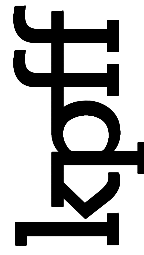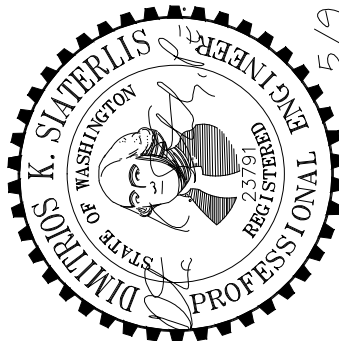 2407 North 31st Street, Suite 100 Tacoma, Washington 98407 (253) 396-0150 Fax (253) 396-0162 P.O. BOX 1837 TACOMA, WA 98401 (253)396-5441		2407 North 31st Street, Suite 100 Tacoma, Washington 98407 (253) 396-0150 Fax (253) 396-0162 P.O. BOX 1837 TACOMA, WA 98401 (253)396-5441		DATE: 6/5/18
		BY: J.T.	APPR:	
		REVISION: 1	ADDENDUM #4	
DCR 5/7/18		CHECKED BY: DKS	DATE: 5/9/18	
APPROVED:		DIRECTOR ENG. DATE: Jeff Jun 05, 2018	PROJ. ENGR DATE:	
		PRINTED BY:	PORT ADDRESS: ONE SITCUM PLAZA	
			TACOMA WA 98401-1837	
PARCEL 77 AUTO IMPORT TERMINAL		ELECTRICAL DETAILS SERVICE POINT PLANS		
E1.17 136 OF 163		TOWNSHIP: 21N	SECTION: 36	
CONT./CONS: 070770		RANGE: 3E	PORT OF TACOMA BM#	
M. ID: 201020.01		DAT-HRZ: W83-SF	VERT:	
PHASE: PRELIMINARY		PARCEL: MULTIPLE	DRAWING SCALE: AS SHOWN	

THIS DRAWING IS THE PROPERTY OF THE PORT OF TACOMA AND SHALL NOT BE USED ON OTHER WORK, DISCLOSED, COPIED, IN WHOLE OR IN PART, WITHOUT WRITTEN PERMISSION


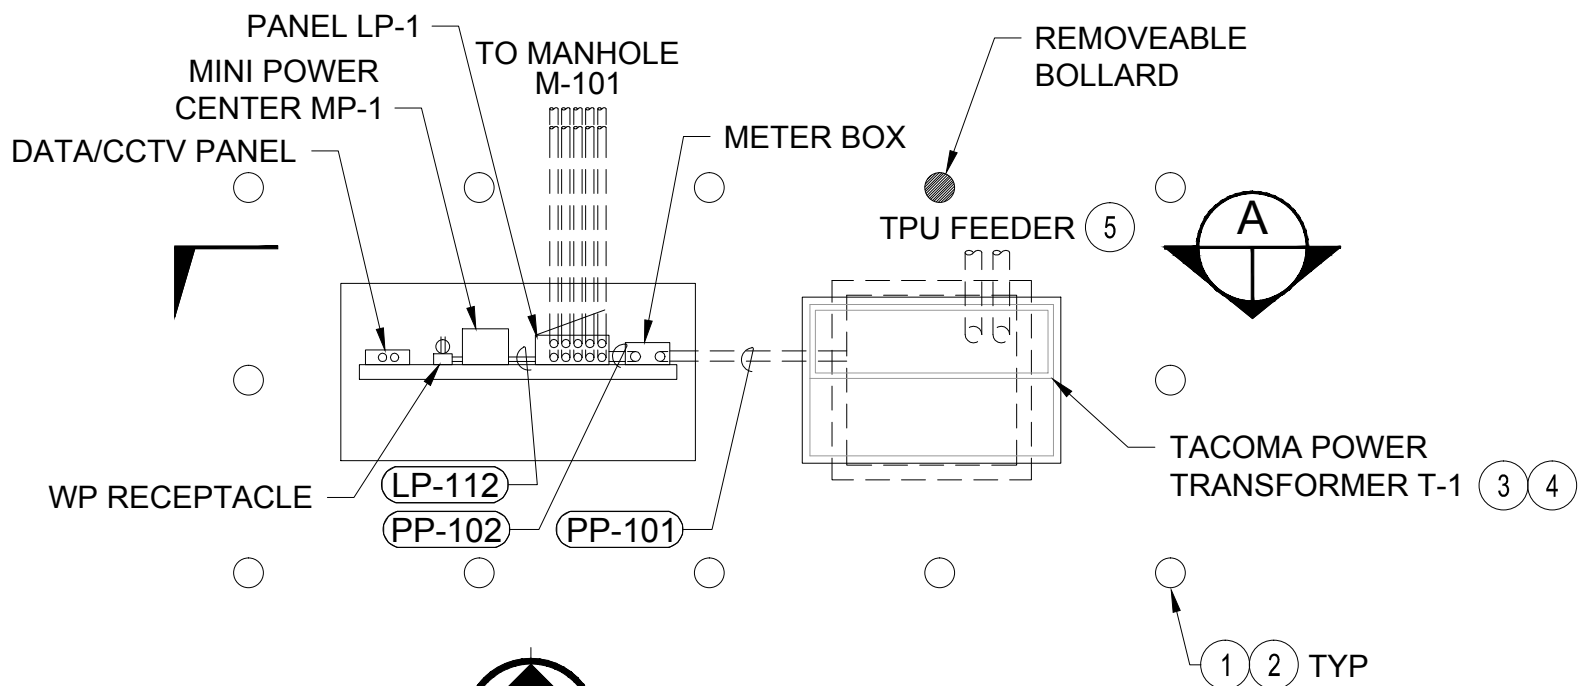


PLAN VIEW

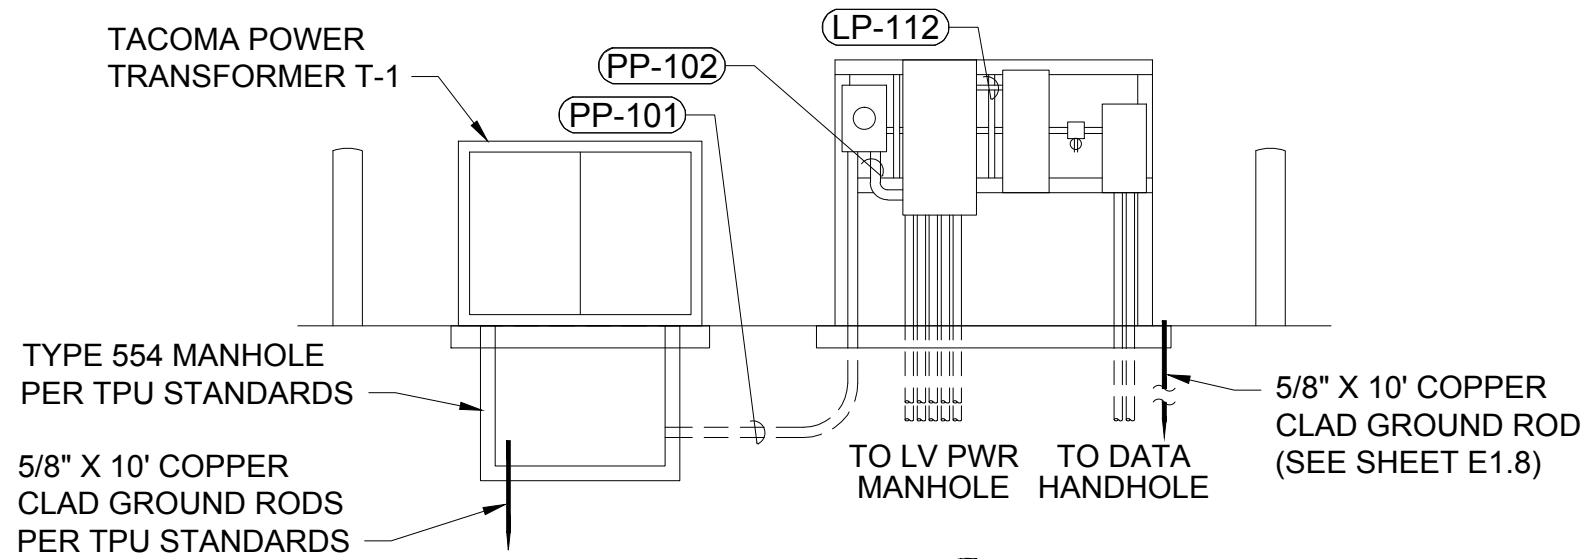


ELEVATION A

 1 DETAIL - ELECTRICAL SERVICE #1
E1.1,E1.7 SCALE: 1/4"=1'-0"

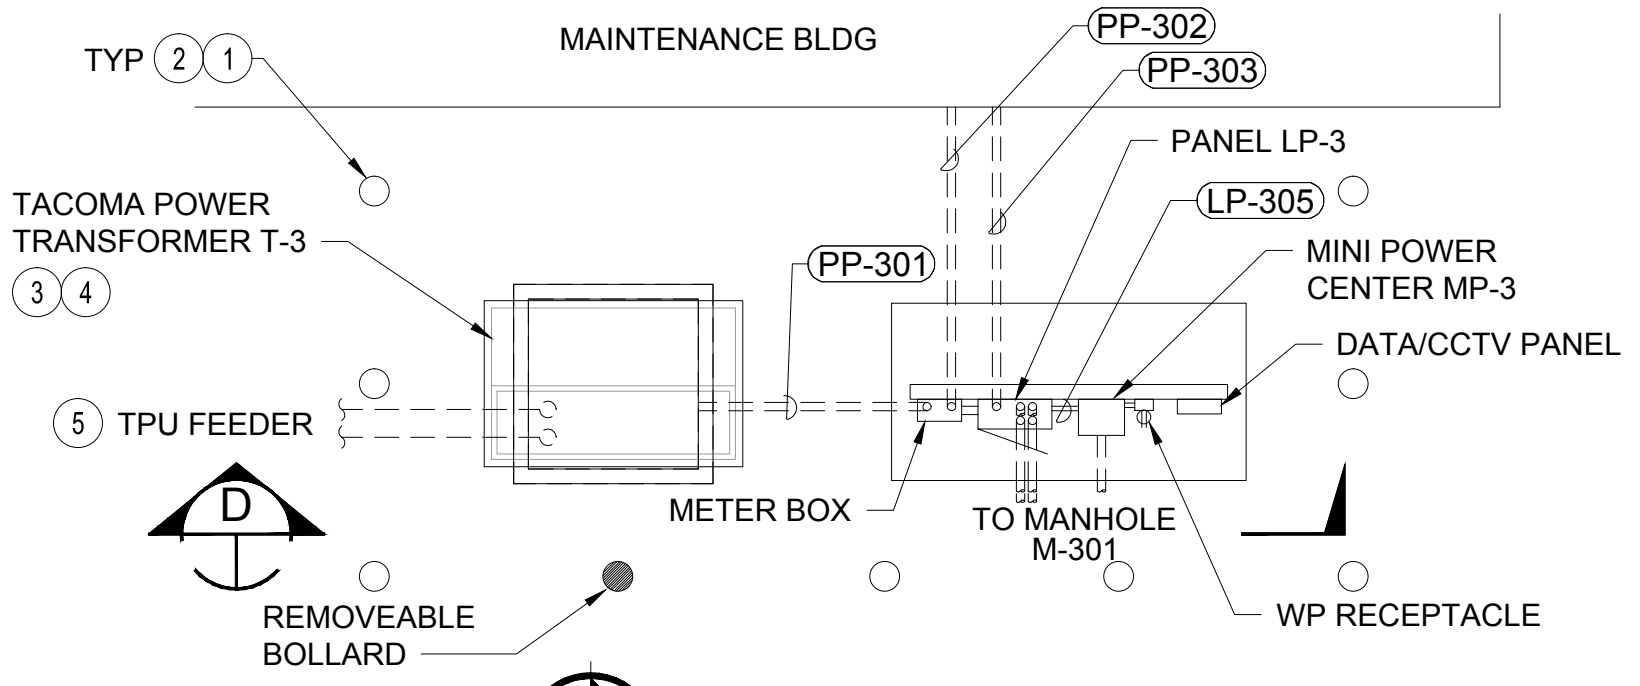



PLAN VIEW

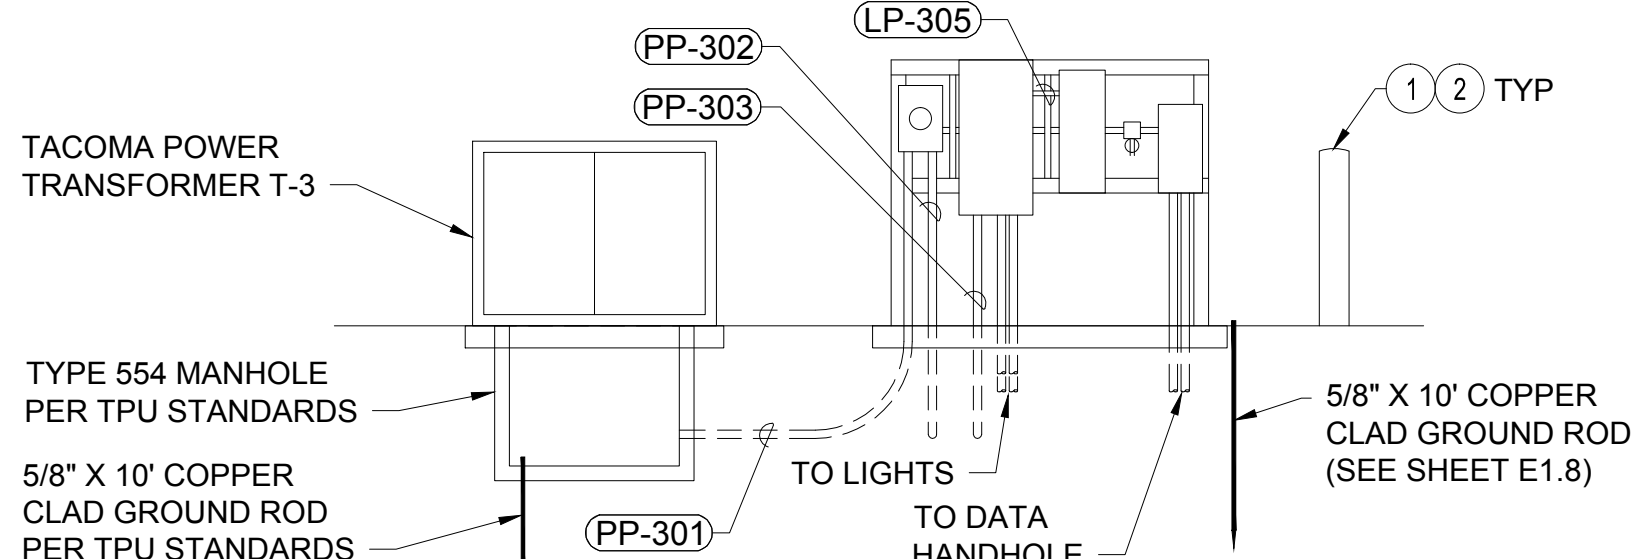


ELEVATION C

 3 DETAIL - ELECTRICAL SERVICE #3
E1.1,E1.4 SCALE: 1/4"=1'-0"

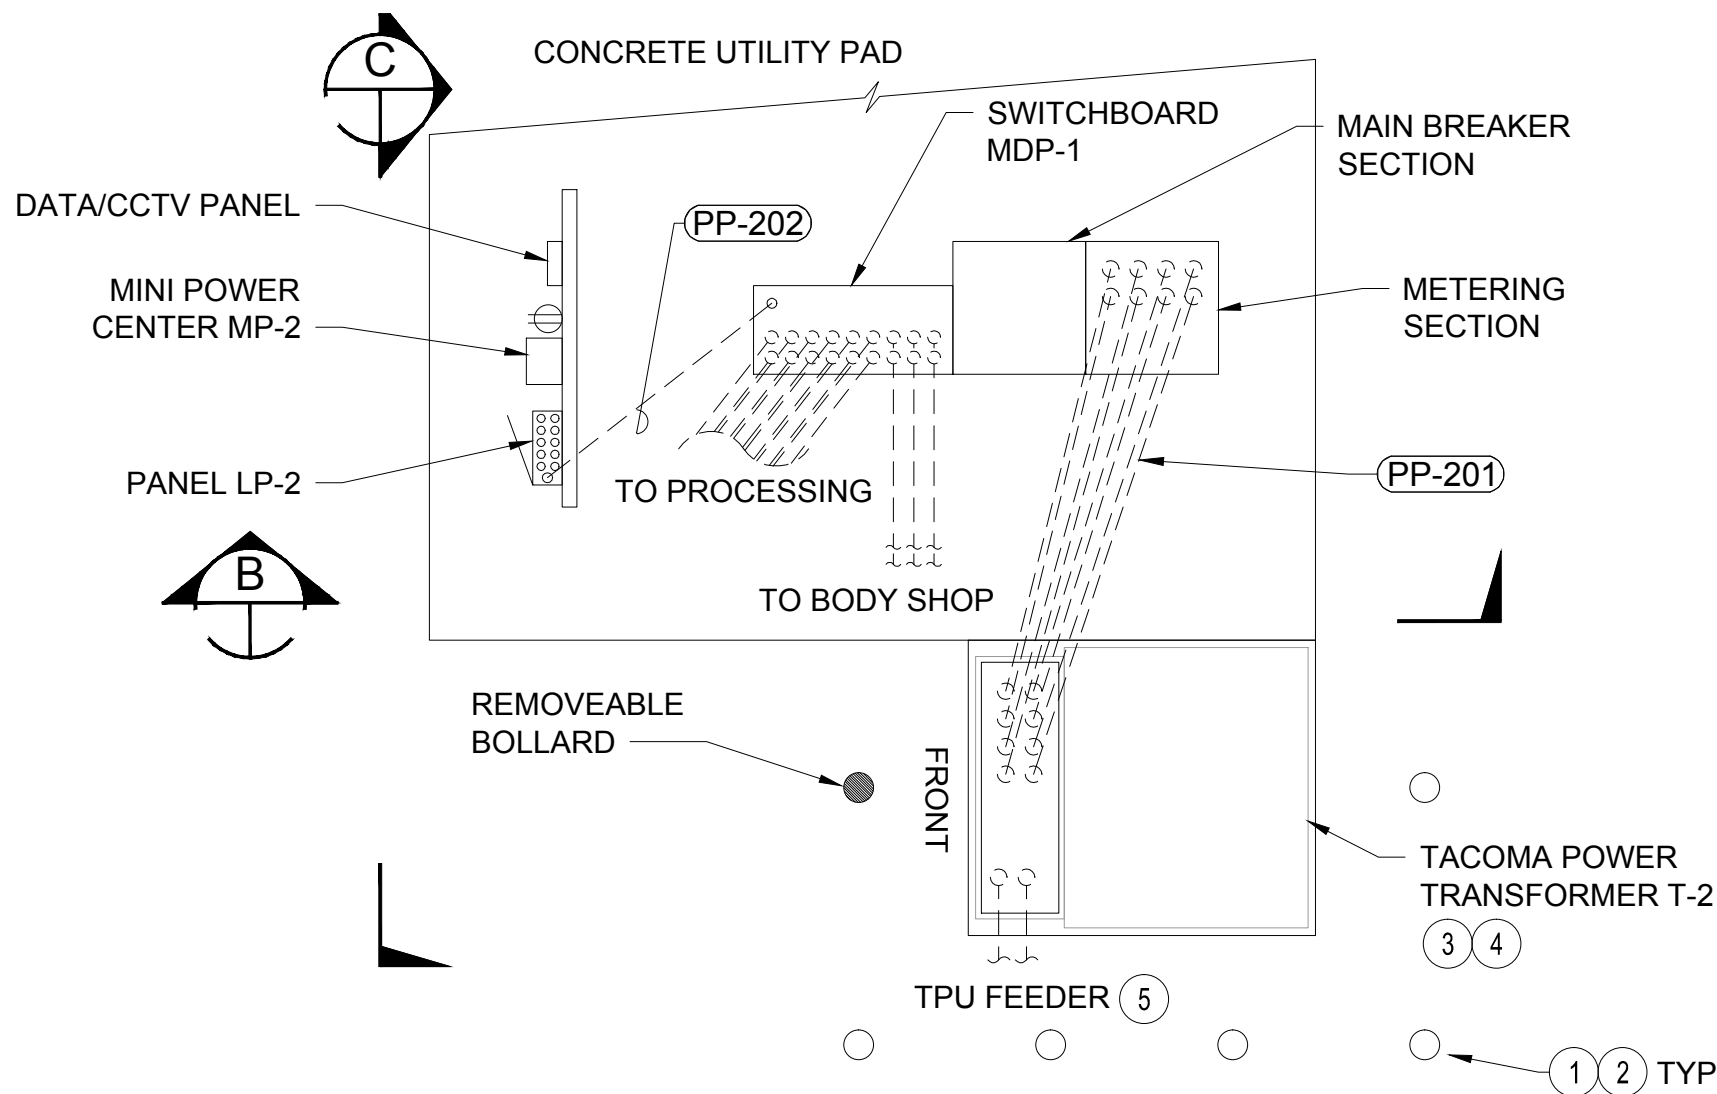


PLAN VIEW

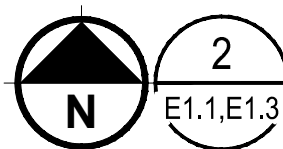


2


DETAIL - ELECTRICAL SERVICE #2
E1.1,E1.3 SCALE: 1/4"=1'-0"

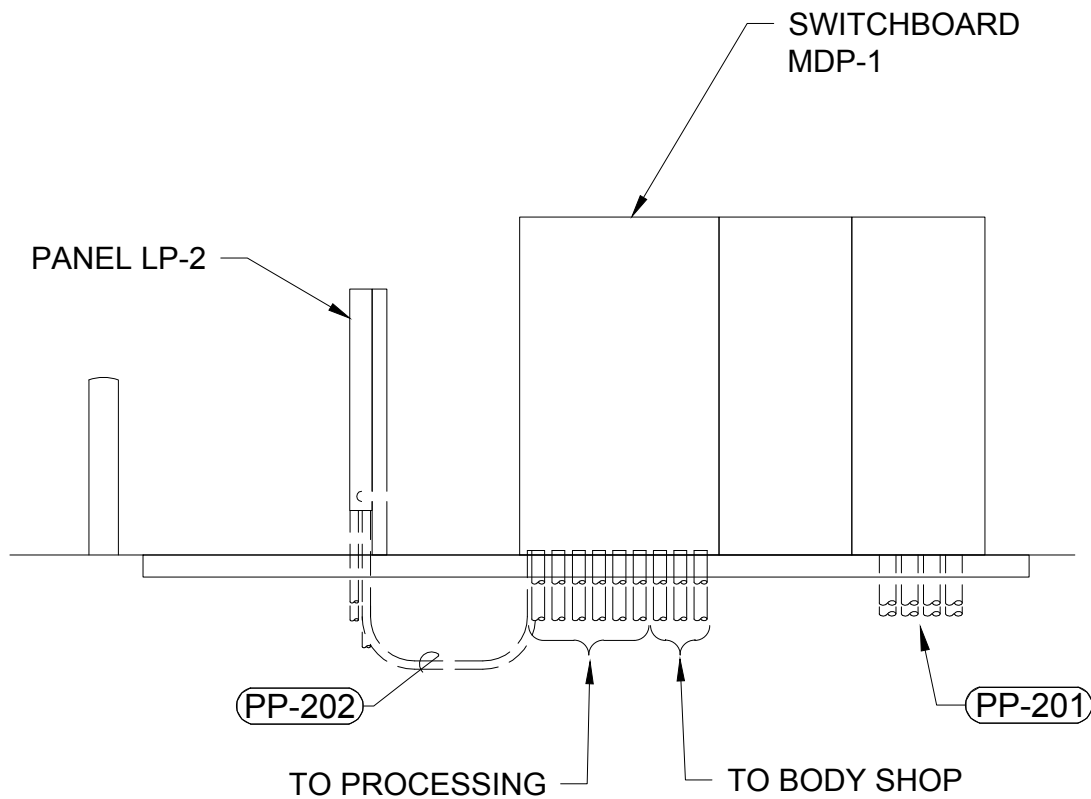

ELEVATION B

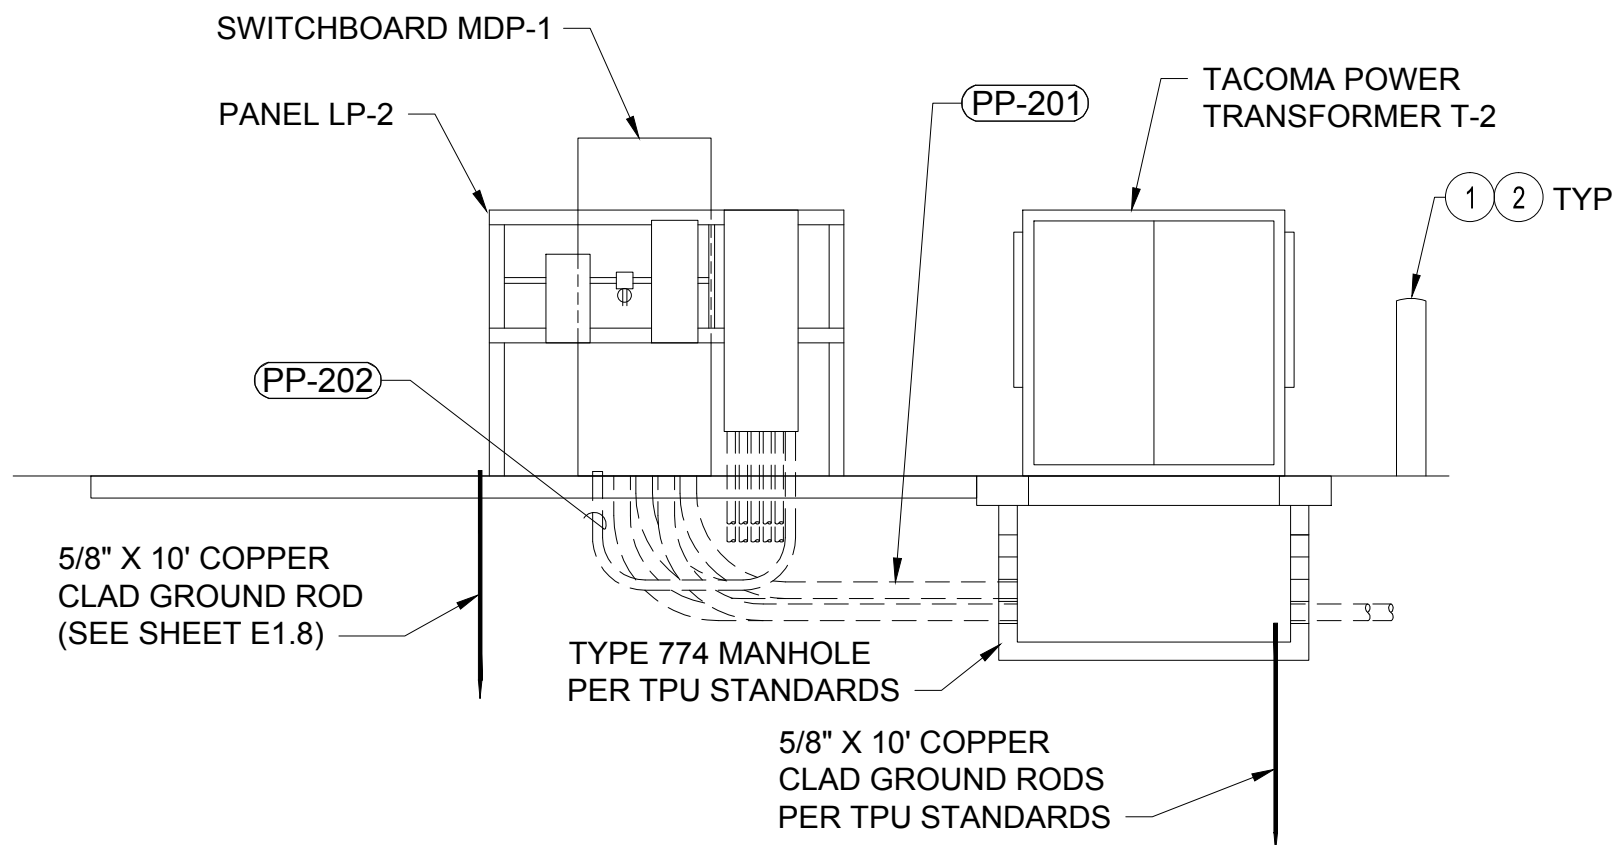

ELEVATION C

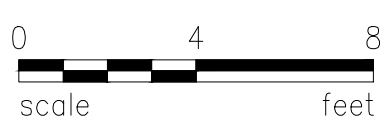

PANELBOARD LP-1				225 A BUS		SECTIONS: 1				RACK MOUNTED	
480/ 277V 3 PHASE 4 WIRE				200 A MCB		LUGS: SINGLE				NEMA: 4X	
LOCATION:				22k AIC		FEED: BOTTOM				NUMBER OF POLES: 42	
CKT	TYPE	SERVES	C.B.	KVA	CONNECTED PHASE LOAD KVA	C.B.	SERVES	TYPE	CKT		
1		SPARE	20 / 3		5.0	15.00	30 / 3	HM-9,-10,-11	LI	2	
3			---		5.0		---	HIGH MAST LIGHTS		4	
5			---		5.0		---			6	
7	LI	HM-12,-13	20 / 3	10.00	5.3	5.80	20 / 3	P-1,-2,-3,-4,-5,-6,-7,-8,-9	LI	8	
9		HIGH MAST LIGHTS	---		5.3		---	SITE LIGHTING		10	
11			---		5.3		---			12	
13	LI	P-10,-11,-12,-13,-31	20 / 3	3.20	1.9	2.60	20 / 3	P-25,-26,-27,-28,-29,-30	LI	14	
15		SITE LIGHTING	---		1.9		---	SITE LIGHTING		16	
17			---		1.9		---			18	
19		SPARE	20 / 3		1.9	5.80	25 / 3	HM-9,-10,-11 POLE MTD RCPT	SF	20	
21			---		1.9		---	MINI PWR ZONES, 3@5kVA		22	
23			---		1.9		---	480V-120/240V, 1PH		24	
25	SF	P-10,-12 POLE MTD RCPT	20 / 3	3.80	2.5	3.80	20 / 3	HM-12,-13 POLE MTD RCPT	SF	26	
27		MINI PWR ZONES, 2@5kVA	---		2.5		---	MINI PWR ZONES, 2@5kVA		28	
29		480V-120/240V, 1PH	---		2.5		---	480V-120/240V, 1PH		30	
31	SF	P-4,-8,-9 POLE MTD RCPT	25 / 3	5.70	3.4	3.00	20 / 2	MINI PWR ZONE, 3kVA	SF	32	
33		MINI PWR ZONES, 3@5kVA	---		3.4		---	(SUBSTATION)		34	
35		480V-120/240V, 1PH	---		2.0	0.18	20 / 2	MINI PWR ZONE, 5kVA	SF	36	
37					0.1		---	(HOTBOX HEATERS)		38	
39					0.1	0.18	20 / 2	MINI PWR ZONE, 5kVA	SF	40	
41					0.1		---	(HOTBOX HEATERS)		42	
9		(21.4%) SPARES/SPACES			20.2	20.2	18.7	CALCULATED LOAD		68.2 KVA	
					4.8%	IMBALANCE		MAXIMUM AMPS PER PHASE		83.8 AMPS	

PANELBOARD LP-3				225 A	BUS				SECTIONS: 1				RACK MOUNTED			
480/ 277V 3 PHASE 4 WIRE				100 A	MCB				LUGS: SINGLE				NEMA: 4X			
LOCATION: SW CORNER				22k	AIC				FEED: BOTTOM				NUMBER OF POLES: 30			
CKT	TYPE	SERVES			C.B.	KVA CONNECTED			PHASE LOAD	KVA	C.B.	SERVES			TYPE	CKT
1	LI	HM-7,-8			20 / 3	10.00	4.4		3.23	20 / 3	P-20,-21,-22,-23,-24,-39			LI	2	
3		HIGH MAST LIGHTS			---		4.4			---	SITE LIGHTING				4	
5					---		4.4			---					6	
7	SF	HM-7,-8 POLE MTD RCPT			20 / 3	3.80	1.9		1.90	20 / 3	P-23 POLE MTD RCPT			SF	8	
9		MINI PWR ZONES, 2@5kVA			---		1.9			---	MINI PWR ZONE, 5kVA				10	
11		480V-120/240V, 1PH			---		1.9			---	480V-120/240V, 1PH				12	
13	SF	MINI POWER ZONE, 3kVA			20 / 2	3.00	1.5								14	
15		(SUBSTATION)			---		1.5								16	
17							0.0								18	
19							0.0								20	
21							0.0								22	
23							0.0								24	
25							0.0								26	
27							0.0								28	
29							0.0								30	
16 (53.3%) SPARES/SPACES				7.8 7.8 6.3				CALCULATED LOAD				25.2 KVA				
				13.7% IMBALANCE				MAXIMUM AMPS PER PHASE				32.2 AMPS				

PANELBOARD LP-2				225 A BUS		SECTIONS: 1				RACK MOUNTED	
480/ 277V 3 PHASE 4 WIRE				200 A MCB		LUGS: SINGLE				NEMA: 4X	
LOCATION: CENTRAL COMPLEX				22k AIC		FEED: BOTTOM				NUMBER OF POLES: 42	
CKT	TYPE	SERVES	C.B.	KVA	CONNECTED PHASE LOAD KVA		C.B.	SERVES	TYPE	CKT	
1	LI	HM-1,-2	20 / 3	10.00	6.7		10.00	20 / 3	HM-3,-4	LI	2
3		HIGH MAST LIGHTS	---		6.7			---	HIGH MAST LIGHTS		4
5			---		6.7			---			6
7	LI	P-14,-15,-16,-17,-18,-19,-35	20 / 3	4.30	2.3		2.60	20 / 3	P-32,-33,-34,-36,-37,-38	LI	8
9		SITE LIGHTING	---		2.3			---	SITE LIGHTING		10
11			---		2.3			---			12
13	LI	HM-5,-6	20 / 3	10.00	5.6		6.82	50 / 3	GUARD HOUSE (NE)	SF	14
15		HIGH MAST LIGHTS	---		5.6			---	TRANSFORMER 30KVA		16
17			---		5.6			---			18
19	SF	P-14,-19 POLE MTD RCPT	20 / 3	3.80	2.5		3.80	20 / 3	HM-1,-2 POLE MTD RCPT	SF	20
21		MINI PWR ZONES, 2@5kVA	---		2.5			---	MINI PWR ZONES, 2@5kVA		22
23		480V-120/240V, 1PH	---		2.5			---	480V-120/240V, 1PH		24
25	SF	HM-3,-4 POLE MTD RCPT	20 / 3	3.80	2.5		3.80	20 / 3	HM-5,-6 POLE MTD RCPT	SF	26
27		MINI PWR ZONES, 2@5kVA	---		2.5			---	MINI PWR ZONES, 2@5kVA		28
29		480V-120/240V, 1PH	---		2.5			---	480V-120/240V, 1PH		30
31	SF	MINI PWR ZONE, 3kVA	20 / 2	3.00	1.5						32
33		(SUBSTATION)	---		1.5						34
35	LI	PEDESTRIAN LIGHTS	20 / 1	0.47	0.5						36
37	LI	PEDESTRIAN LIGHTS	20 / 1	0.47	0.5						38
39	LI	PEDESTRIAN LIGHTS	20 / 1	0.47	0.5						40
41					0.0						42
7 (16.7%) SPARES/SPACES					21.6	21.6	20.1	CALCULATED LOAD			72.9 KVA
					4.7% IMBALANCE		MAXIMUM AMPS PER PHASE			89.5 AMPS	



E1.22 141 OF 163		PARCEL 77 AUTO IMPORT TERMINAL				APPROVED:		DCR 5/7/18		 5/9/18	2407 North 31st Street, Suite 100 Tacoma, Washington 98407 (253) 396-0150 Fax (253) 396-0162 P.O. BOX 1837 TACOMA, WA 98401 (253)393-6461
ELECTRICAL						CHECKED BY DATE		MARK: REVISION: BY: DATE:			
PANEL SCHEDULES						DKS 5/9/18					
RANGE: 3E		SECTION: 36				PROJ. ENGR DATE					
TOWNSHIP: 21N		DATE-HRZ: W83-SF				PRINTED BY: jeff Jun 05, 2018					
M. ID: 201020.01		VERT: PORT OF TACOMA BM#		DRAWING SCALE: AS SHOWN		PORT ADDRESS: ONE SITCUM PLAZA		TACOMA WA, 98401-1837			
PHASE: PRELIMINARY		PARCEL: MULTIPLE									