


NIM TOWER FOURTH FLOOR RENOVATIONS

Project No. 101247.02
Contract No. 070929

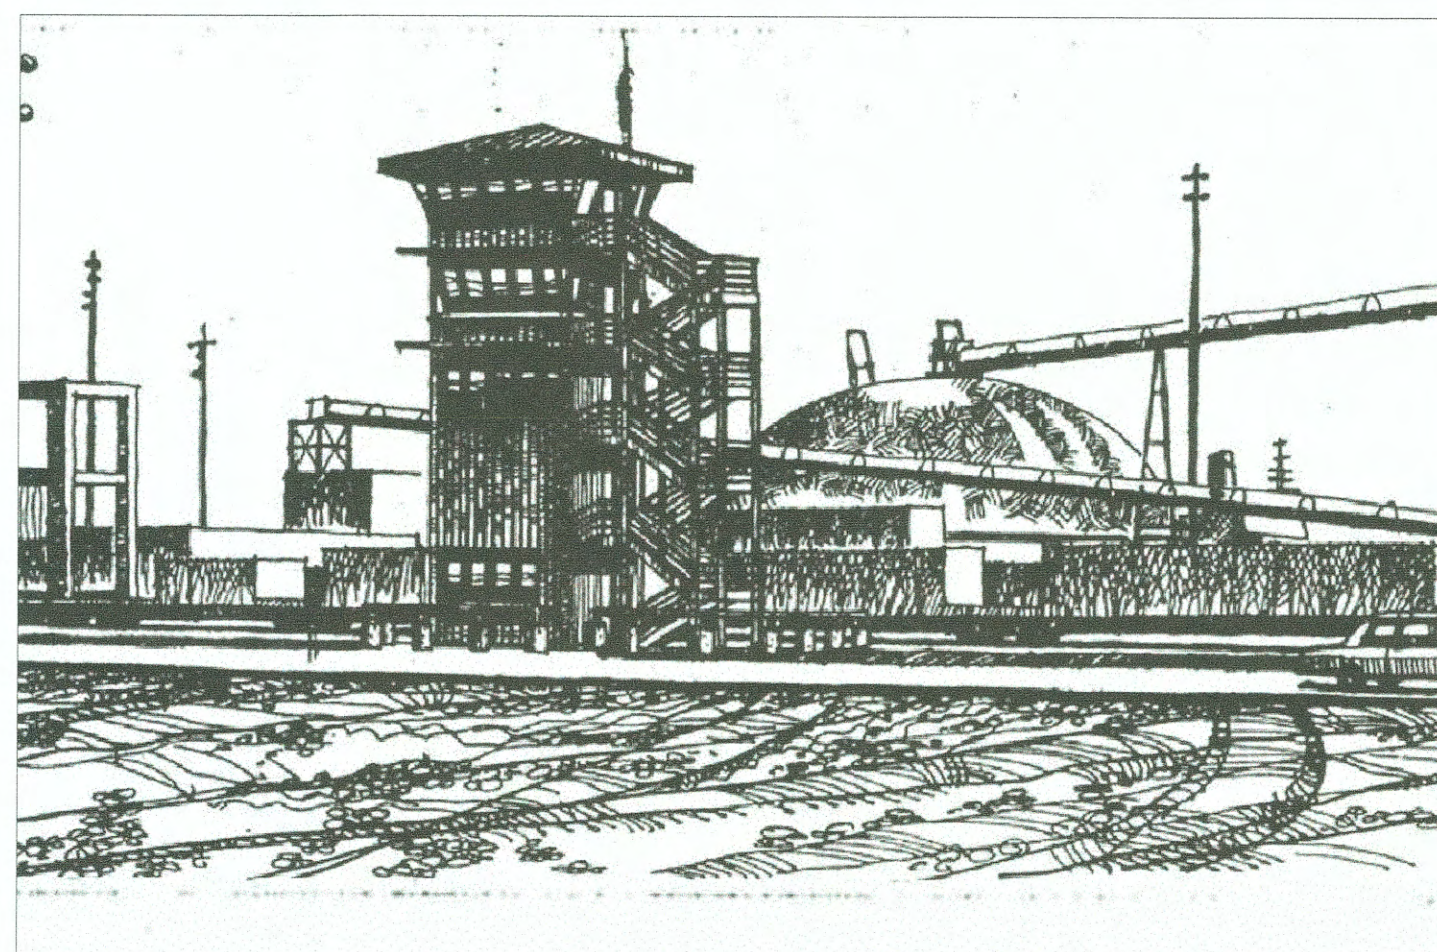

PORT COMMISSIONERS:


JOHN McCARTHY
DON MEYER

DONALD C. JOHNSON
RICHARD P. MARZANO
CLARE PETRICH

PORT STAFF:

JOHN WOLFE
Chief Executive Officer

DAKOTA CHAMBERLAIN
Director of Facilities Development

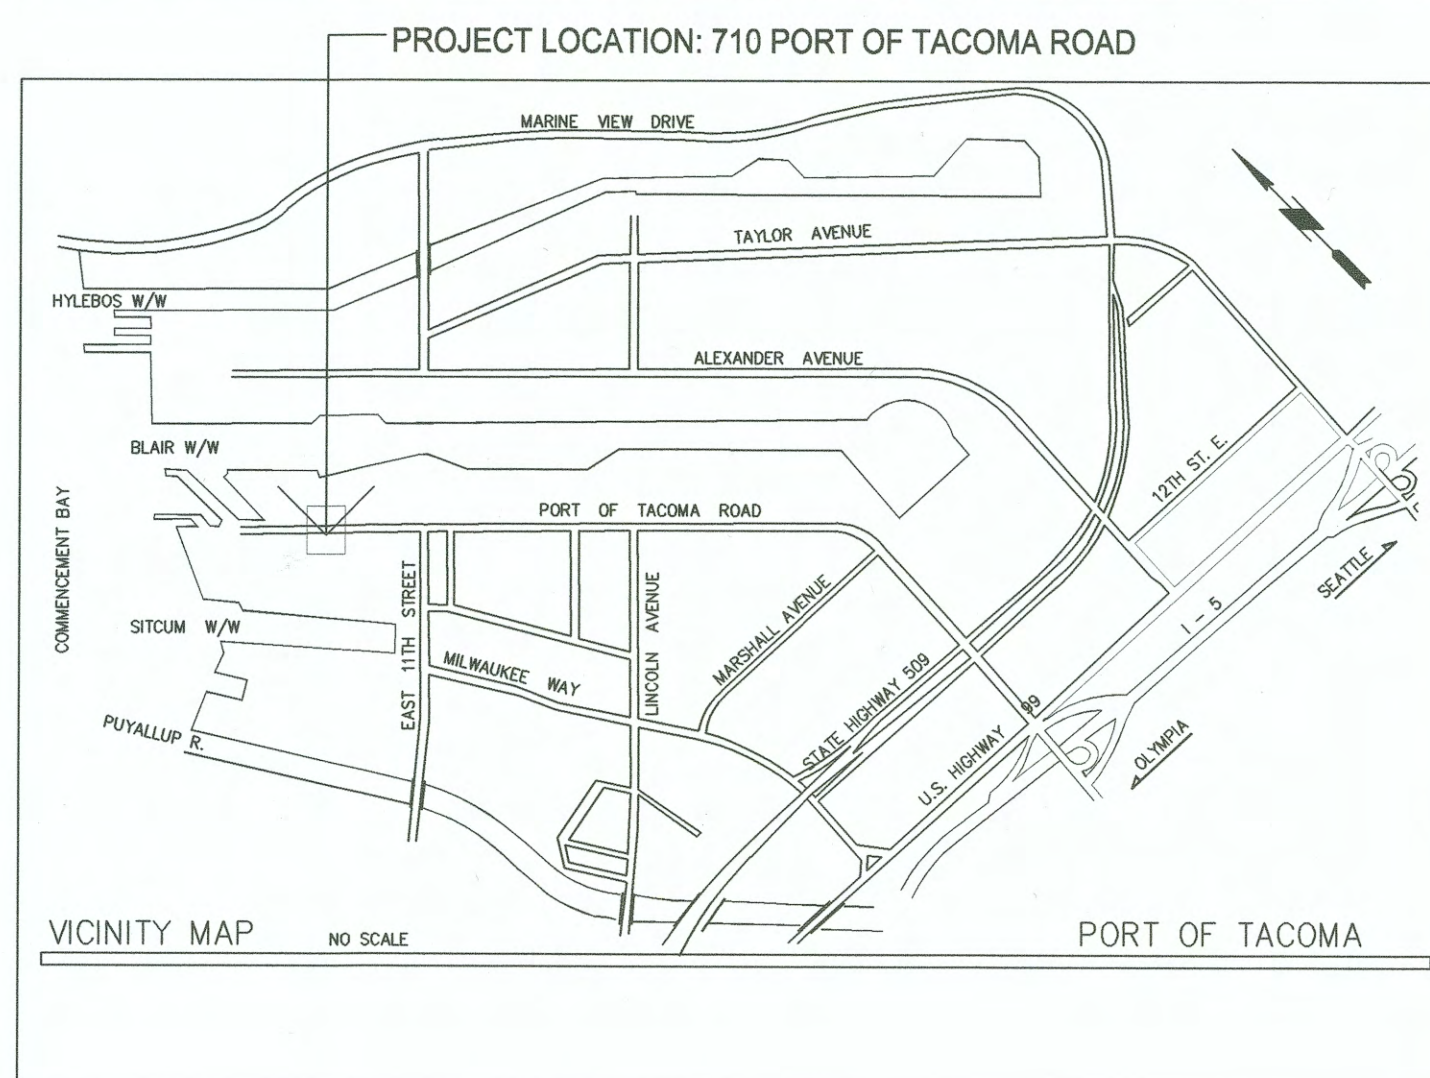

TETRA TECH
1420 Fifth Avenue Suite 600
Seattle, WA 98101
www.tetrattech.com

CONSULTANT:



PROJECT DATA:

1. ADDRESS: 710 PORT OF TACOMA ROAD
2. ACCESSOR'S PARCEL: # 2275200610
3. LEGAL DESCRIPTION: SECTION 27 TOWNSHIP RANGE 03 QUARTER 43 ASHTONS RPT BLKS 13-48 TAC TDLDS
126.150 AC B 15 & 1.274 AC B 15A TOG/W POR VAC E 11TH ST ABUTT PER ORD 25746 DC7/1/98JU
4. USE: RAIL YARD CONTROL TOWER (1988) - NO CHANGE OF USE
5. OCCUPANCY: B-2
CONSTRUCTION TYPE: II - 1 Hr - SPRINKLERED
FOURTH FLOOR AREA: 484 SF
ADA ACCOMMODATIONS: NONE, EXEMPT - STAIR ACCESS ONLY

PROJECT DESCRIPTION:

1. NO EXTERIOR IMPROVEMENTS & NO CHANGES TO BUILDING ENVELOPE.
2. REMOVE & REPLACE EXISTING CABINETS & COUNTERTOPS
3. REPLACE EXISTING LIGHTING FIXTURES
4. ADD NEW UNDERCOUNTER REFRIGERATORS
5. PATCH & PAINT EXISTING WALLS & CEILINGS INCLUDING ANY DISTURBED SURFACES LOCATED ON FLOORS 2 & 3 (ASSOCIATED W/ PLUMBING & ELECTRICAL WORK).
6. INSTALL NEW FLOOR COVERING & BASE
7. ADD NEW HAND SINK & WATER FILTER

DRAWING LIST			
SHEET DESIGNATION	SHEET #	NAME	REVISION
G1	1	COVER SHEET - DRAWING INDEX	0
G2	2	SYMBOLS & ABBREVIATIONS	0
A1	3	FLOOR PLAN & REFLECTED CEILING PLAN	0
A2	4	INTERIOR ELEVATIONS	0
A3	5	DETAILS	0
M1	6	FOURTH FLOOR PLUMBING PLAN	0
E1	7	ELECTRICAL SYMBOLS	0
E2	8	ELECTRICAL FLOOR PLANS	0
E3	9	ELECTRICAL ONE-LINE AND SCHEDULES	0
			0
		REFERENCE DRAWINGS	0
REF #1	10	REFERENCE DRAWING - ORIGINAL SITE PLAN 1988	0
	11		0
	13		0
	14		0
	15		0
	16		0
	17		0
	18		0
	19		0
	20		

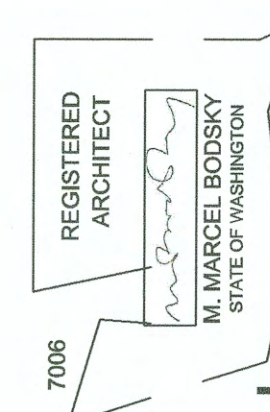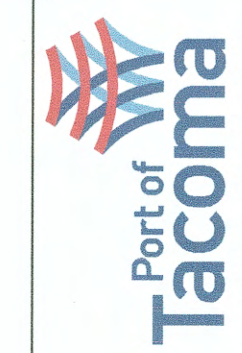


6602 G1 1 OF 10	NIM TOWER FOURTH FLOOR RENOVATIONS COVER SHEET - DRAWING INDEX				APPROVED: 	CHECKED BY: _____ DATE: _____
	TOWNSHIP: _____	RANGE: _____	SECTION: _____	DIRECTOR ENG. DATE: _____	PROJ. ENGR _____ DATE _____	
	DAT-HRZ: WA83-SF	VERT: _____	MLLW 19.33' @ Tide 22 19.33'	PRINTED BY: thomas roth Jan 03, 2019		
	PARCEL: _____	DRAWING SCALE: AS NOTED		PORT ADDRESS: ONE SITCUM PLAZA SECONUM, CT 0637		
	PERMITS: _____	PERMITTING: _____				

ABBREVIATIONS

A	AS DESCRIBED	CF/CI	CONTRACTOR	EPS	EXPANDED	HDW	HARDWARE	MTG	MOUNTING	PT	PRESSURE TREATED,	SQ IN	SQUARE INCH	U	UNDERGROUND
(A)	A LABEL CLASS DOOR		FURNISHED/		POLYSTYRENE BOARD	HDWD	HARDWOOD	MTL	METAL		PAINT	SQ M	SQUARE METER	UE	UTILITY LINES
A/C	AIR CONDITIONING		CONTRACTOR	EQ	EQUAL	HEPA	HIGH EFFICIENCY	MW	MONITORING WELL	PTD	PAPER TOWEL	SQ YD	SQUARE YARD	UNF	UNFINISHED
AB	ANCHOR BOLT	CFE	CONTRACTOR	ET	ELECTRICAL		FILTER	MWP	MEMBRANE	PTDR	DISPENSER	SS	STAINLESS STEEL	UNO	UNLESS NOTED
ABDN	ABANDON		FURNISHED		TRANSFORMER	HGT	HEIGHT		WATERPROOFING		PAPER TOWEL	SSMR	SANITARY SEWER		OTHERWISE
ACC	ACCESSIBLE	CFLG	EQUIPMENT	EW	EACH WAY	HK	HOOK	N			DISPENSER AND	ST	METAL ROOF	UR	URINAL
ACI	AMERICAN CONCRETE	CFM	COUNTER FLASHING	EWC	ELECTRIC WATER	HM	HOLLOW METAL	N		PTN	RECEPTACLE	ST	STAIRS, STAIN	V VB	VAPOR BARRIER
	INSTITUTE		CUBIC FEET PER		COOLER	HORIZ	HORIZONTAL	NA		PVDF	PARTITION	STC	SOUND	VCT	VINYL COMPOSITION
ACoust	ACOUSTIC(AL)	CFMF	MINUTE	EXIST	EXISTING	HT	HEIGHT	ND			POLYVINYLIDENE	STD	STANDARD	VERT	VERTICAL
ACP	ACOUSTICAL CEILING		COLD FORM METAL	EXP AB	EXPOSED	HSS	HOLLOW STRUCTURAL	ND		PWR	FLUORIDE	STR	TRANSMISSION CLASS	VR	VAPOR RETARDER
	PANEL		FRAMING		EXPANSION ANCHOR		SECTION	NE		Q	POWER	STL	STEEL	VTC	VIDEO
ACS	AUTOMATIC CONTROL		CUBIC FEET PER		BOLT	HVAC	HEATING VENTILATION	N		QTY		STL JST	STEEL JOIST	VTR	VENT THROUGH ROOF
ACT	ACOUSTICAL CEILING	CFT	SECOND	EXPN	EXPANSION		AND AIR	NFFA				STL RF DK	STEEL ROOF DECK		
	TILE	CG	CERAMIC FLOOR TILE	EXT	EXTERIOR PAINT	HW,	HARDWARE				QUARRY TILE	STR	STORAGE		
ACU	AIR CONDITIONING	CI	CORNER GUARD	EXT GR	EXTERIOR GRADE	HDWR		NIC	NOT IN CONTRACT	R	QUANTITY	STRB/HRN	STRINGER	W	WATER
	UNIT	CIP	CAST IRON			HYD	HYDRAULIC	NL	NAIL	R		STRUCT	STRUCTURE(AL)	W	WEST
ADA	AMERICANS WITH	CJ	CAST IN PLACE	F	FOUND			NO	NUMBER	RB	RISER	SUB FL	SUB FLOOR	W	WITH
ADD	DISABILITIES ACT	CL	CONTROL JOINT	F	FIRE ALARM	I		NOM	NOMINAL	RCP	REFLECTED CEILING	SUSP	SUSPENDED	W/O	WITHOUT
	ADMINISTRATION	CLG	CENTER LINE	FAAP	FIRE ALARM	IBC	INTERNATIONAL	NP	NO PAINT		REINFORCED CONC	SV	SHEET VINYL	WC	WATER CLOSET
AFF	ADDITIONAL ADMIN	CLG DIFF	CEILING		FIRE ALARM		BUILDING CODE	NRC	NOISE REDUCTION	RCP	PIPE	SV	SANITARY SEWER	WD	WOOD
AFG	ABOVE FINISH FLOOR	CLG HT	CEILING HEIGHT	FAS BD	ANNUNCIATOR PANEL		INSULATED	NTS	NOT TO SCALE	RD	ROOF DRAIN	SW	SOUTHWEST	WG	WIRE GLASS
AFU	ABOVE FINISH GRADE	CLL	COLUMN LINE	FC BRK	FASCIA BOARD	IF	CONCRETE FORM	NW	NORTHWEST	REC	RECESSED	SYM	SYMMETRICAL	WM	WALK OFF MAT
AIB	AIR HANDLING UNIT	CLO	CLOSET	FC BRK	FACE BRICK	IG	INSULATING GLASS			REF	REFERENCE			WR	WASTE RECEPTACLE
	AIR INFILTRATION	CLR	CLEAR	FD	FLOOR CLEAN OUT	IJ	ISOLATION JOINT	O		REFR	REFRIGERATOR	T	TREAD	WRB	WEATHER RESISTANT
	BARRIER	CLRM	CLASSROOM	FDC	FLOOR DRAIN	ILO	IN LIEU OF	OTO	OUT TO OUT	REM	REMOVABLE	T			
AISC	AMERICAN INSTITUTE	CM	CONCRETE		FIRE DEPT	IN	INCH	OA	OVERALL	REP	REPAIR	T&G	TONGUE AND GROOVE		
	OF STEEL	CMP	CORRUGATED METAL	FDTN	FOUNDATION	INCAND	INCANDESCENT	OC	ON CENTER	REQ	REQUIRE	T/S	TUB / SHOWER	WRGWB	WATER RESISTANT
	CONSTRUCTION		PIPE	FEC	FIRE EXTINGUISHER	INSUL	INSULATION	OCC	OCCUPANCY	REQ'D	REQUIRED	TB	TOWEL BAR		GYPSUM WALLBOARD
ALT	ALTERNATE	CMU	CONCRETE MASONRY			INV	INVERT	OD	OUTSIDE DIAMETER	RESIL	RESILIENT	TB	TELEPHONE RISER	WS	WATER STOP
ALUM	ALUMINUM		UNIT	FED	FEDERAL	IP	IRON PIPE	OE	OVERHEAD UTILITY	REV	REVISION	TC	TERRA COTTA	WTP	WATER TREATMENT
ANOD	ANODIZE	CNDS	CONDENSATE	FF	FINISH FLOOR	IR	IRON ROD		LINES	RF	RESILIENT FLOORING	TD	TRAVEL DISTANCE	PLANT	PLANT
ANT	ANTENNA	CO	CLEANOUT	FF INSUL	FOIL FACED	IRP	INSULATED ROOF	OFCL	OWNER FURNISHED	RH	RIGHT HAND	TEL	TELEPHONE	WV	WATER VALVE
APPROX	APPROXIMATE(LY)	COL	COLUMN		INSULATION	IRR/	IRRIGATION VALVE	OFD	OVERFLOW DRAIN	RL	ROOF LEADER	TEMP	TEMPORARY	WWTP	WASTE WATER
AR	AS REQUIRED	COMM	COMMUNICATIONS	FFE	ELEVATION	ITG	TEMPERED GLASS		OFFICE	RLG	RAILING	TER	TERRAZZO		TREATMENT PLANT
ARCH	ARCHITECT(URAL)	CONC	CONCRETE		FINISH GRADE		INSULATED WALL	OFGL	OWNER FURNISHED	RM	ROOM	TFF	TOP OF FINISH FLOOR	X	X CUT
ASC	ABOVE SUSPENDED	CONF	CONFERENCE		FIBERGLASS	IWP		OFFO	OWNER FURNISHED	RR	ROUGH OPENING	THK	THICKNESS	XC	
	CEILING	CONST	CONSTRUCTION		FIRE HOSE		PANEL		OWNER INSTALLED	RR	RESTROOM	TK BD	TACK BOARD		
ASSY	ASSEMBLY	CONT	CONTINUOUS		FIRE HYDRANT			OGH	OBSCURE GLASS	RR	RAILROAD	TLT	TOILET		
ATFP	ANTI-TERRORISM /	COORD	COORDINATE		FIGURE	J		OPH	OPPOSITE HAND	RSD	ROLLING STEEL DOOR	TMPD GL	TEMPERED GLASS		
	FORCE PROTECTION	CORR	CORRIDOR		FIN	J	JUNCTION BOX	OPNG	OPENING	RV	ROOF VENT	TOF	TOP OF FOOTING		
AVG	AVERAGE	CP	CONCRETE PIPE		FIXTURE	JAN	JANITOR	OPP	OPPOSITE	RVL	REVEAL	TOM	TOP OF MASONRY		
AW	ARCHITECTURAL	CPP	CORRUGATED		FL	JBL	JURISDICTIONAL	OPQ	OPAQUE			TOP	TOP OF PARAPET		
	WOODWORK		PLASTIC PIPE		FLDG	JST	JOINT	OPR	OPERABLE	S		TOPO	TOPOGRAPHY		
AWT	ACOUSTICAL WALL	CPT	CARPET		FLEX	JT	JOIST	ORIG	ORIGINAL	S	SET	TOS	TOP OF SLAB		
	TREATMENT	CR	CONTROL ROOM		FLMT		JOINT	OSB	ORIENTED STRAND	S	SOUTH	TP	TRANSVERSE POINT		
		CS	CAST STONE		FLR				BOARD	S2S	SURFACE TWO SIDES	TRANS	TRANSOM		
B	B LABEL CLASS DOOR	CSWK	CASEWORK		FLUOR	K	KITCHEN	OTS	OPEN TO STRUCTURE	S4S	SURFACE FOUR SIDES	TRTD	TREATED		
BALC	BALCONY	CTB	CERAMIC TILE - BASE		FM	KPD	KEYPAD	OWSJ	OPEN WEB STEEL	SAPC	SUSPENDED	TS	TUBE STEEL		
BB	BASEBOARD	CTF	CERAMIC TILE - FLOOR		FO	KPL	KICKPLATE	OZ	OUNCE		CEILING	TSC	TRAFFIC SIGNAL		
BD	BOARD	CTR	CENTER		FOM					SATC	SUSPENDED	TSP	CONTROL		
BFF	BELOW FINISH FLOOR	CTW	CERAMIC TILE - WALL		FOS	L		P	POST		ACOUSTICAL TILE	TV	CABLE TELEVISION		
BHMA	BUILDER'S HARDWARE	CU FT	CUBIC FEET		FR	LAM	LAMINATE	P	PER PLAT	SB	SPLASH BLOCK	TYP	TYPICAL		
	MANUFACTURER'S	CW	CASEMENT WINDOW		FRG	LAV	LAVATORY	(P)	PUBLIC ADDRESS	SC	SHOWER CURTAIN				
	ASSOCIATION	CWT	CERAMIC WALL TILE		FRMG	LBR	LUMBER	PA	PARAPET	SC	SECTION CORNER				
BL	BASELINE				FRP	LBS	POUNDS	PAR	PATTERN	SCHED	SCHEDULE				
BLDG	BUILDING	D	DEPTH		FRT	LDG	LANDING	PAT	PLAT BOOK	SCR	SHOWER CURTAIN				
BLKG	BLOCKING	D LABEL	D LABEL CLASS DOOR		FR	LG	LONG	PB	PULL BOX	SCW	SOLID CORE WOOD				
BLT	IN BUILT-IN	DBL	DOUBLE		FR	LG	LONG	PBD	PARTICLE BOARD	SCWD	SOLID CORE WOOD				
BM	BEAM	DEPT	DEPARTMENT		FT	LIB	LIBRARY	PCC	PRECAST CONCRETE		DOOR				
BM	BENCH MARK	DET	DETAIL		FTG	LIN	LINEAR	PCF	POUND PER CUBIC	SD	SMOKE DETECTOR				
BN	BULLNOSE	DF	DRINKING FOUNTAIN		FUR	LKR	LOCKER	PCT	PERCENT	SD	STORM DRAIN				
BOF	BOTTOM OF FOOTING	DIA	DIAMETER		FWC	LLH	LONG LEG	PEMB	PRE-ENGINEERED	SE	SOUTH EAST				
BOS	BOTTOM OF STEEL	DIAG	DIAGONAL			LNT	LONG LEG VERTICAL	PERF	METAL BUILDING	SF	SQUARE FOOT				
BOT	BOTTOM	DIM	DIMENSION			LOC	LOCATION	PERIM	PERFORATED	SFTWD	SOFT WOOD				
BP	BUILDING PAPER	DIP	DUCTILE IRON PIPE			LOCS	LOCATIONS	PERP	PERPENDICULAR	SGL	SINGLE				
BRG	BEARING	DK	DECK			LP	LIGHT POLE	PG	PAGE	SH	SOAP HOLDER				
BRKT	BRACKET	DN	DOWN			LT	LABORATORY SINK	PH	PHASE	SHR	SHOWER				
BSMT	BASEMENT	DOC	DOCUMENT			LVD	LOUVER DOOR	PIL	PILASTER	SHT MTL	SHEET METAL				
BTWN	BETWEEN	DR	DOOR			LVR	LOUVER	PK	PK NAIL	SHTNG	SHEATHING				
BUR	BUILT UP ROOF	DS	DOWNSPOUT					PL	PROPERTY LINE	SHV	SHELVING				
		DWG(S)	DRAWING(S)					PL GL	PLATE GLASS	SIM	SIMILAR				
C	CENTER POINT	E	EAST					PLAS	PLASTIC LAMINATE	SJ	SCORED JOINT				
C	CALCULATED	E LABEL	E LABEL CLASS DOOR					PLBG	PLUMBING	SKLT	SKYLIGHT				
C CONC	CAST CONCRETE	EA	EACH					PLG	PILING	SLNT	SEALANT				
C LABEL	C LABEL CLASS DOOR	EB	ELECTRICAL RISER					PLYWD	PLYWOOD	SLR	SEALER				
C-C	CENTER TO CENTER	EF	EACH FACE					PNC	PANEL	SM	SQUARE METER				
CAB	CABLE	EIFS	EXTERIOR INSULATION					POLY	POINT OF CONTACT	SMHD	SHELF METAL HEAVY				
CATW	CATWALK		AND FINISH SYSTEM					PP PL	POLYSTYRENE	SMK	DUTY				
CAV	CAVITY		EXPANSION JOINT					PR	PRECAST	SMLS	SEAMLESS				
CB	CATCH BASIN		ELEVATOR					PRCST	PREFABRICATED	SND	SANITARY NAPKIN				
CB	CEMENTITIOUS		ELEVATION					PRKNG	PARKING		AND TAMPON				
	(BACKER) BOARD		ELEVATION					PS CONC	PRESTRESSED		DISPENSER				
CBB	CEMENTITIOUS		ENGINEER						CONCRETE	SP EL	SPOT ELEVATION				
	BACKER BOARD		ENTRY							SPEC	SPECIFICATIONS				
CD	CONSTRUCTION		EDGE OF ASPHALT							SPF	SPRAY APPLIED				
	DOCUMENT(S)		EDGE OF CONCRETE								POLYURETHANE FOAM				
CDW	CHILLED DRINKING		EDGE OF GUTTER								INSULATION				
	WATER		ELECTRICAL METER								WATER SPIGOT				
CEM PLAS	CEMENT PLASTER		ELECTRICAL METER								SQUARE				
CER	CERAMIC		EXPLOSION PROOF								SQ FT				
CF	CONTRACTOR														
	FURNISHED														

DRAWING SYMBOLS

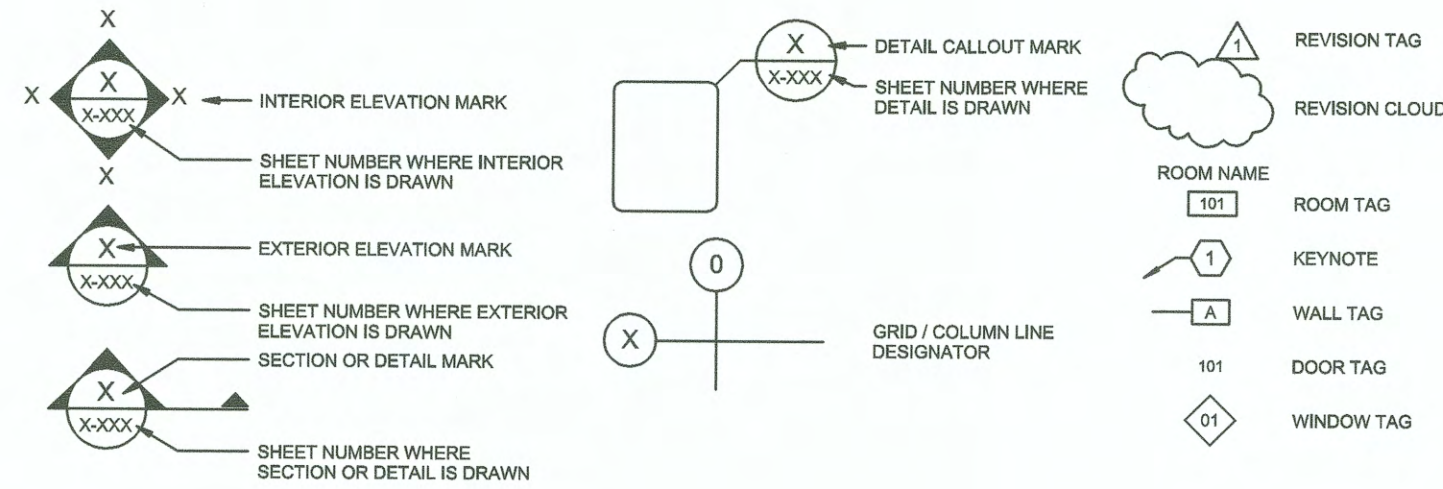

6602
G2

SH #2 OF 10

CONTCONS: 070929
M. ID: 101247.02
PHASE: PERMITTING

TOWNSHIP: 070929
DAT-HRZ: 101247.02
PARCEL: 101247.02

SECTION: 101247.02
RANGE: 101247.02
DRAWING SCALE: AS NOTED

NIM TOWER
FOURTH FLOOR RENOVATIONS
SYMBOLS & ABBREVIATIONS


APPROVED:
DIRECTOR ENG. DATE: 2/4/19
PRINTED BY: thomas.roth Jan 03, 2019
PORT ADDRESS: ONE SITCUM PLAZA

CHECKED BY: DATE: 2/4/19
PROJ. ENGR: DATE: 2/4/19
TACOMA, WA 98401-1837

REGISTERED
ARCHITECT
M. MARCELO BODSKY
STATE OF WASHINGTON


TETRA TECH
www.tetratech.com
14201 Fifth Avenue, Suite 600
P.O. BOX 1837 TACOMA, WA 98401 (253)883-8841
Tel 253.883.8438 Fax 253.883.8371

Port of
Tacoma
P.O. BOX 1837 TACOMA, WA 98401 (253)883-8841

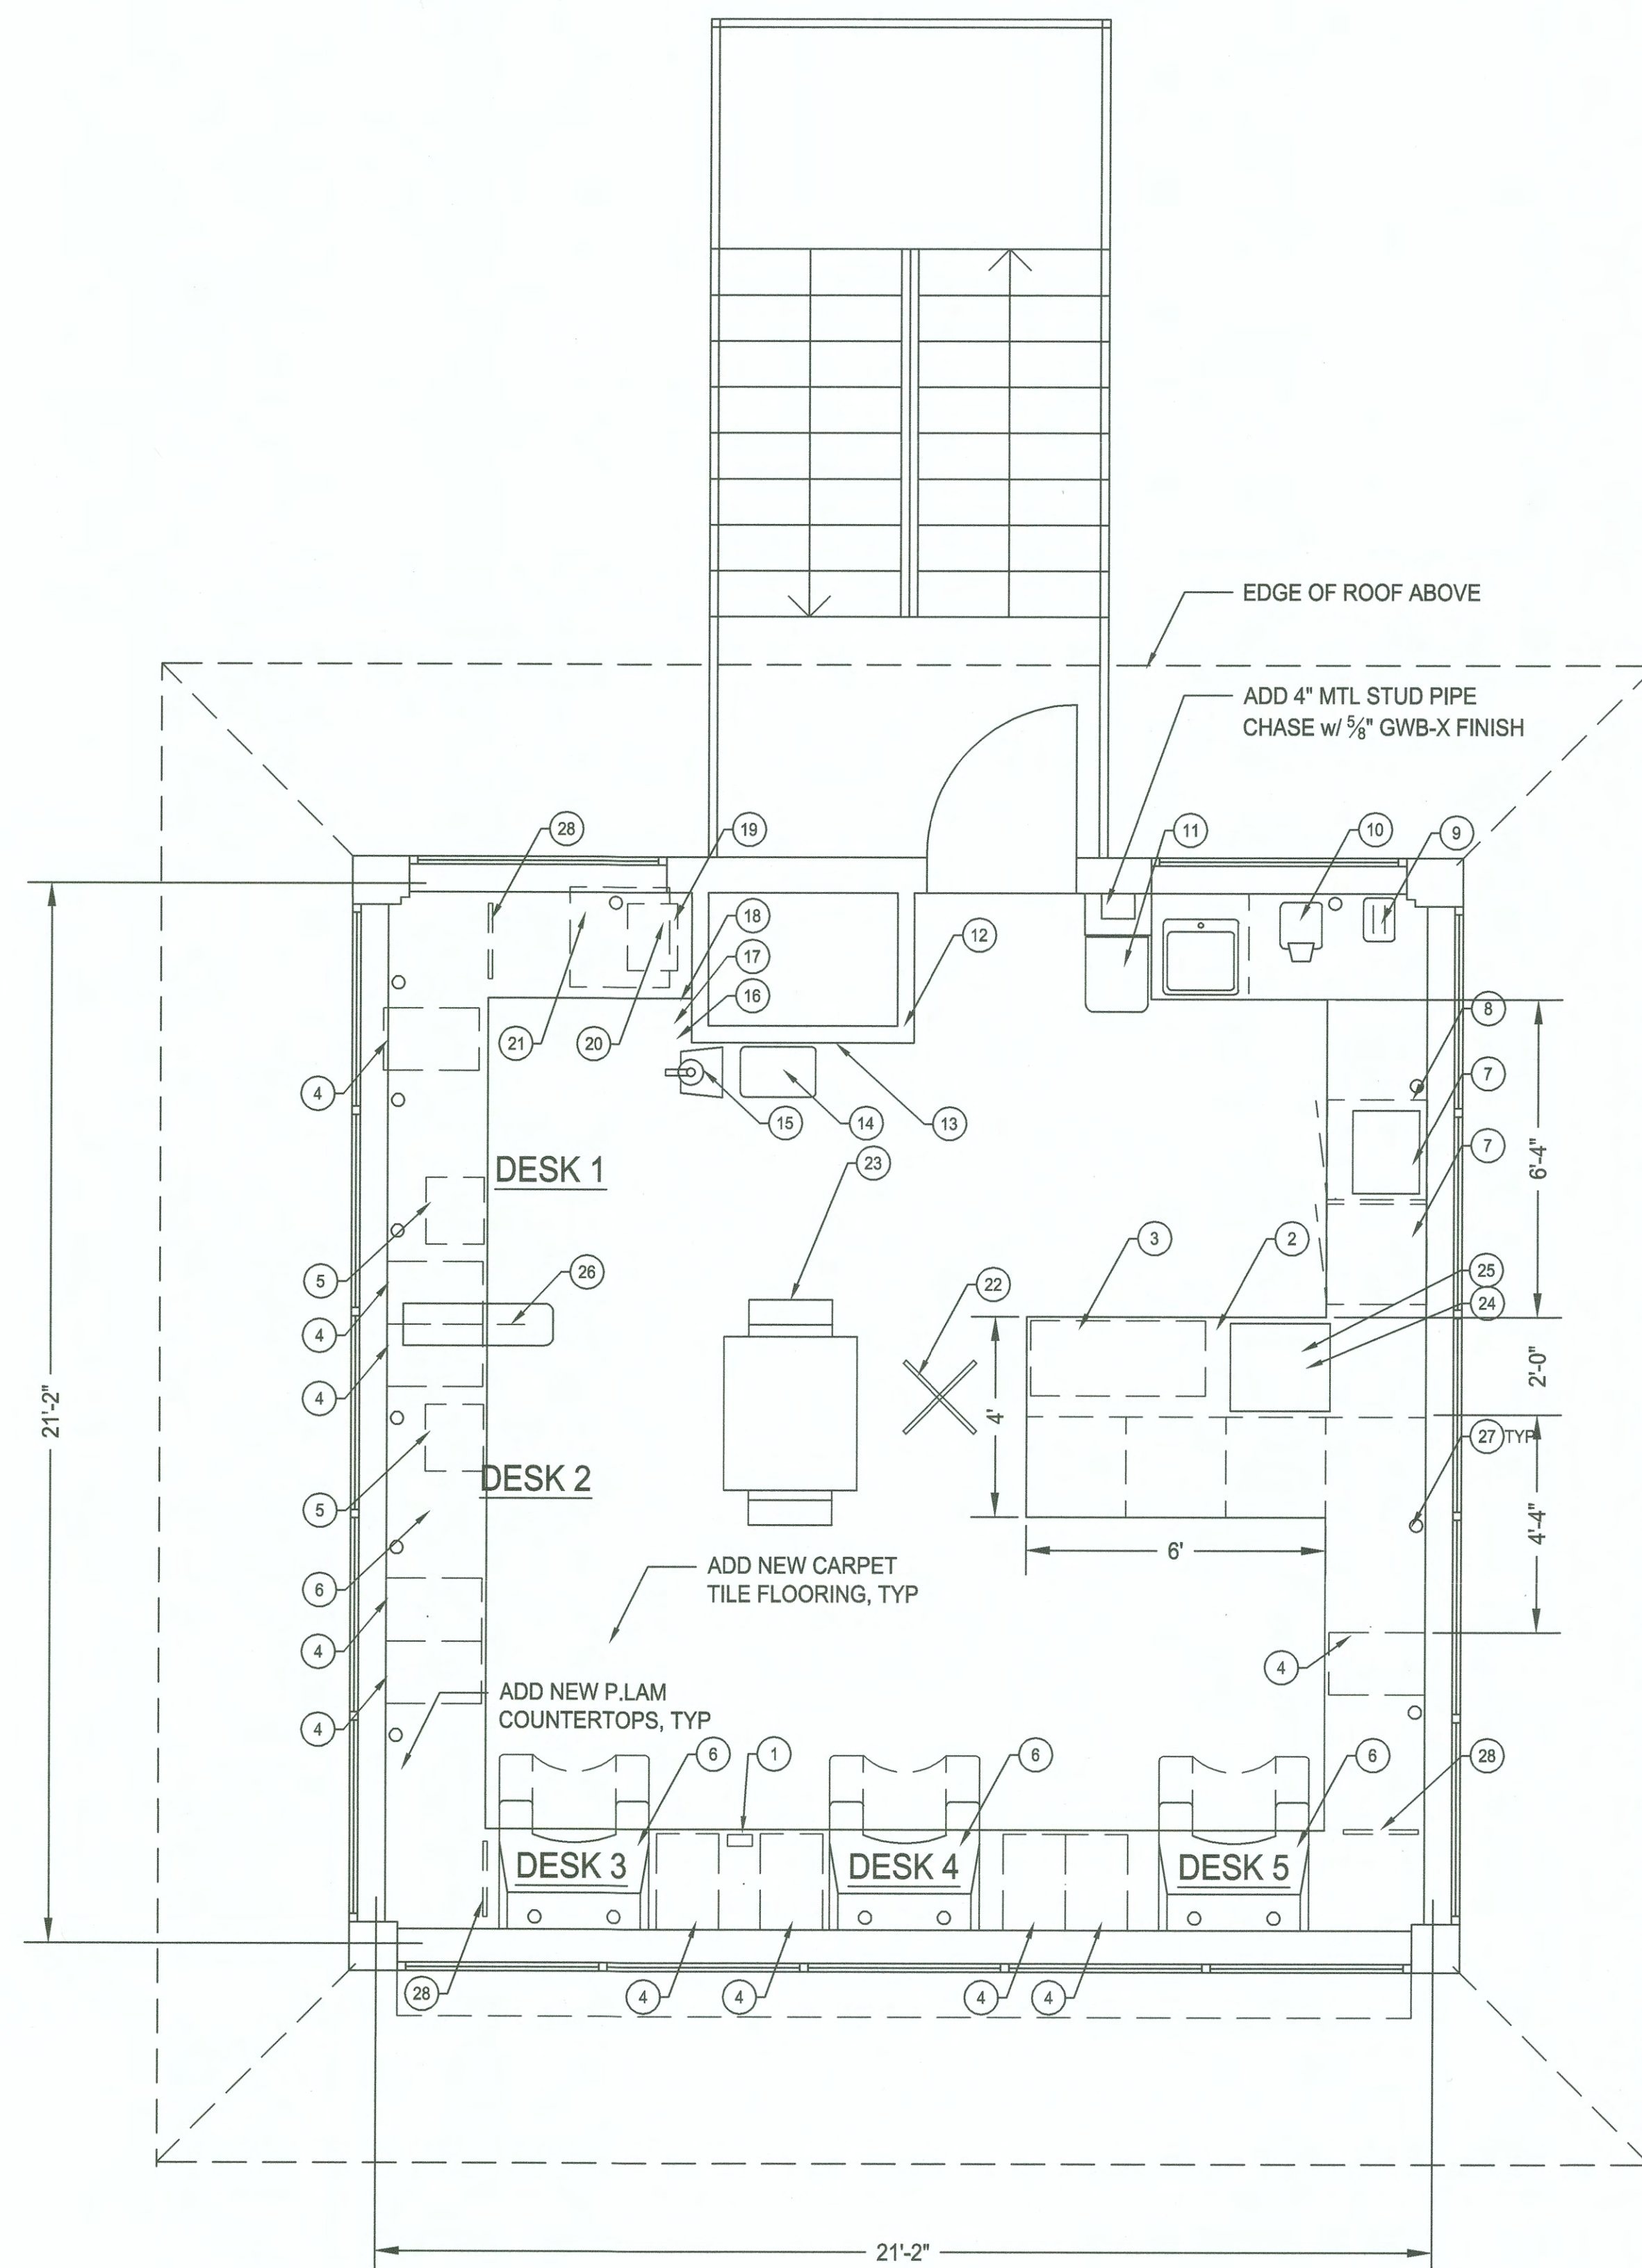


4th FLOOR PLAN

SCALE: $\frac{3}{8}" = 1'-0"$

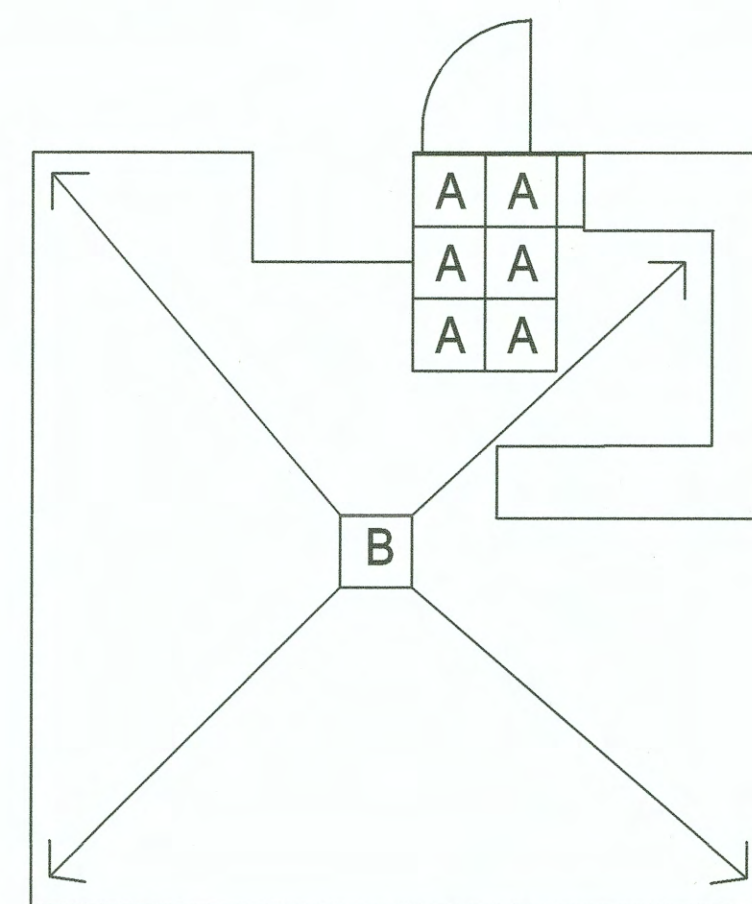

4th FLOOR CARPET PLAN

SCALE: 3/16" = 1'-0"

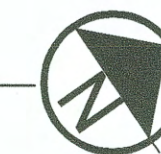

CARPET:

"A" DENOTES 24 x 24 WALK-OFF CARPET TILE

"B" DENOTES 24 x 24 FIELD CARPET TILE

ALL CARPET TILE TO BE ADHESIVE APPLIED OVER
CLEAN PREPARED CONCRETE SUBSTRATE.

REFER TO SPECIFICATIONS SECTION 09 68 13.

FURNISHINGS & EQUIPMENT:

- (10) 3-DRAWER PEDESTAL BASE FILE CABINET
(KEY PLAN ITEM 4)
- (3) COUNTERTOP-INSTALLED ERGONOMIC
STANDUP DESK (KEY PLAN ITEM 6)
- (2) UNDERCOUNTER REFRIGERATOR
(KEY PLAN ITEM 7)

DEMOLITION - GENERAL:

1. PROTECT EXISTING EQUIPMENT TO REMAIN
2. REMOVE & DISPOSE OF EXISTING CARPET, CABINETS, COUNTERTOPS & LIGHT FIXTURES.
3. BALLASTS & FLUORESCENT TUBES SHALL BE DISPOSED OF AT COUNTY HAZ-MAT FACILITIES
4. VERIFY ANY REQUIREMENTS WITH ENGINEER REGARDING MATERIALS TO BE SALVAGED
5. PORT SHALL PROVIDE A REPORT TO BIDDERS IDENTIFYING ANY HAZARDOUS MATERIALS.

DEMOLITION - FLOORS 3 & 4:


1. FLOORS 2 & 3 ARE OCCUPIED FLOORS. COORDINATE DEMOLITION ACTIVITY WITH PORT ENGINEER. IF NECESSARY, SCHEDULE WORK IN THESE AREAS FOR WEEKENDS OR EVENINGS.
2. PROTECT EXISTING FACILITIES AND PERSONNEL FROM DUST AND DAMAGE.
3. ISOLATE AREAS REQUIRING DEMOLITION AND PREVENT DUST AND DEBRIS FROM ACCUMULATING OR LEAVING IMMEDIATE WORK AREA.
CLEAN UP DEMOLITION WORK IMMEDIATELY.

DEMOLITION RESTORATION:

1. WHERE GYPSUM BOARD HAS BEEN REMOVED AND REQUIRES PATCHING, INSTALL MATCHING TYPE X BOARD AND FINISH JOINTS SMOOTH TO MATCH EXISTING.
2. SANDING IN OCCUPIES SPACES SHALL BE ACCOMPLISHED USING SANDING SCREENS ATTACHED TO VACUUM CANISTERS.
3. REPAINT ENTIRE SURFACE PLAIN OF GYPSUM BOARD FROM CORNER TO CORNER TO MATCH EXISTING. PROVIDE THOROUGH CLEANING OF ALL SPACES PRIOR TO OCCUPANCY.

KEY NOTES: ①

1. PROPOSED LOCATION FOR (E) RADIO/PHONE
2. 36" HT CABINET - P.LAM TOP (STORAGE UNDER)
3. 2 - DRAWER LATERAL FILE (42" x 19" x 28")
4. 3 - DRAWER FILE CABINET (15" x 23" x 27-1/2")
5. UNDERCOUNTER PENCIL DRAWER
6. ERGONOMIC STANDING COUNTERTOP DESK
7. UNDERCOUNTER REFRIG - 25-5/8" W x 34-1/8"
8. (E) MICROWAVE (N.I.C.)
9. (E) TOASTER (N.I.C.)
10. (E) COFFEE MAKER (N.I.C.)
11. (E) BOTTLED WATER DISPENSER (N.I.C.)
12. PROPOSED NEW LOCATION OF (E) THERMOSTAT
13. (E) BULLETIN BOARD (RETAIN)
14. (E) TRASH CAN (N.I.C.)
15. (E) VACUUM CLEANER (N.I.C.)
16. (E) LOCATION OF THERMOSTAT TO BE RELOCATED
17. (E) LIGHT BUTTON/SWITCH
18. (E) RECESSED FIRE EXTINGUISHER CABINET
19. (E) WALL-MOUNTED EQUIPMENT TO REMAIN
20. (E) FIBEROPTIC C.I.U. & SHELF TO REMAIN
21. (E) I.D.F. EQUIPMENT UNDER COUNTERTOP (RETAIN)
22. (E) COAT TREE (N.I.C.)
23. (E) FLOOR PRINTER/COPIER (N.I.C.)
24. (E) COUNTERTOP/PRINTER
25. PAPER STORAGE BELOW
26. CUSTOM SHELF UNIT
27. 3" DIAM PLASTIC WIRE MANAGEMENT SLEEVE
28. P.LAM FACED 1" SUPPORT PANEL
29. ADD NEW SINK & WATER FILTER IN CABT

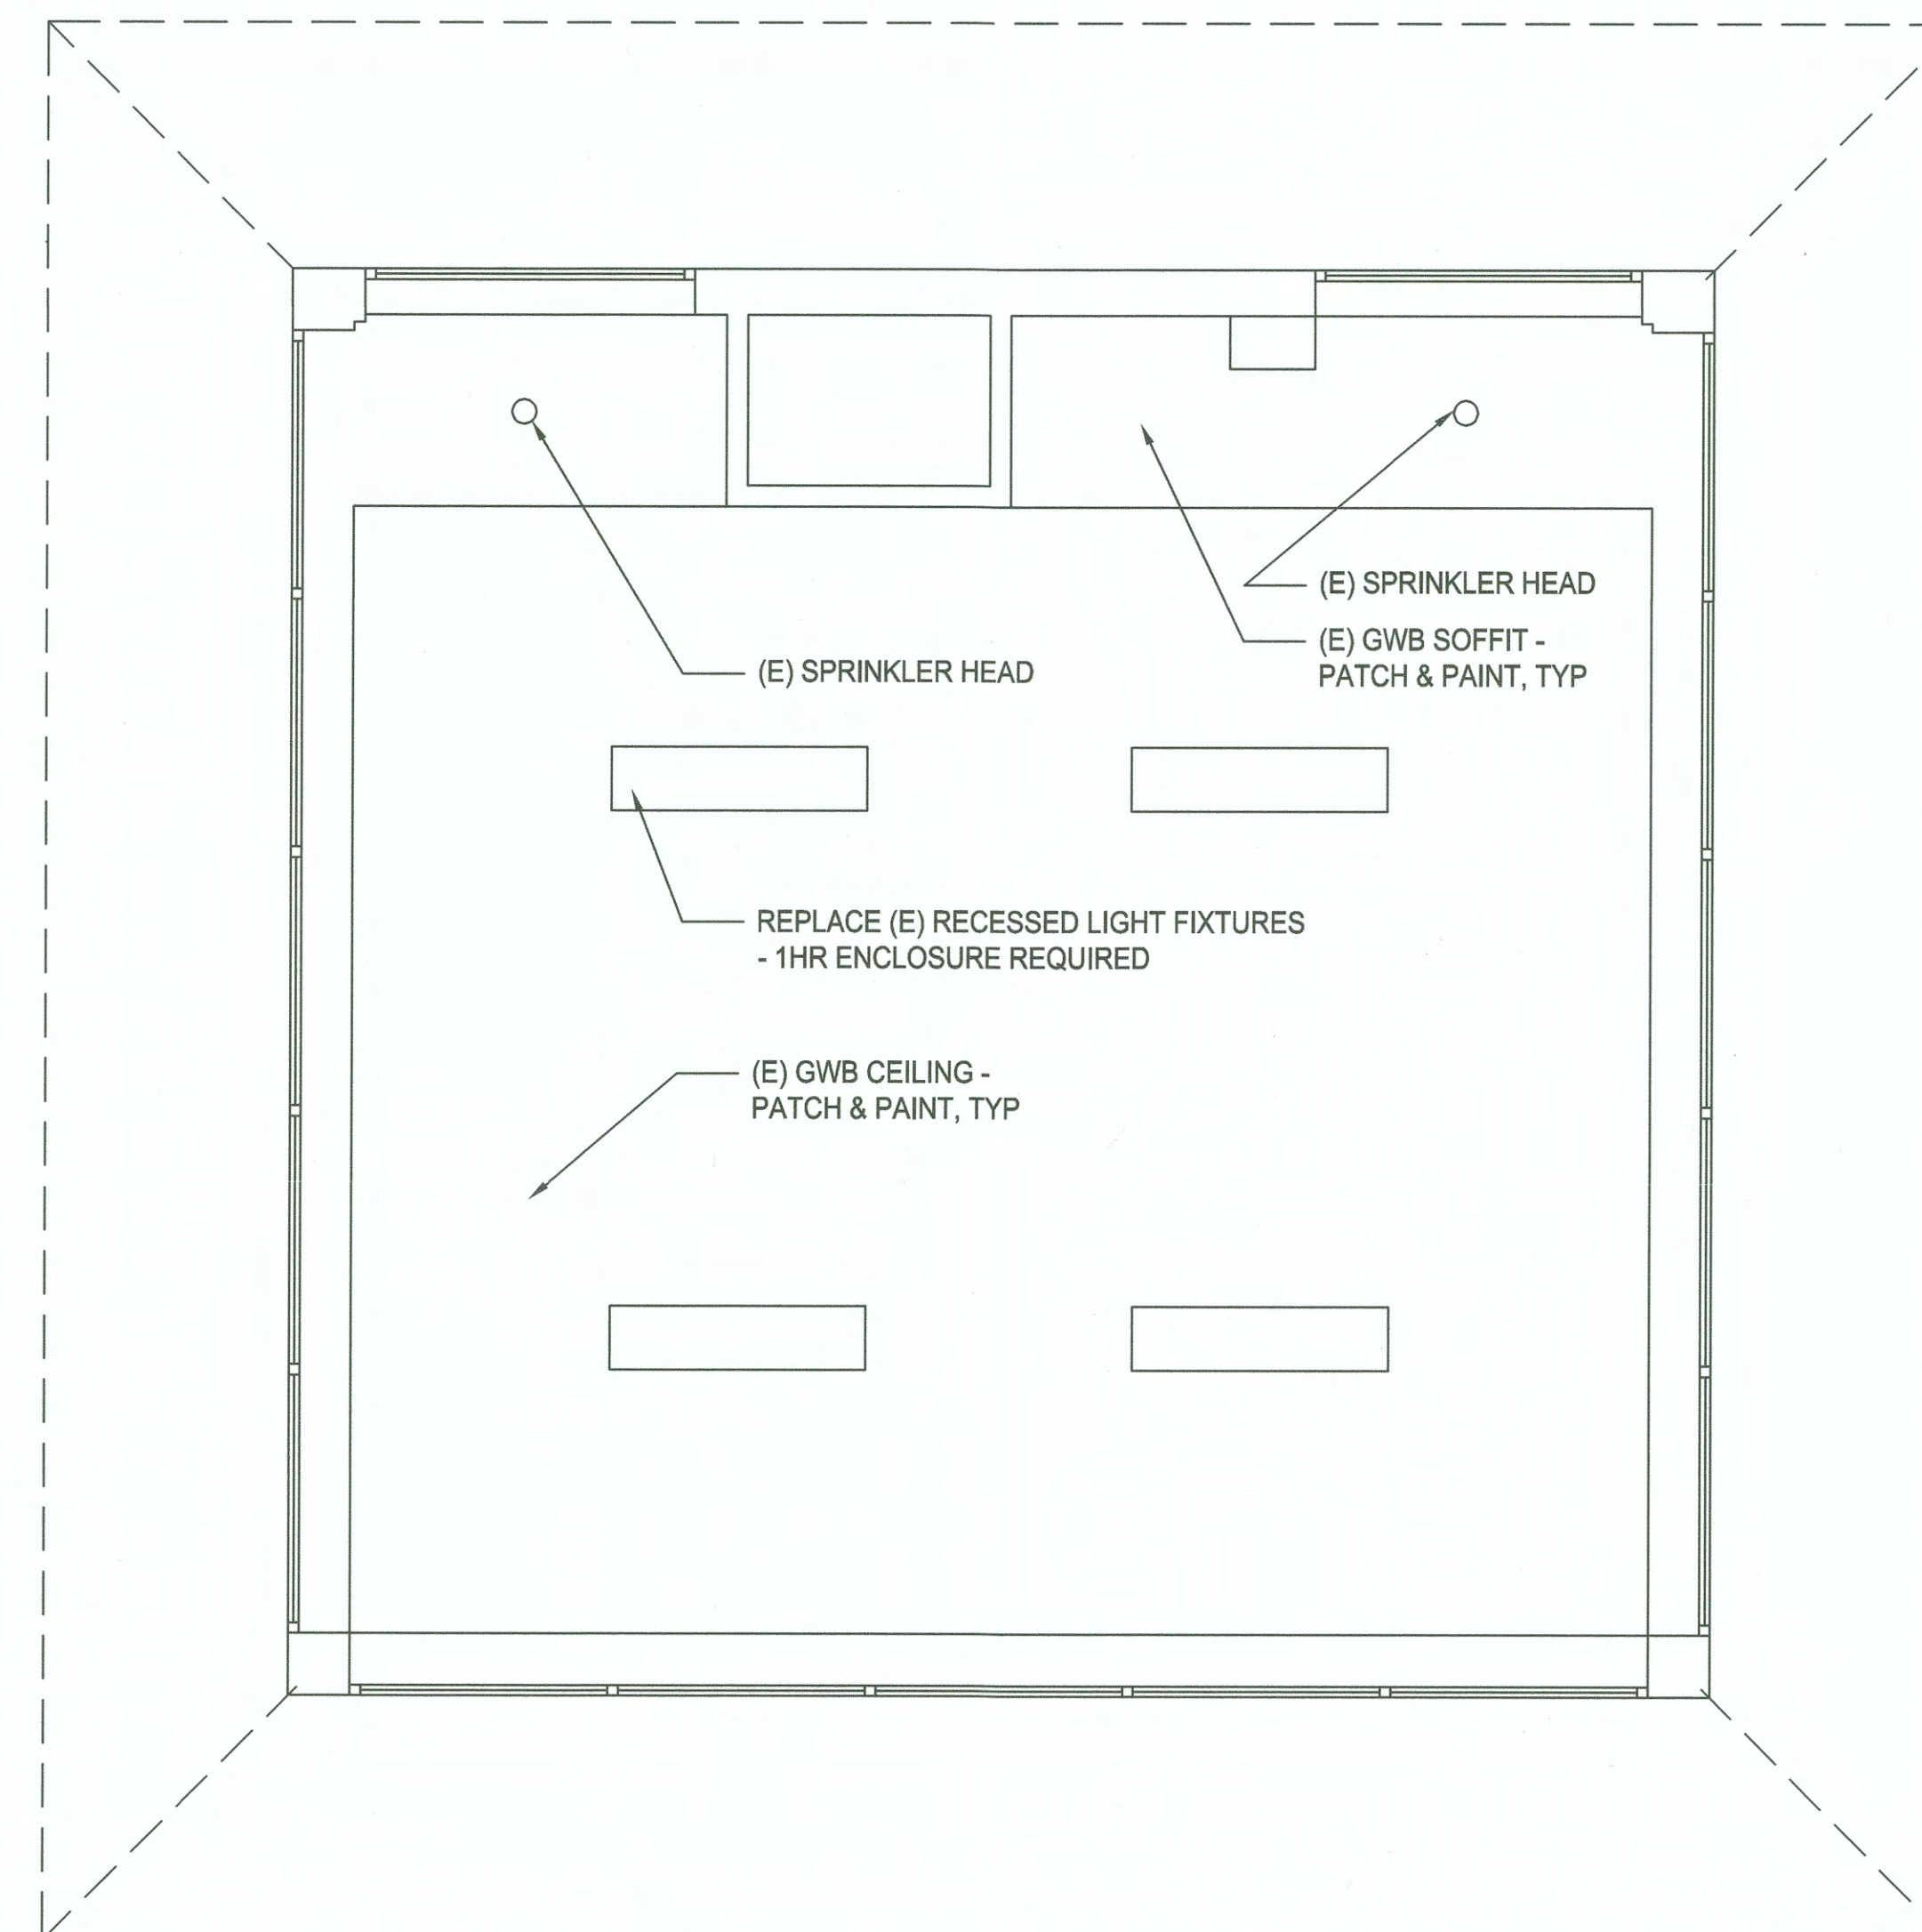

4th FLOOR REFLECTED CEILING PLAN

SCALE: $\frac{3}{8}" = 1'-0"$



6602 A1 SH #3 OF 10	NIM TOWER FOURTH FLOOR RENOVATIONS FLOOR PLANS	TOWNSHIP: RANGE: SECTION: DAT-HRZ: WA83-SF MLLW 19.39' @ Tide 22 1933 PARCEL: DRAWING SCALE: AS NOTED	APPROVED: <i>[Signature]</i> DIRECTOR ENG. DATE <i>2/4/14</i> PRINTED BY: thomas.roth Jan 03, 2019 PORT ADDRESS: ONE SITCUM PLAZA TACOMA, WA 98401-1837	7008  REGISTERED ARCHITECT 14000	 TETRA TECH www.tetratech.com 1420 First Avenue, Suite 600 Tacoma, WA 98401 TEL 206.868.9424 FAX 206.863.0901	MARK: REVISION: BY: APPR: DATE:
		CONT/CONS: 070929 M. I. D. 101247.02 PHASE: PERMITTING				










THIS DRAWING IS THE PROPERTY OF THE PORT OF TACOMA AND SHALL NOT BE USED ON OTHER WORK, DISCLOSED, COPIED, IN WHOLE OR IN PART, WITHOUT WRITTEN PERMISSION

ROOM FINISH SCHEDULE

ROOM #	NAME	FLOOR		BASE	N. WALLS		S. WALLS		E. WALLS		W. WALLS		CEILING		NOTES
		MTL	FIN		MTL	FIN	MTL	FIN	MTL	FIN	MTL	FIN	MTL	FIN	
01	CONTROL	CONC	CAR	R	GWB	PNT	GWB	PNT	GWB	PNT	GWB	PNT	GWB	PNT	PATCH & REPAIR GWB AS NEEDED - PRIME ALL PATCHES PRIOR TO APPLICATION OF FINISH - REPLACE BASE @ ALL WALLS

ABBREVIATIONS

CAR	CARPET SQUARES
CONC	(E) CONCRETE
FIN	FINISH
FIN	FINISH
GWB	(E) GYPSUM WALLBOARD
PNT	PAINT
R	RUBBER

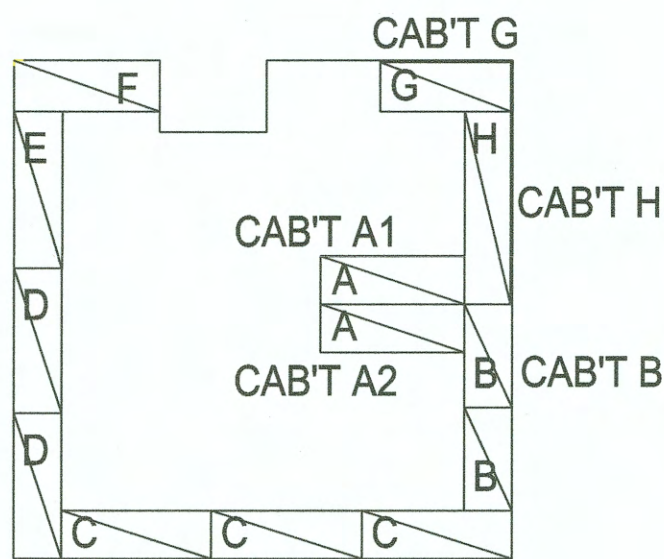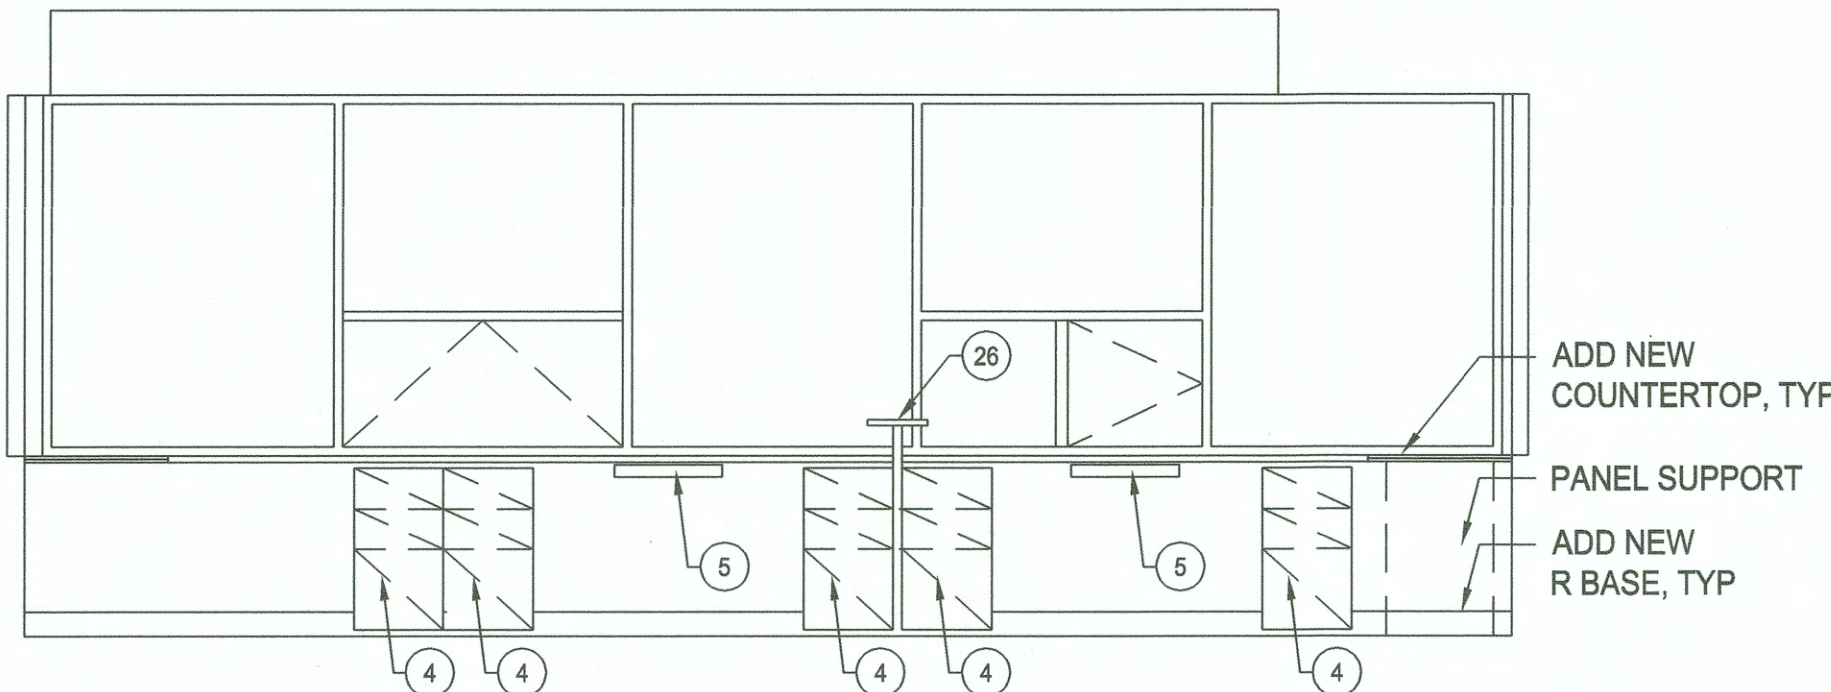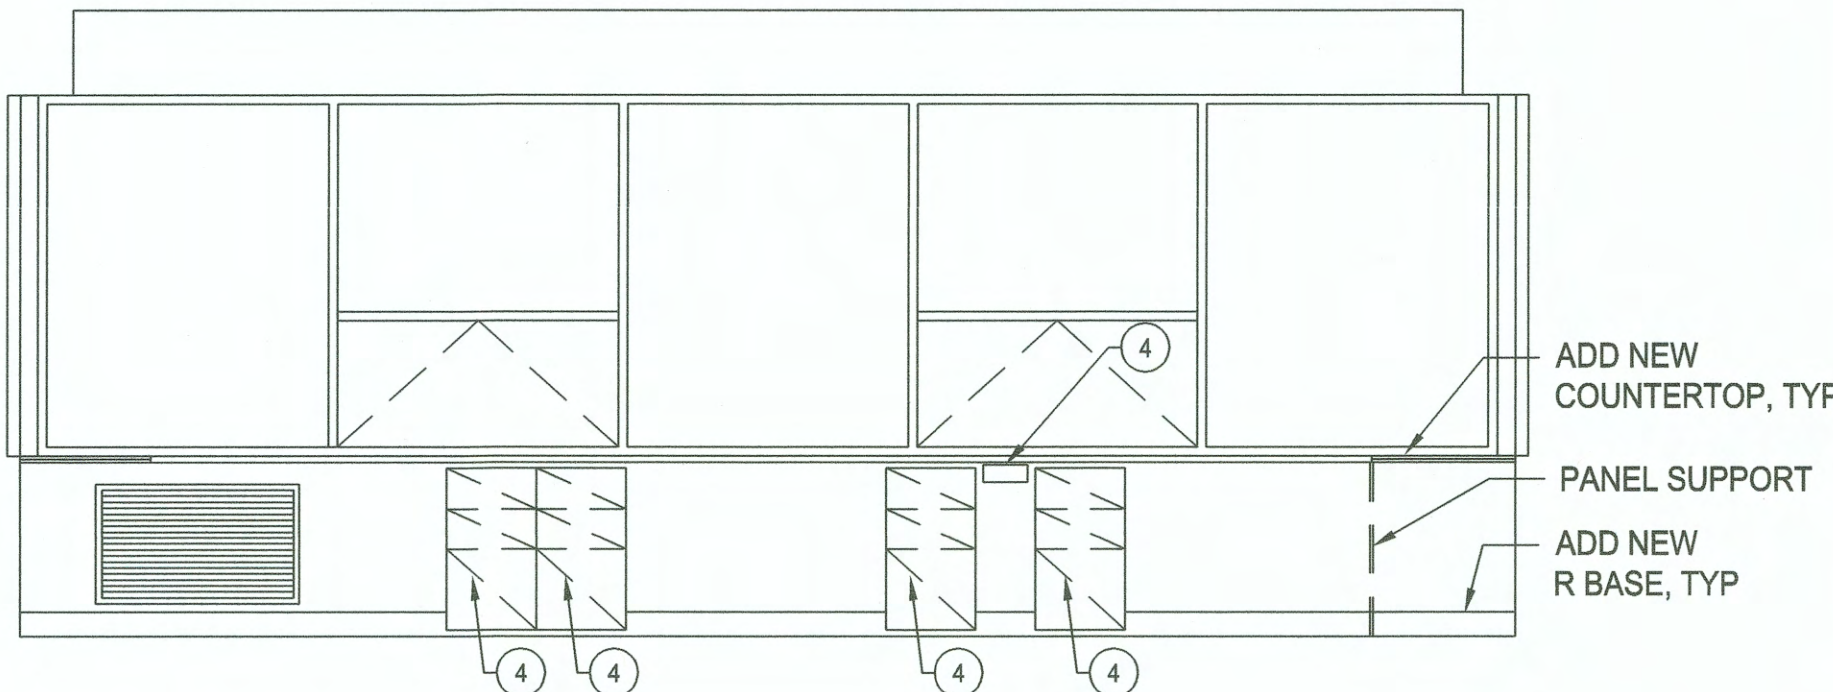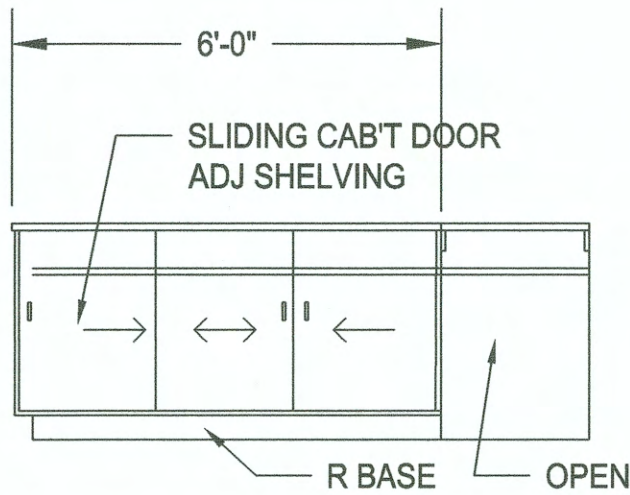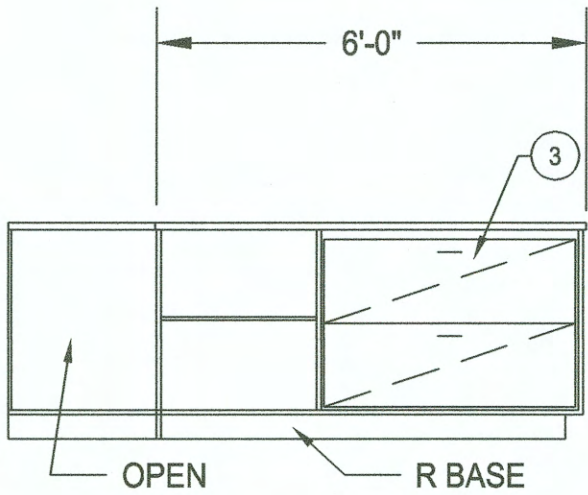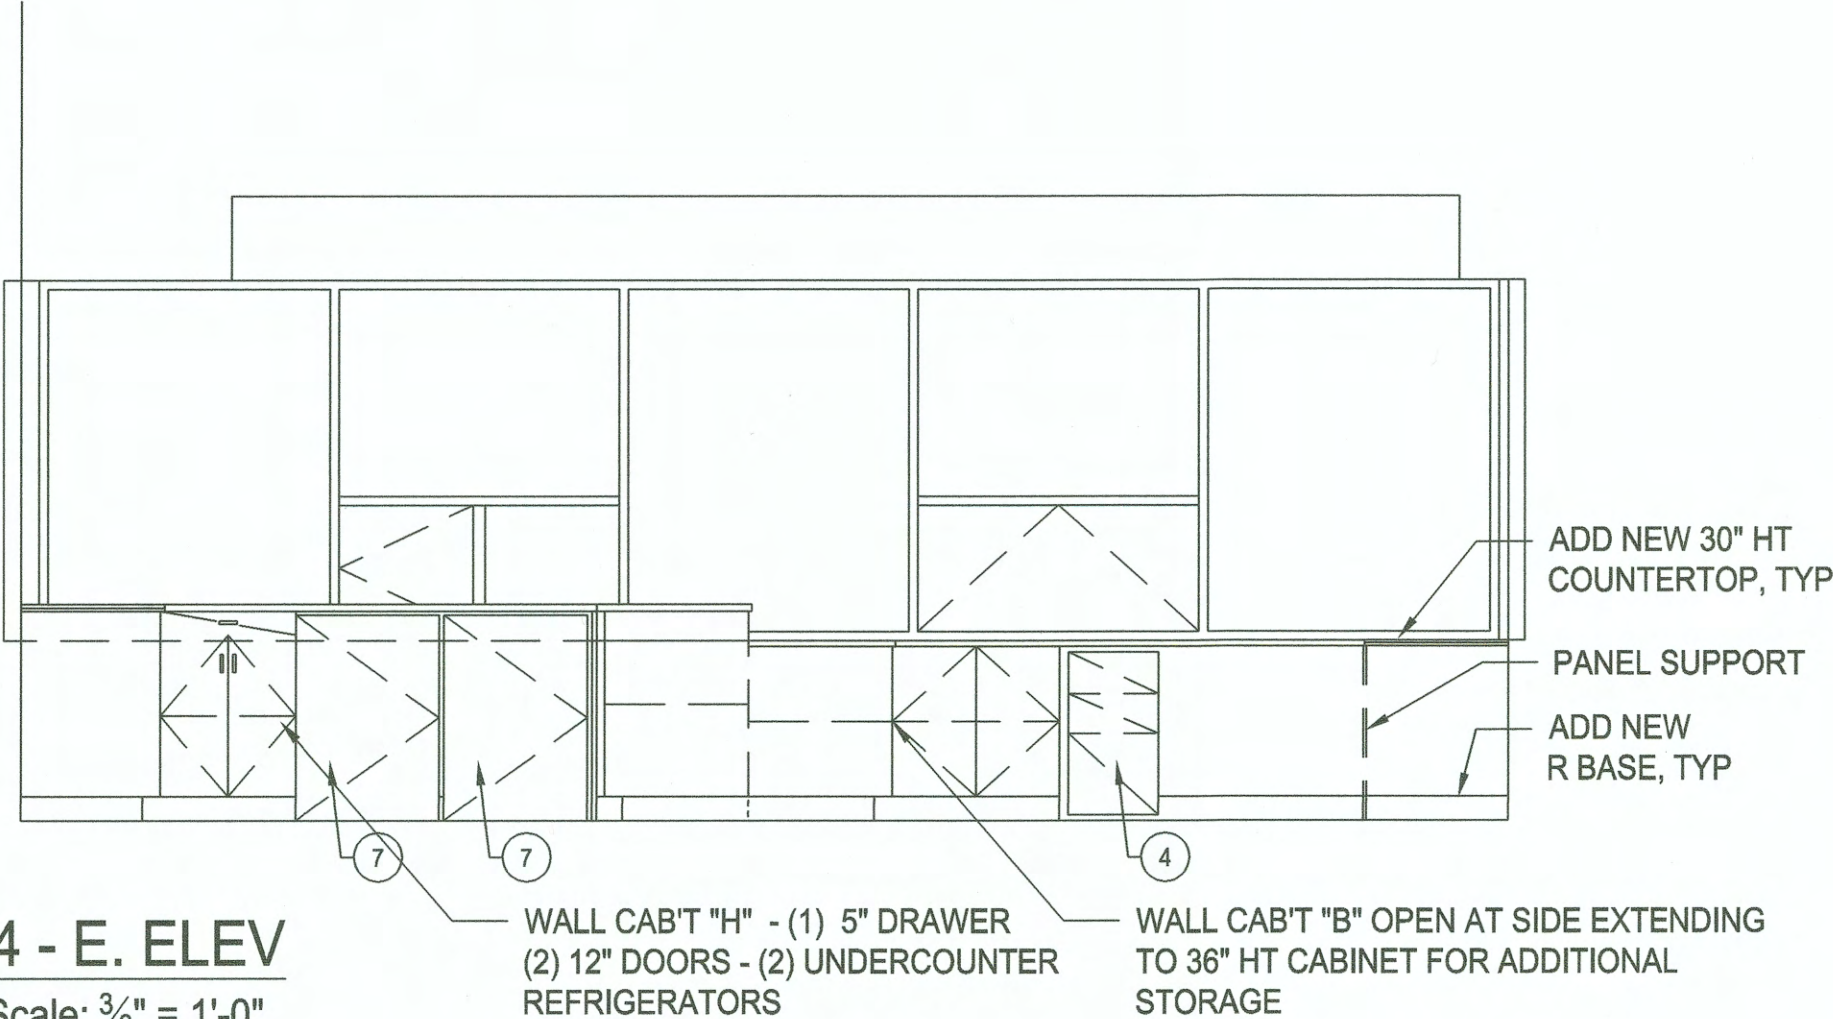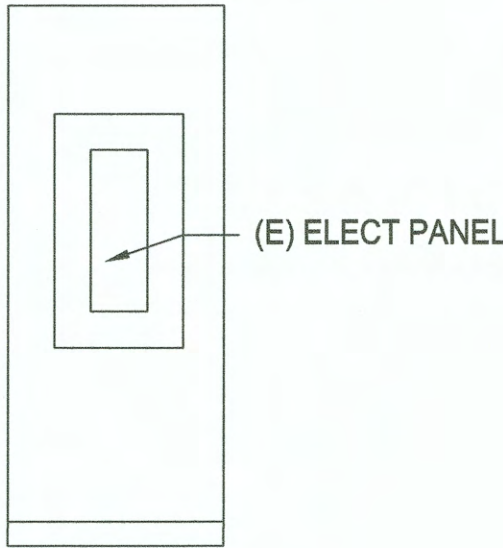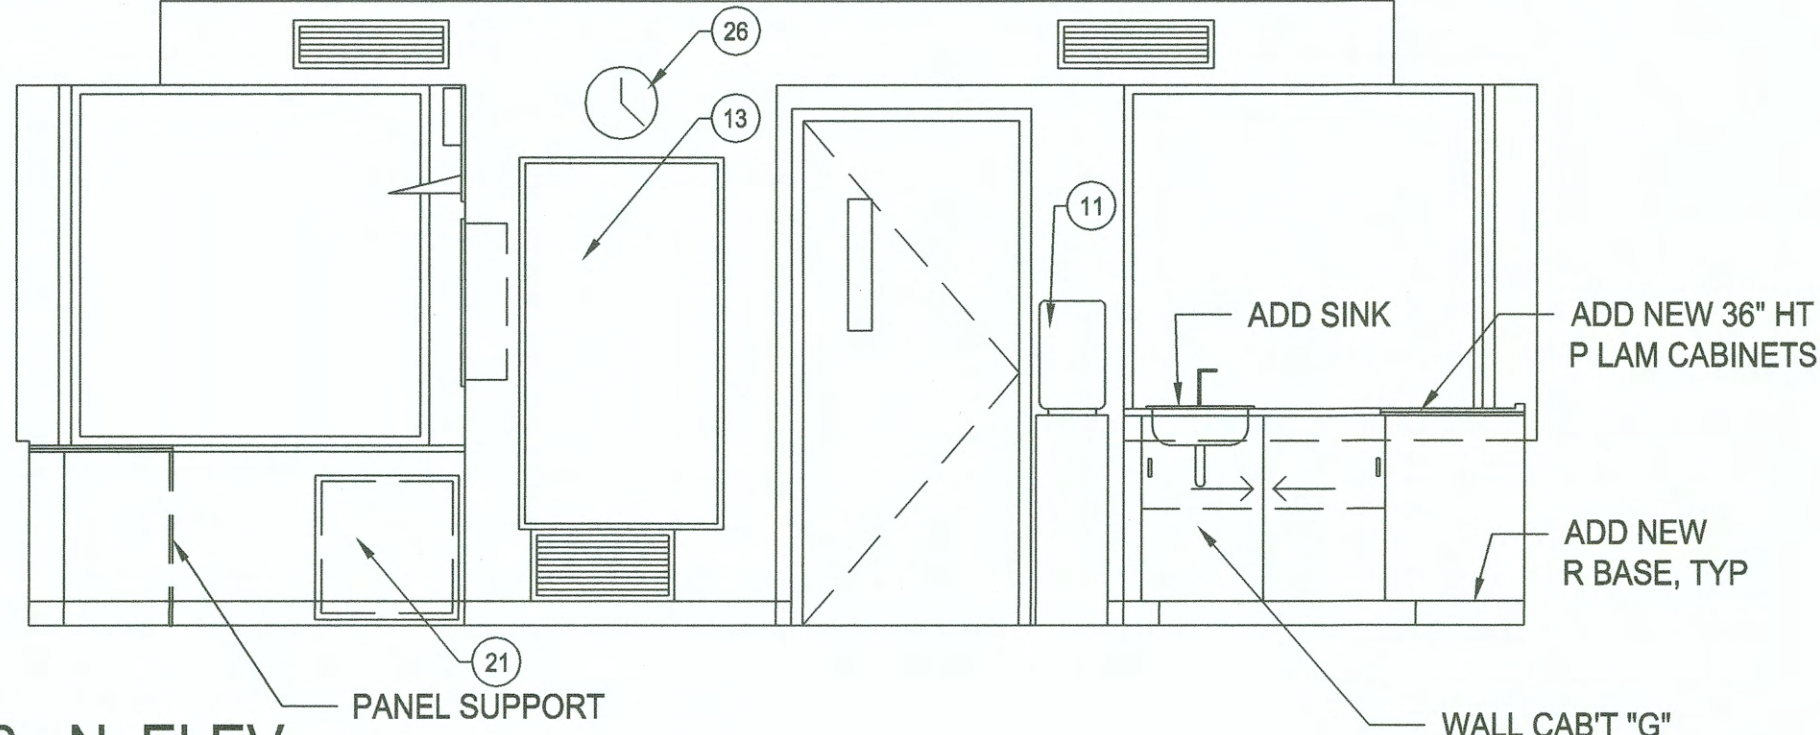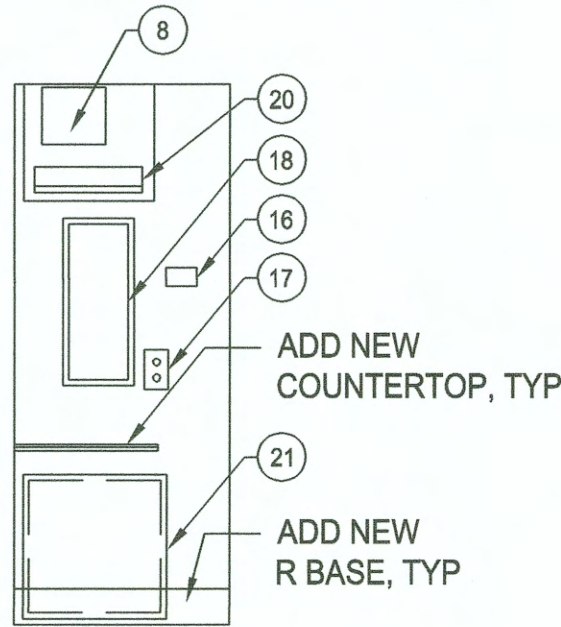

COUNTERTOP NOTES:

- COUNTERTOPS SHALL BE FABRICATED OFF-SITE IN FINISHED SECTIONS & SUPPORTED BY NEW CONTINUOUS WALL LEDGERS, NEW CABINETS, NEW FILE CABINETS, NEW FABRICATED INDIVIDUAL SUPPORT PANELS & PANEL SPLICE PLATES. SECURE TO LEDGERS WITH LIGHT GAGE STEEL UTILITY ANGLES. FIELD SCRIBE WHERE REQUIRED FOR FIT AT CORNERS & WHERE NECESSARY.
- CONTRACTOR SHALL PROVIDE LAYOUT DRAWINGS WITH SHOP DRAWINGS SHOWING DIMENSIONS BASED ON FIELD MEASUREMENTS.
- LOCATIONS OF SUPPORT PANELS ARE SHOWN ON THE FLOOR PLAN.

COUNTERTOP KEY:

- A. 24 x 72 x 1 P LAM TOP w/ PVC EDGE
- B. 24 x (+/-) 54 x 1 P LAM TOP w/ PVC EDGE
- C. 24 x (+/-) 78 x 1 P LAM TOP w/ PVC EDGE
- D. 24 x (+/-) 75 x 1 P LAM TOP w/ PVC EDGE
- E. 24 x (+/-) 80 x 1 P LAM TOP w/ PVC EDGE
- F. 30" x (+/-) 76 x 1 P LAM TOP w/ PVC EDGE (MATCH EXISTING COUNTERTOP DEPTH)
- G. 24 x (+/-) 68 x 1 P LAM TOP w/ PVC EDGE & 1" SPLASH w/ FINISHED BACK
- H. 24 x 96 x 1 P LAM TOP w/ PVC EDGE & 1" SPLASH w/ FINISHED BACK

KEY NOTES: ①

- PROPOSED LOCATION FOR (E) RADIO/PHONE
- 36" HT CABINET - P.LAM TOP (STORAGE UNDER)
- 2 - DRAWER LATERAL FILE (42" x 19" x 28")
- 3 - DRAWER FILE CABINET (15" x 23" x 27")
- UNDERCOUNTER PENCIL DRAWER
- ERGONOMIC STANDING COUNTERTOP DESK
- UNDERCOUNTER REFRIGERATOR
- (E) MICROWAVE (N.I.C.)
- (E) TOASTER (N.I.C.)
- (E) COFFEEMAKER (N.I.C.)
- (E) BOTTLED WATER DISPENSER (N.I.C.)
- PROP(E)OSED NEW LOCATION OF (E) THERMOSTAT
- (E) BULLETIN BOARD (RETAIN)
- (E) TRASH CAN (N.I.C.)
- (E) VACUUM CLEANER (N.I.C.)
- (E) LOCATION OF THERMOSTAT TO BE RELOCATED
- (E) LIGHT BUTTON/SWITCH
- (E) RECESSED FIRE EXTINGUISHER CABINET
- (E) WALL-MOUNTED EQUIPMENT TO REMAIN
- (E) FIBEROPTIC C.I.U. & SHELF TO REMAIN
- (E) I.D.F. EQUIPMENT UNDER COUNTERTOP (RETAIN)
- (E) COAT TREE (N.I.C.)
- (E) FLOOR PRINTER/COPIER (N.I.C.)
- (E) COUNTERTOP PRINTER
- PAPER STORAGE BELOW
- CUSTOM SHELF UNIT

TETRA TECH
www.tetratech.com
14207 Fir Avenue, Suite 600
Tacoma, WA 98401
Tel: 206.863.8432 Fax: 206.263.8801

REGISTERED ARCHITECT
M. MARCEL BODSKY
STATE OF WASHINGTON
7006

6602
A2
SH #4
OF 10

CONT/CONS: 070929
M.ID: 101247.02
PHASE: PERMITTING

SECTION: MLLW 19.39' @ Tide 22 1933
RANGE: WA83-SF
TOWNSHIP: DAT-HRZ: 101247.02
DRAWING SCALE: AS NOTED
PARCEL:

CHECKED BY: DATE
PROJ. ENGR: DATE
PRINTED BY: thomas roth Jan 03, 2019
PORT ADDRESS: ONE SITCUM PLAZA
TACOMA, WA 98401-1837

APPROVED: DIRECTOR ENG. DATE 2/4/19

DATE: DATE:
BY: BY:
REVISION: REVISION:
MARK: MARK:

Port of Tacoma
P.O. BOX 1897 TACOMA, WA 98461 (206)863-3841