

TACOMA TERMINALS INC.

PORT COMMISSIONERS 1984

ROBERT G. EARLEY
JACK A. FABULICH
JOE E. FAKER
JOHN A. MCCARTHY
PATRICK O'MALLEY

LAWRENCE M. KILLEEN EXECUTIVE DIRECTOR

JOHN J. TERPSTRA PROJECT MANAGER

ARCHITECT

McGRANAHAN, MESSENGER ASSOCIATES
950 S. FAWCETT, SUITE 300
TACOMA, WA 98402 383-3084





PORT OF TACOMA PHASE IV

STRUCTURAL ENGINEER



ADAMS-HODSDON ENGINEERS, INC.
5308 12th STREET EAST
TACOMA, WA 98424 922-1600

MECHANICAL/ELECTRICAL ENGINEER

TRES WEST ENGINEERS, INC.
2719 ROCHESTER STREET WEST, SUITE 2
TACOMA, WA 98406 565-6252

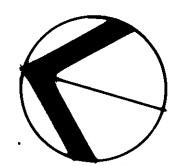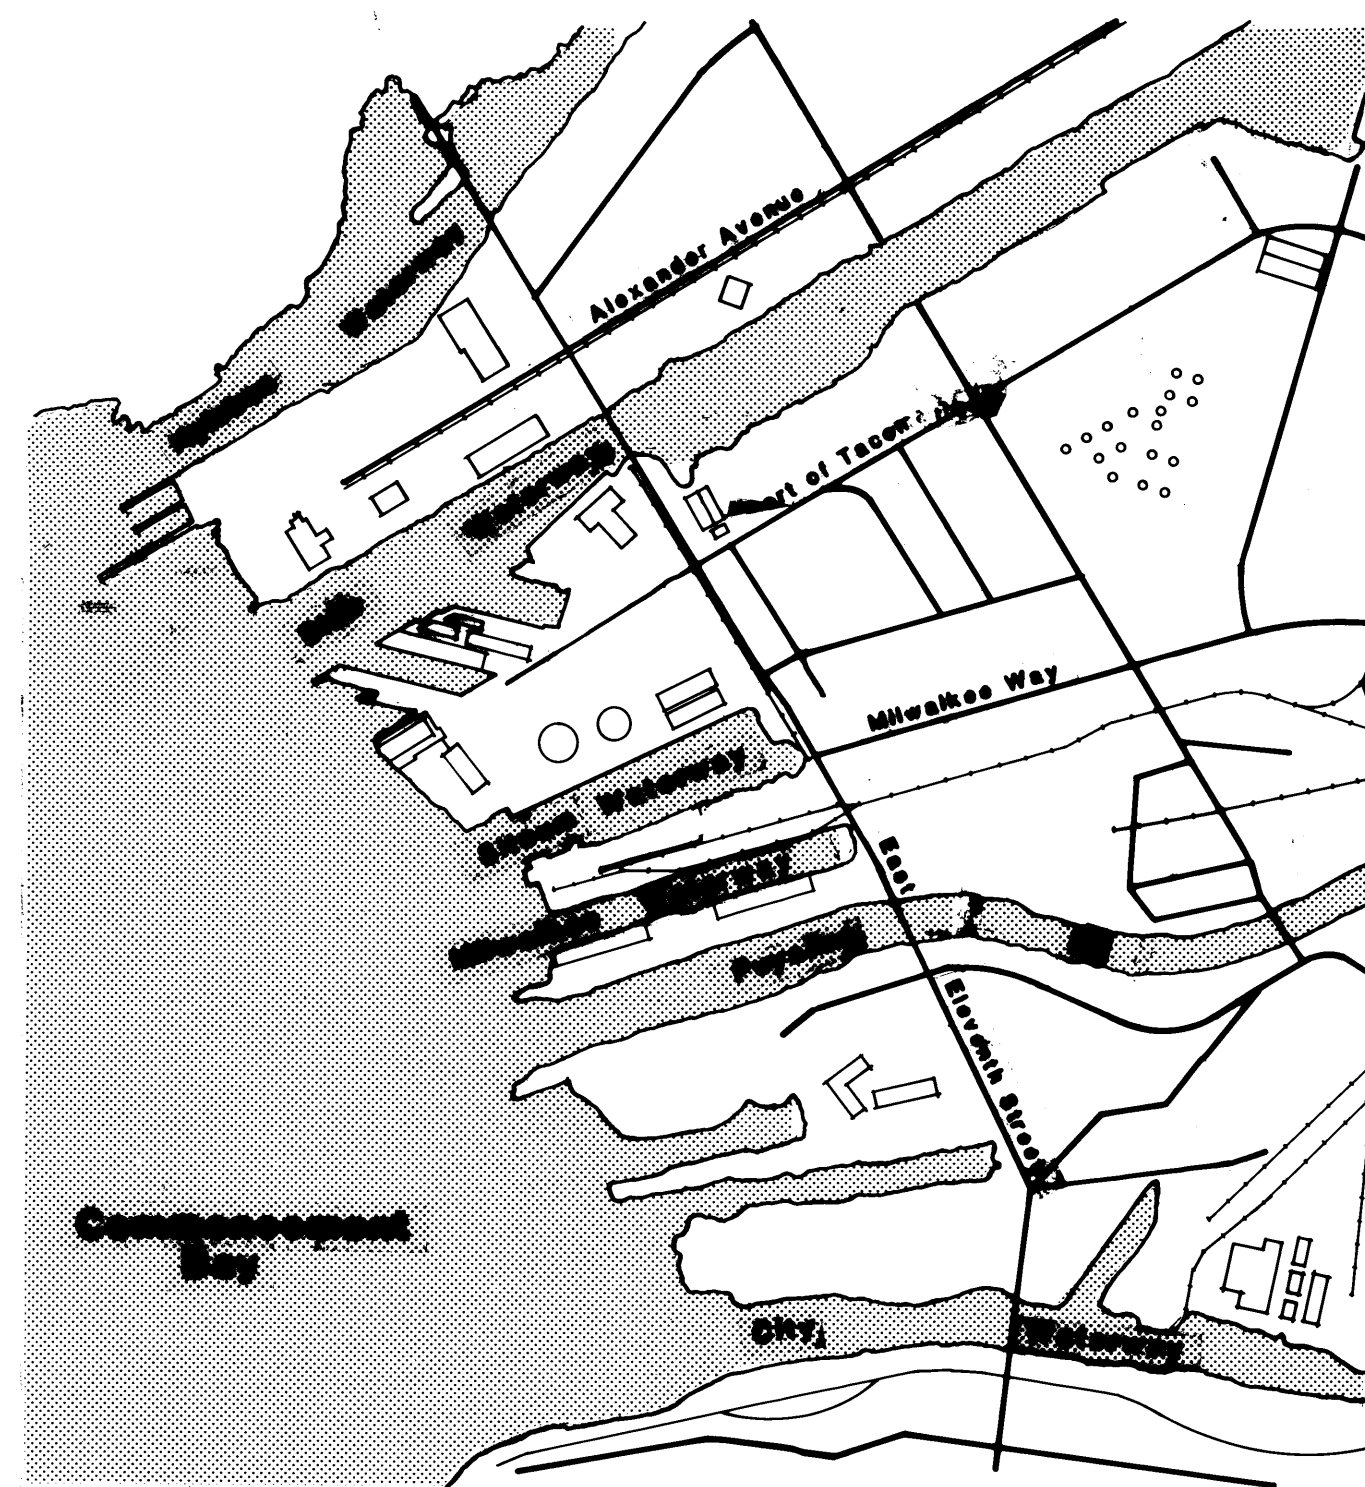

VICINITY MAP

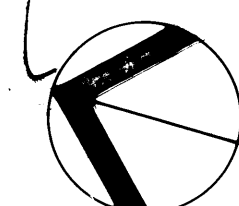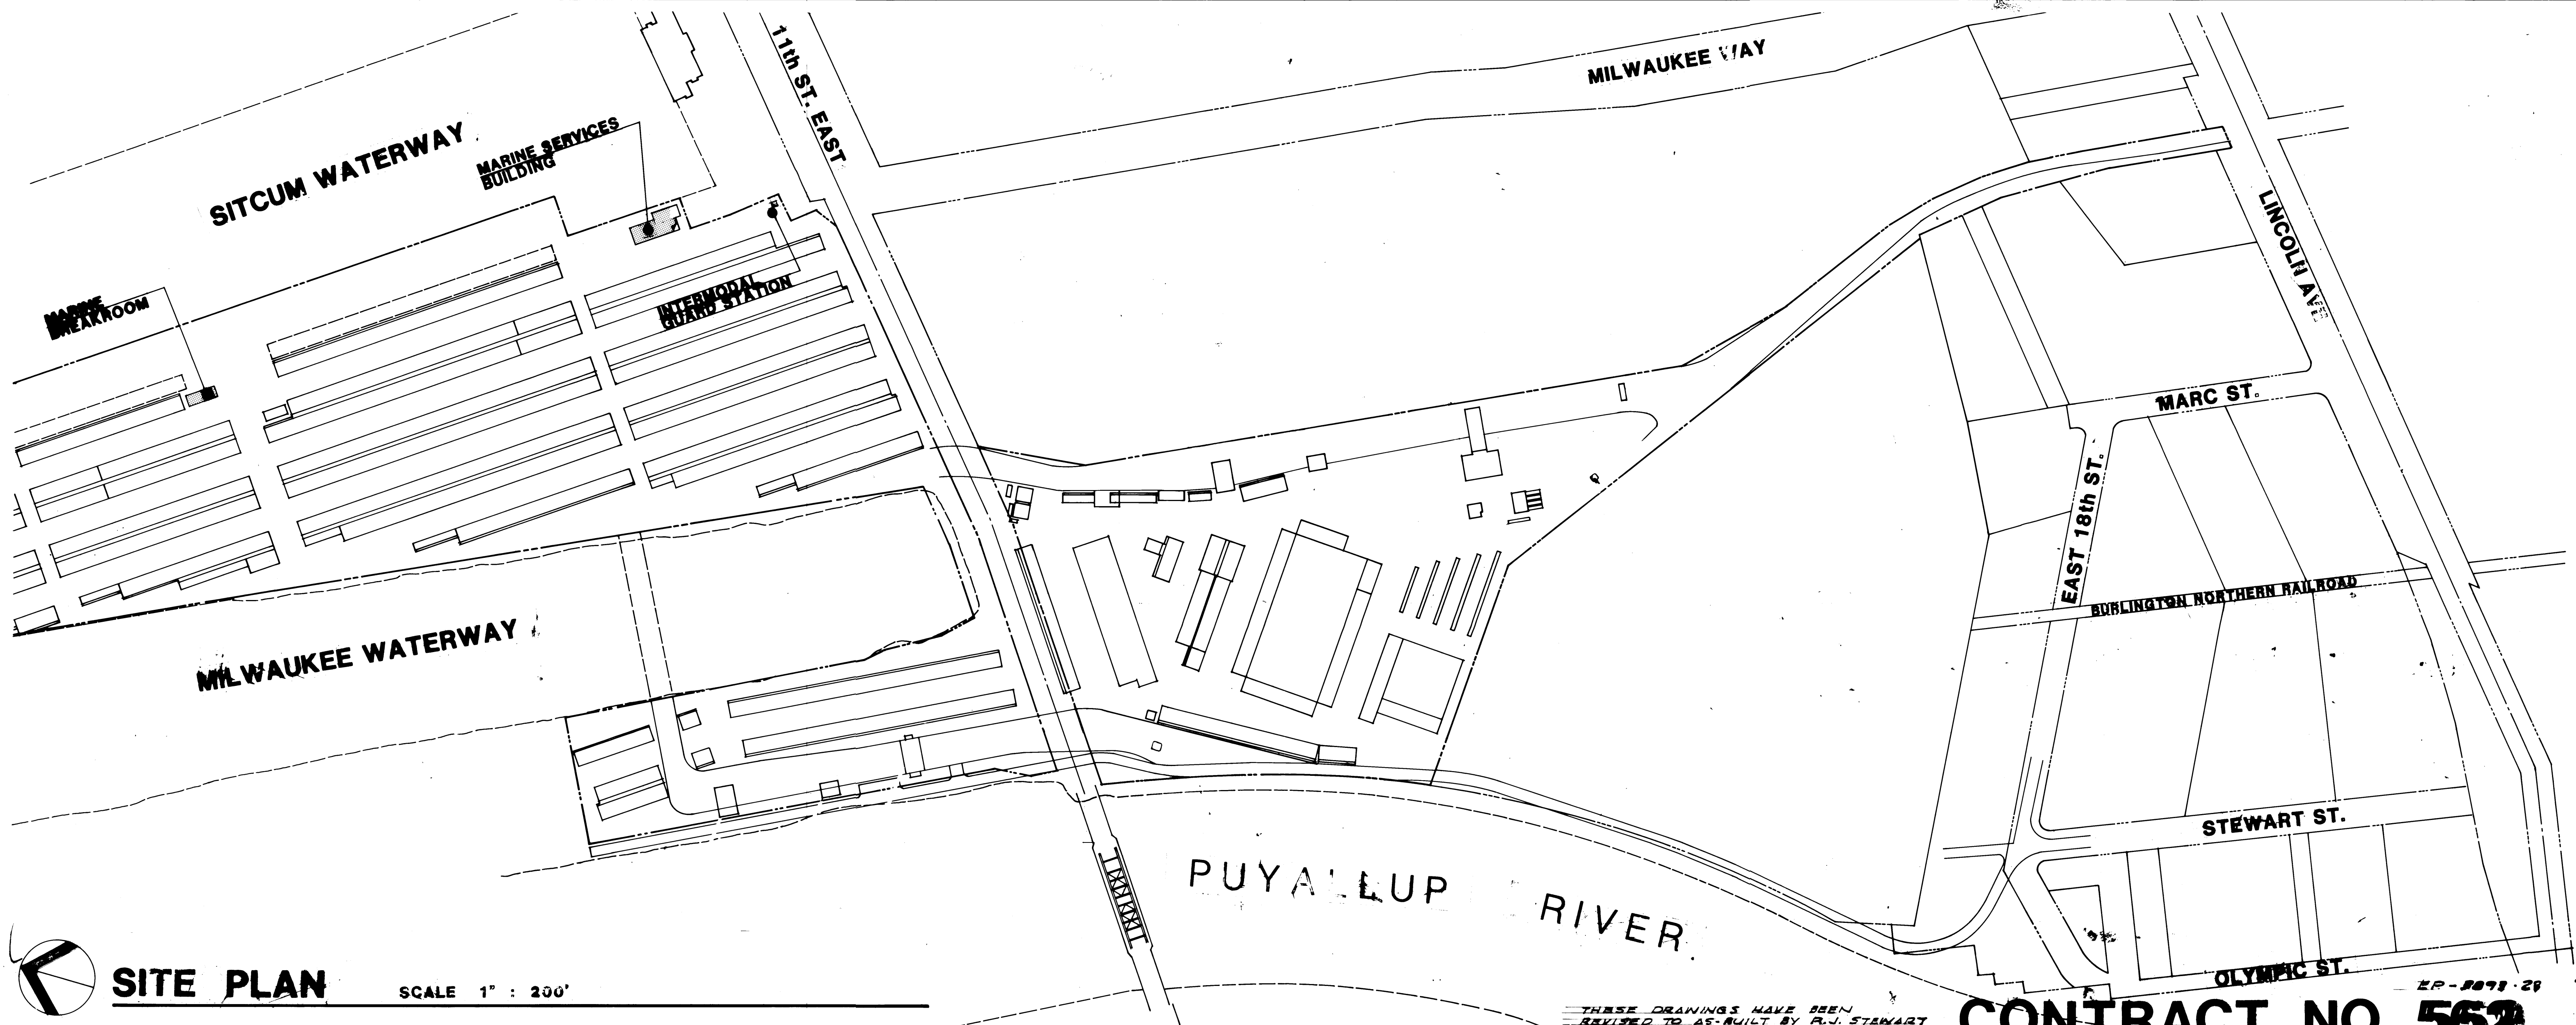

SITE PLAN

SCALE 1" = 200'

THESE DRAWINGS HAVE BEEN
REVISED TO AS-BUILT BY P.J. STAWART

CONTRACT NO. 562

EP-8893-29

INDEX OF DRAWINGS

MARINE SERVICES BUILDING

- 6-A11-1 First Floor Level Plan, 1/4" Scale Toilet/Locker Room
- 6-A11-2 Second Floor Level Plan, 1/4" Scale Toilet Room
- 6-A11-3 Third Floor Level Plan, Door & Frame Types
- 6-A11-4 Roof Plan, Window Types
- 6-A11-5 Exterior Elevations
- 6-A11-6 Building Sections
- 6-A11-7 Wall Sections
- 6-A11-8 Stair Plans & Sections
- 6-A11-9 First & Second Level Reflected Ceiling Plans
- 6-A11-10 Third Level Reflected Ceiling Plan & Elevator Plan & Section
- 6-A11-11 Interior Elevations
- 6-A11-12 Interior Elevations
- 6-A11-13 Interior Elevations & Cabinet Details

- 6-S11-1 Foundation Plan & Details
- 6-S11-2 Second Floor Framing Plan
- 6-S11-3 Third Floor & Roof Framing Plan

- 6-M11-1 Mechanical Foundation Plan
- 6-M11-2 First Floor Plumbing Plan
- 6-M11-3 Second & Third Floor Plumbing Plans
- 6-M11-4 Plumbing Riser Diagram
- 6-M11-5 First Floor Plan / HVAC
- 6-M11-6 First Floor Ceiling Plan / HVAC
- 6-M11-7 Second Floor Plan and Ceiling Plan / HVAC
- 6-M11-8 Third Floor Plan & Ceiling Plan / HVAC

- 6-E11-1 First Floor Lighting Plan
- 6-E11-2 Second & Third Floor Lighting Plans
- 6-E11-3 First Floor Power Plan
- 6-E11-4 Second & Third Floor Power Plans
- 6-E11-5 Load Calcs. / One Line Diagrams / System Riser Diagram

MARINE BREAKROOM BUILDING

- 6-A12-1 Floor Plan, Exterior Elevations, Building Sections, Door Frame, and Window Types
- 6-A12-2 1/4" Scale Toilet Room Plans, Interior Elevations
- 6-A12-3 Wall Sections, Roof Plan, and Reflected Ceiling Plan

- 6-S12-1 Foundation Plan, Roof Framing Plan, and Details

- 6-M12-1 Plumbing Plans
- 6-M12-2 HVAC Plans

- 6-E12-1 Lighting & Power Plans

INTERMODAL GUARD STATION

- 6-A13-1 Floor Plan, Reflected Ceiling Plan, Roof Plan, Exterior Elevations, Building Sections, Wall Section, Interior Elevations, Door, Frame and Window Types

- 6-S13-1 Structural Plans

- 6-E13-1 Lighting & Power Plans

BUILDING CODE DATA

- GOVERNING BUILDING CODE: Uniform Building Code 1982
- FIRE ZONE: None
- TYPE OF ZONING: M-3
- TYPE OF CONSTRUCTION:

Const.	Occupancy	Sq.Ft. Areas
Marine Services Building	SN	B-2, H-4 16,460 Sq.Ft.
Marine Breakroom	SN	B-2 2,400 Sq.Ft.
Interroom Guard Station	SN	B-2 140 Sq.Ft.
- TYPE OF FOUNDATIONS: Continuous and Spread Footings
- FIRE RESISTENCES REQUIRED:

1-Hour Between Occupancy	MSB
2-Hour Document Lift Shaft	MSB
1-Hour Elevator Shaft	MSB
- TYPES OF HEATING AND AIR CONDITIONING:

Marine Services Building	- Electric Infrared, Heat Pump, Variable
Marine Breakroom	- Heat Pump
Interroom Guard Station	- Resistance Electric
- DESIGN LOADS: See detail sheet 17/1, Paragraph 1.3 Design Criteria, Subparagraph A. for callouts.
- EARTHQUAKE LOADS: See detail sheet 17/2, Paragraph 1.3 Design Criteria, Subparagraph c(2) "Seismic...." for callouts.
- EARTH WEIGHTS AND PRESSURES: See Detail 17/2, Paragraph 1.4 "Soils Data" for callouts.
- FOUNDATIONS: Per Attached Report

KEY TO SYMBOLS



BUILDING SECTION



WALL SECTION



DIVISION NUMBER



DETAIL

SHEET NUMBER
SHOWN IN MANUAL

DOOR NUMBER

DOOR

HARDWARE GROUP

FRAME TYPE



ROOM NUMBER



ROOM FINISH NUMBER

APPEARS WHERE A CHANGE
OF MATERIAL OCCURS

FINISH SCHEDULE BOX

OPB OFFICE	FLOOR	BASE	WALL	CLG.
FINISH SCHEDULE	11	20	31	41

SCHEDULE NUMBER
DOT INDICATES ADDITIONAL
FINISHES



CABINET SCHEDULE




WINDOW BLIND LOCATION




2x4 STUD WALL W/
SOUND BATTS




STUD WALL

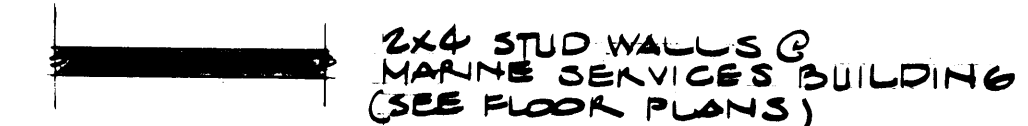

2x4 STUD WALLS @
MARINE SERVICES BUILDING
(SEE FLOOR PLANS)

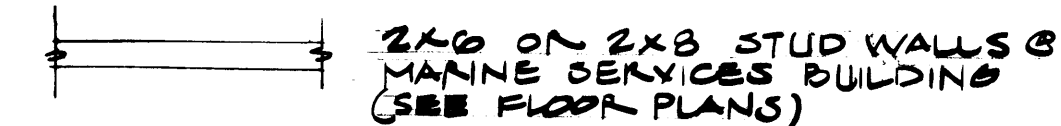

2x6 ON 2x8 STUD WALLS @
MARINE SERVICES BUILDING
(SEE FLOOR PLANS)

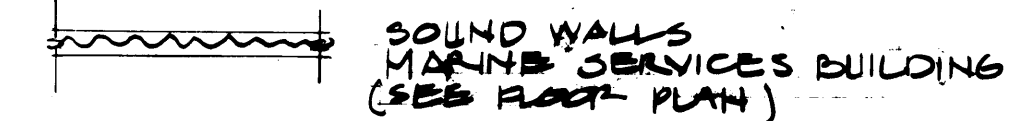

SOUND WALLS
MARINE SERVICES BUILDING
(SEE FLOOR PLAN)


McGRANAHAN,
MESSENGER
ASSOCIATES

ARCHITECTURE / PLANNING / INTERIORS


MEMBER AMERICAN INSTITUTE OF ARCHITECTS • 190 (AWCET), SUITE 300, TACOMA, WA 98402 • (206) 383-3004

MARK	REVISION	BY	APP.	DATE
	BUILT AS SHOWN	R.J.S.		8-22-05

DRAWN _____	DATE 9-21-04	PORT OF TACOMA TACOMA TERMINALS, INC. INDEX TO DRAWINGS BUILDING CODE DATA KEY TO SYMBOLS
CHECKED _____	DATE _____	
CHECKED _____	DATE _____	
CHECKED _____	DATE _____	
CONT. NO. 382	FIELD BOOK (S) _____	SCALE NONE
APPROVED _____	DATE 9/24/04	DRAWING NO. EP-3893-23
PROJECT MANAGER _____	DATE _____	6-AO-1
CHIEF ENGINEER _____	DATE _____	1

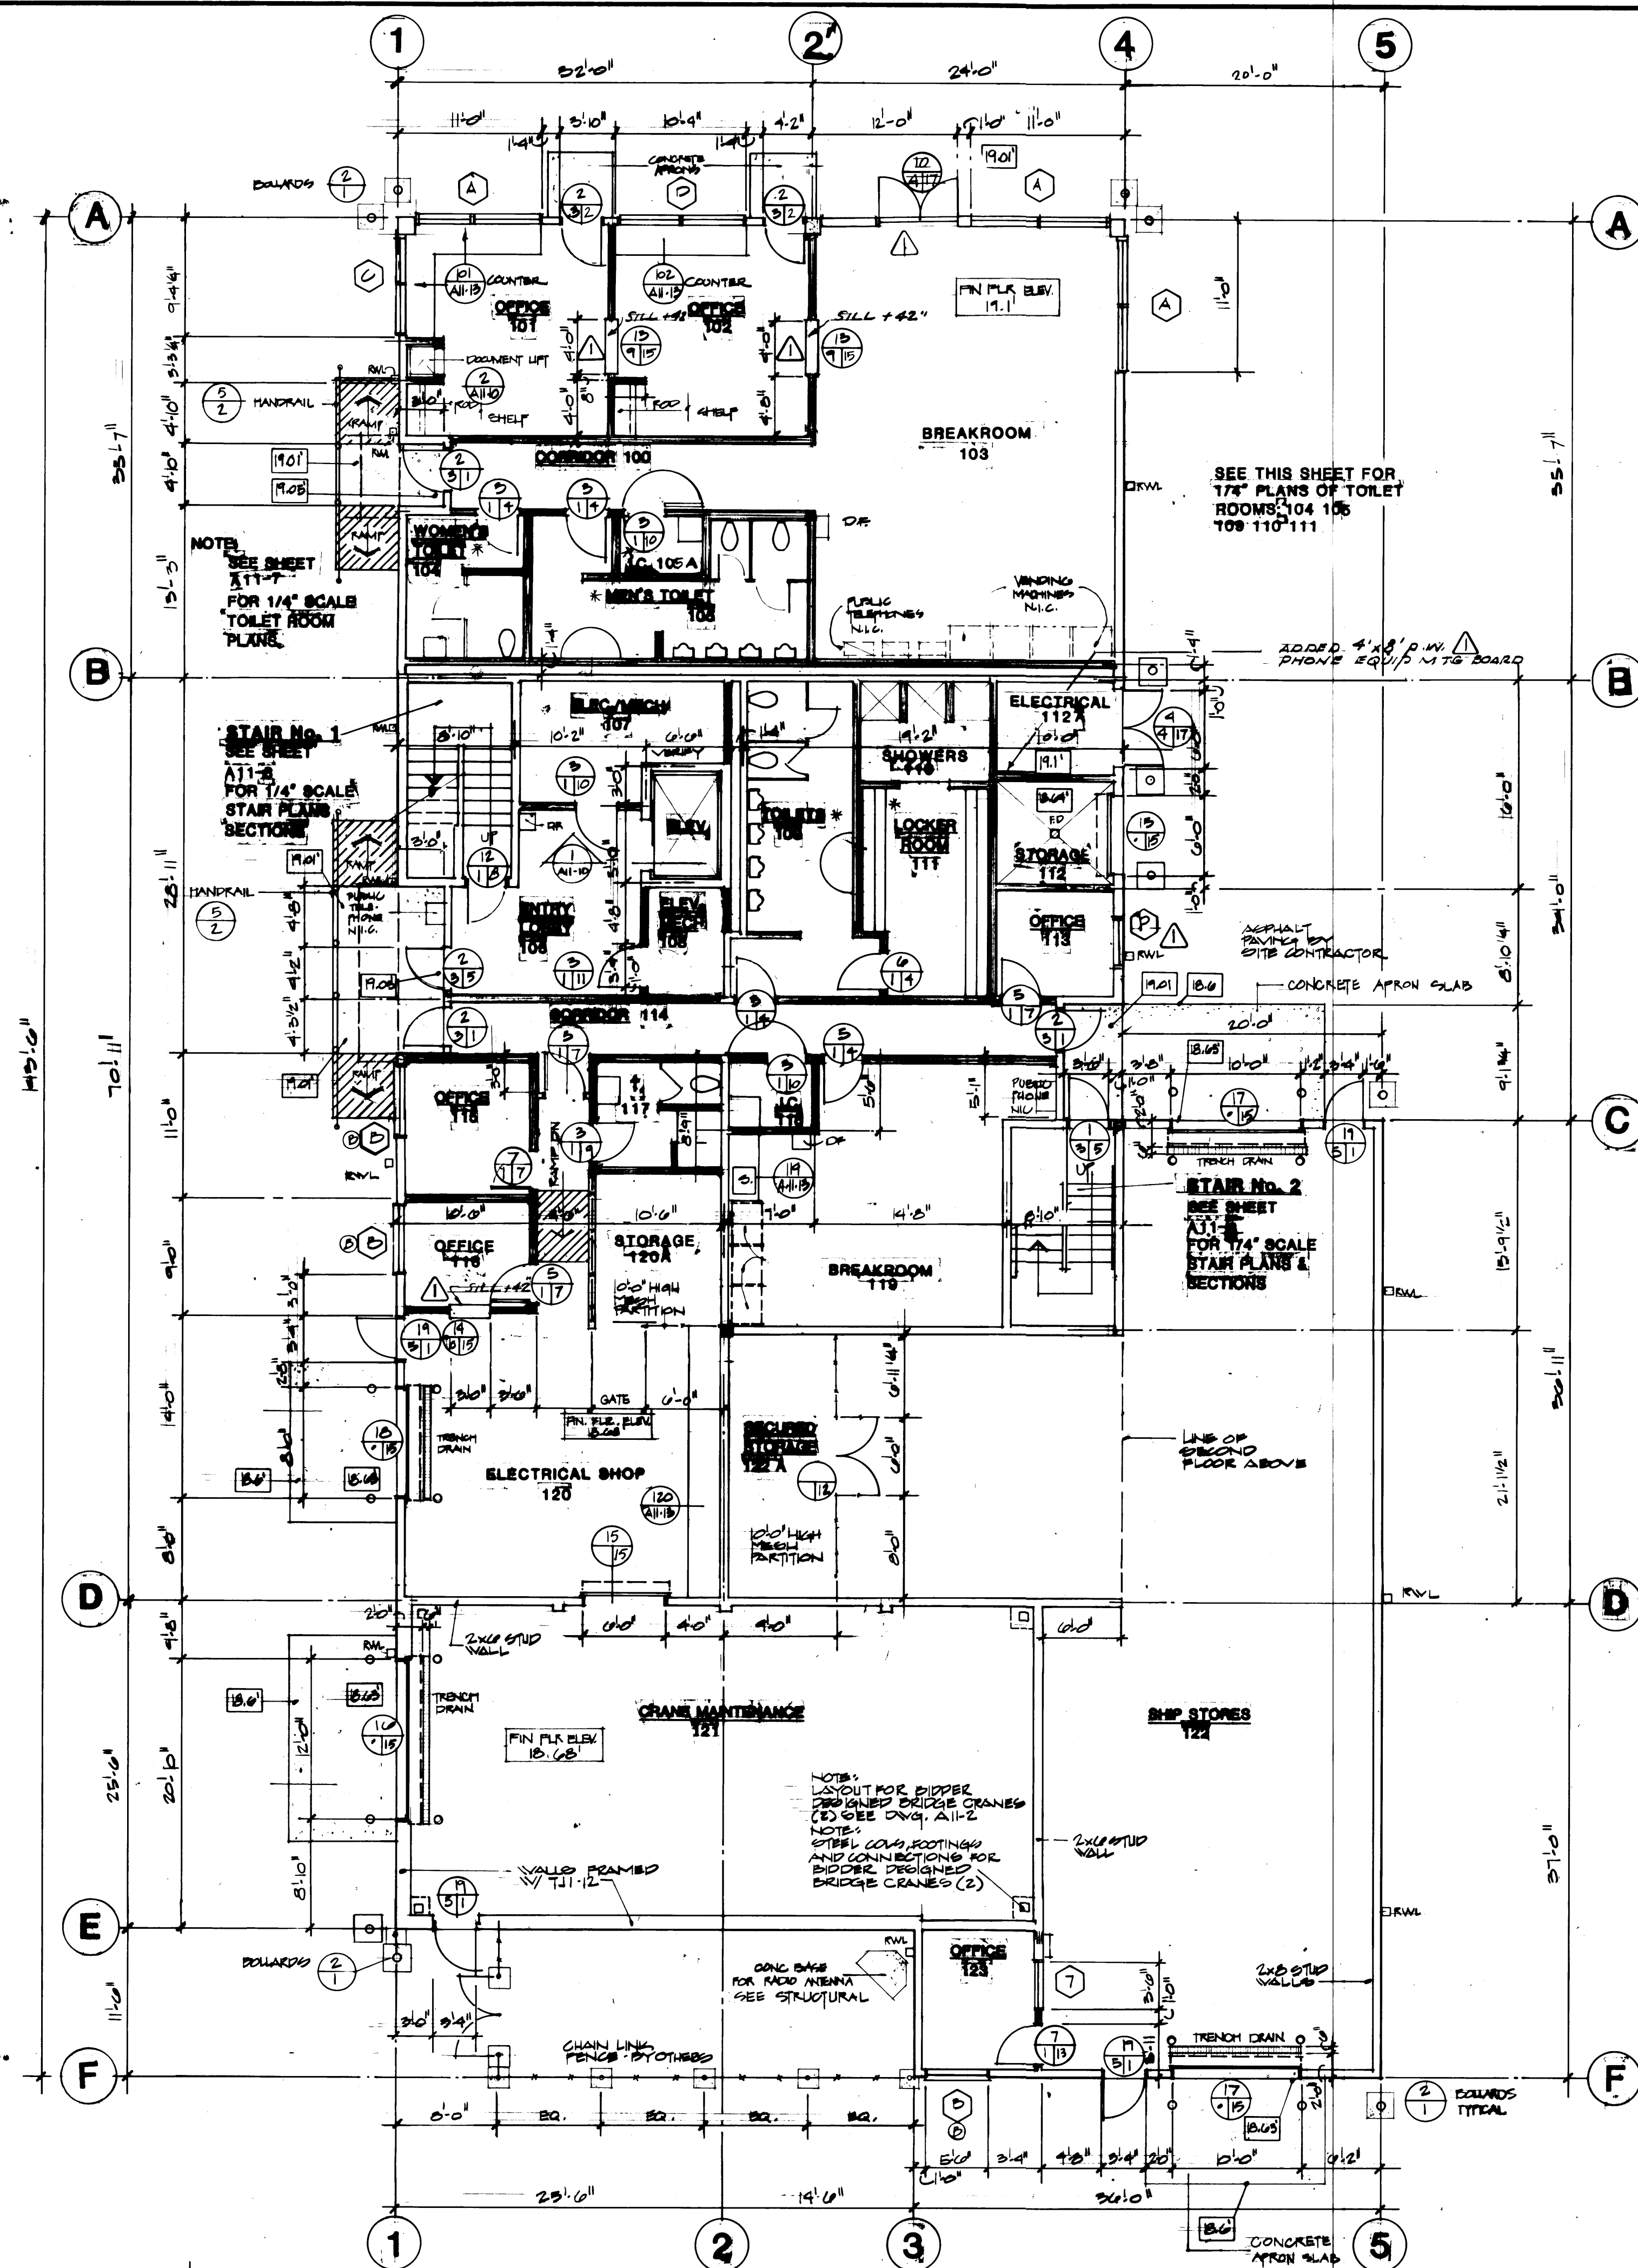


FIRST FLOOR LEVEL
SCALE 1/8" = 1'-0"

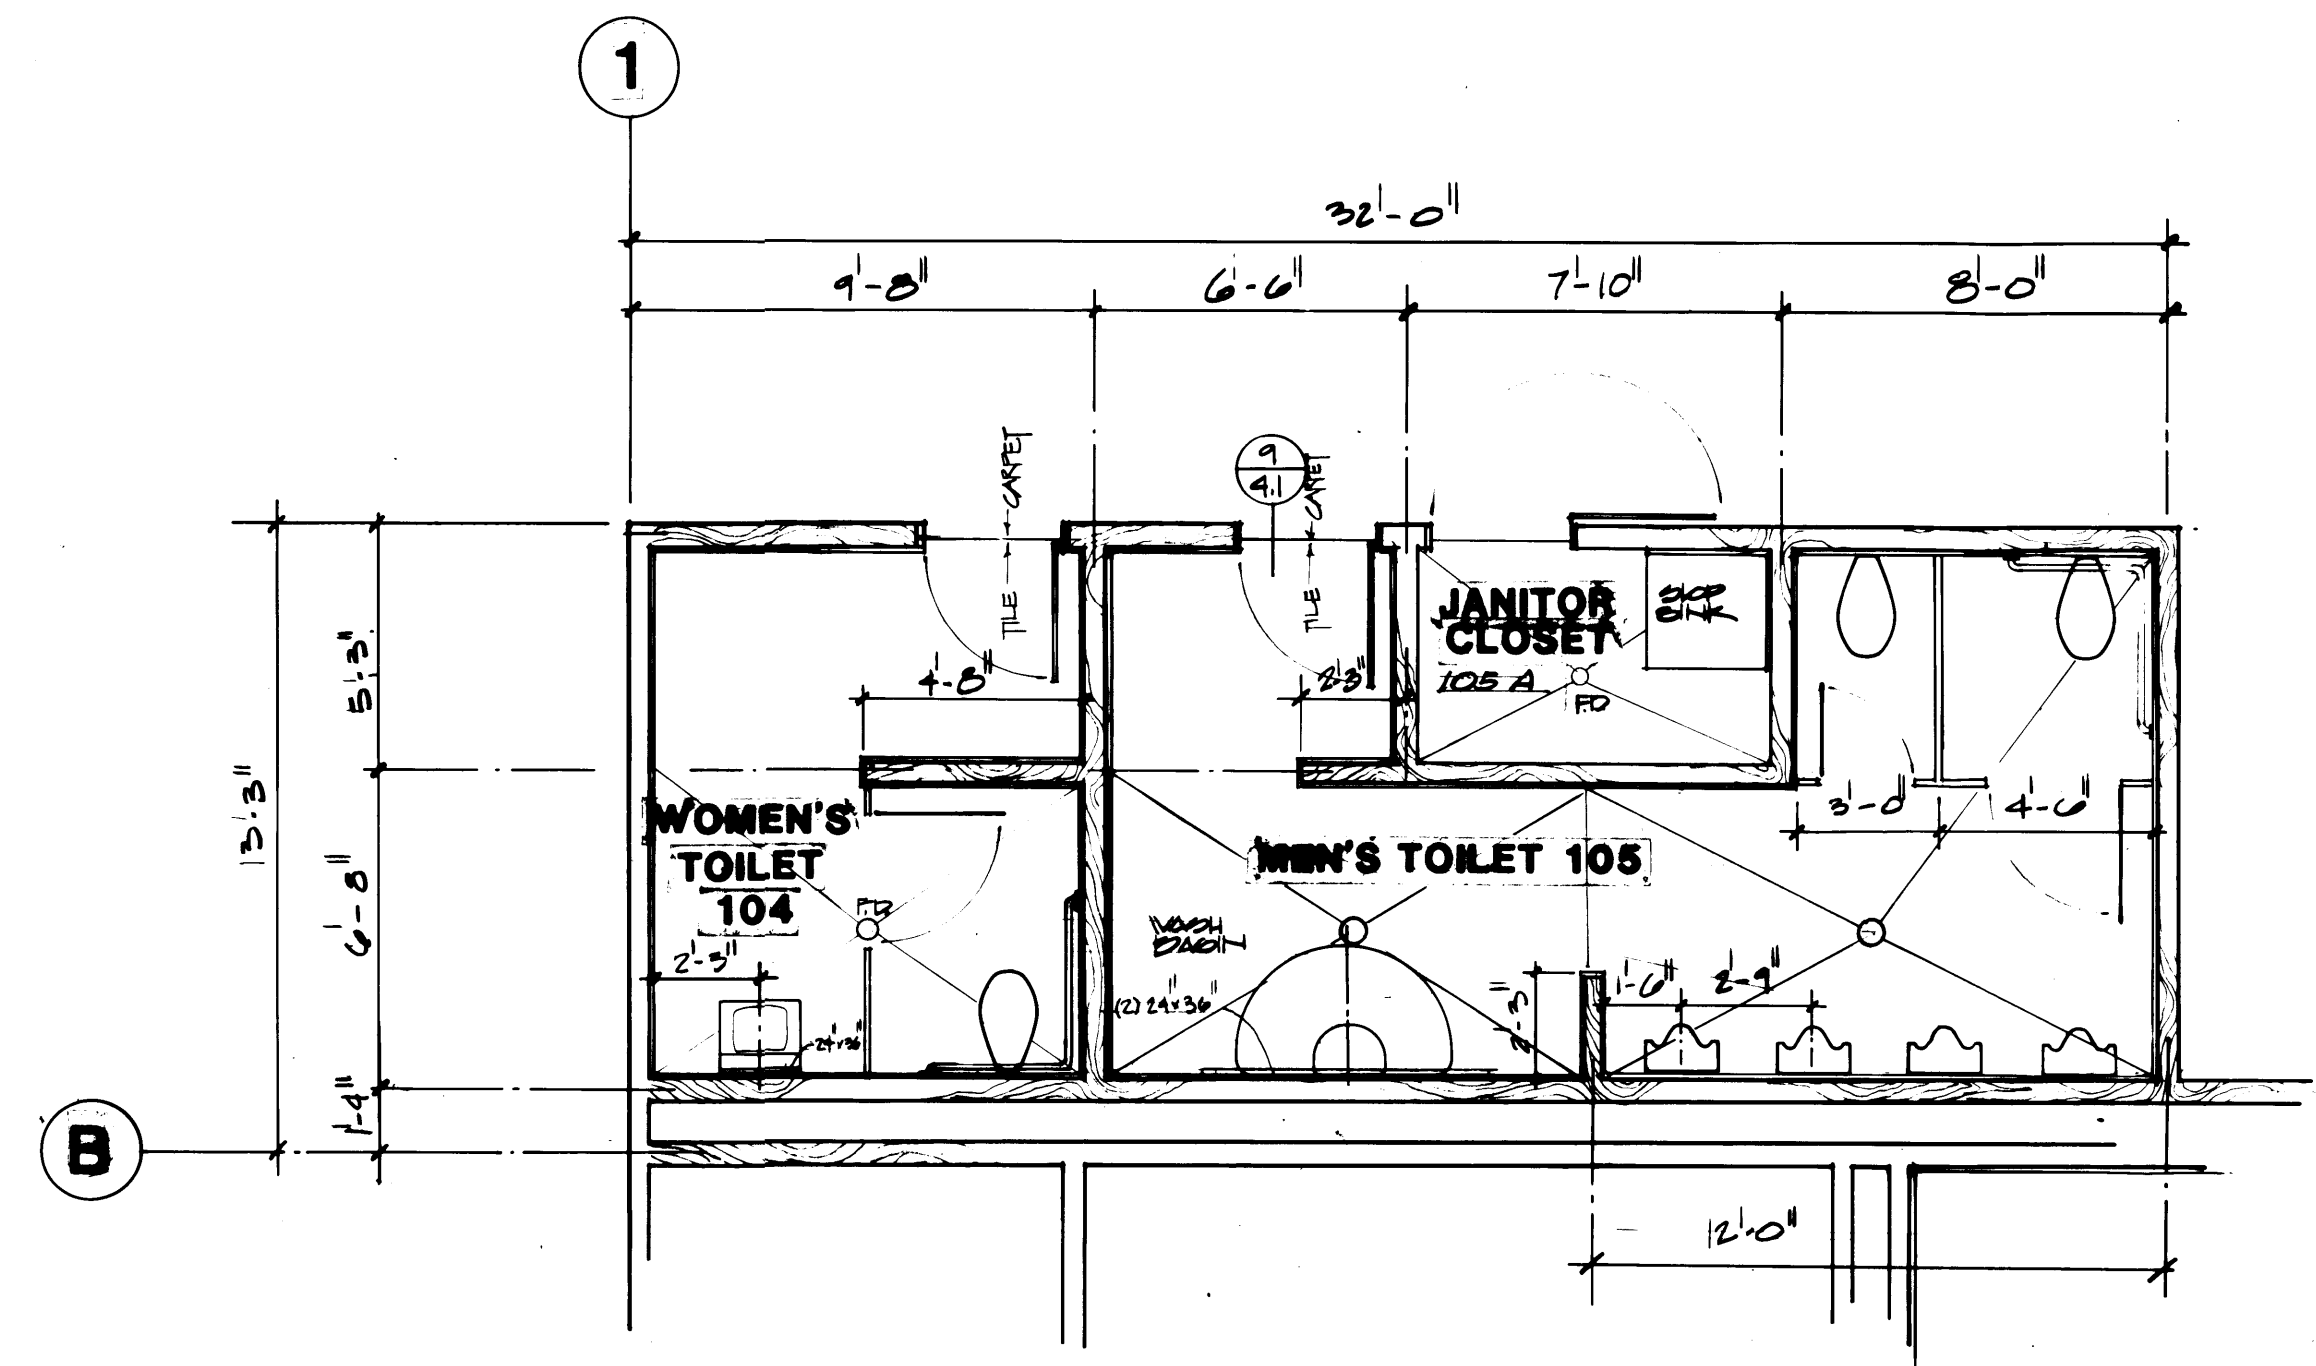

TOILET ROOM FLOOR PLAN
SCALE 1/4" = 1'-0"

ALL LAVATORY DRAIN LINES
HERE INSULATED TO COMPLY
WITH HANDICAPPED CODE

FIRE TAPED
GYPSUM BOARD & FRAMING WAS
EXTENDED TO UNDERSIDE OF
FLOOR AND ROOF DECK ABOVE AS
REQUIRED BY CITY OF TACOMA
BUDG. DEPT.

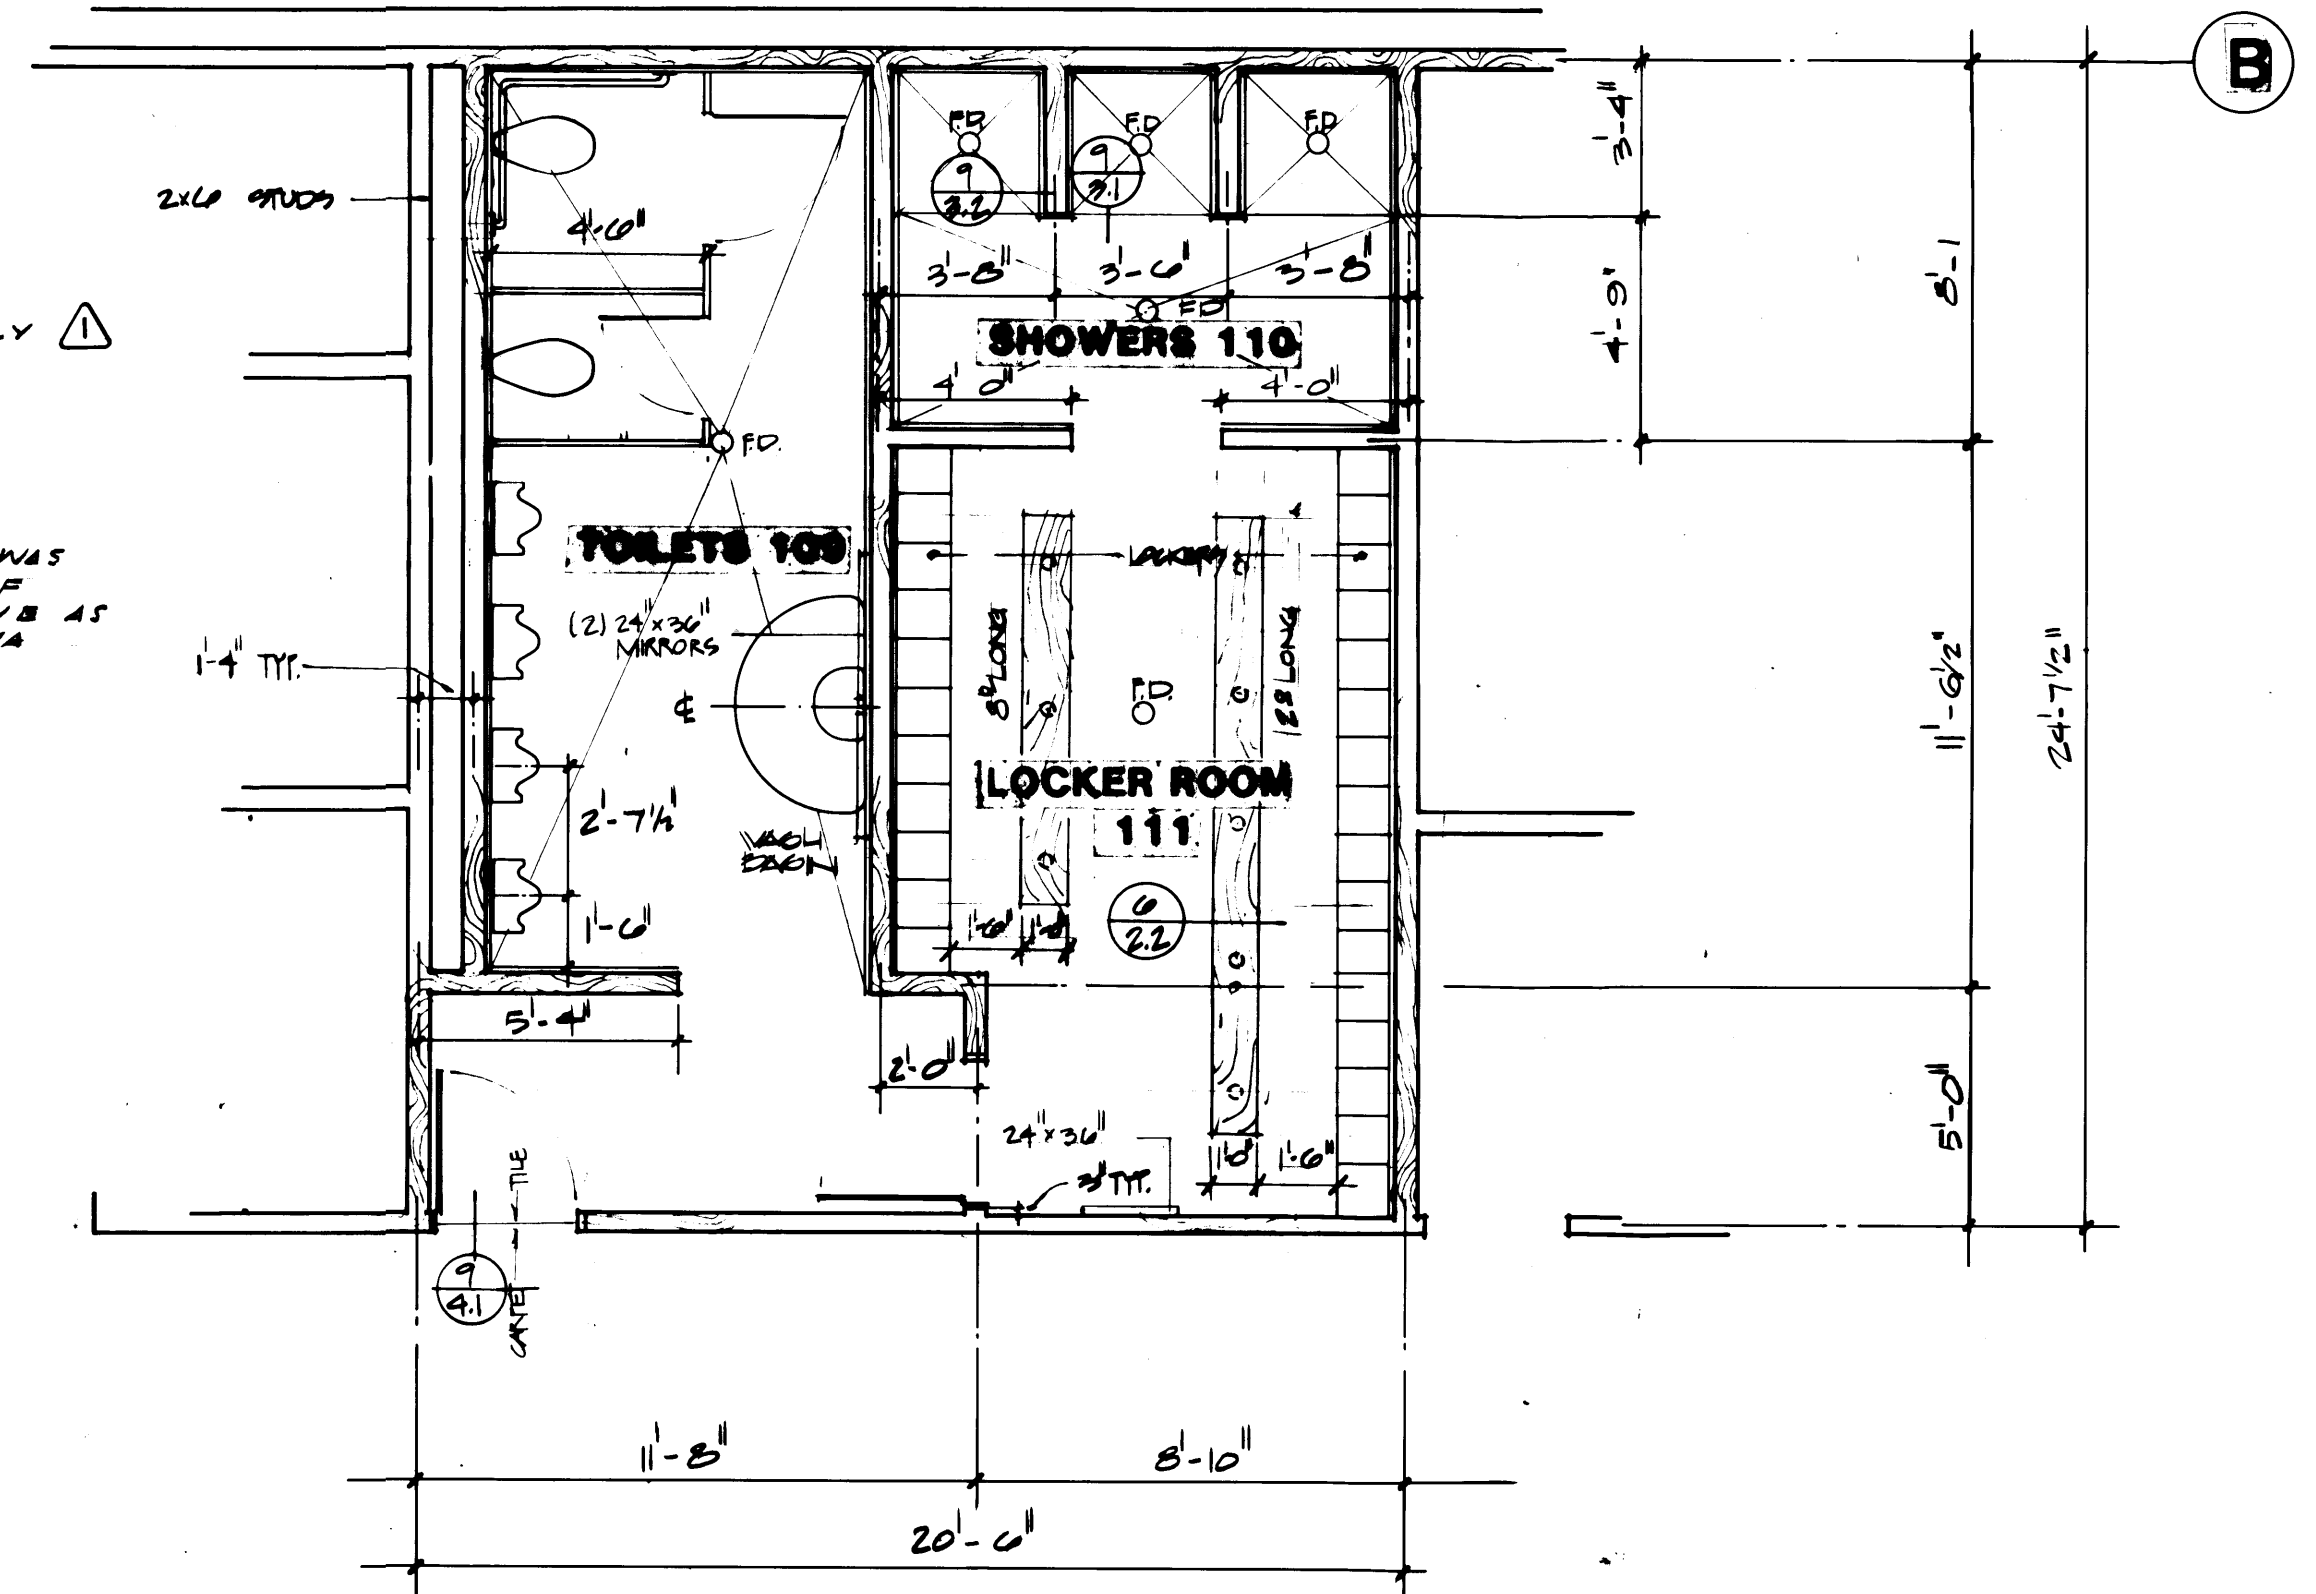


TOILET/LOCKER/SHOWER ROOM FLOOR PLAN
SCALE 1/4" = 1'-0"

1593 REGISTERED ARCHITECT JAMES A. MCGRANAHAN STATE OF WASHINGTON	2618 REGISTERED ARCHITECT LYN H. MESSENGER STATE OF WASHINGTON
---	--


**MCGRANAHAN,
MESSENGER
ASSOCIATES**
ARCHITECTURE / PLANNING / INTERIORS
MEMBER AMERICAN INSTITUTE OF ARCHITECTS • 1950 AVENUE, SUITE 300 TACOMA, WA 98402 • (206) 343-3344

REVISION	BY	APP.	DATE
REVISED TO AS-BUILT	A.J.S.		4/22/85


DRAWN M.G./D.P. DATE 9/14/84 CHECKED _____ DATE _____ CHECKED _____ DATE _____ CONT. NO. 882		PORT OF TACOMA TACOMA TERMINALS, INC. MARINE SERVICES BUILDING FIRST FLOOR LEVEL	
FIELD BOOK (S) APPROVED _____ PROJECT MANAGER CHIEF ENGINEER		SCALE AS NOTED EP-3883-23 6-A11-1 SHEET 111-1 OF 111	

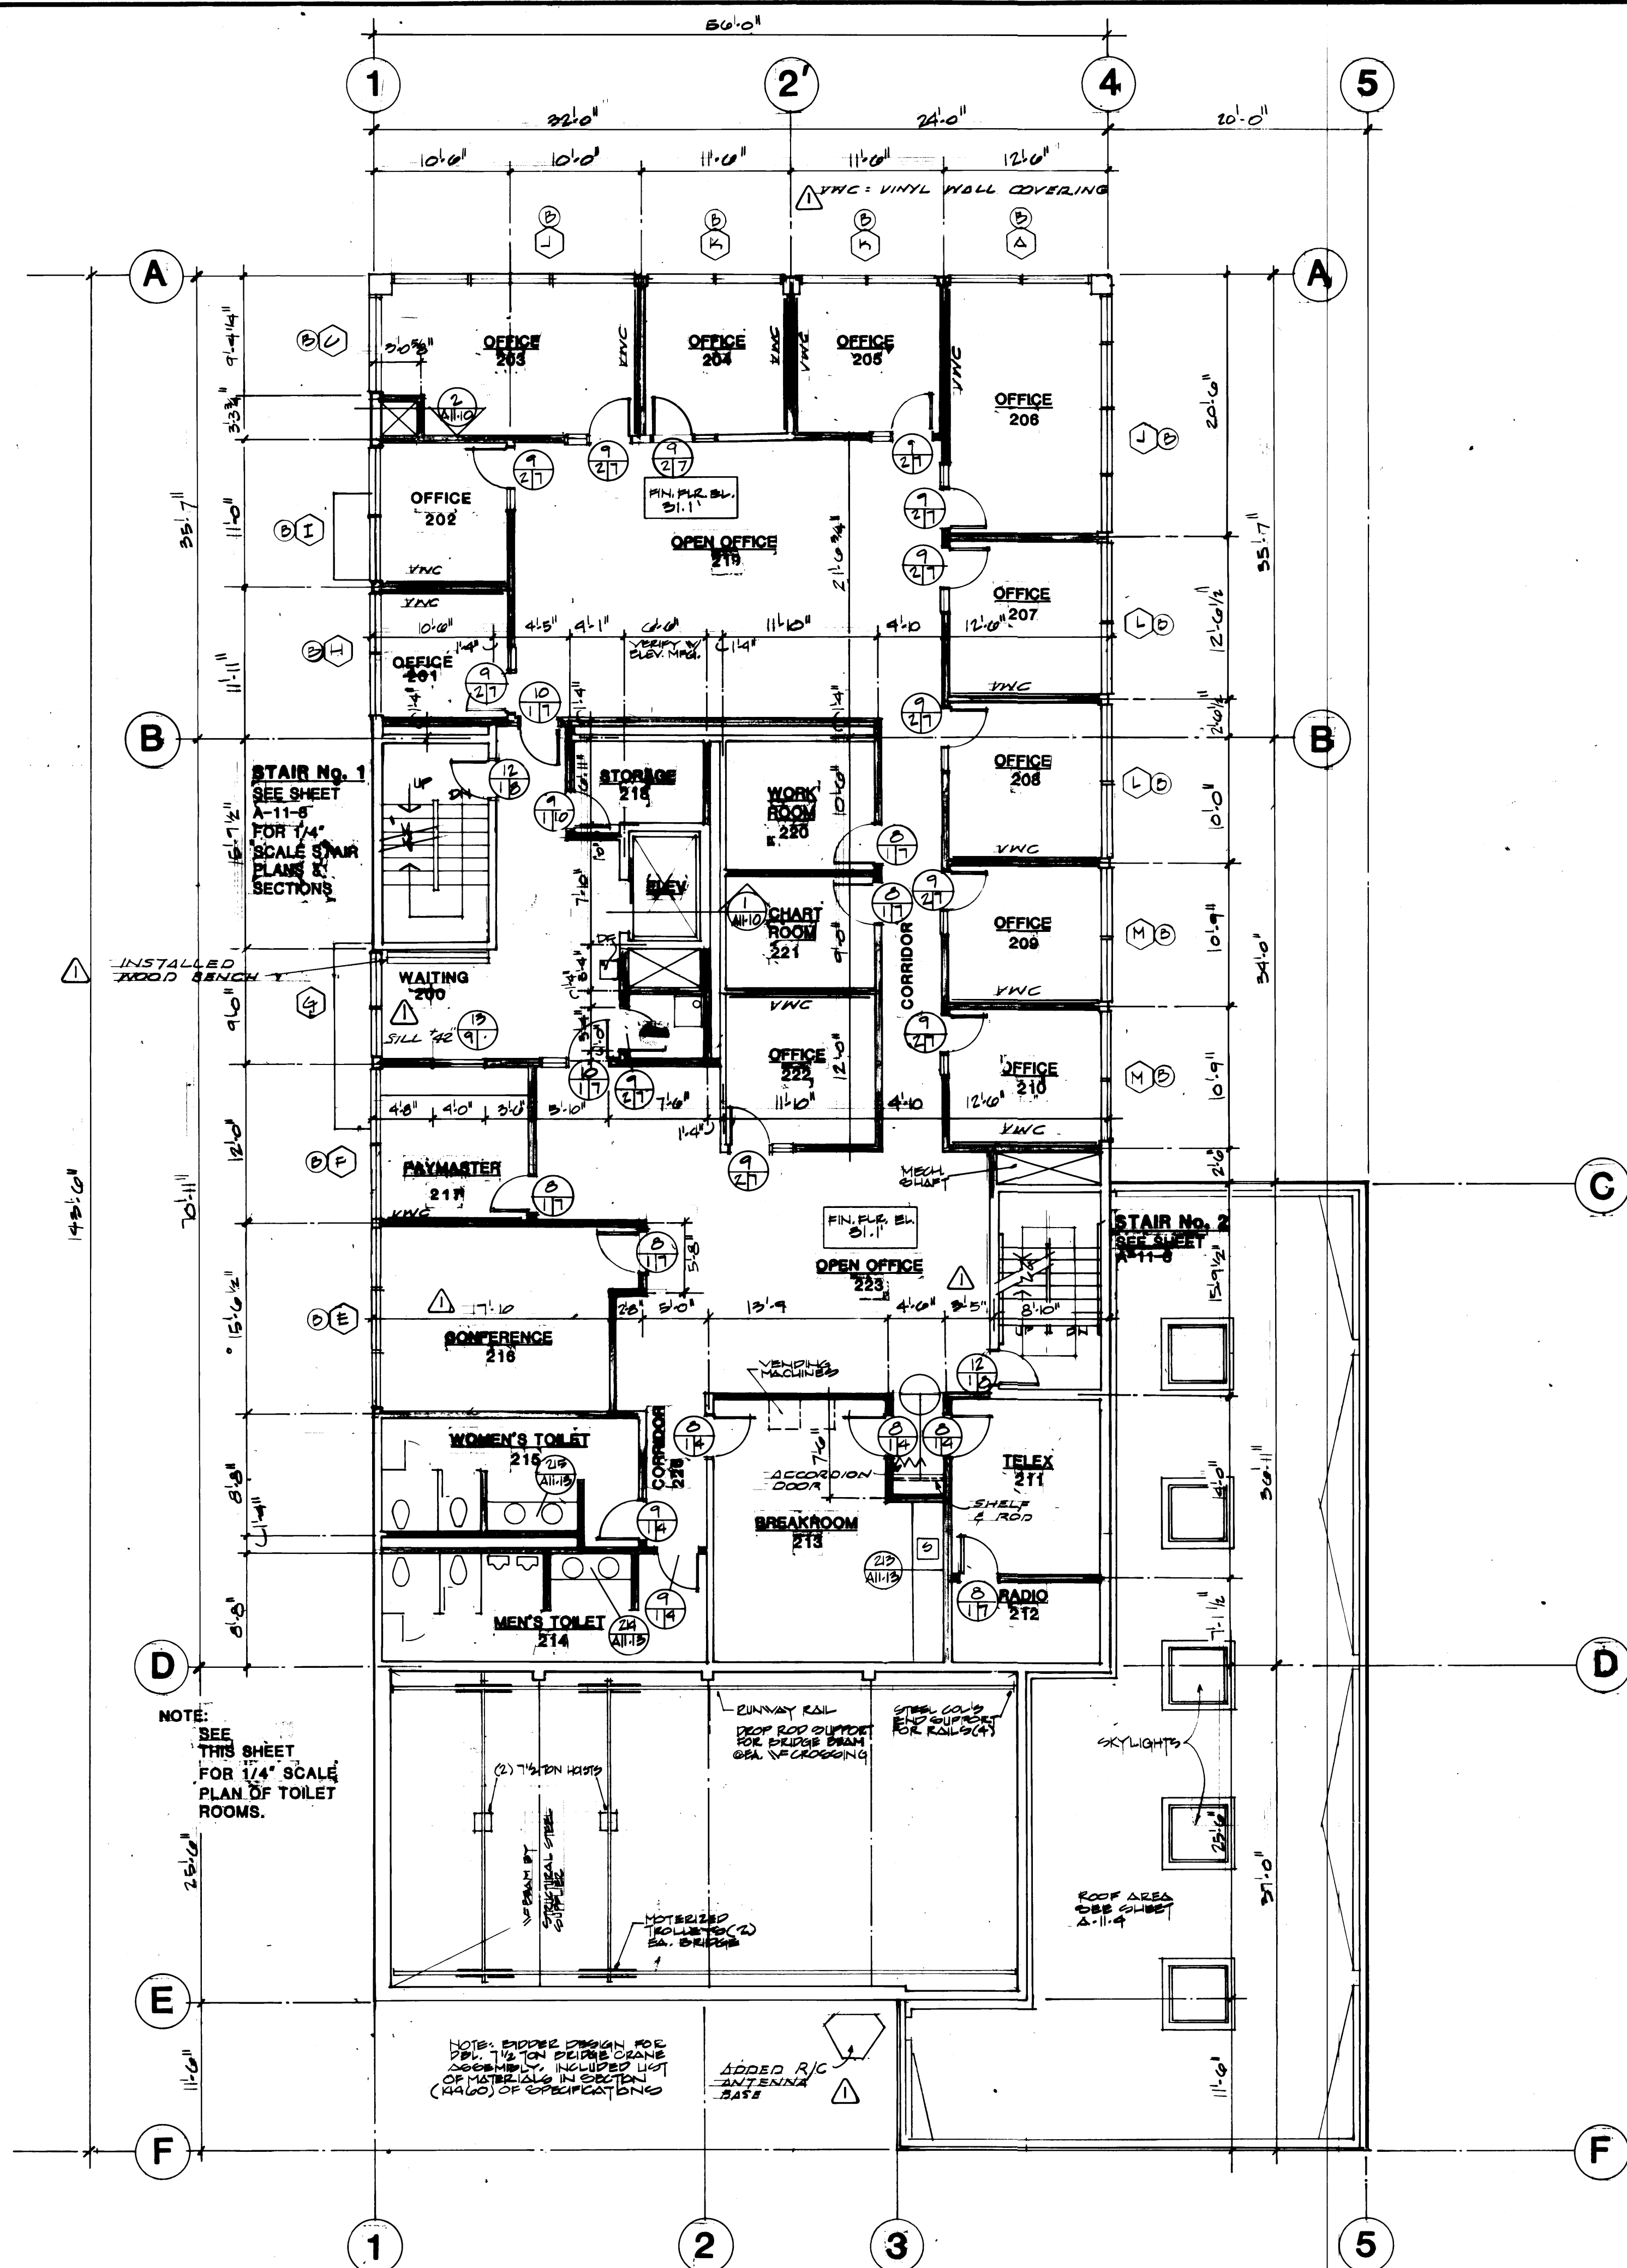


SECOND FLOOR LEVEL
SCALE 1/8" = 1'-0"

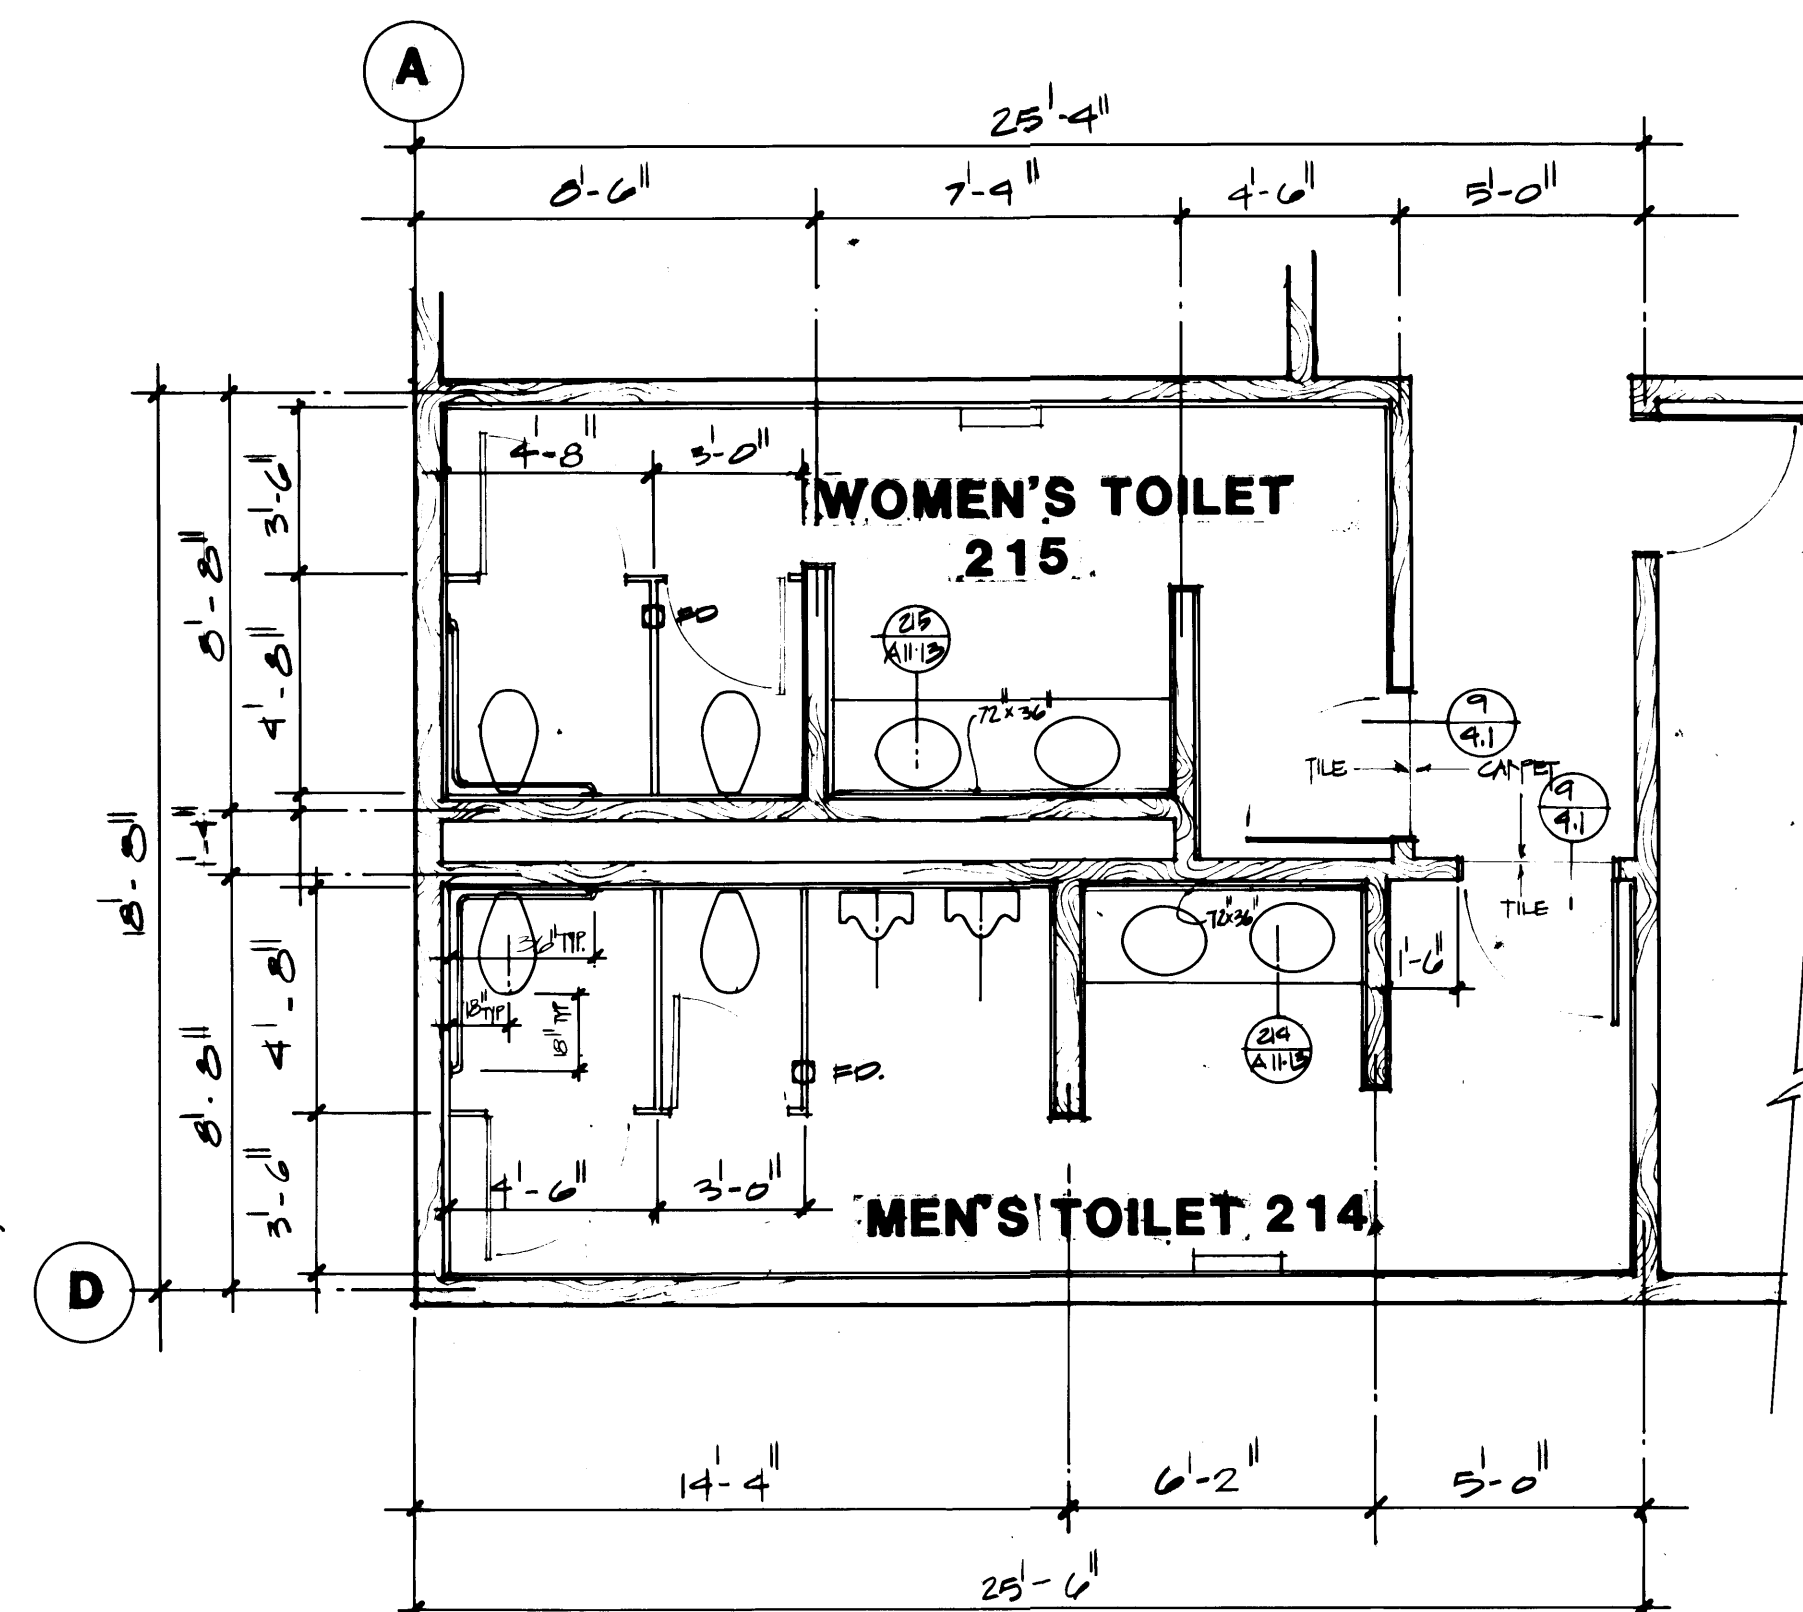


TOILET ROOM PLANS ROOMS 214 and 215
SCALE 1/4" = 1'-0"

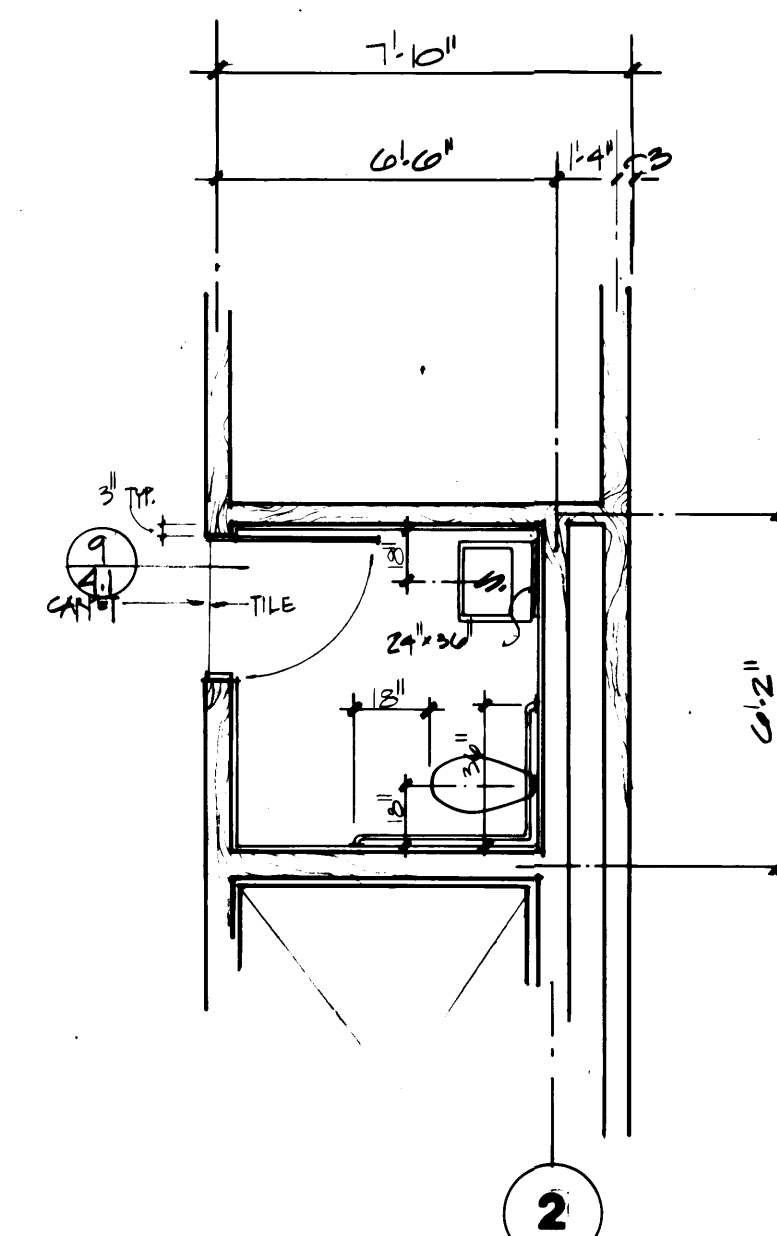

TOILET ROOM PLAN ROOM 303
SCALE 1/4" = 1'-0"

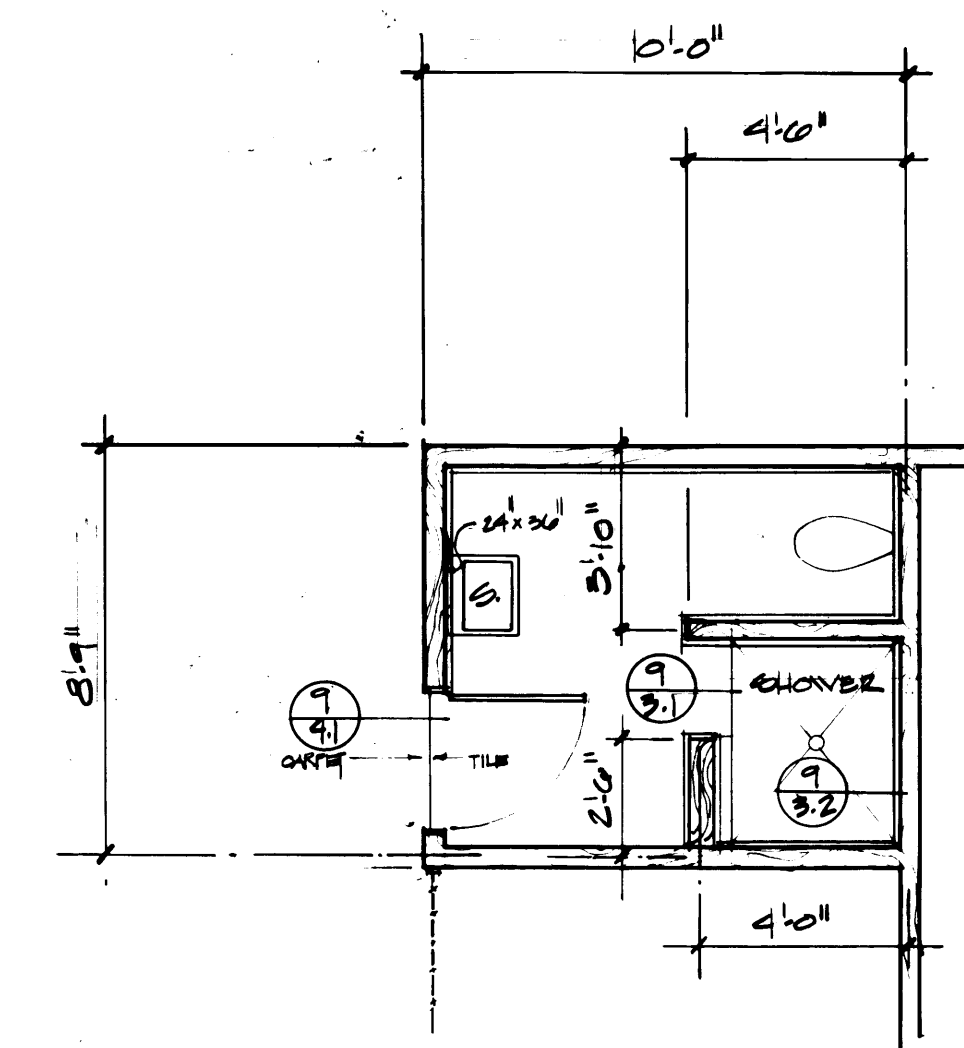


TOILET ROOM PLAN ROOM 117
SCALE 1/4" = 1'-0"

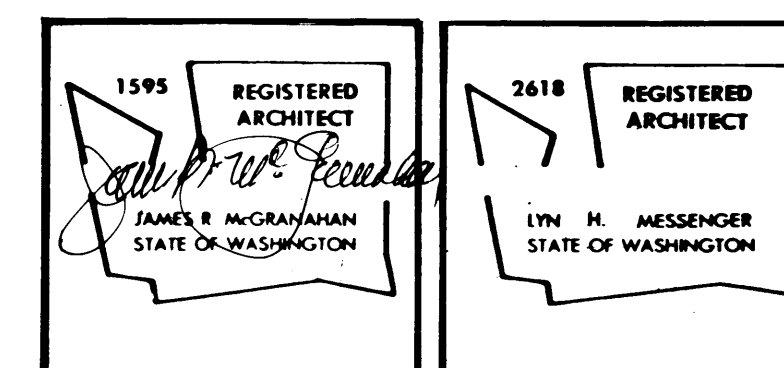


McGRANAHAN, MESSENGER ASSOCIATES
ARCHITECTURE / PLANNING / INTERIORS
MEMBER AMERICAN INSTITUTE OF ARCHITECTS • 9501 FAWCETT BLVD. SUITE 300 TACOMA, WA 98402 • (206) 363-3004

REVISION	BY	APP.	DATE
REVISED TO AS BUILT	R.J.S.		8-22-89


DRAWN: M.G./D.J.E. DATE: 7/18/84		PORT OF TACOMA	
CHECKED: _____ DATE: _____		TACOMA TERMINALS, INC.	
CHECKED: _____ DATE: _____		MARINE SERVICES BUILDING	
CONT. NO. 582		SECOND FLOOR LEVEL	
FIELD BOOK (S)		SCALE: AS NOTED	
APPROVED: _____ PROJECT MANAGER: _____ DATE: 9/24/84		DRAWING NO. EP-3893-23	
CHIEF ENGINEER: _____ DATE: _____		SHEET A11-2 OF 13	

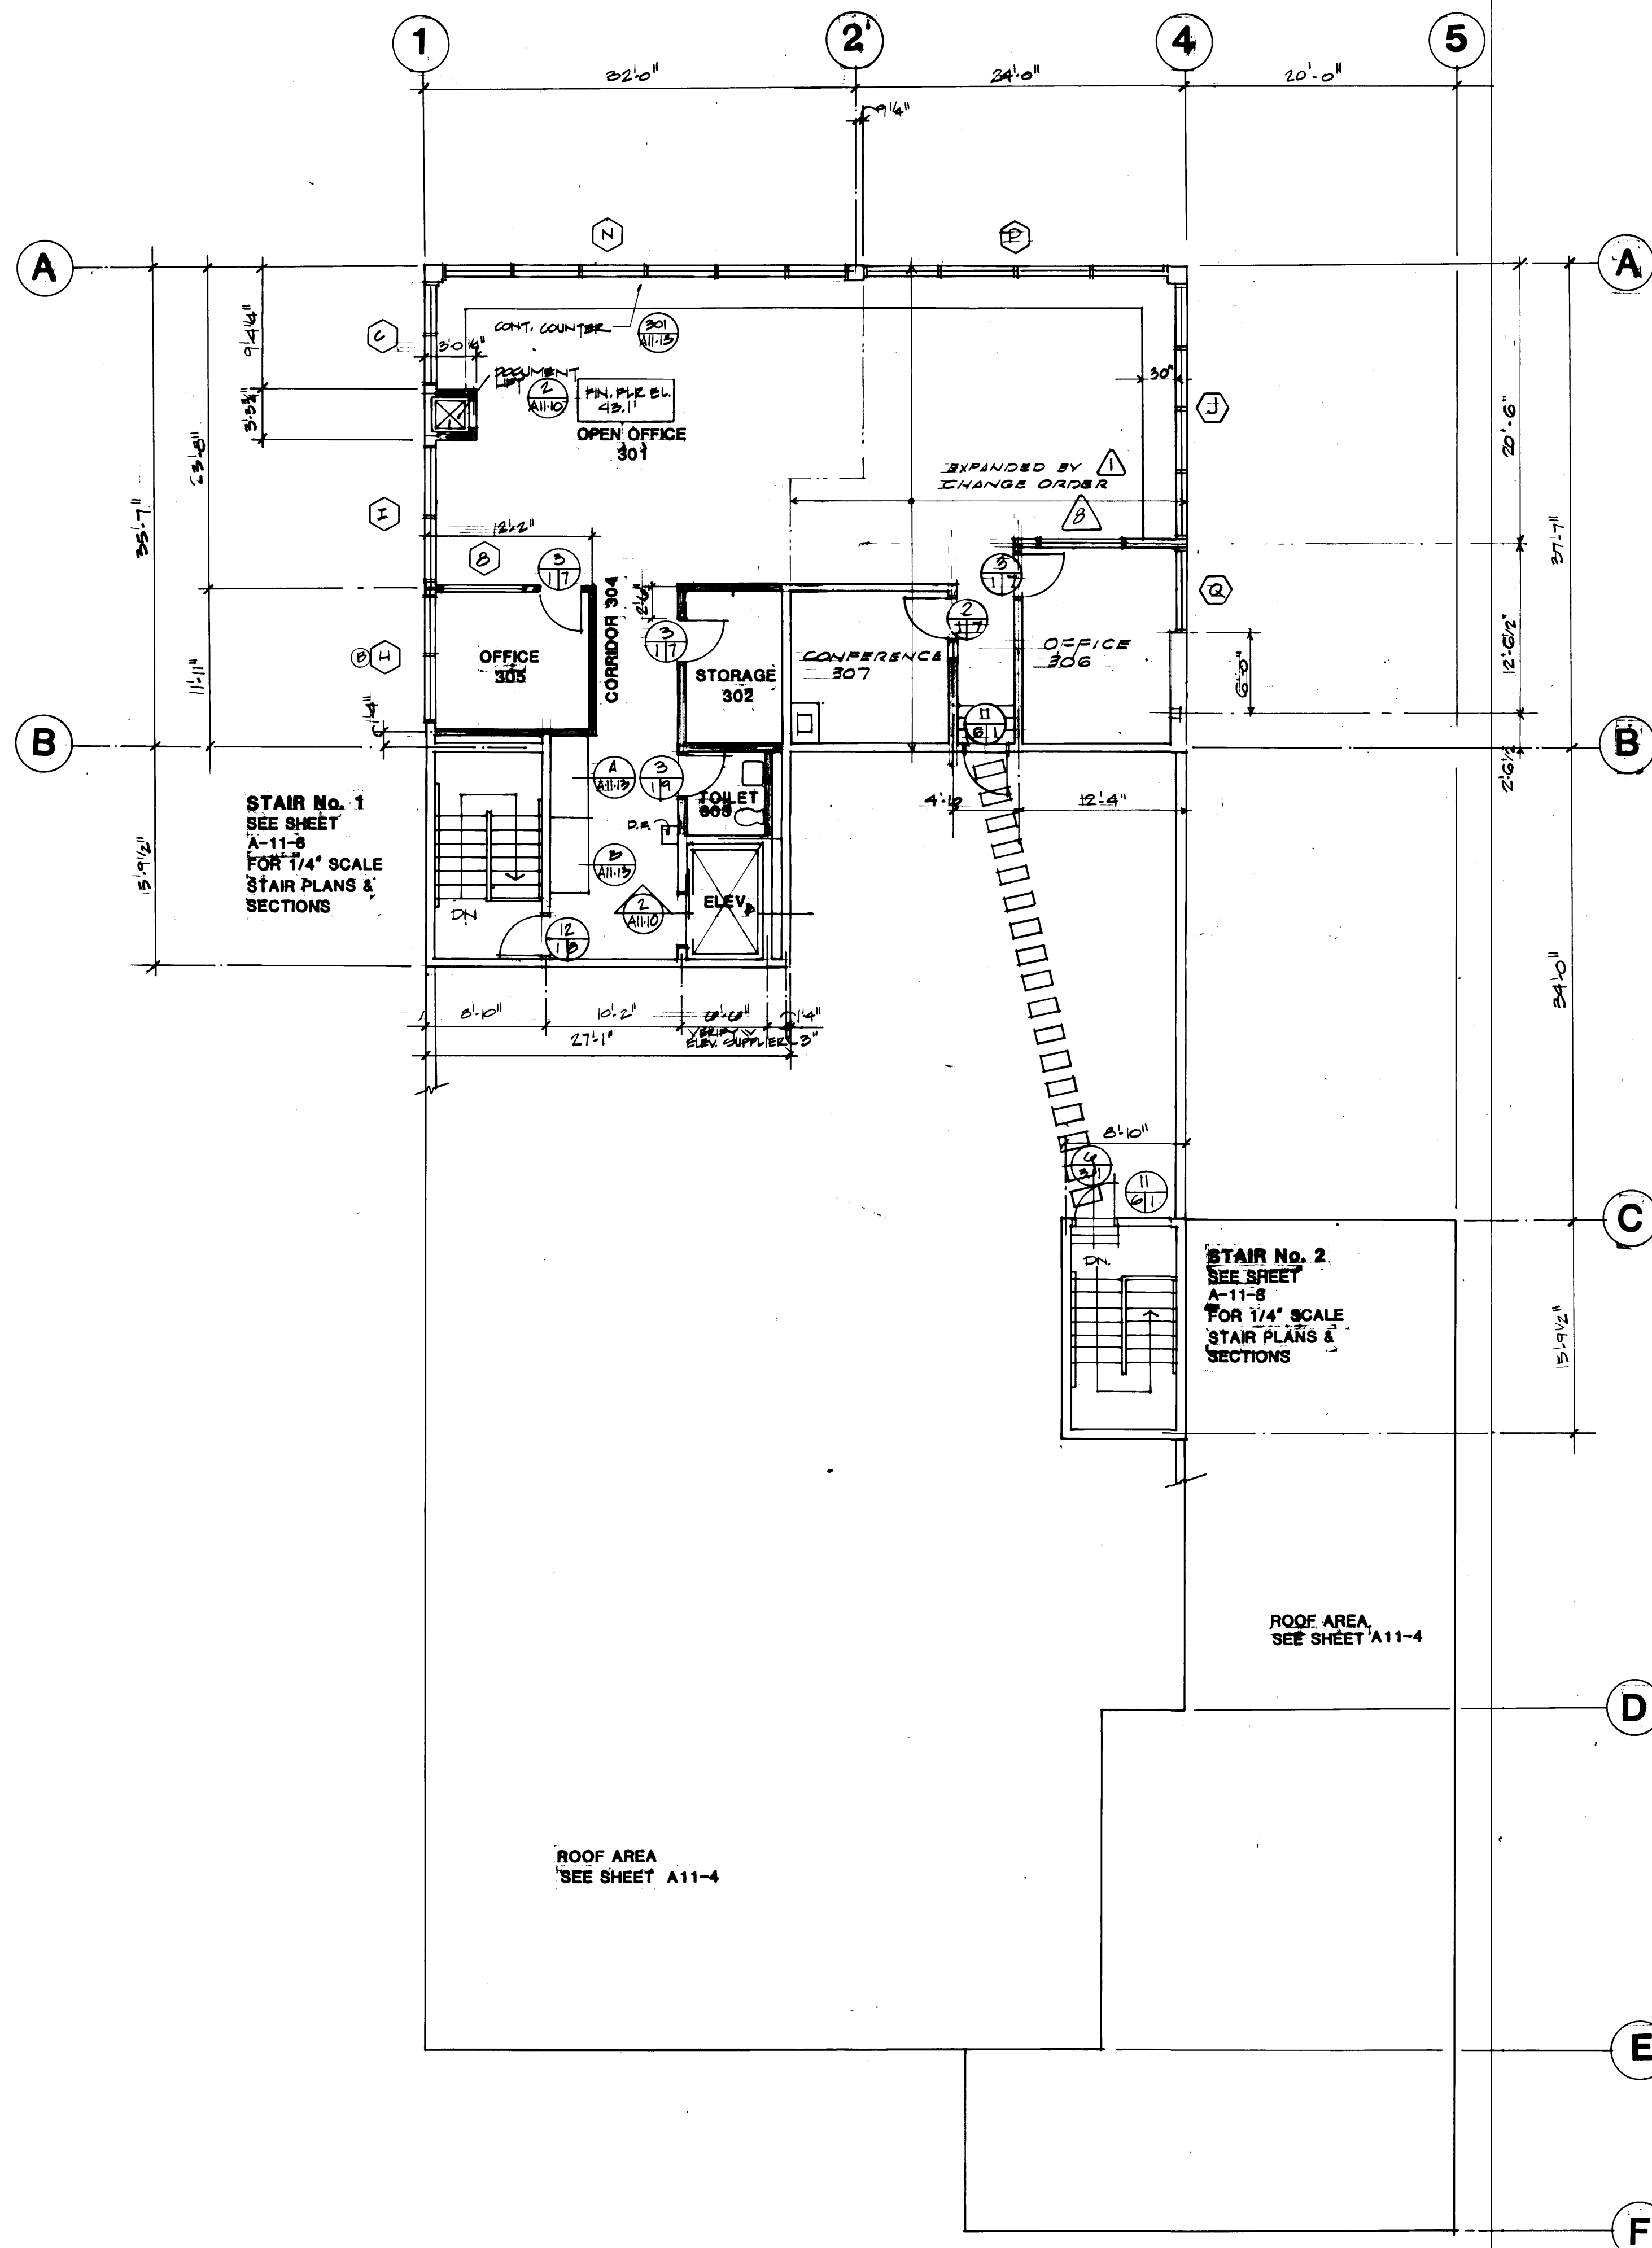

DOOR TYPES

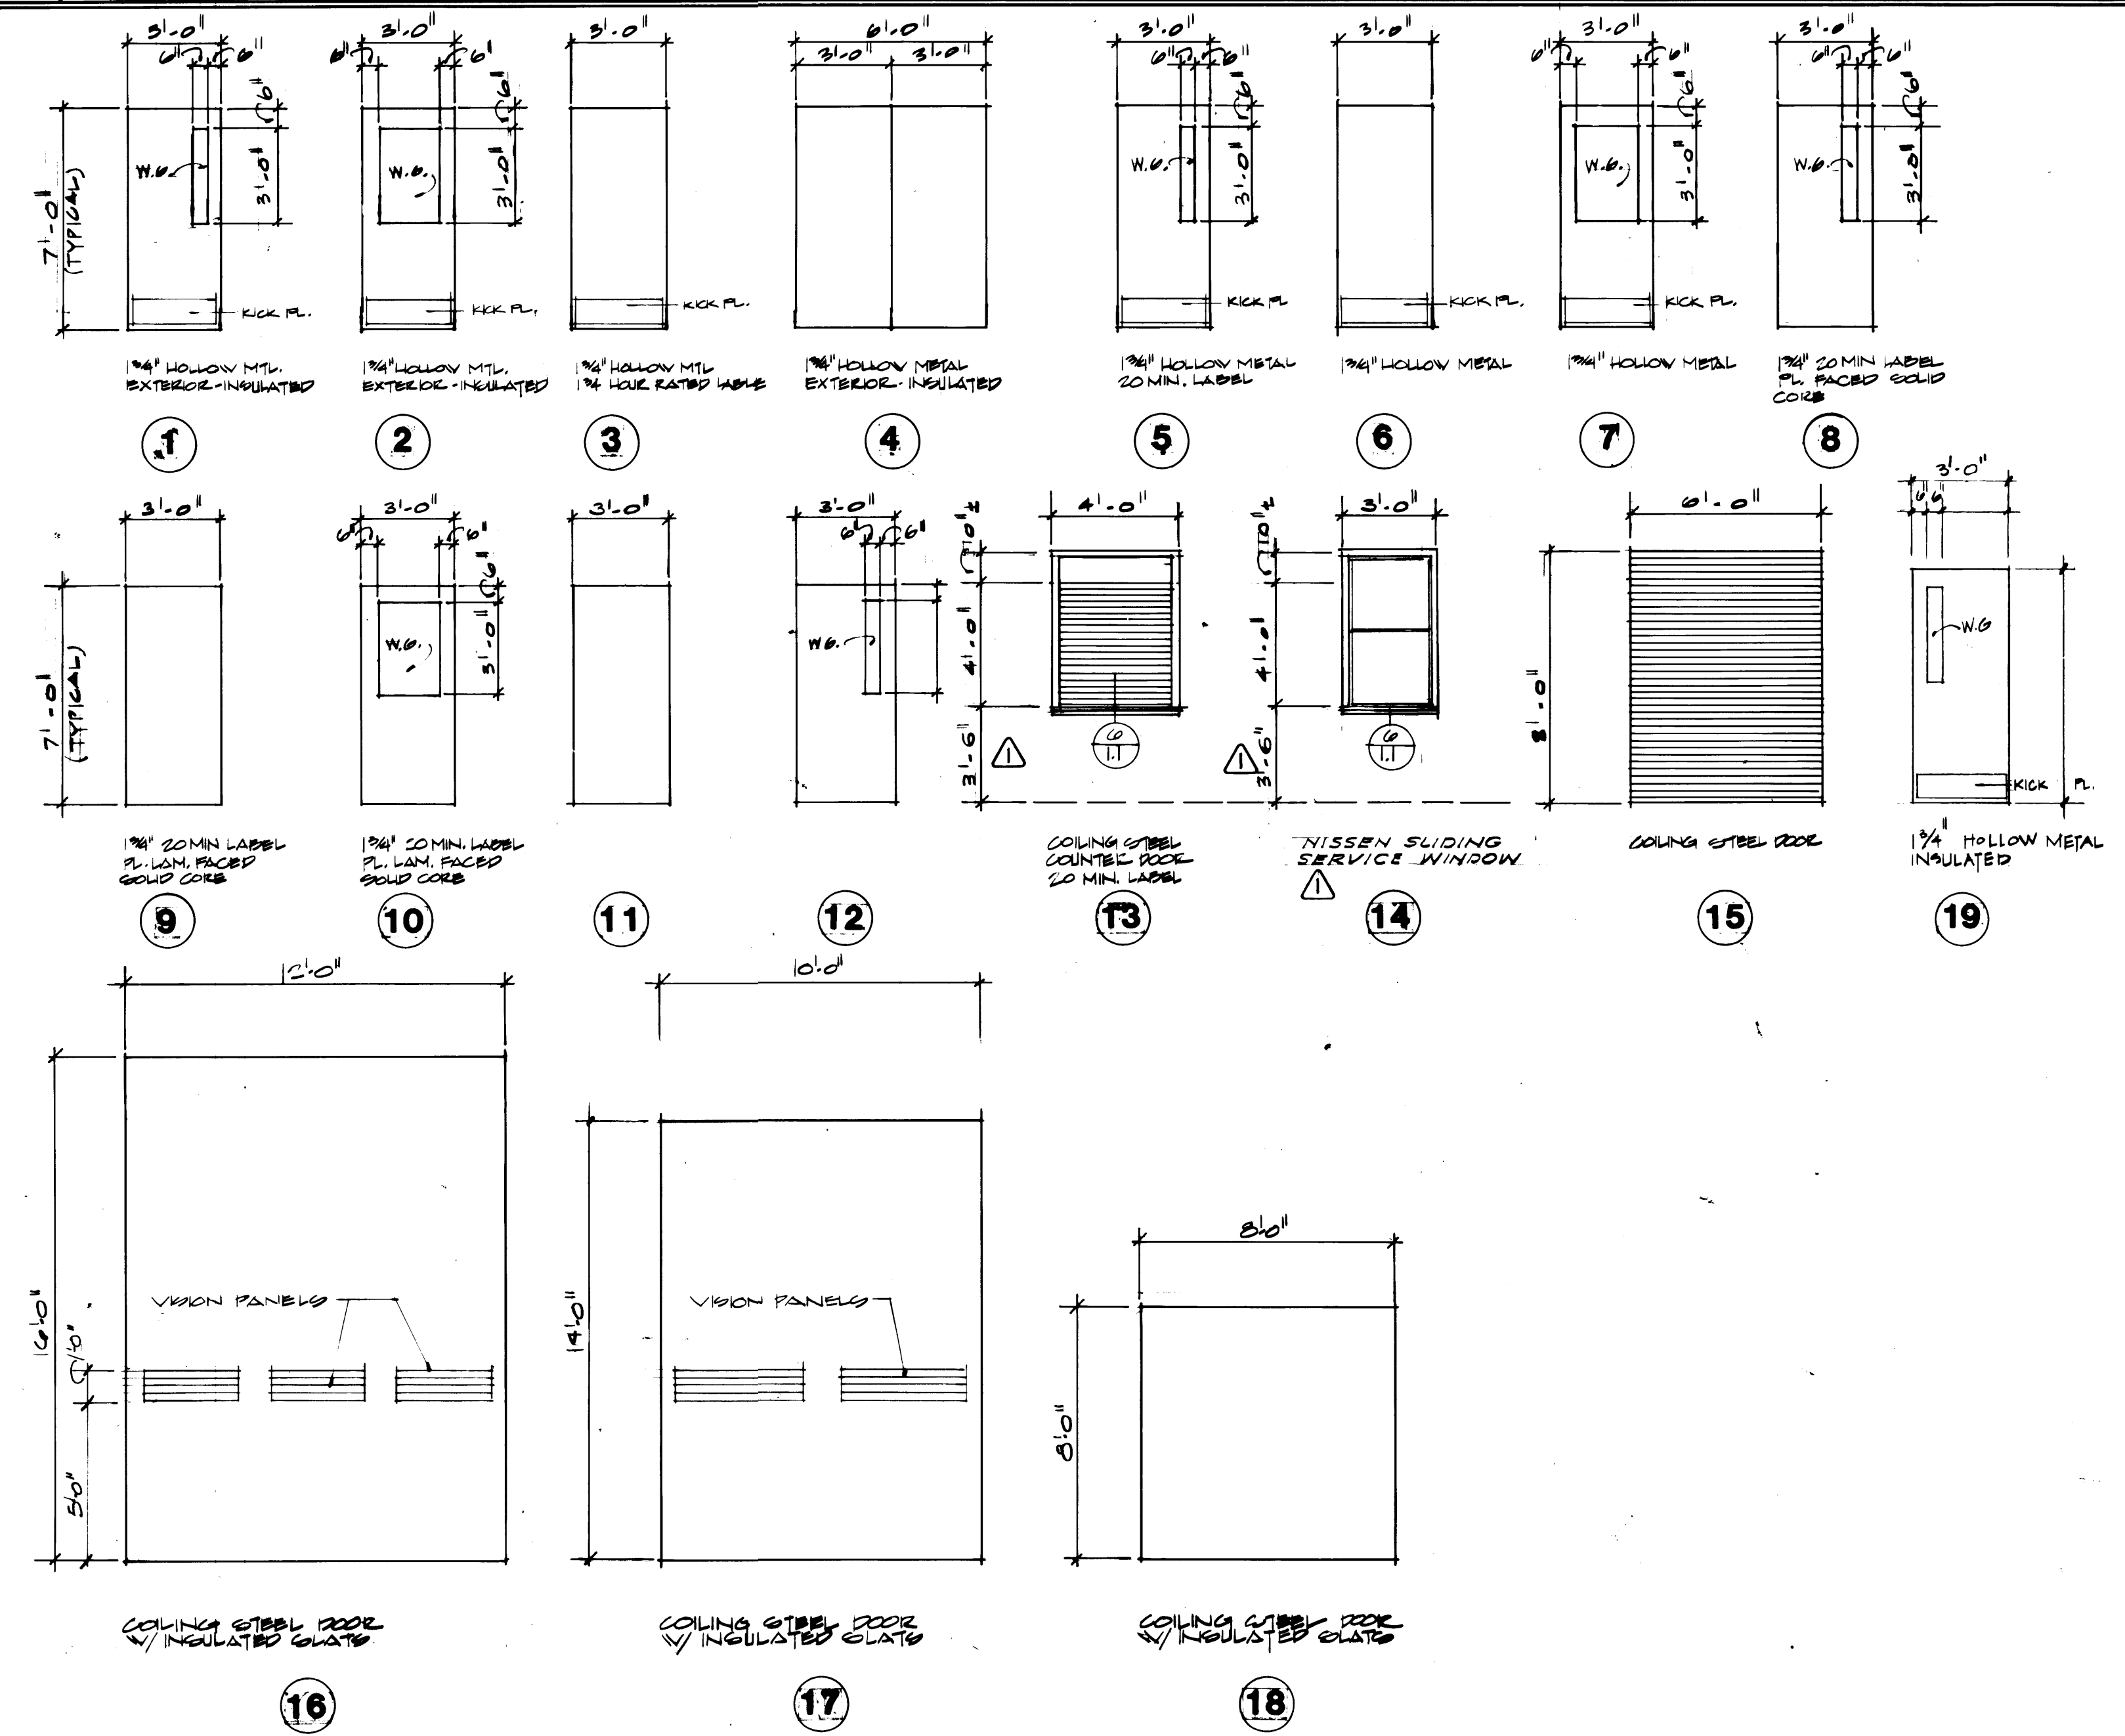

FRAME TYPES

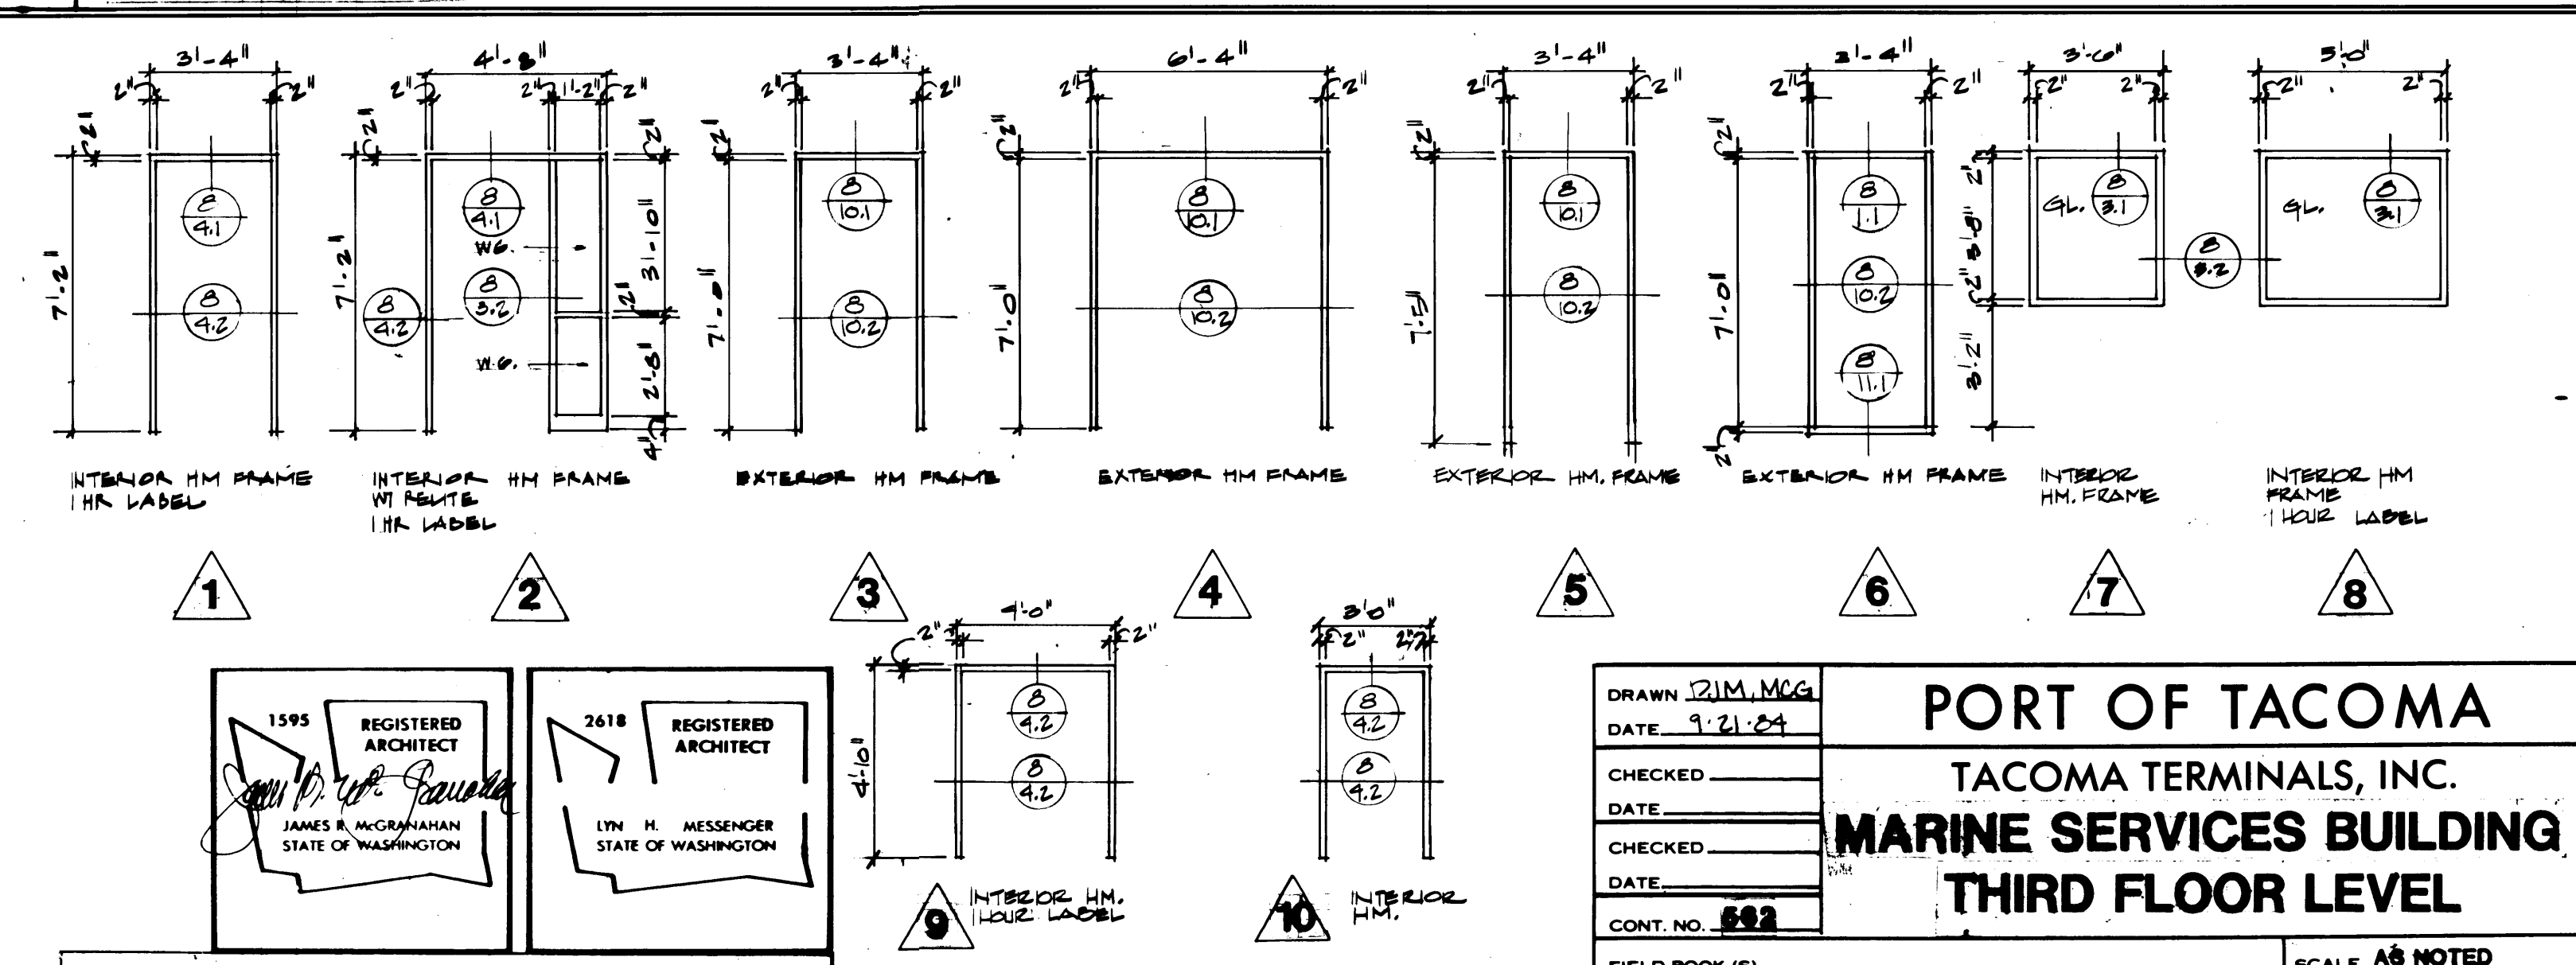

1595 REGISTERED ARCHITECT
JAMES R. MCGRAINAHAN
STATE OF WASHINGTON

MEMBER AMERICAN INSTITUTE OF ARCHITECTS • 9501 AVENUE C, SUITE 300, TACOMA, WA 98402 • (206) 343-3044

ARCHITECTURE / PLANNING / INTERIORS

2618 REGISTERED ARCHITECT
LYN H. MESSENGER
STATE OF WASHINGTON

REVISION TO AS BUILT

MARK REVISION BY APP. DATE

DRAWN JIM.MCG
DATE 9-21-84
CHECKED
DATE
CHECKED
DATE
CONT. NO. 592

FIELD BOOK (S)

APPROVED

PROJECT MANAGER

CHIEF ENGINEER

PORT OF TACOMA
TACOMA TERMINALS, INC.
MARINE SERVICES BUILDING
THIRD FLOOR LEVEL

SCALE AS NOTED


DRAWING NO. EP-3893-23

6-A11-3

SHEET 11 OF 13

DATE 9/24/84


DATE 11

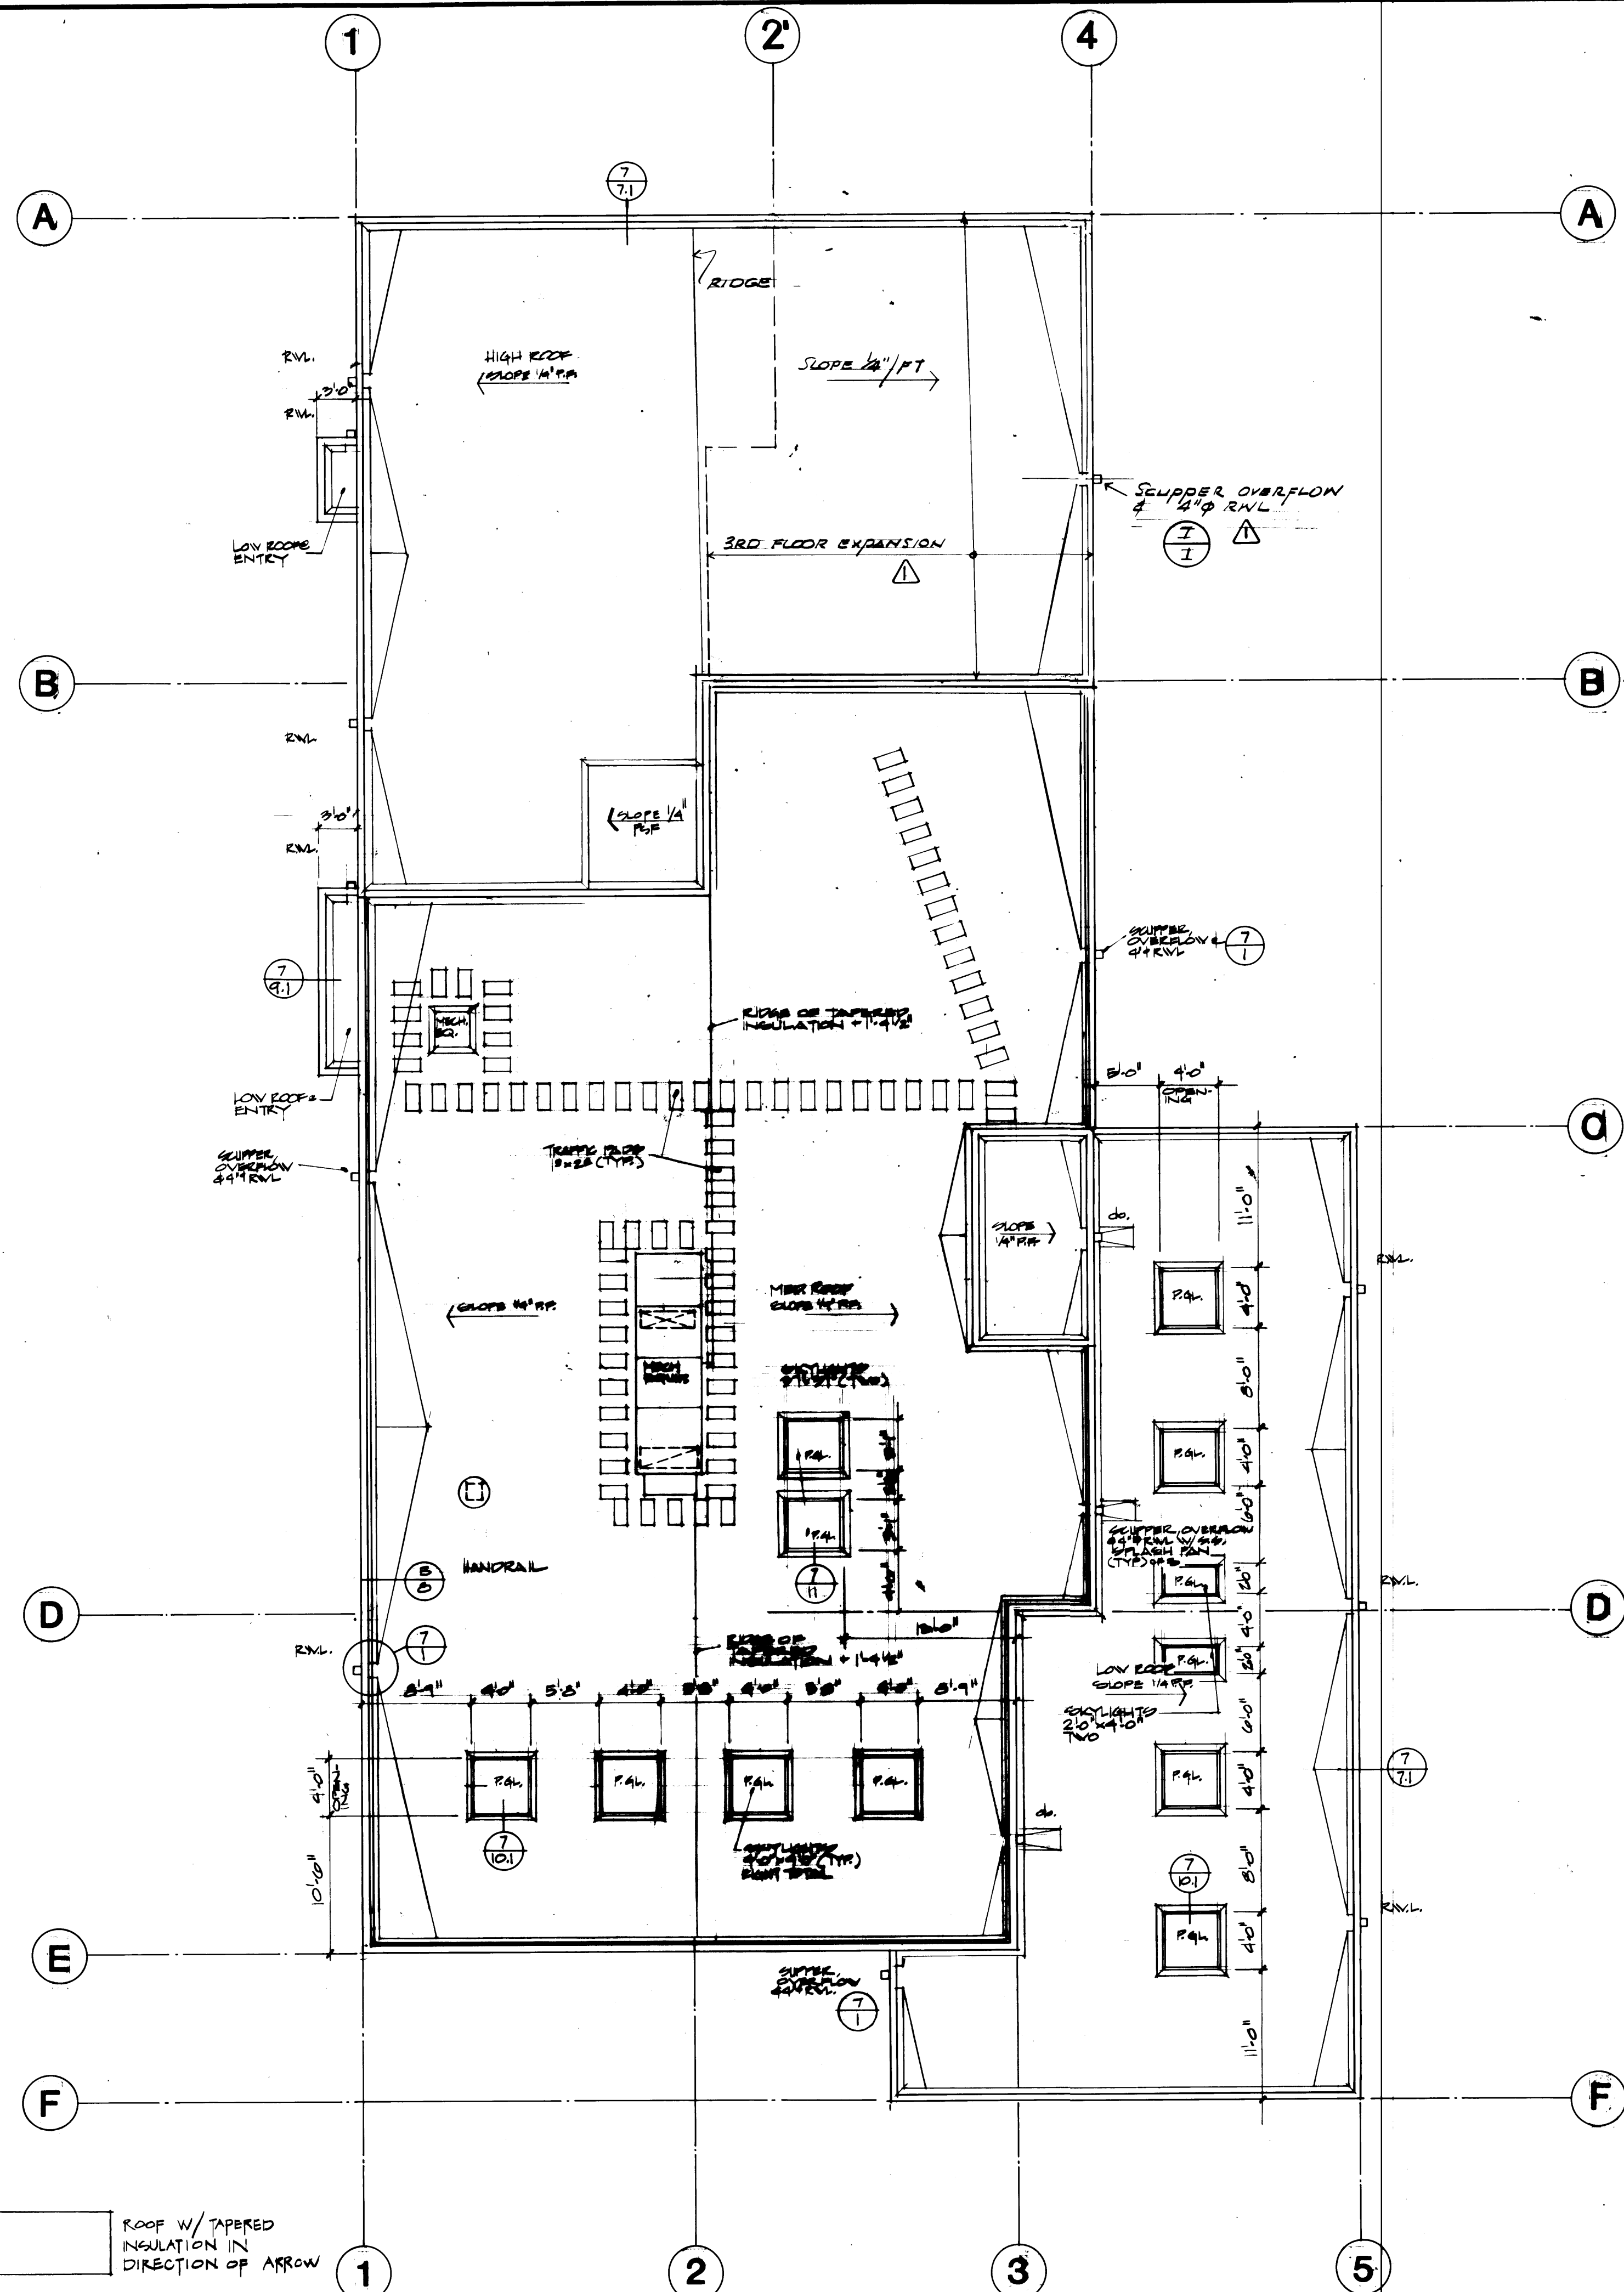

ROOF PLAN
SCALE 1/8"=1'-0"

WINDOW TYPES

NOTES: (TYPICAL)
- ANODIZED ALUMINUM
- 1" INSULATED GLAZING
- SOLAR GREY GLAZING

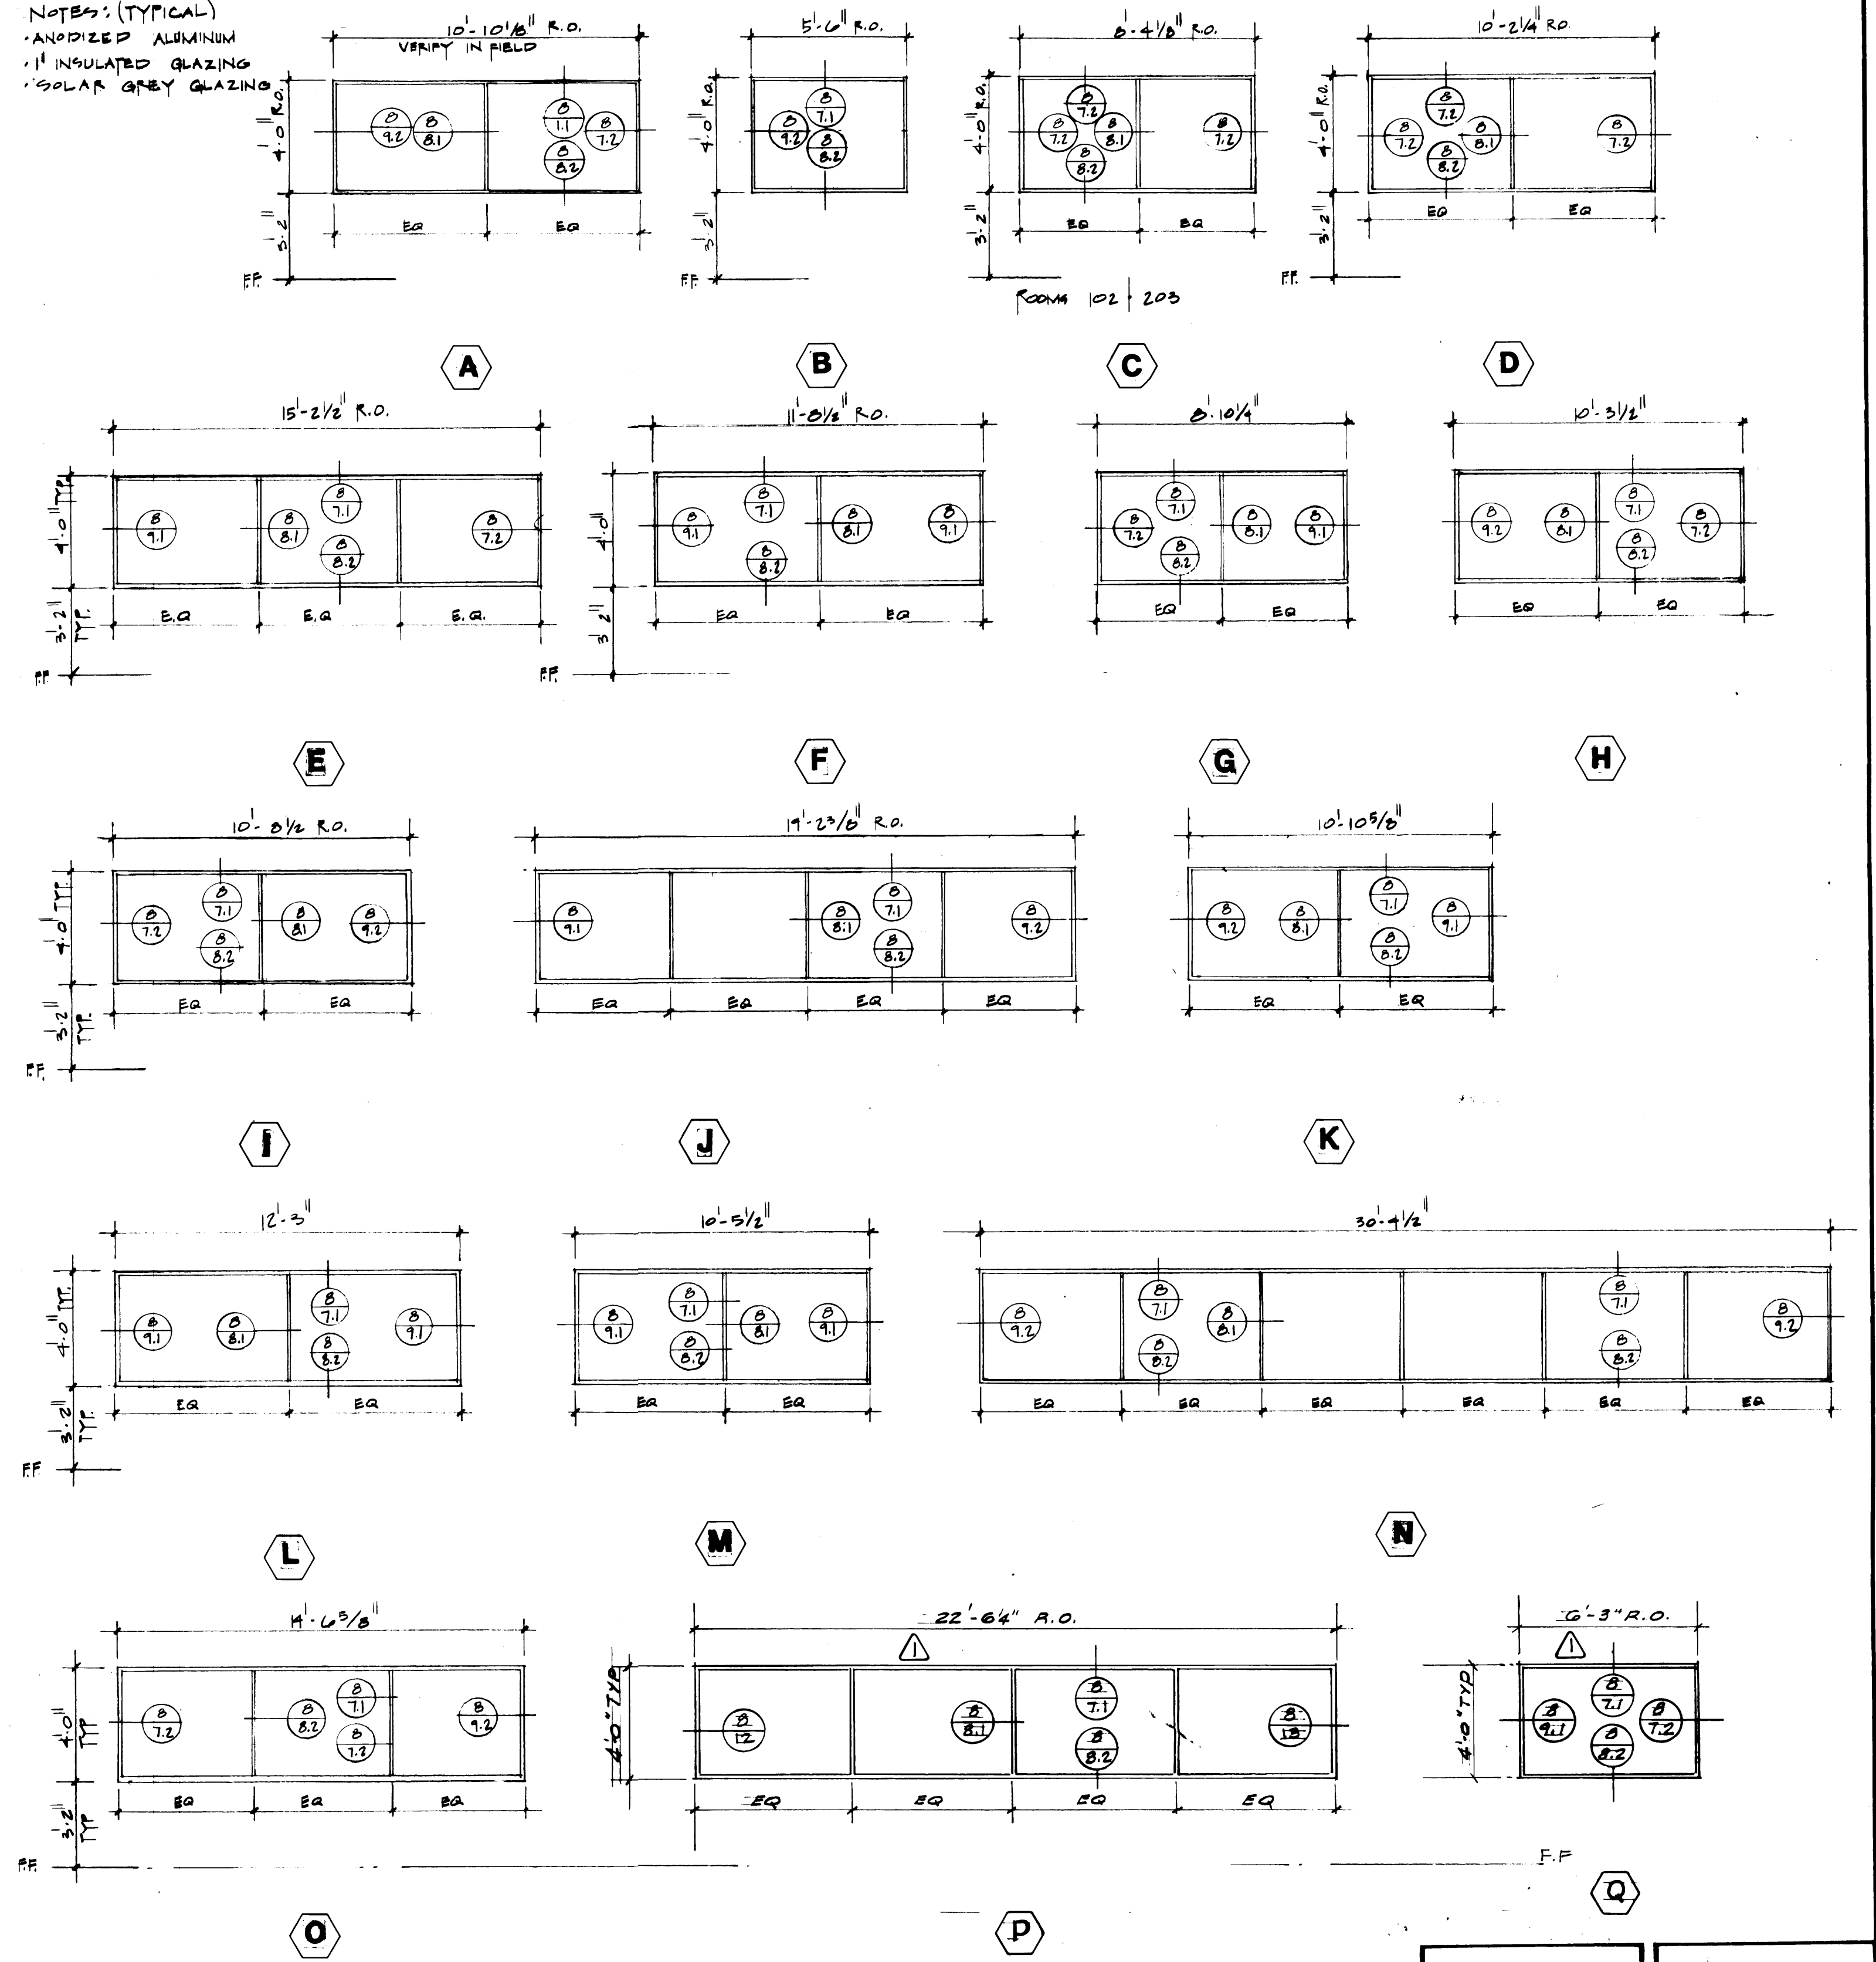

1595 REGISTERED ARCHITECT
JAMES R. McGRANAHAN
STATE OF WASHINGTON

2618 REGISTERED ARCHITECT
LYNN H. MESSENGER
STATE OF WASHINGTON

PORT OF TACOMA
TACOMA TERMINALS, INC.
MARINE SERVICES BUILDING
ROOF PLAN & WINDOW TYPES

McGRANAHAN, MESSENGER ASSOCIATES
ARCHITECTURE / PLANNING / INTERIORS
1101 WEST AMERICAN INSTITUTE OF ARCHITECTS • 1901 AVENUE C, SUITE 300, TACOMA, WA 98401 • (206) 383-3084


MARK	REVISION	BY	APP.	DATE
1	REVISED TO AS BUILT	A.J.S.		9/27/84

DRAWN	21E, MCG
DATE	9/21/84
CHECKED	
DATE	
CHECKED	
DATE	
APPROVED	
PROJECT MANAGER	
CHIEF ENGINEER	

CONT. NO. 562	FIELD BOOK (S)
APPROVED	DATE 9/24/84
PROJECT MANAGER	DATE
CHIEF ENGINEER	DATE
SCALE	DRAWING NO. EP-3893-00
	6-A11-4
	SHEET A11-4 OF 13




DRAWN <u>WIF</u>	PORT OF TACOMA TACOMA TERMINALS, INC. MARINE SERVICES BUILDING EXTERIOR ELEVATIONS
DATE <u>9-21-84</u>	
CHECKED _____	
DATE _____	
CHECKED _____	
DATE _____	
CONT. NO. <u>562</u>	
FIELD BOOK (S) _____	
APPROVED <u>[Signature]</u>	SCALE _____
PROJECT MANAGER <u>[Signature]</u>	DRAWING NO. EP-3893-23
DATE <u>9/24/84</u>	6-A11-5
PROJECT ENGINEER <u>[Signature]</u>	A11-5 OF 13
DATE _____	SHEET _____

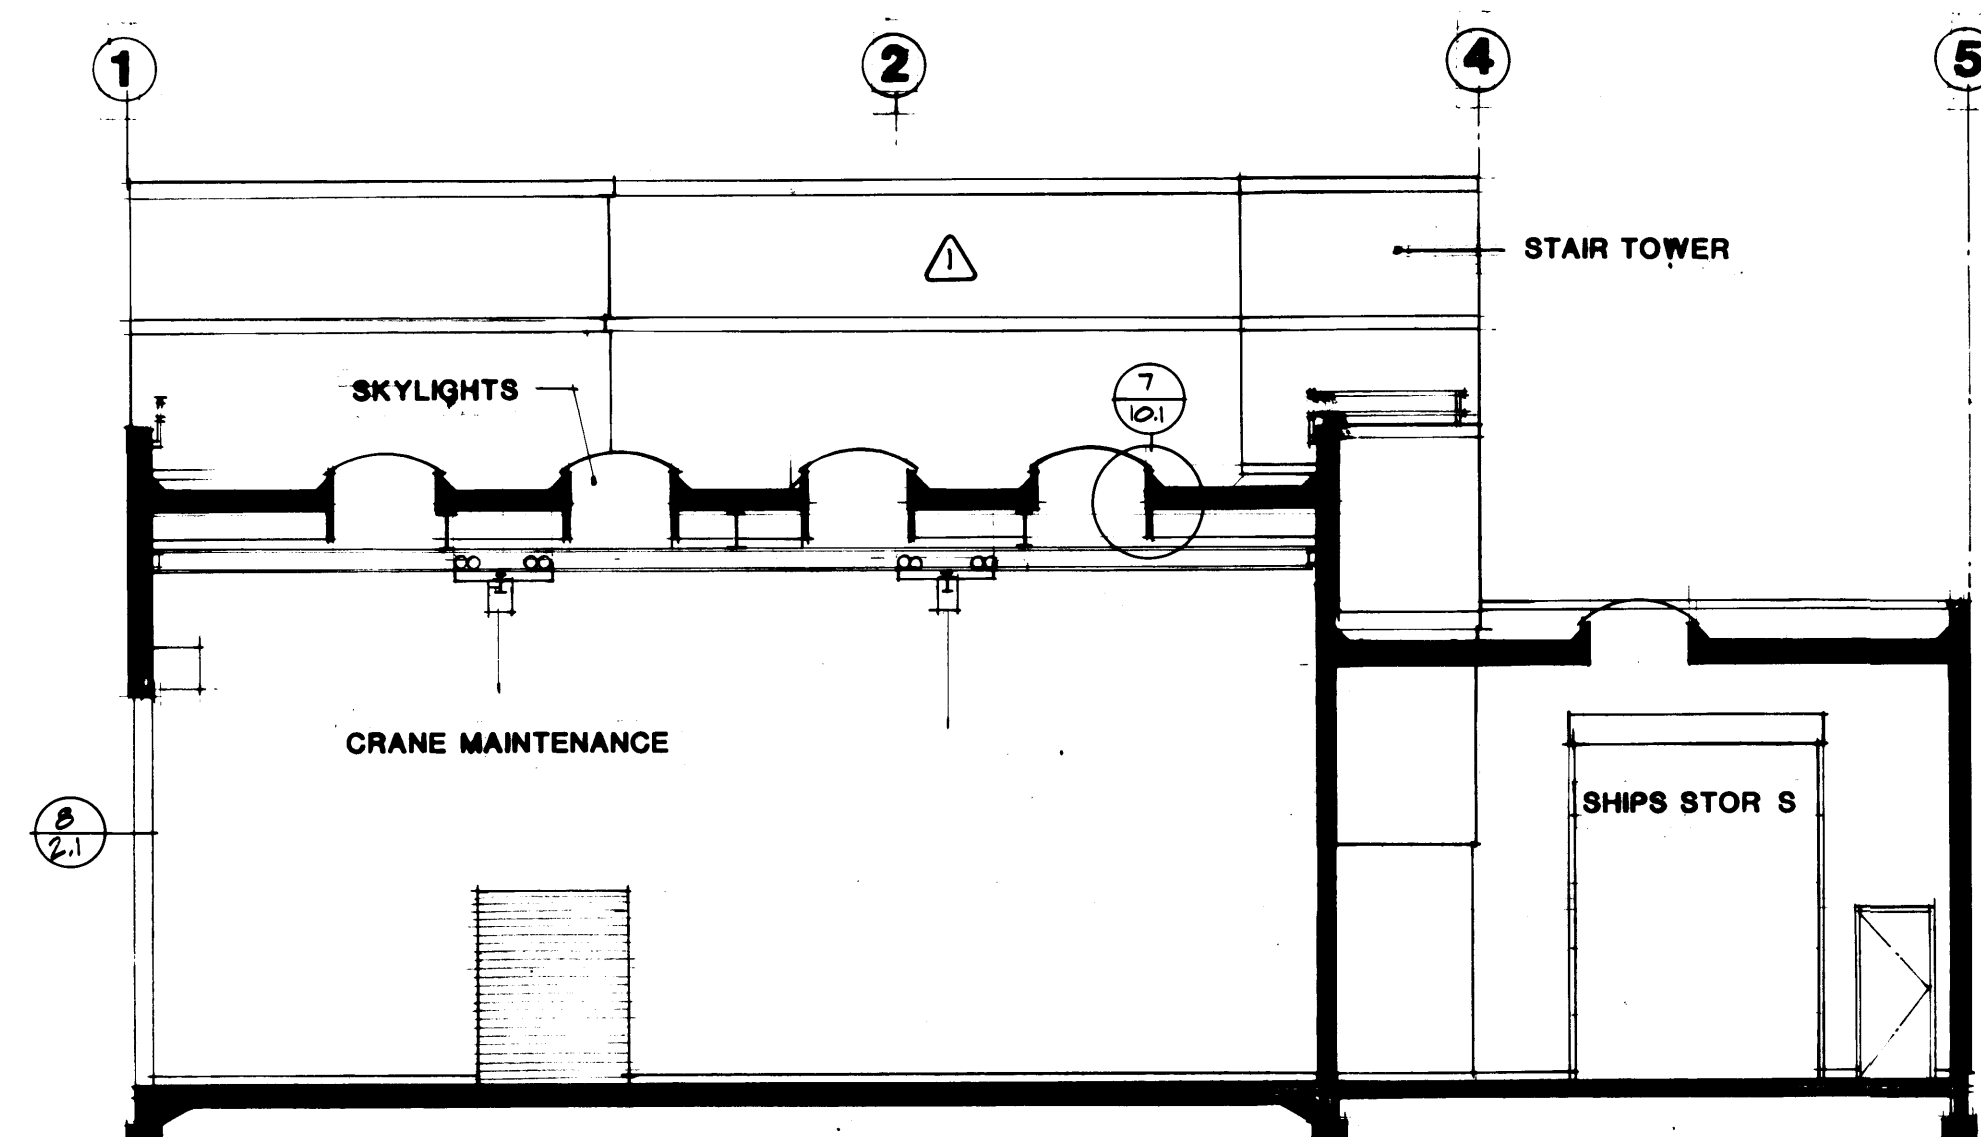


BUILDING SECTION A-A

SCALE 1/8"=1'-0"

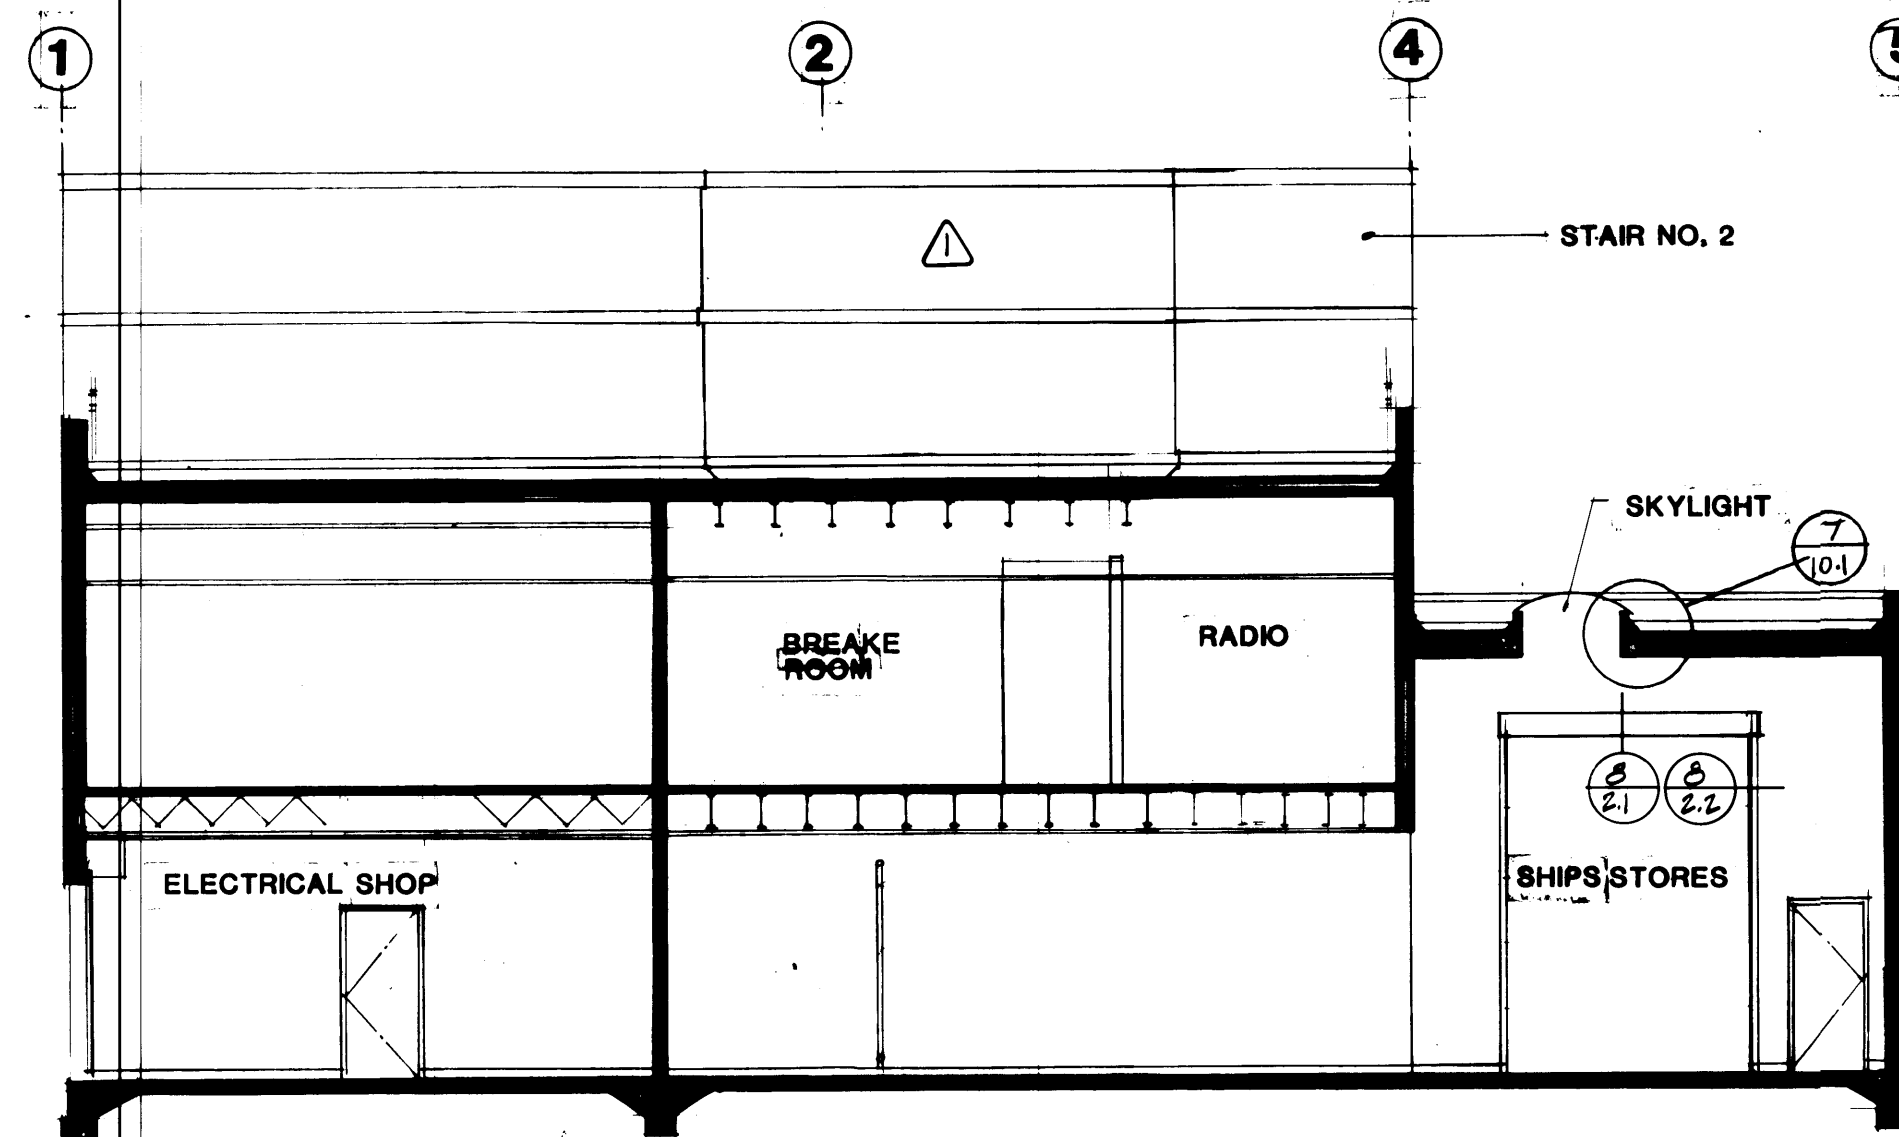


BUILDING SECTION B-B

SCALE 1/8"=1'-0"

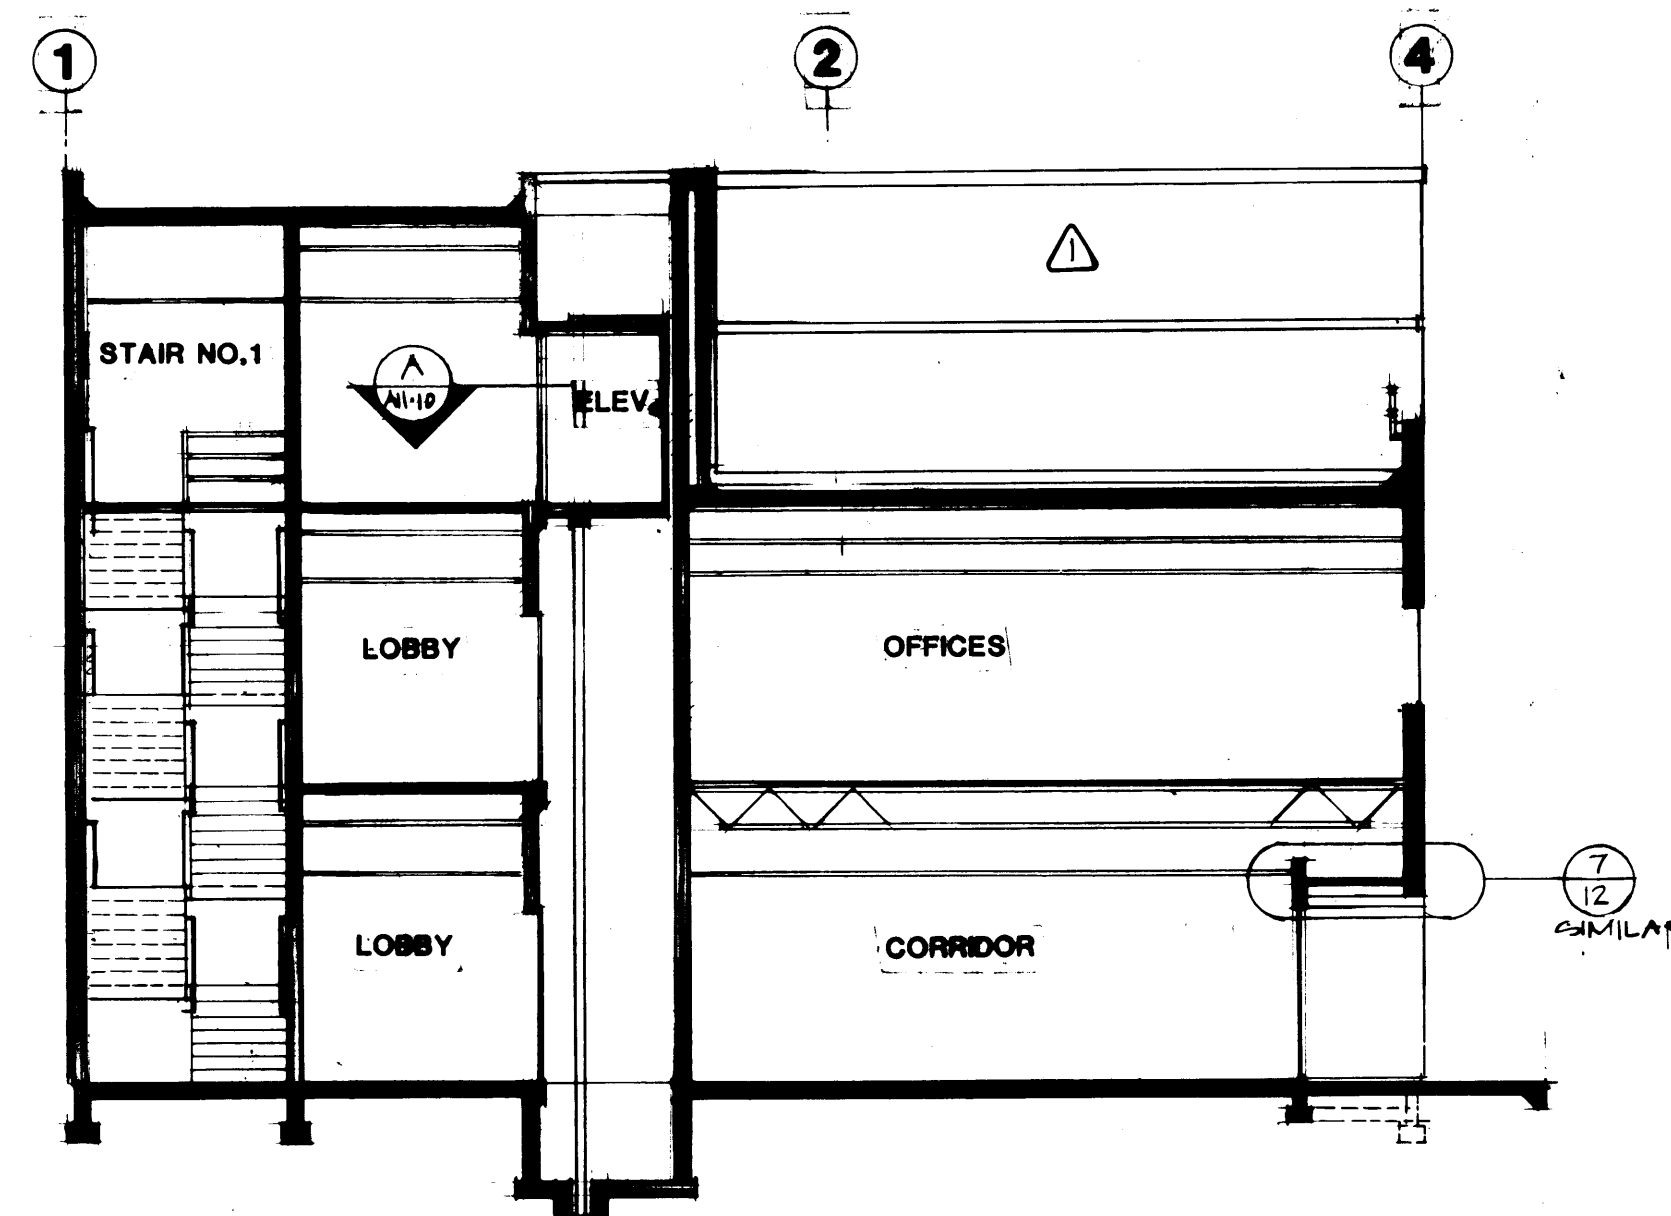


BUILDING SECTION C-C

SCALE 1/8"=1'-0"

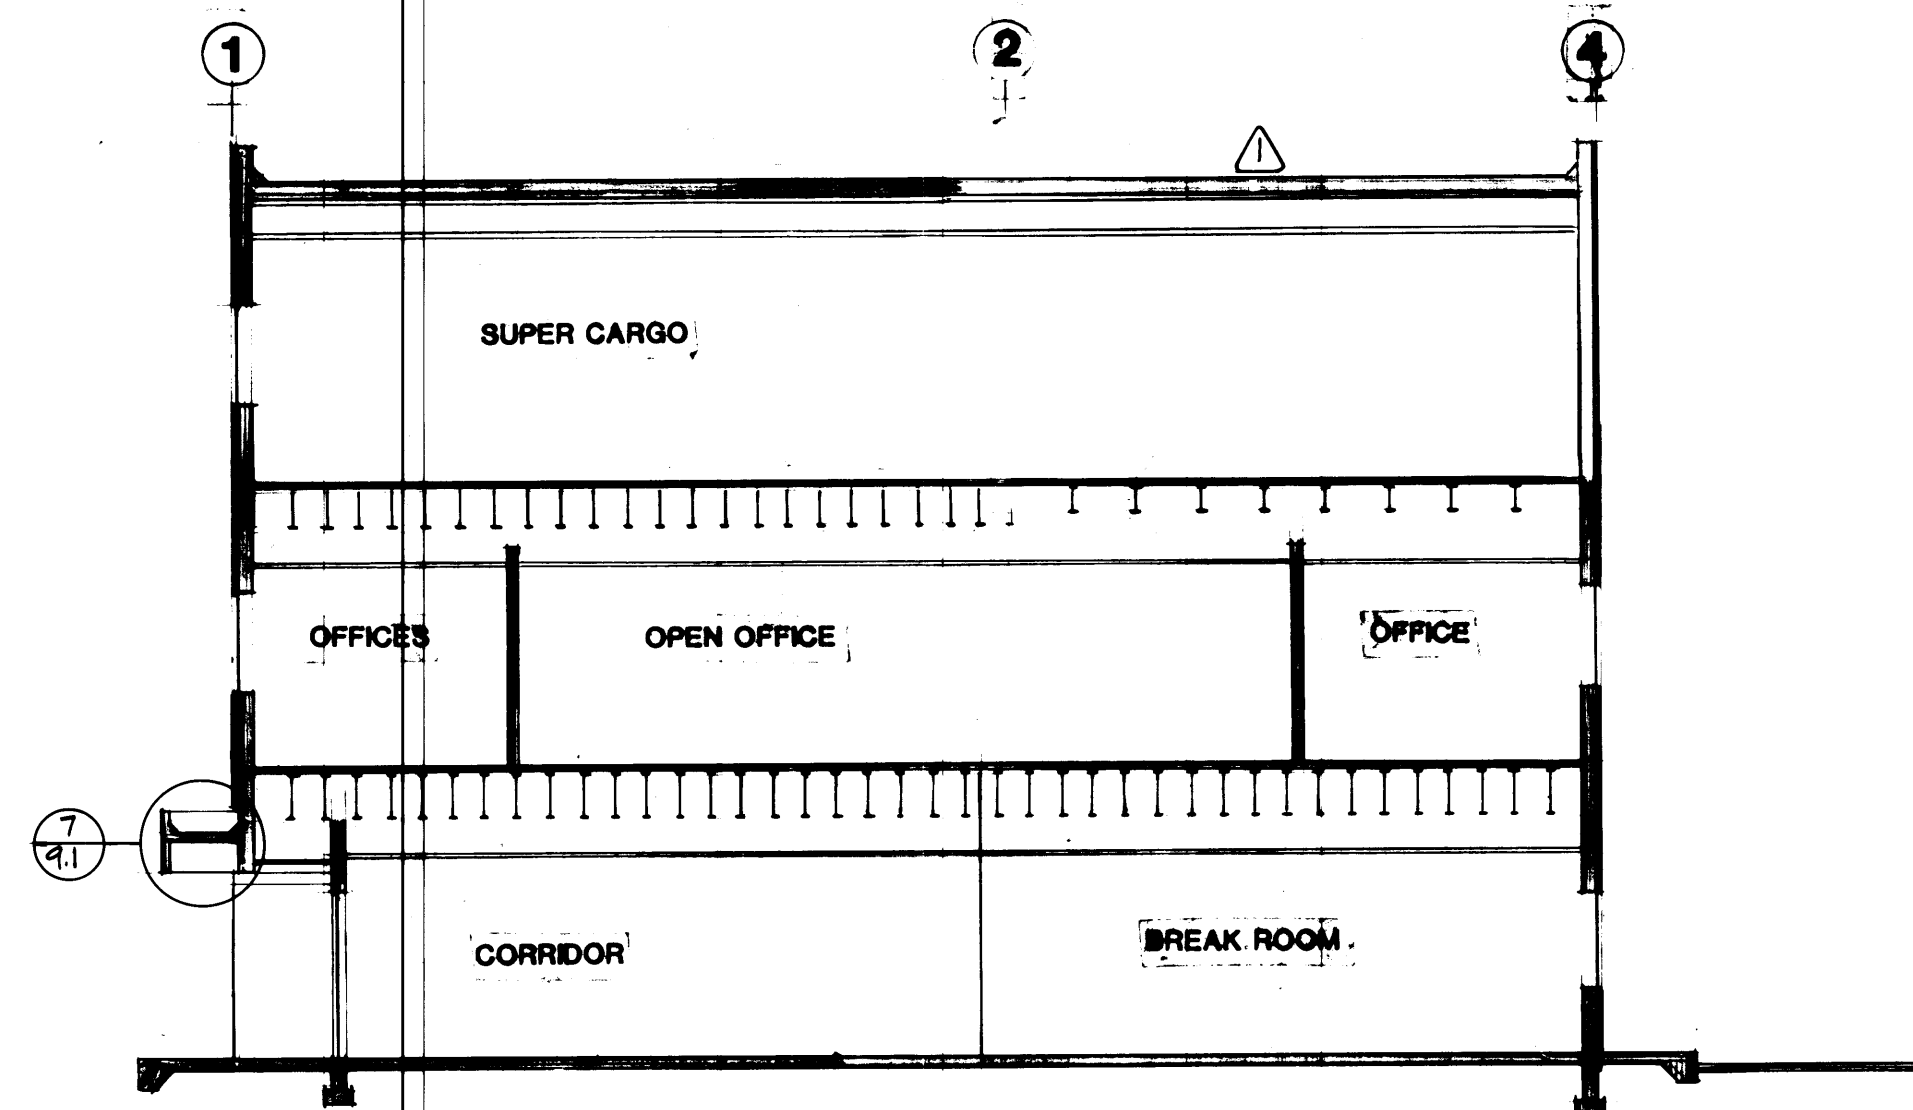

BUILDING SECTION D-D

SCALE 1/8"=1'-0"

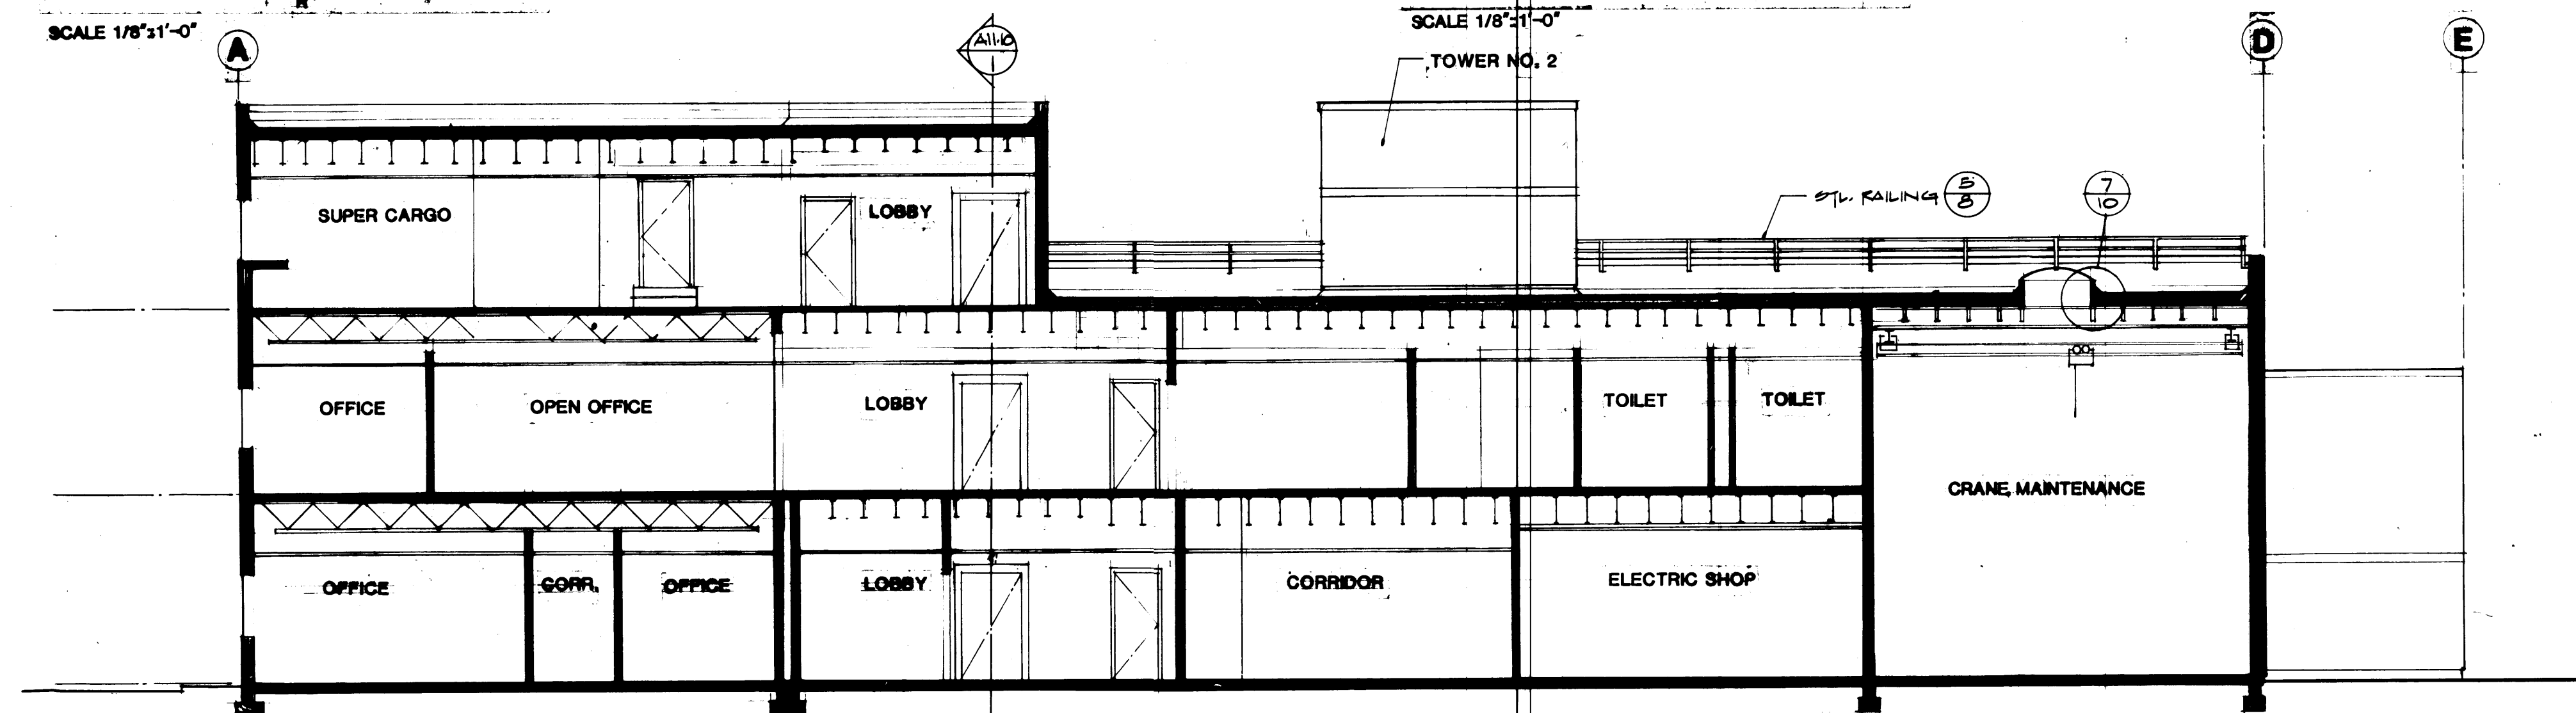

BUILDING SECTION E-E

SCALE 1/8"=1'-0"

**MCGRANAHAN,
MESSENGER
ASSOCIATES**

ARCHITECTURE / PLANNING / INTERIORS
MEMBER AMERICAN INSTITUTE OF ARCHITECTS • 9501 AVENUE 11, SUITE 300, TACOMA, WA 98402 • (206) 383-3004


MARK	REVISION	BY	APP.	DATE
1	REVISED TO AS-BUILT	R.J.S.		9-28-85


DRAWN	DLF
DATE	9-21-84
CHECKED	
DATE	
CHECKED	
DATE	
CONT. NO.	552

FIELD BOOK (S)	
APPROVED	
PROJECT MANAGER	
CHIEF ENGINEER	

PORT OF TACOMA
TACOMA TERMINALS, INC.
MARINE SERVICES BUILDING
BUILDING SECTIONS

SCALE	AS NOTED
DRAWING NO.	EP-3883-23
	6-A11-6
SHEET	A11-6 OF 13

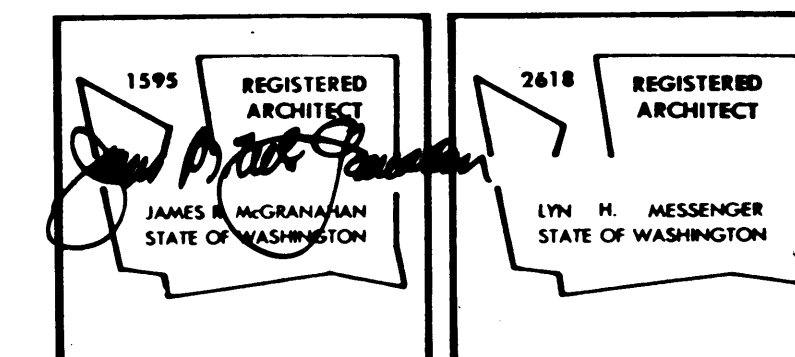





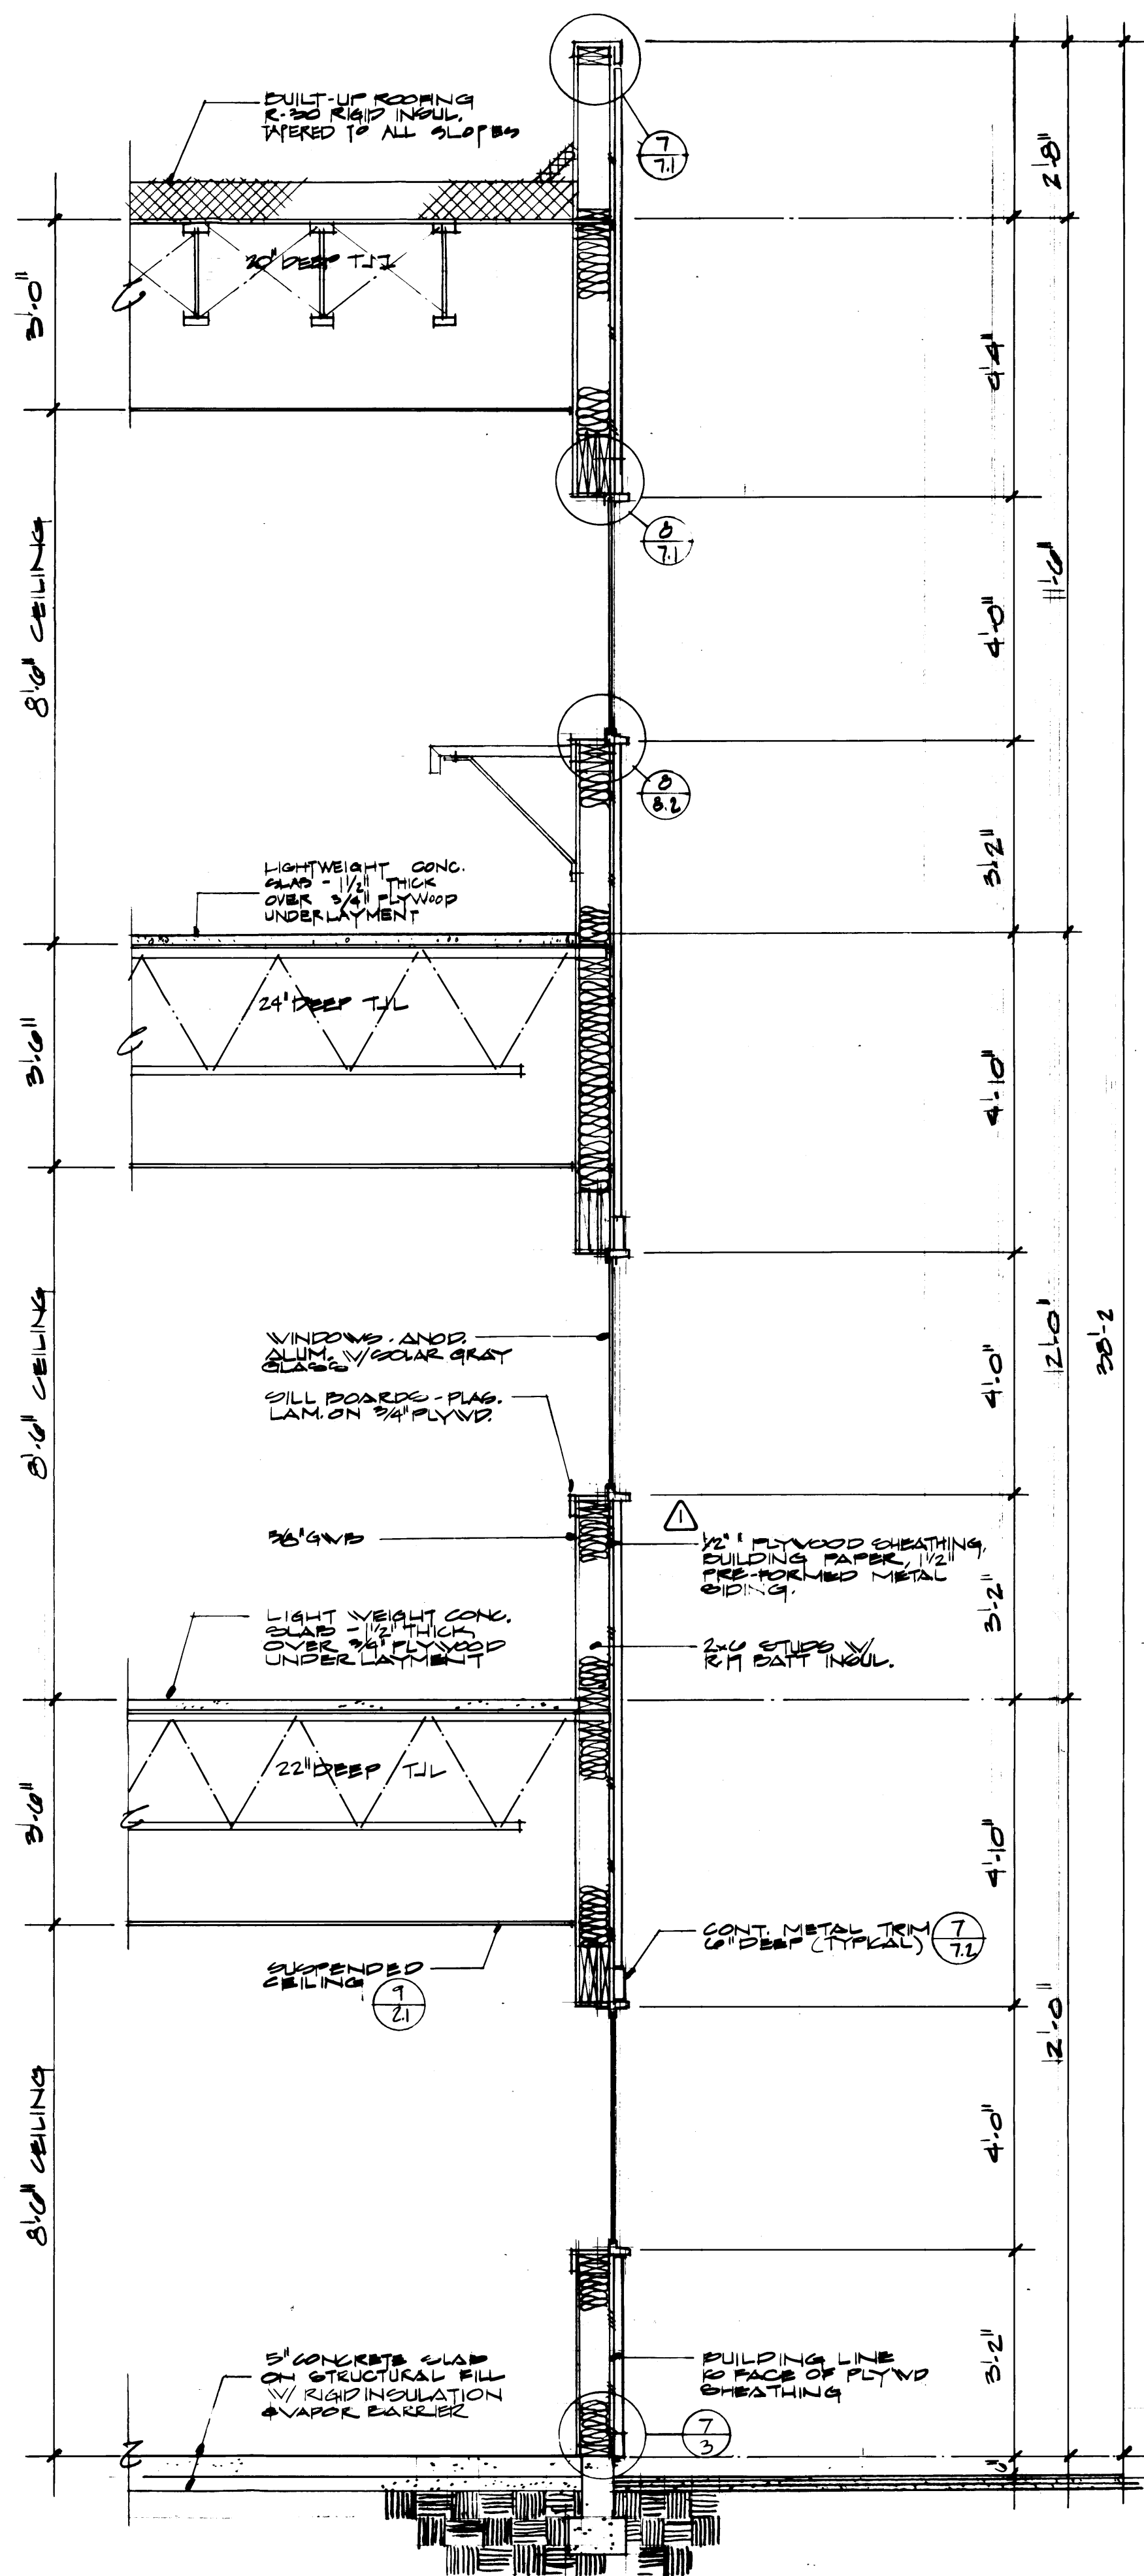


FINISHED ELEVATION
ROOF DECK 35.0'

FINISHED ELEVATION
THIRD FLOOR 43.5'

FINISHED ELEVATION
SECOND FLOOR 31.5'

FINISHED ELEVATION
FIRST FLOOR 19.5'

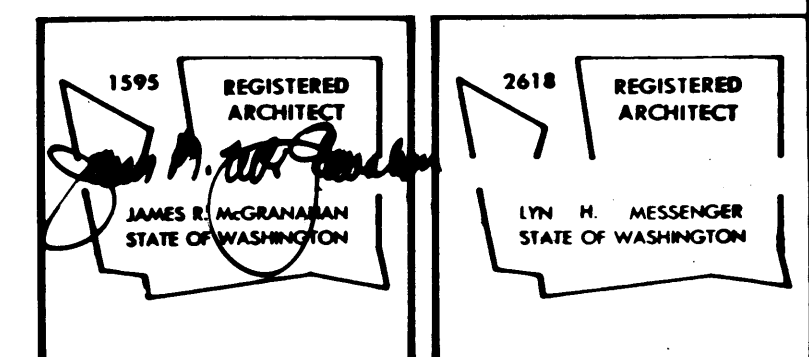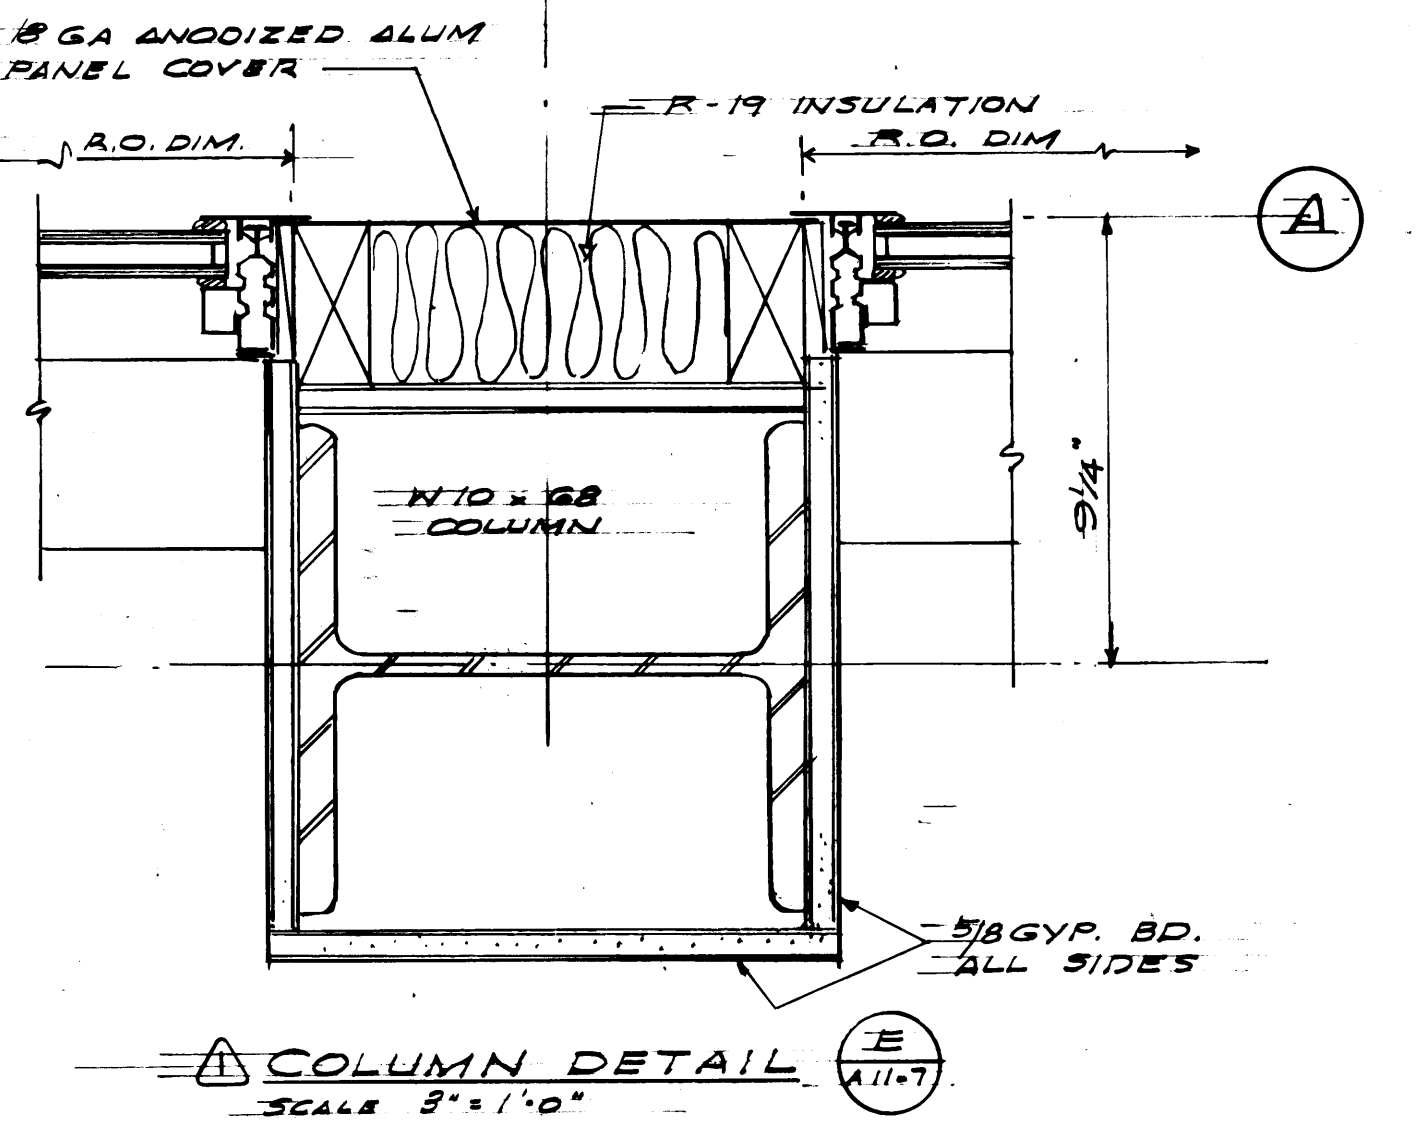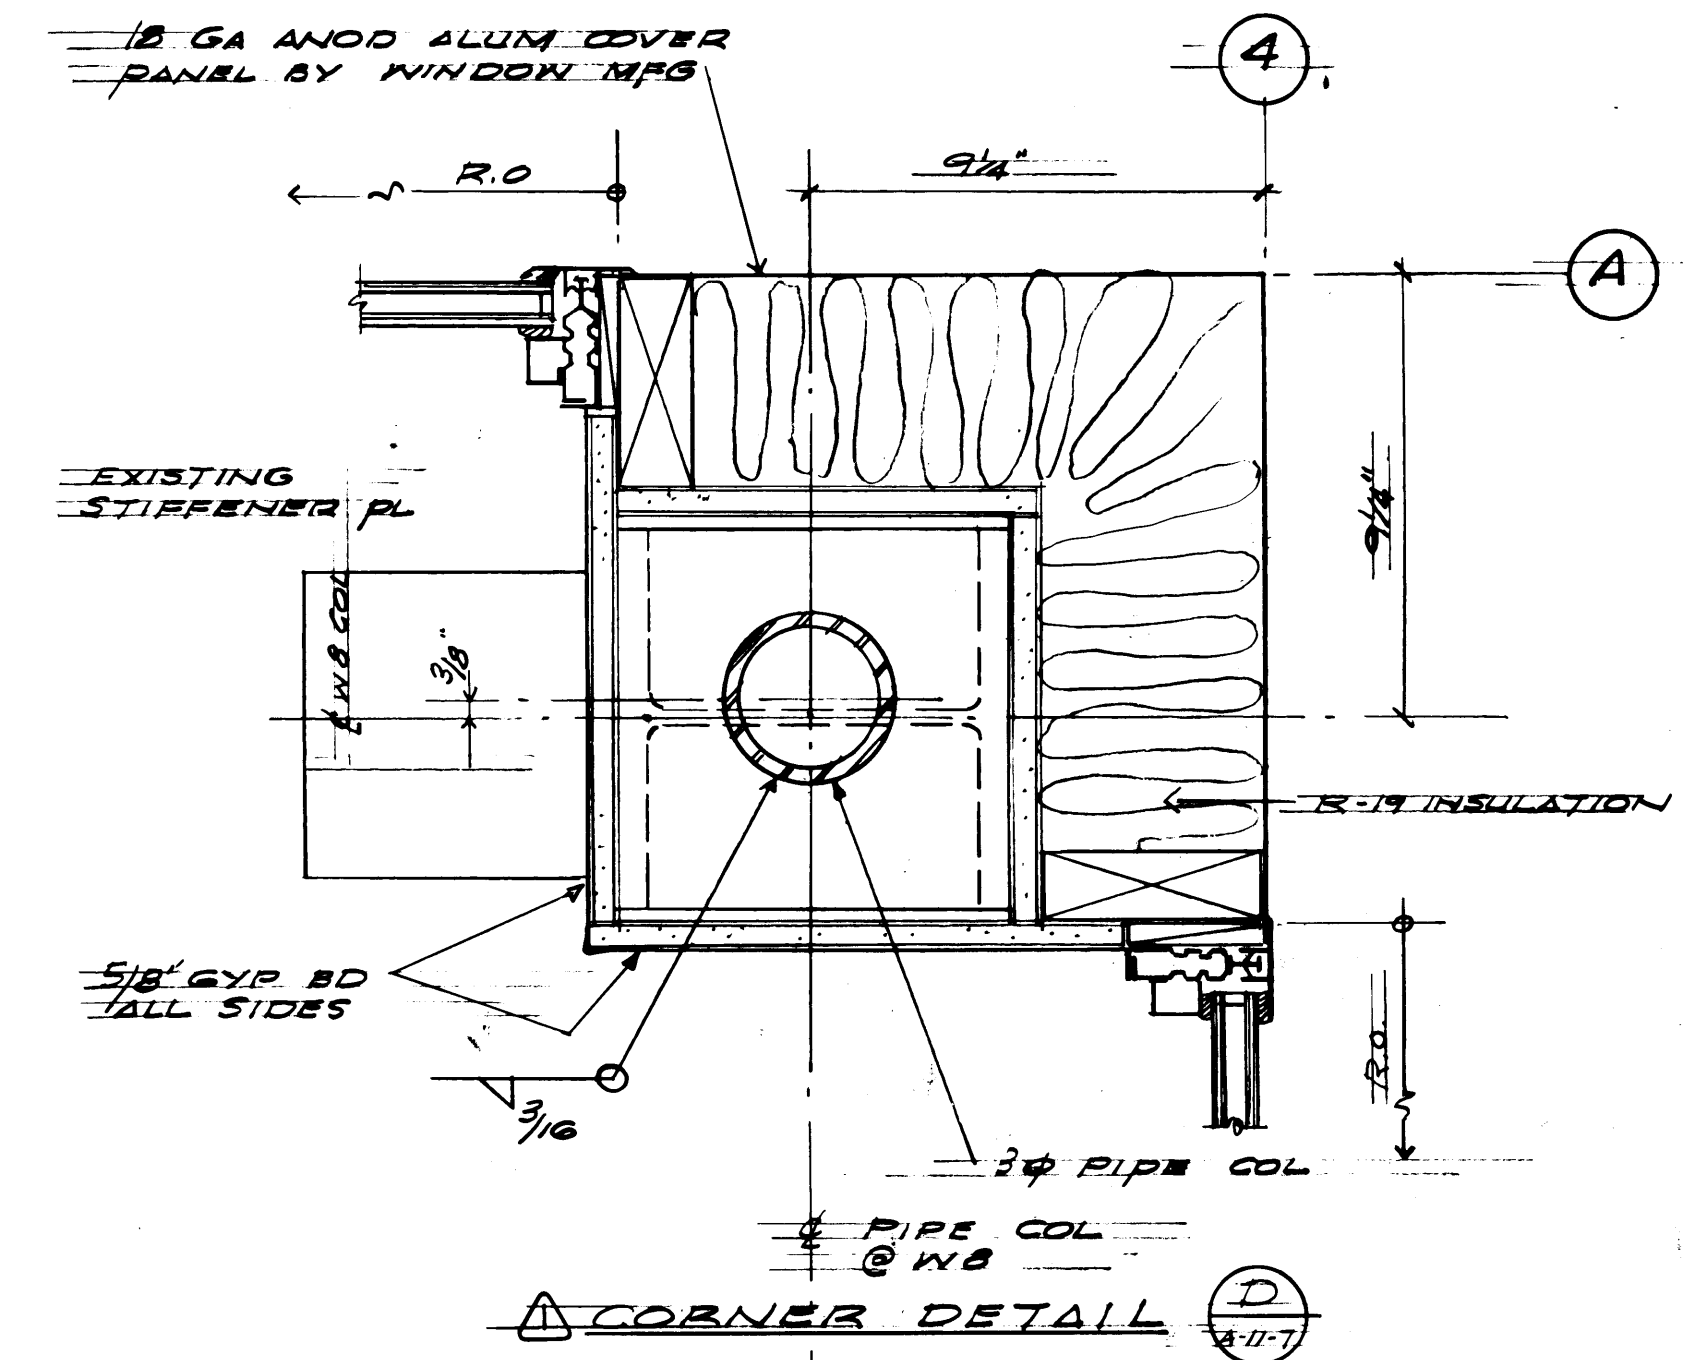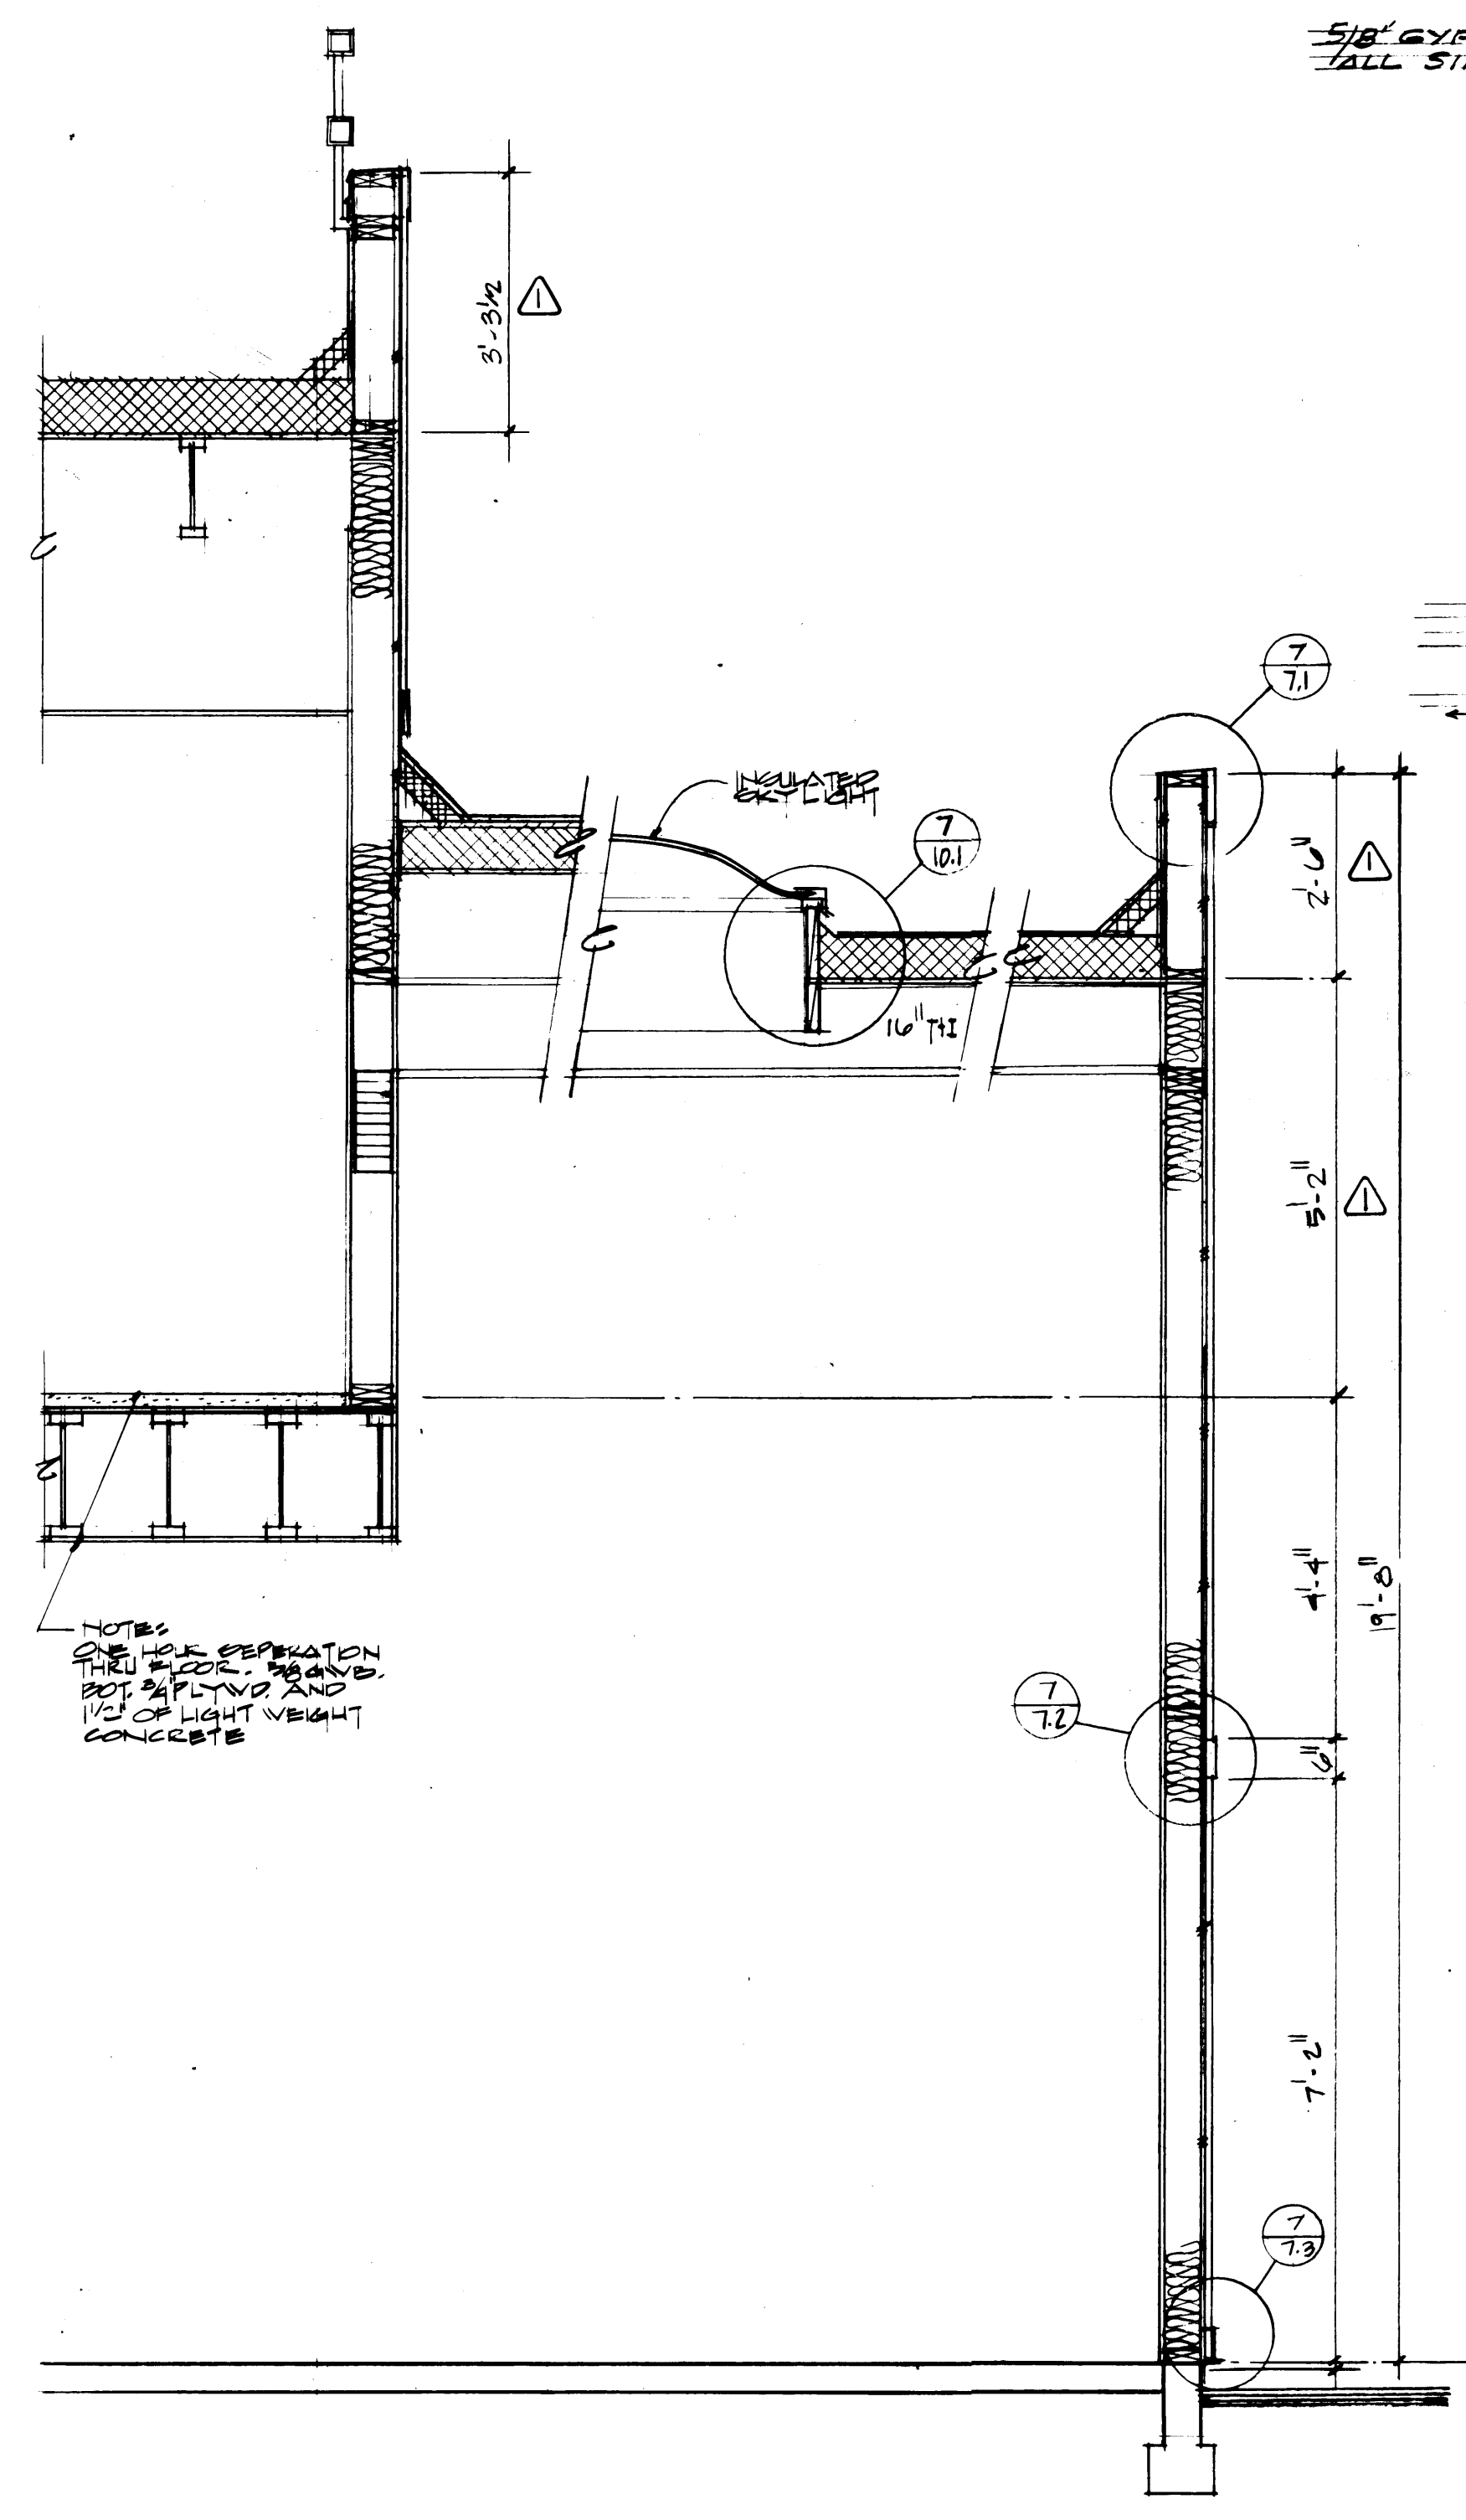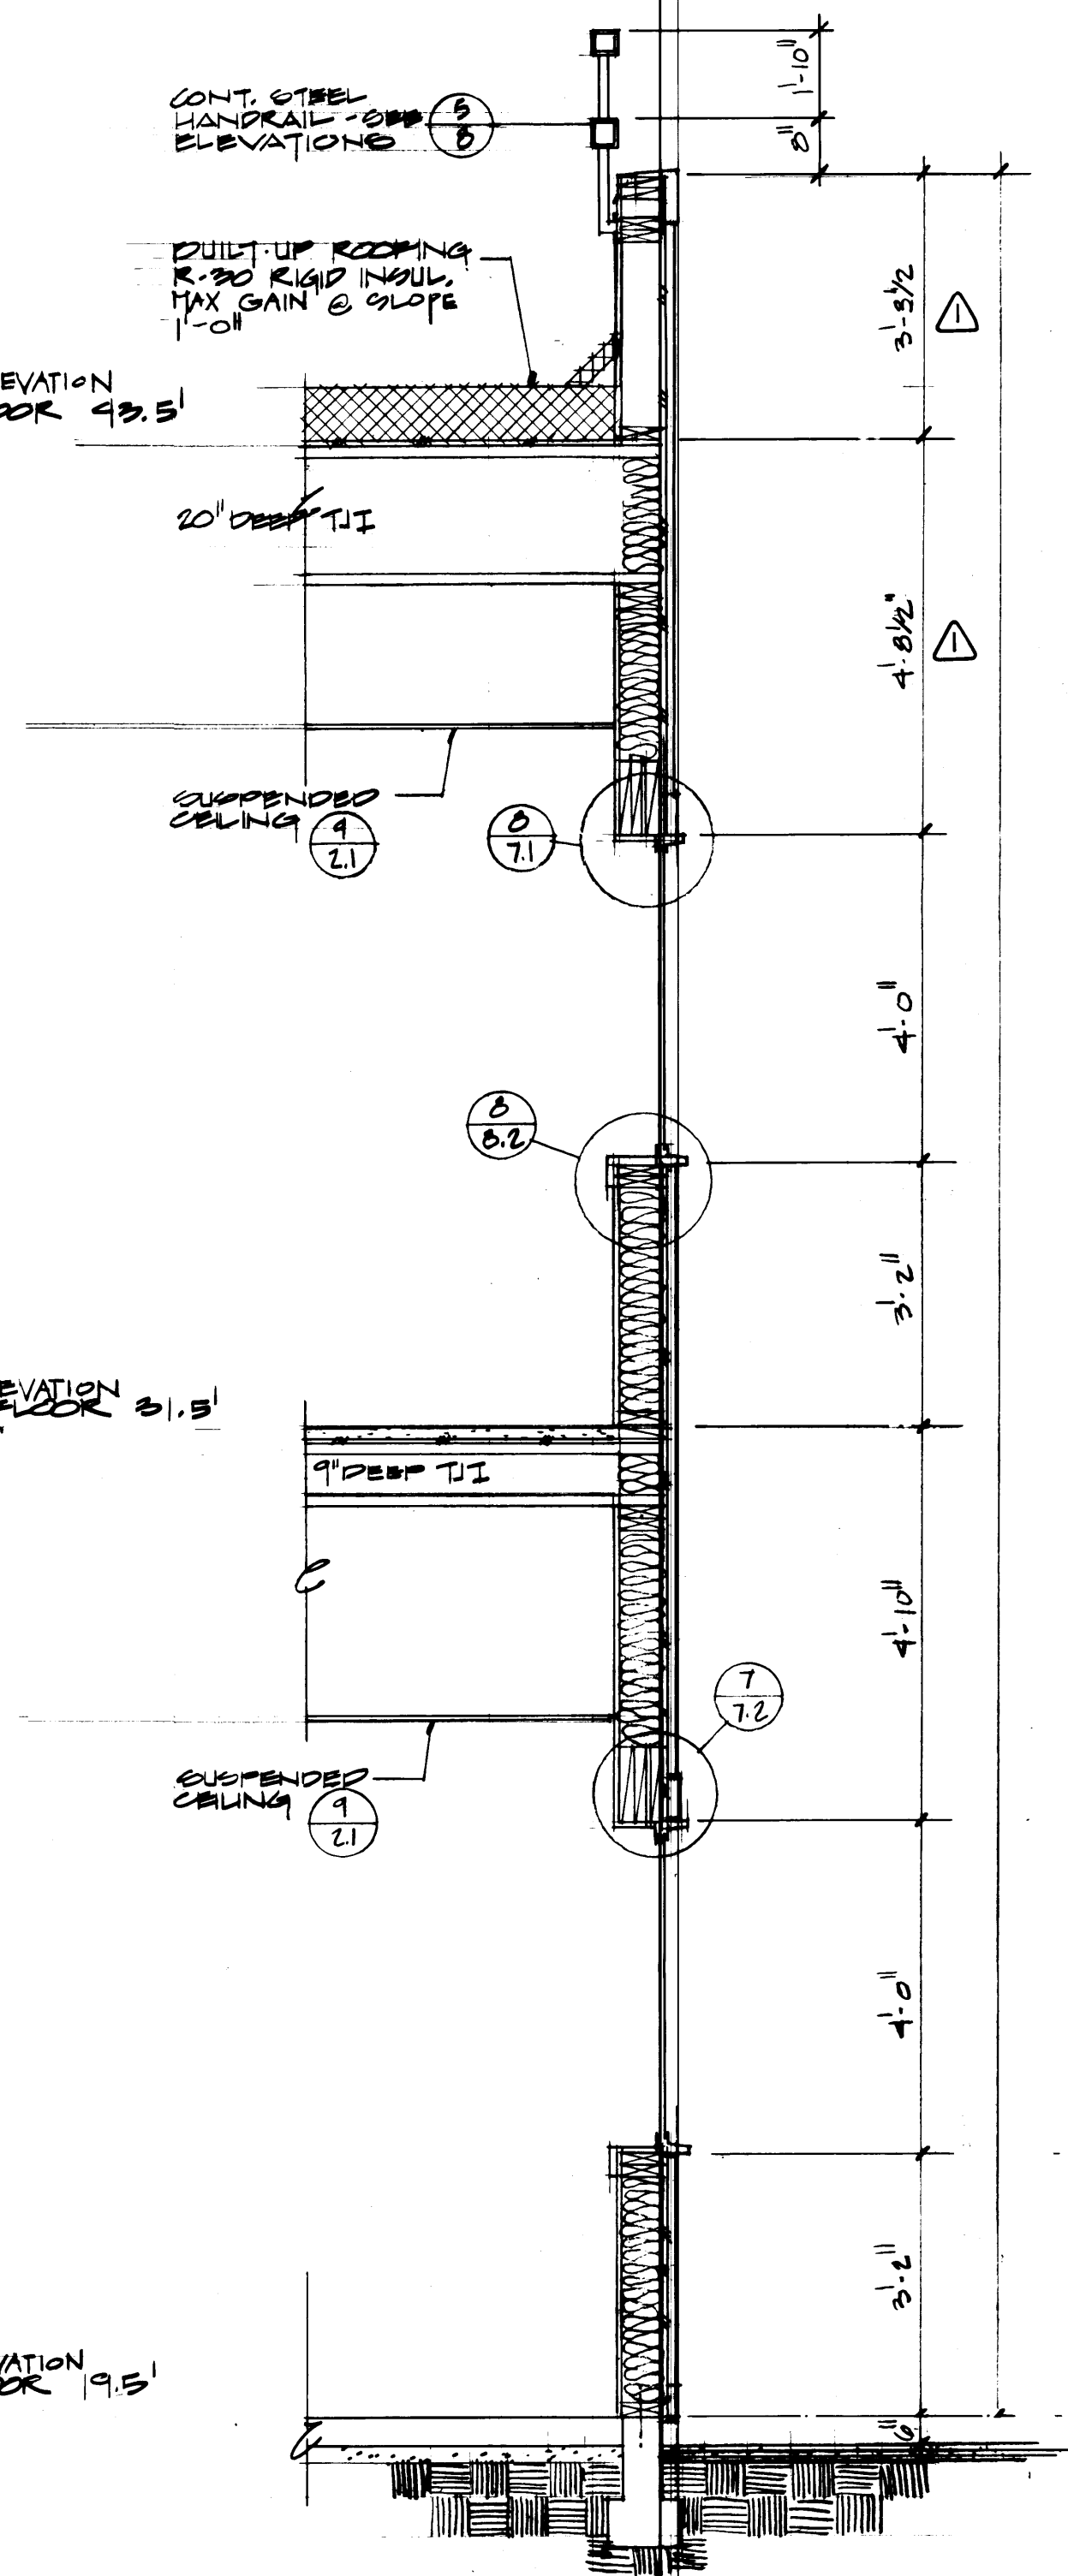


DRAWN: JLM/MCG		DATE: 9-21-84	
CHECKED:		CHECKED:	
DATE:		DATE:	
CHECKED:		CHECKED:	
DATE:		DATE:	
CONT. NO. 892		FIELD BOOK (S)	
APPROVED: [Signature]		DATE: 9/24/84	
PROJECT MANAGER: [Signature]		DATE: 9/24/84	
CHIEF ENGINEER: [Signature]		DATE: 9/24/84	
TACOMA TERMINALS, INC.		DRAWING NO. EP-3893-23	
MARINE SERVICES BUILDING		6-A11-7	
WALL SECTIONS		A11-7 OF 13	

McGRANAHAN,
MESSENGER
ASSOCIATES


ARCHITECTURE / PLANNING / INTERIORS

MEMBER AMERICAN INSTITUTE OF ARCHITECTS • 1701 N. 10TH ST., SUITE 300, TACOMA, WA 98402 • (206) 383-3084


MARK	REVISION	BY	APP.	DATE
Δ	REVISED TO AS BUILT	A.J.S.		8.28.84

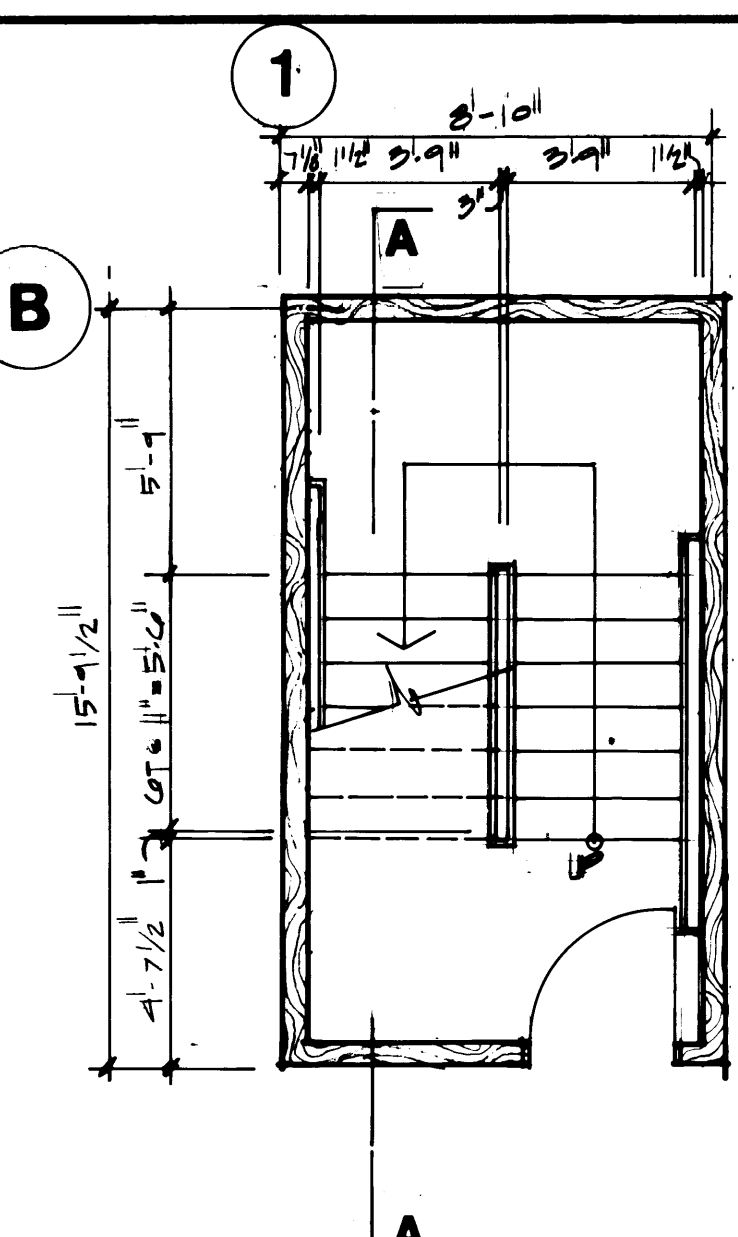


STAIR PLAN
FIRST FLOOR LEVEL

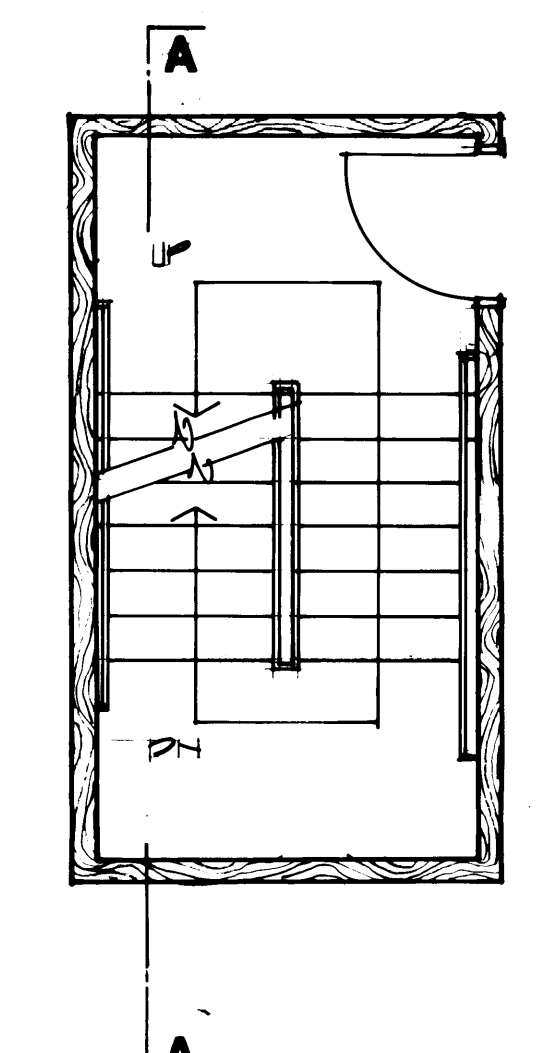

STAIR PLAN
SECOND FLOOR LEVEL

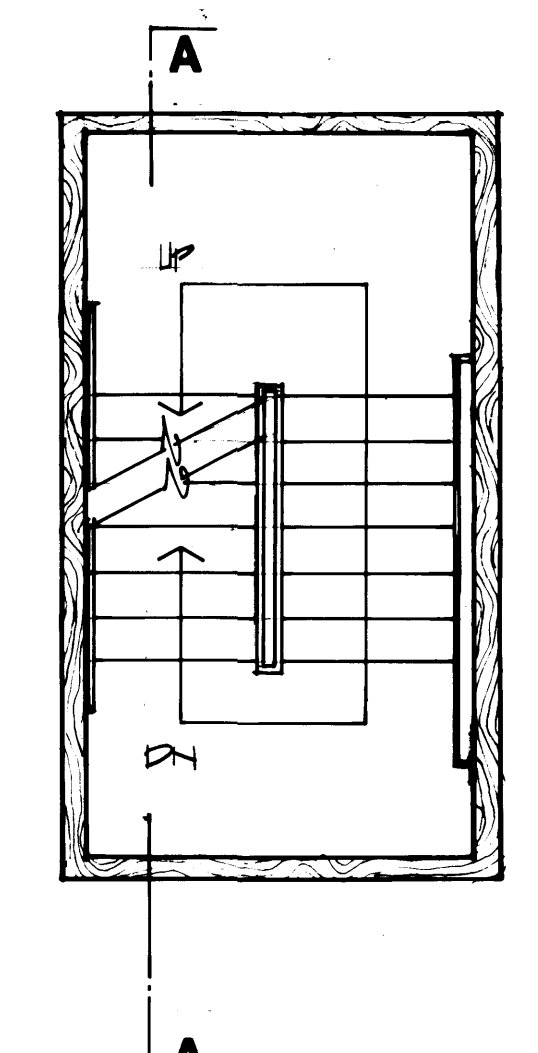


STAIR PLAN
INTERMEDIATE LEVEL

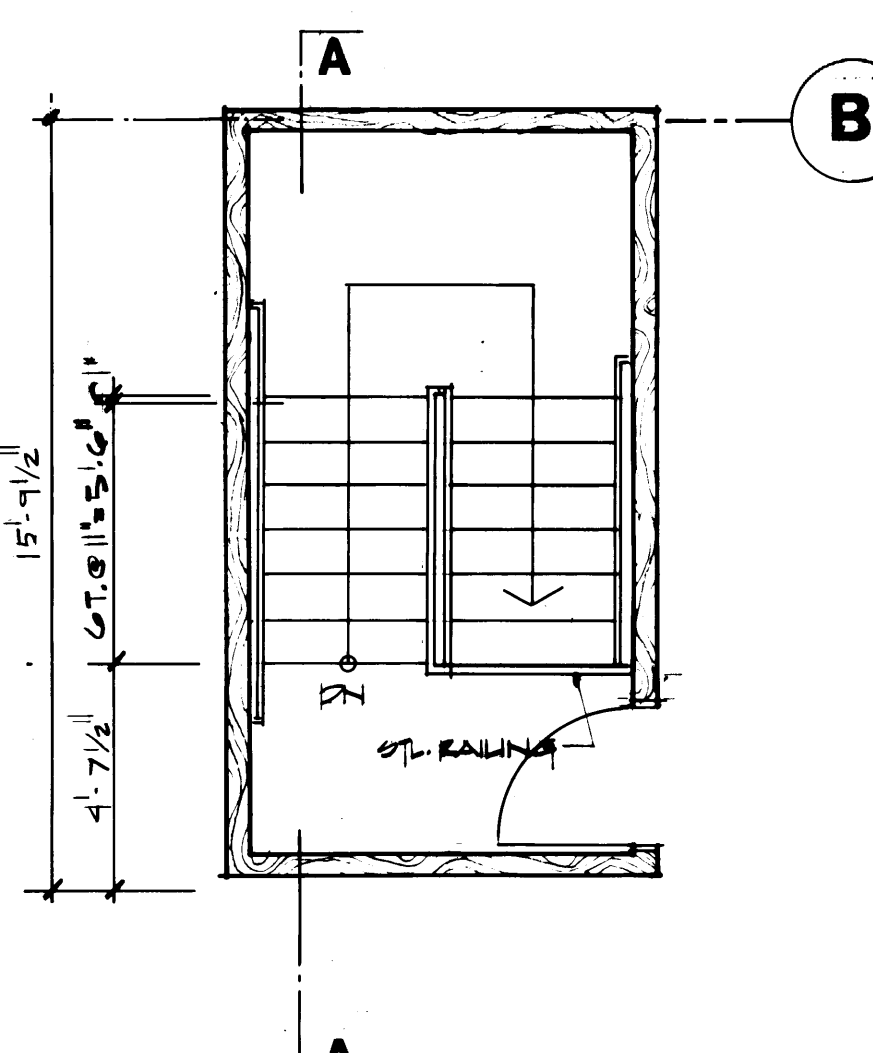


STAIR PLAN
THIRD FLOOR PLAN


STAIR NO. 1 PLANS
1/4\"=1'-0\"

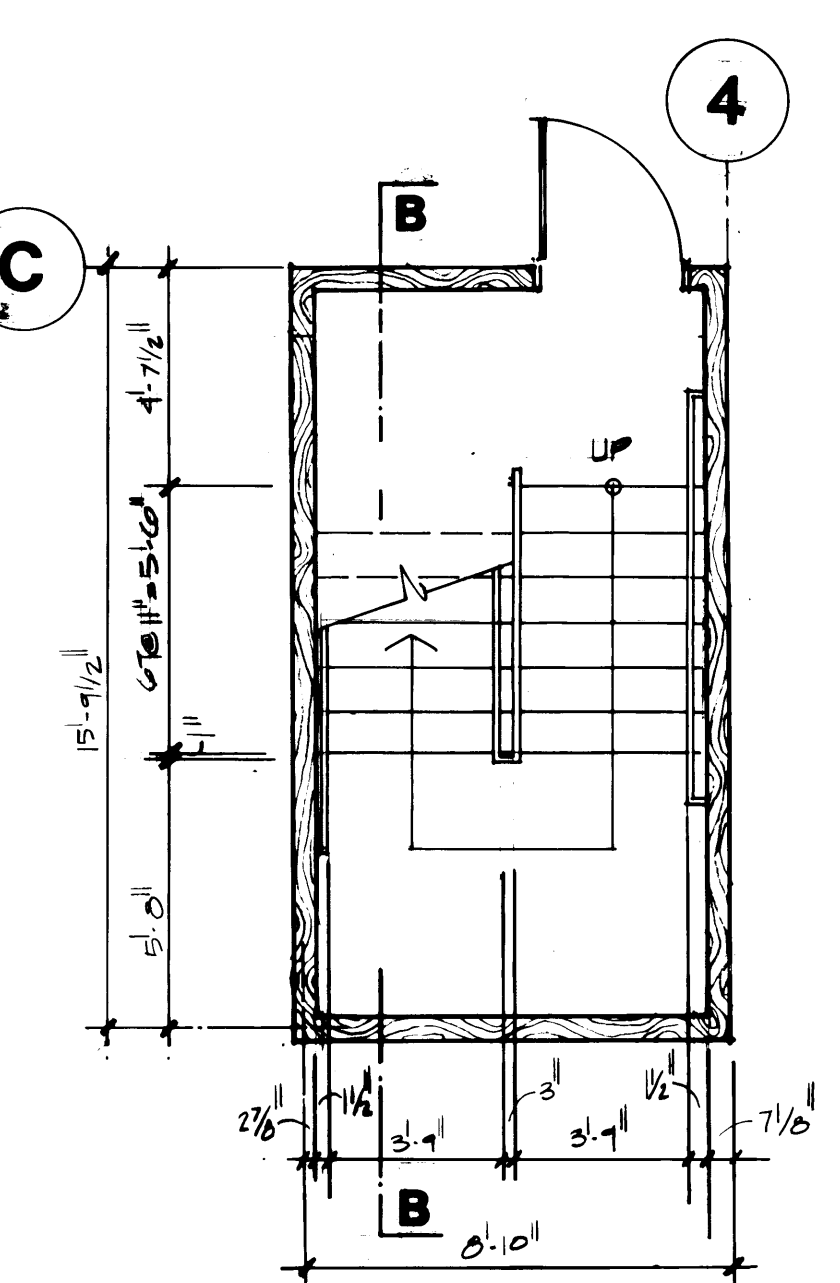


STAIR PLAN
FIRST FLOOR LEVEL

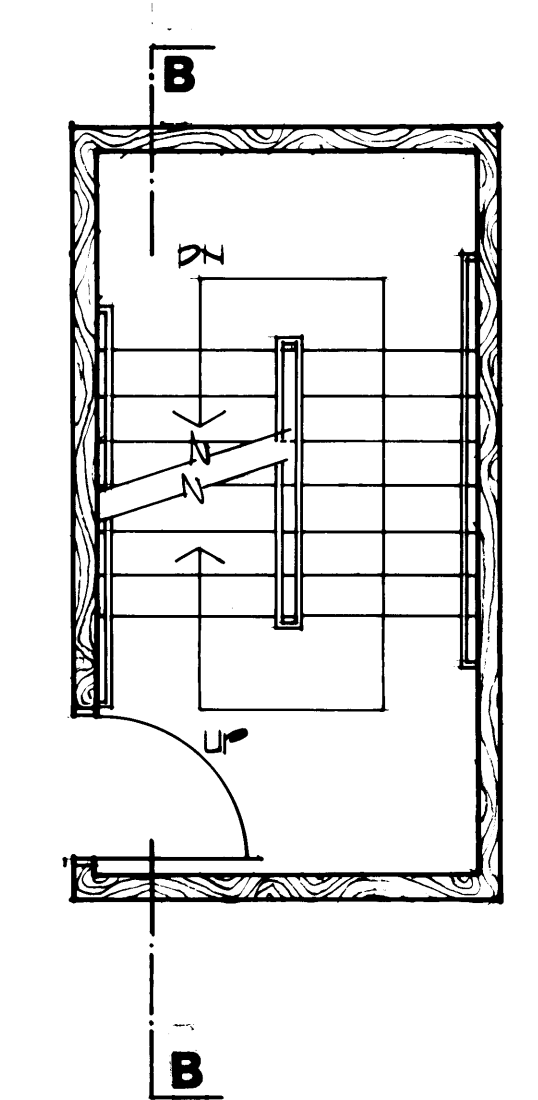

STAIR PLAN
SECOND FLOOR LEVEL

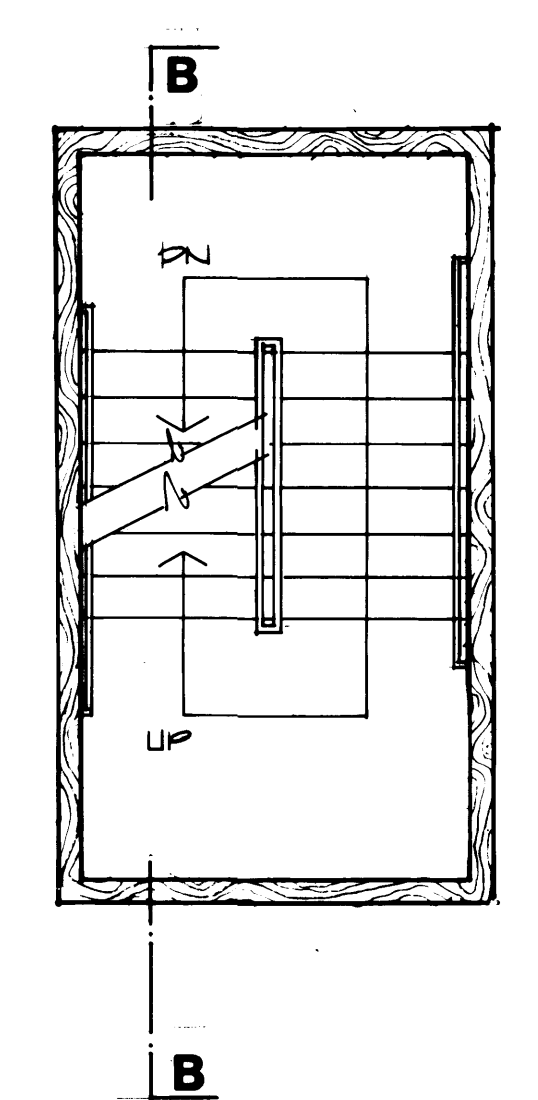


STAIR PLAN
INTERMEDIATE LEVEL

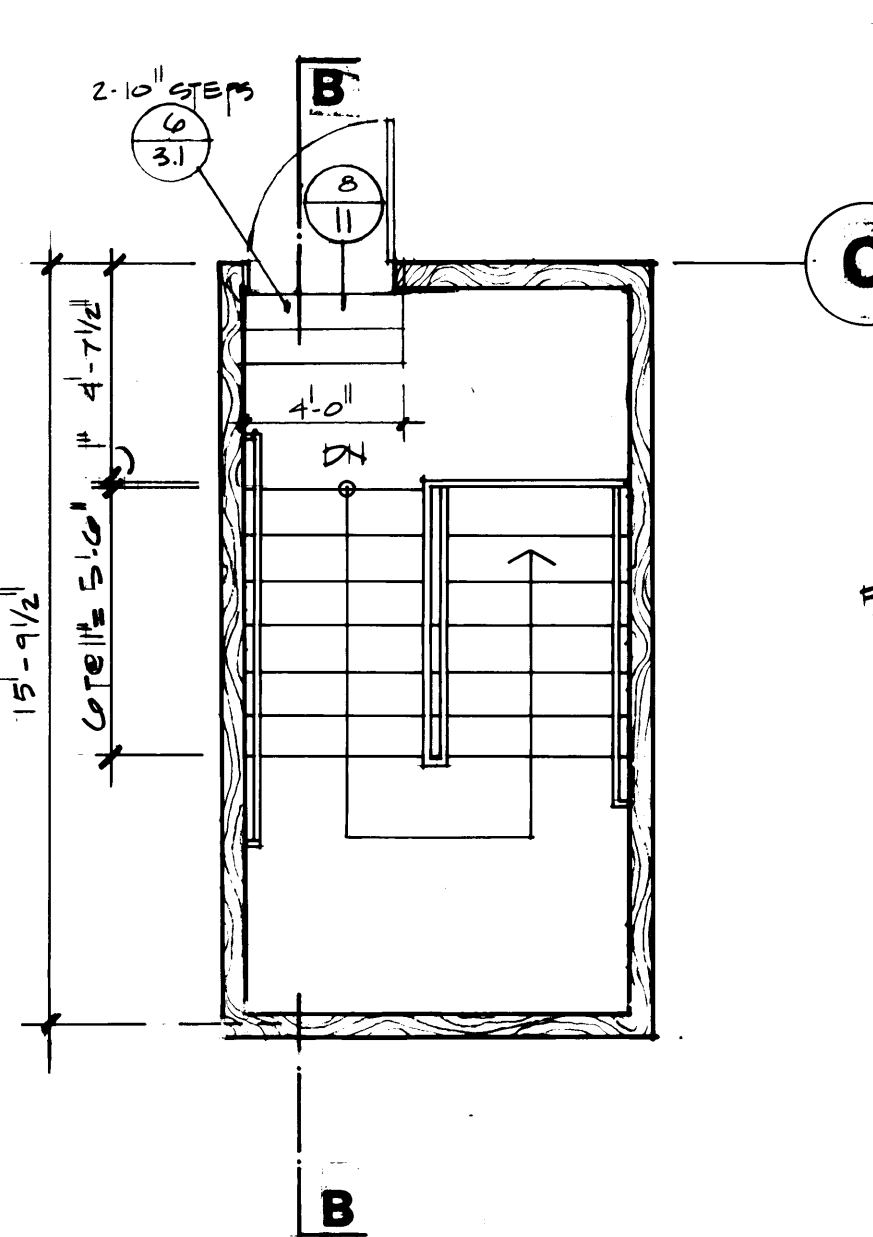


STAIR PLAN
THIRD FLOOR PLAN

STAIR NO. 2 PLANS
1/4\"=1'-0\"

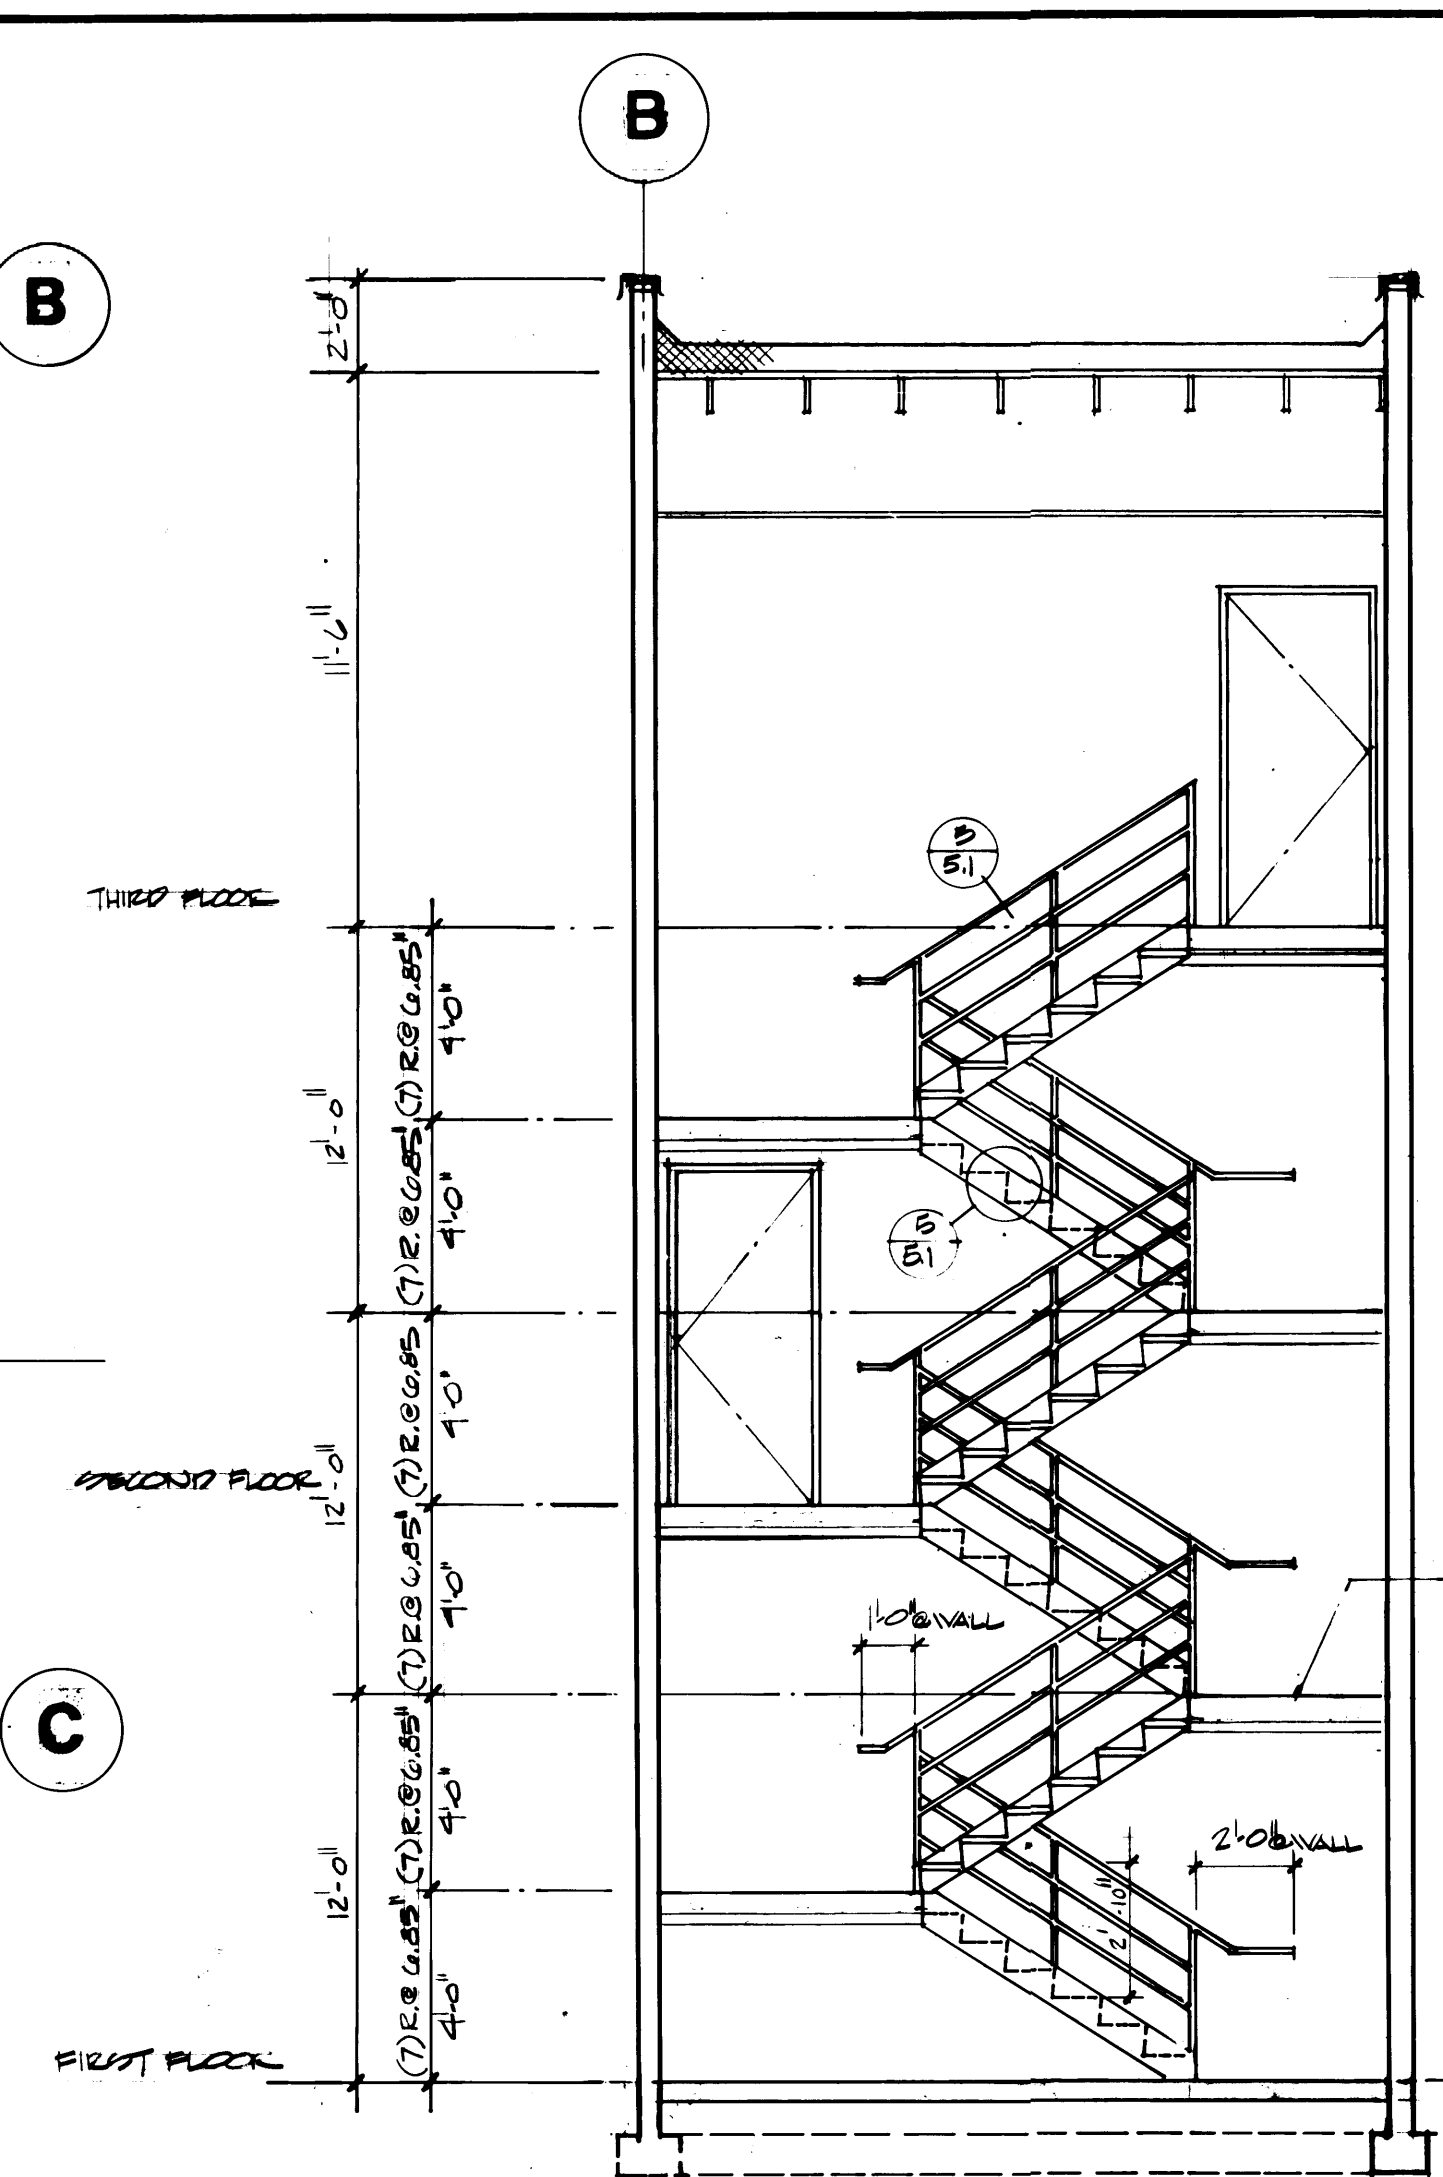

STAIR SECTION A
STAIR NO. ONE 1/4\"=1'-0\"

STAIR NO. 1	FLOOR	BASE	WALL	CEILING
FINISH SCHEDULE	14	20	33	53

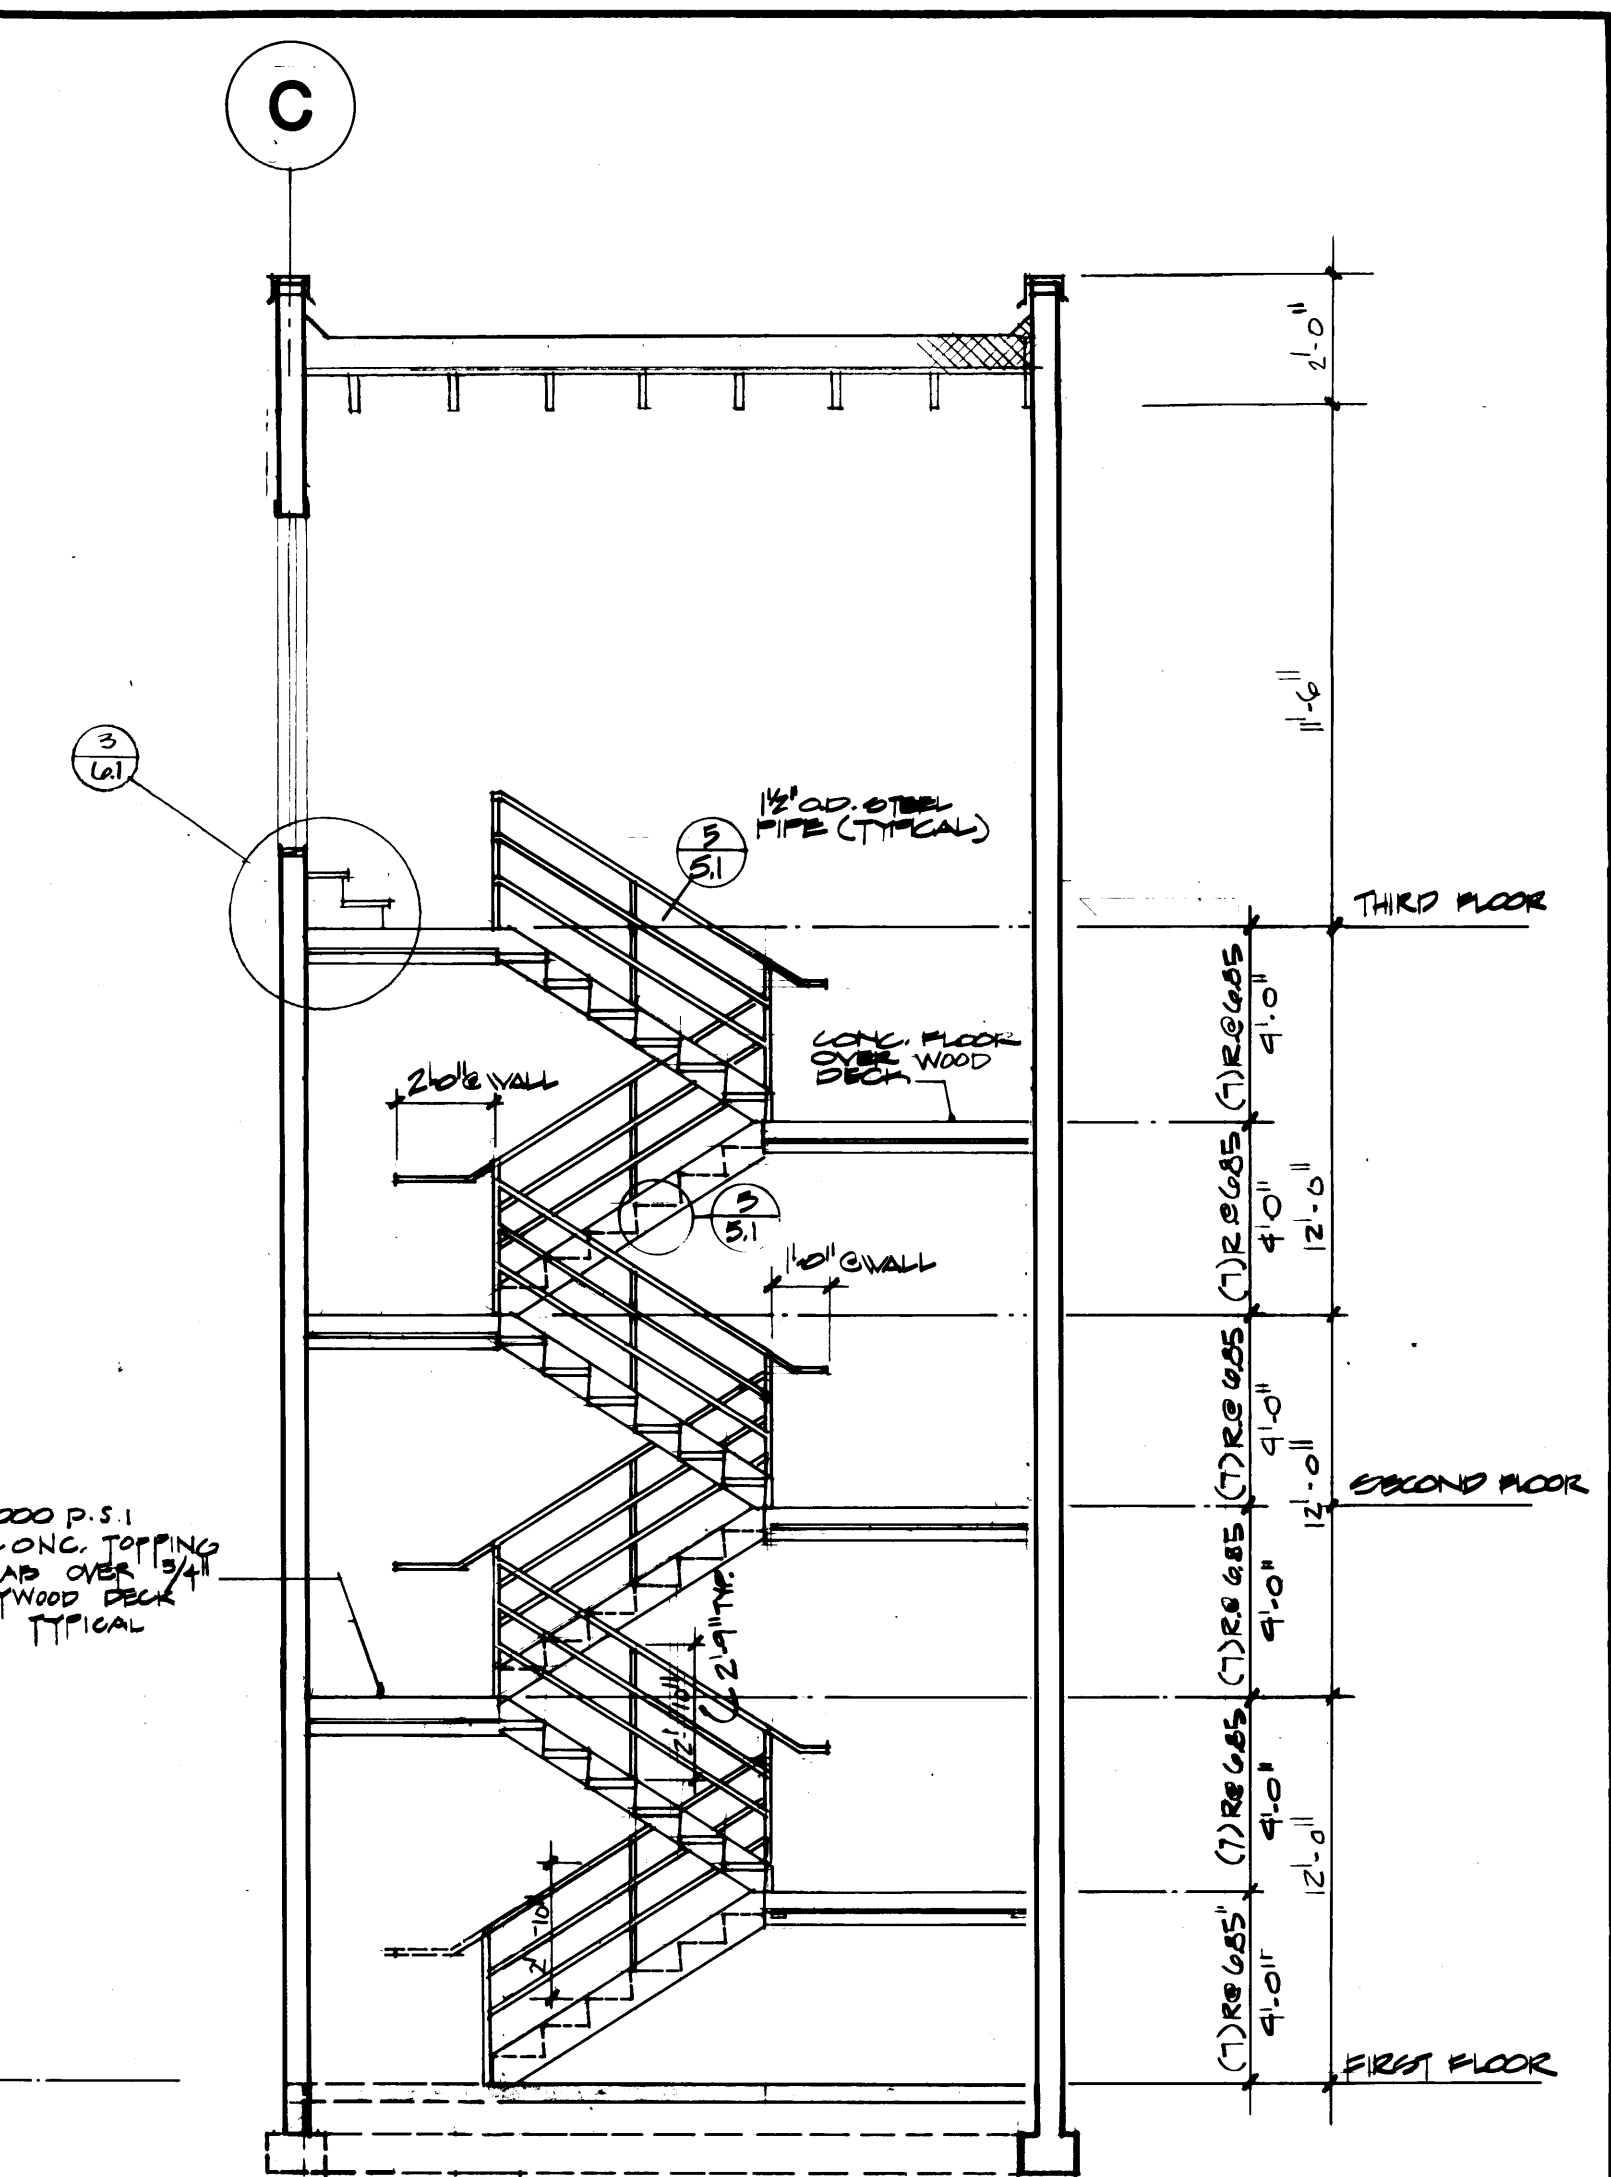

STAIR SECTION B
STAIR NO. TWO 1/4\"=1'-0\"

STAIR NO. 2	FLOOR	BASE	WALL	CEILING
FINISH SCHEDULE	14	20	33	53







MCGRANAHAN, MESSENGER ASSOCIATES
ARCHITECTURE / PLANNING / INTERIORS
MEMBER AMERICAN INSTITUTE OF ARCHITECTS • 950 FAWCETT BLVD. SUITE 300, TACOMA, WA 98402 • (206) 383-3034

1595
REGISTERED ARCHITECT
JAMES I. MCGRANAHAN
STATE OF WASHINGTON


2618
REGISTERED ARCHITECT
LYN H. MESSENGER
STATE OF WASHINGTON

DRAWN <u>J.F. MCG</u> DATE <u>9/24/84</u>		PORT OF TACOMA	
CHECKED _____ DATE _____		TACOMA TERMINALS, INC.	
CHECKED _____ DATE _____		MARINE SERVICES BUILDING	
CONT. NO. <u>582</u>		STAIR PLANS & SECTIONS	
APPROVED <u>[Signature]</u> 9/24/84		SCALE <u>AS NOTED</u>	
PROJECT MANAGER <u>[Signature]</u>		DRAWING NO. <u>EP-3893-23</u>	
CHIEF ENGINEER <u>[Signature]</u>		6-A11-8	
DATE _____		SHEET <u>A11-8</u> OF <u>13</u>	


MARK	REVISION	BY	APP.	DATE
△	REVISED TO AS-BUILT	RJS		9-28-85

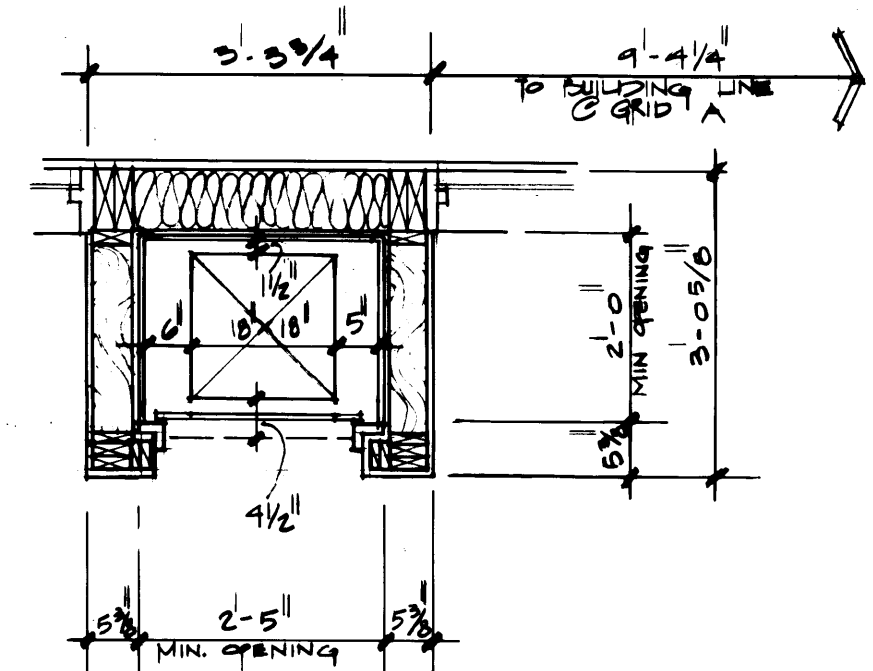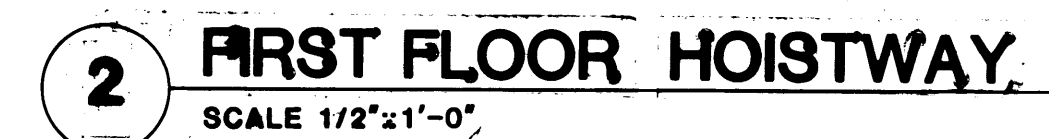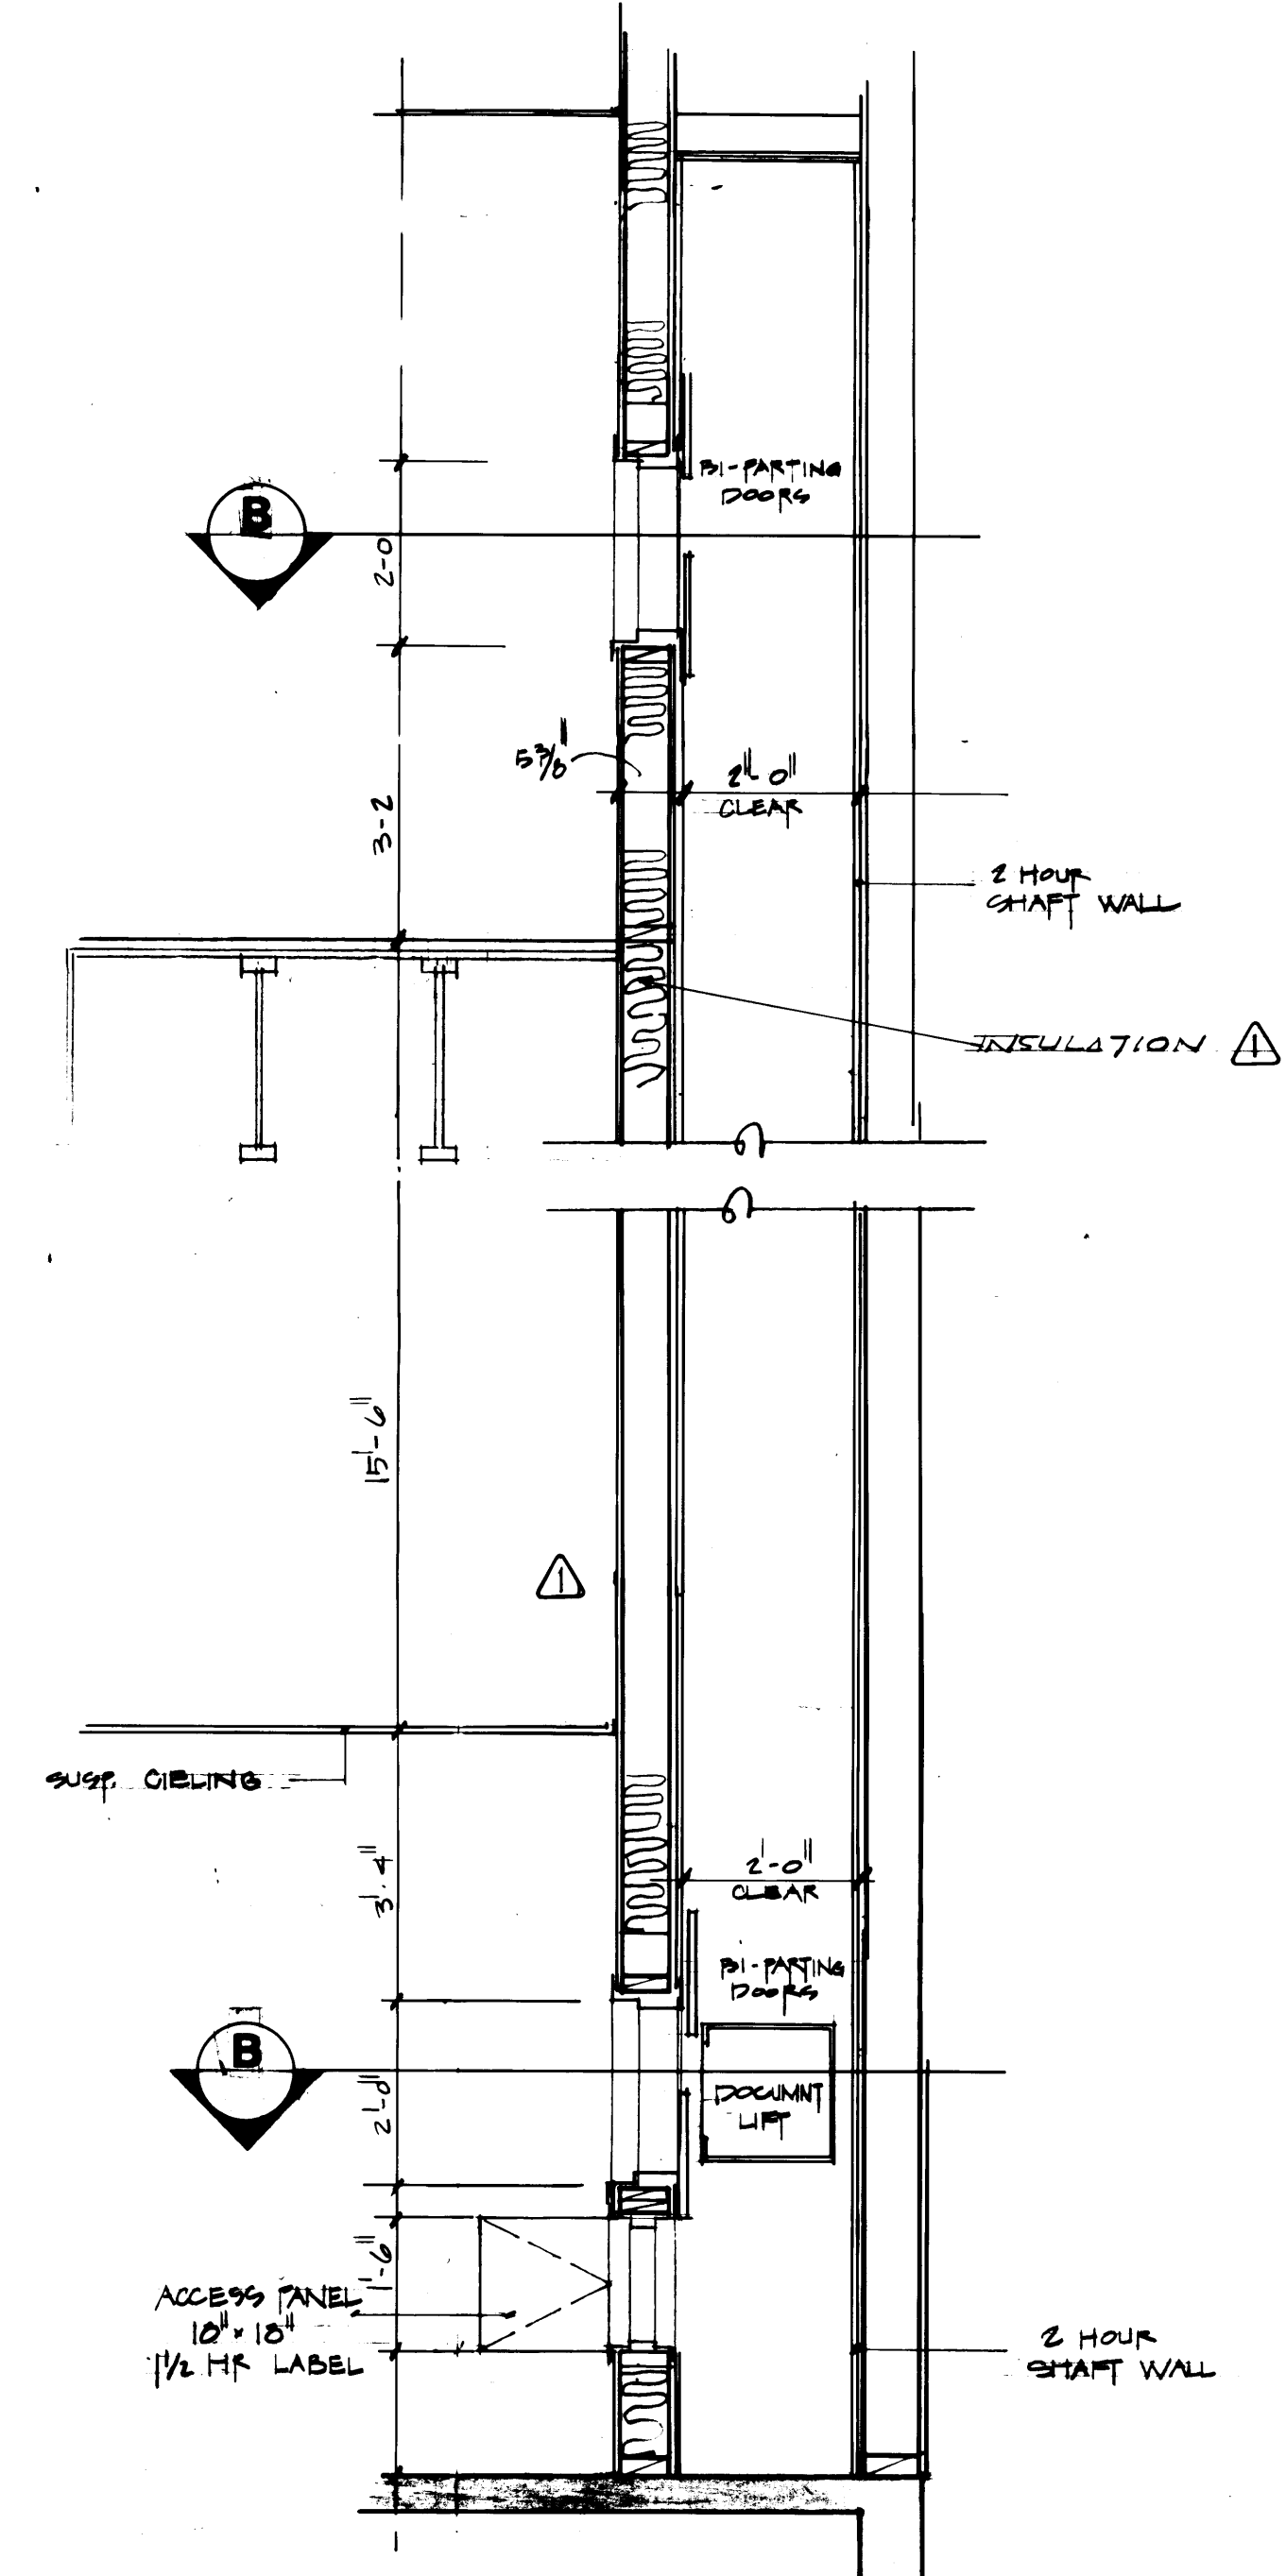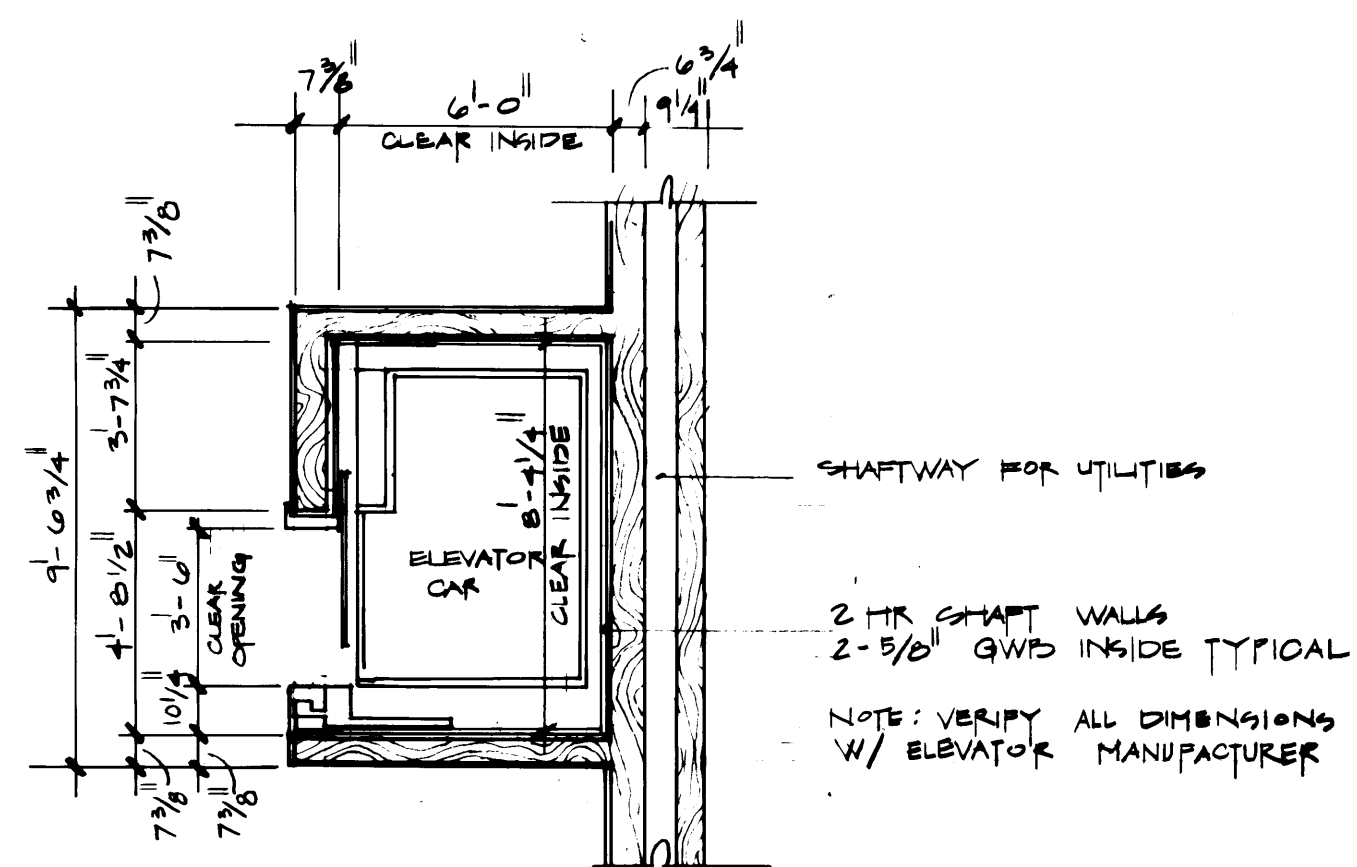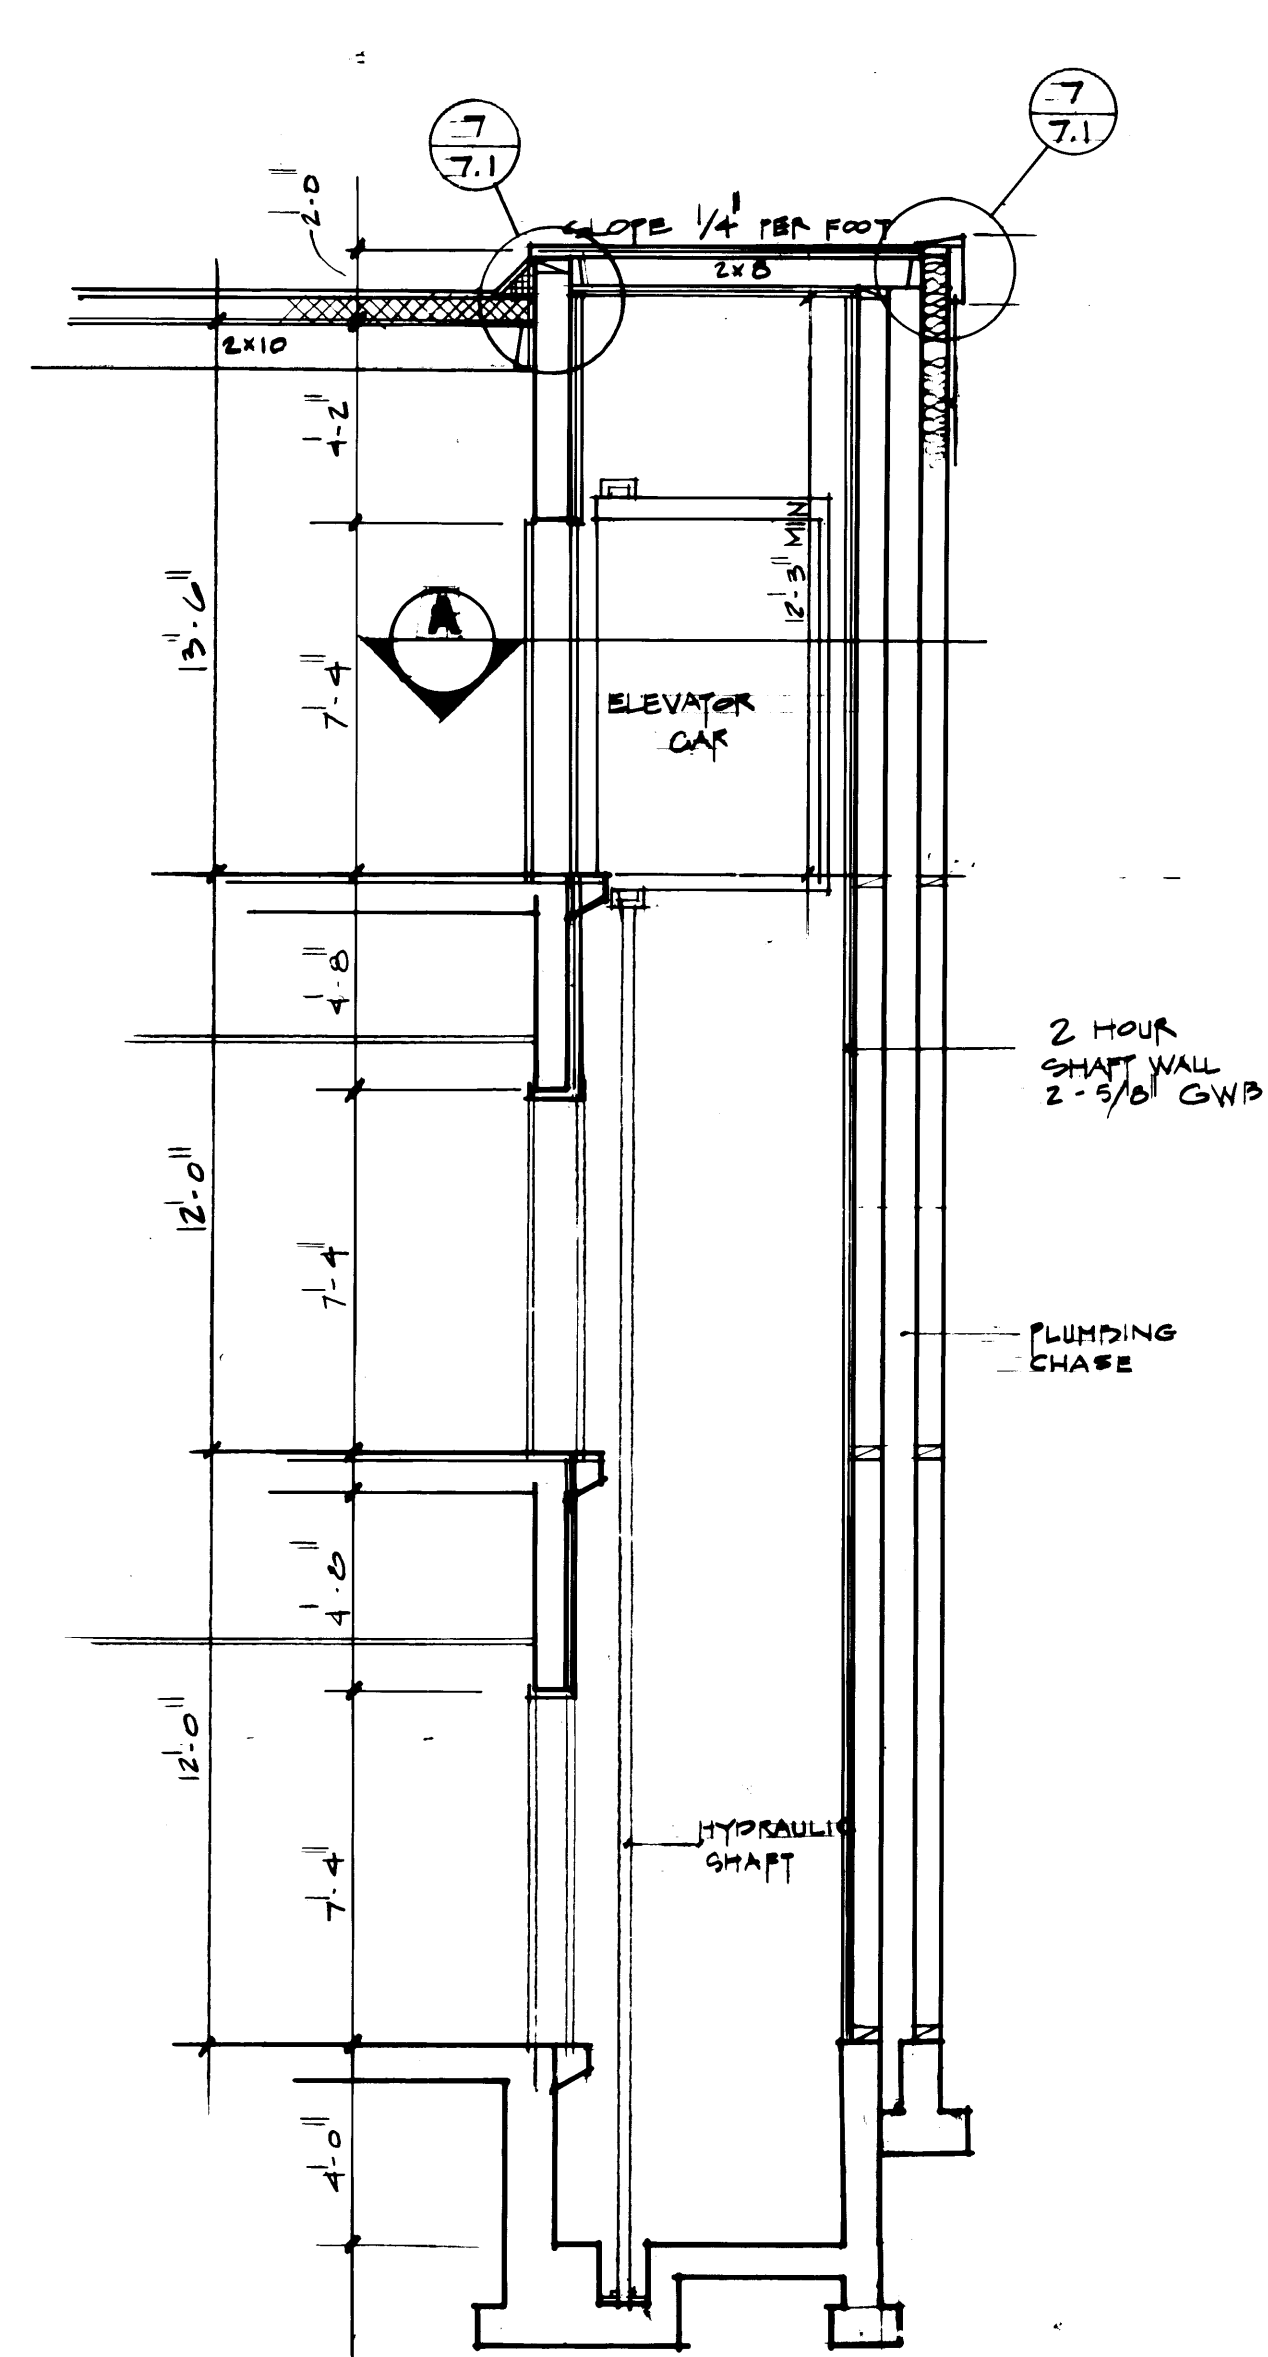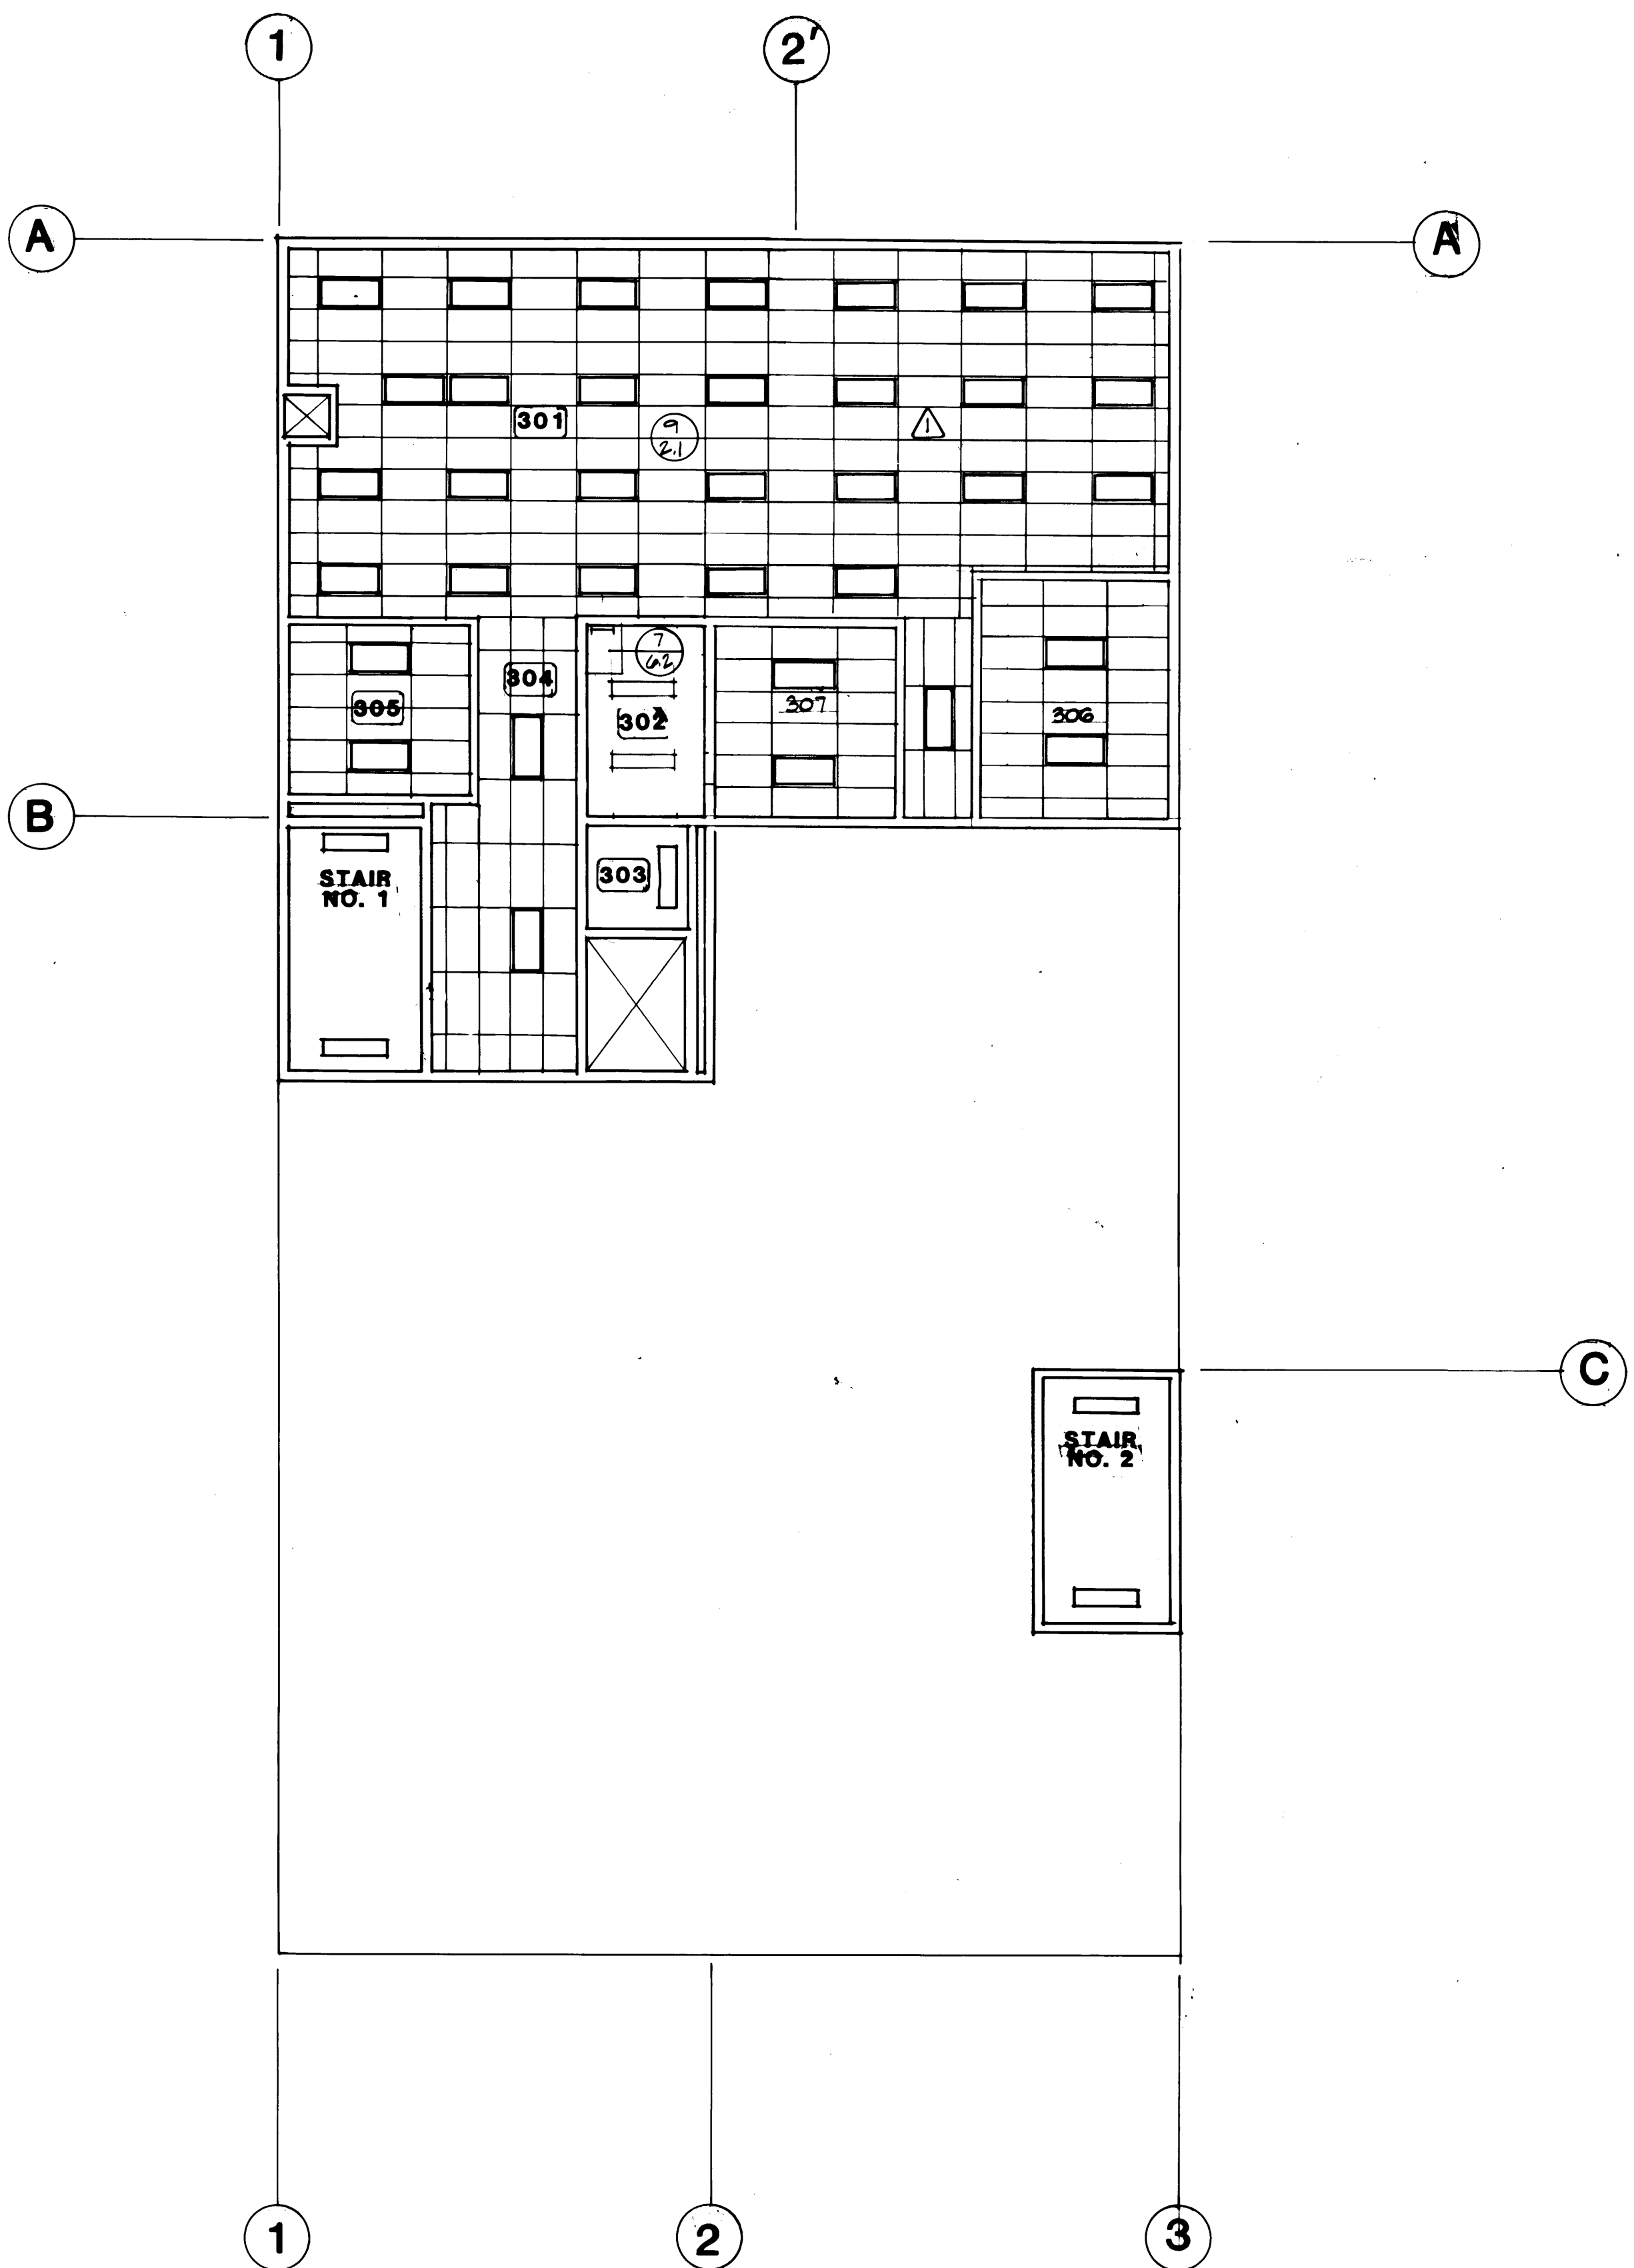




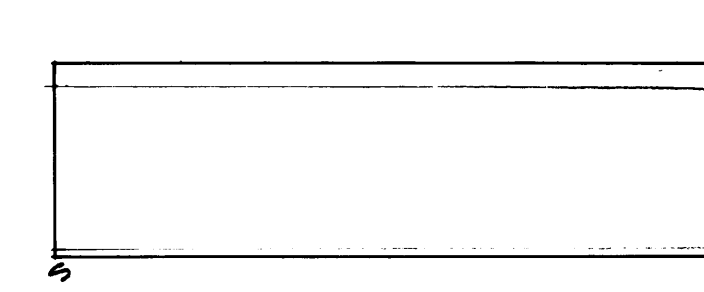


CORRIDOR 100	FLOOR	BASE	WALL	CEILING
FINISH SCHEDULE	12	20	30	55

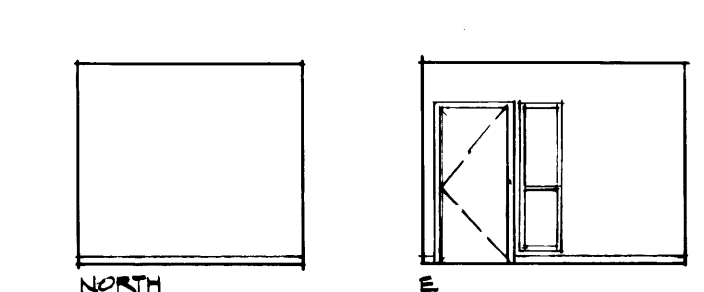


OFFICE 202	FLOOR	BASE	WALL	CEILING
FINISH SCHEDULE	13	20	32	5

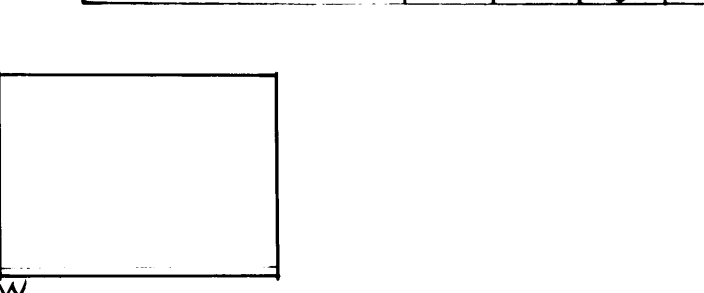


OFFICE 205	FLOOR	BASE	WALL	CEILING
FINISH SCHEDULE	13	20	32	55

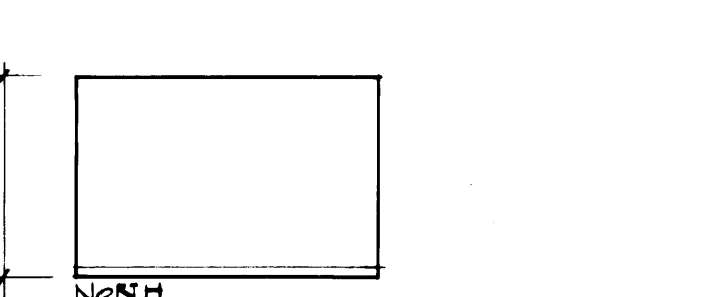


OFFICE 209	FLOOR	BASE	WALL	CEIL
FINISH SCHEDULE	13	20	32	5

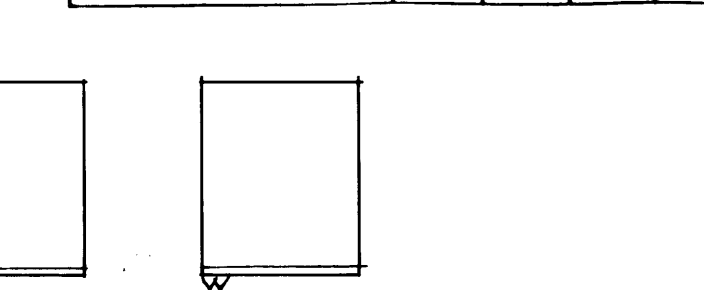

RADIO 212	FLOOR	BASE	WALL	CEILING
FINISH SCHEDULE	13	20	32	55

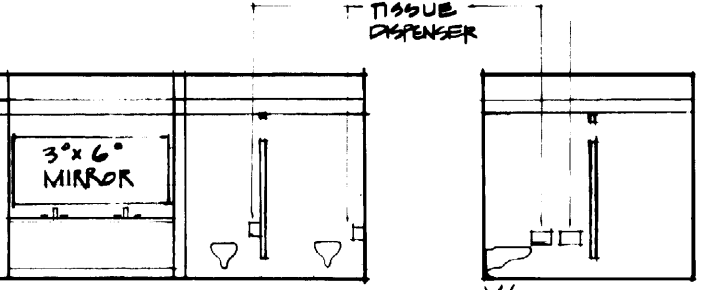

W TOILET 218	FLOOR	BASE	WALL	CEILING
FINISH SCHEDULE	15	22	35	54

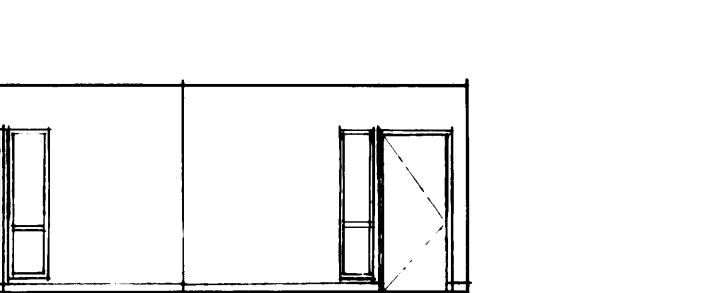

OPEN OFF. 216	FLOOR	BASE	WALL	CEILING
---------------	-------	------	------	---------


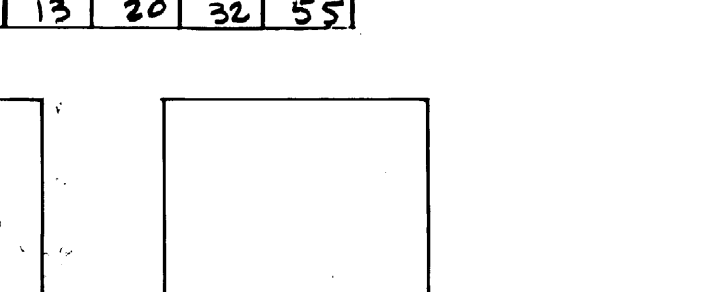





CHART RM 221	FLOOR	BASE	WALL	CEILING
--------------	-------	------	------	---------



JAN CLST 234	FLOOR	BASE	WALL	CEILING
--------------	-------	------	------	---------

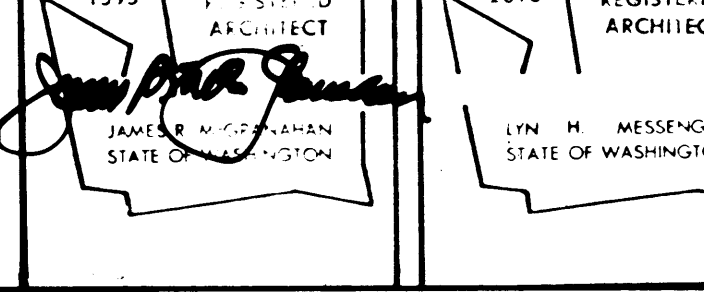

NORTH

WAITING	FLOOR	BASE	WALL	CEILING
---------	-------	------	------	---------

ARCHITECTURE / PLANNING / INTERIOR

11, SUITE 300, TACOMA, WA 98402 • (206) 383-3088

--	--	--	--

--	--	--	--

	A. J. S.		B. 29
--	----------	--	-------

	BY	APP.	DATE
--	----	------	------

FIELD BOOK (S) _____

APPROVED


85

CHIEF


[illegible]

DRAWING NO.
SD-2802-22


CT MANAGER DATE 4

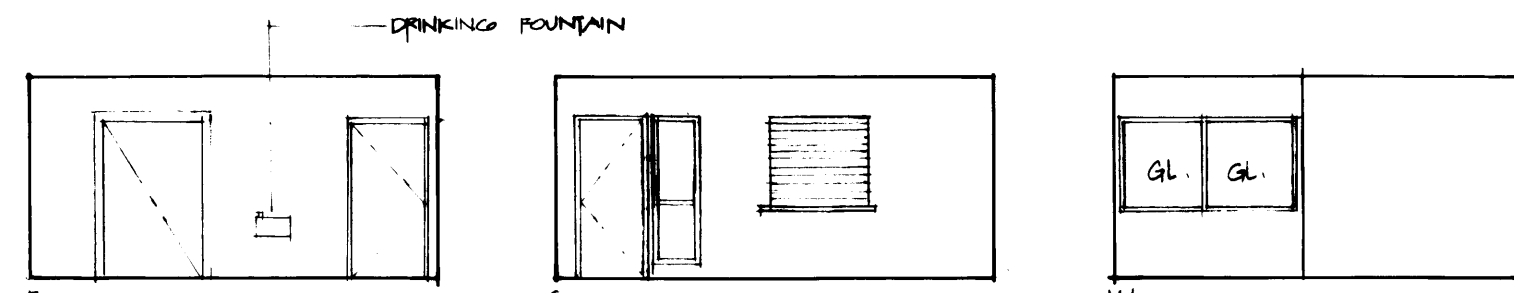


200 CONT.	FLOOR	BASE	WALL	CEILING
FINISH SCHEDULE	13	20	37	55

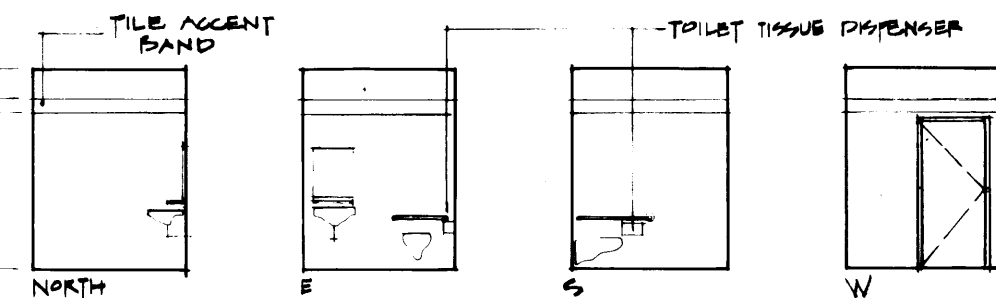


TOILET 303	FLOOR	BASE	WALL	CEILING
FINISH SCHEDULE	13	20	37	55

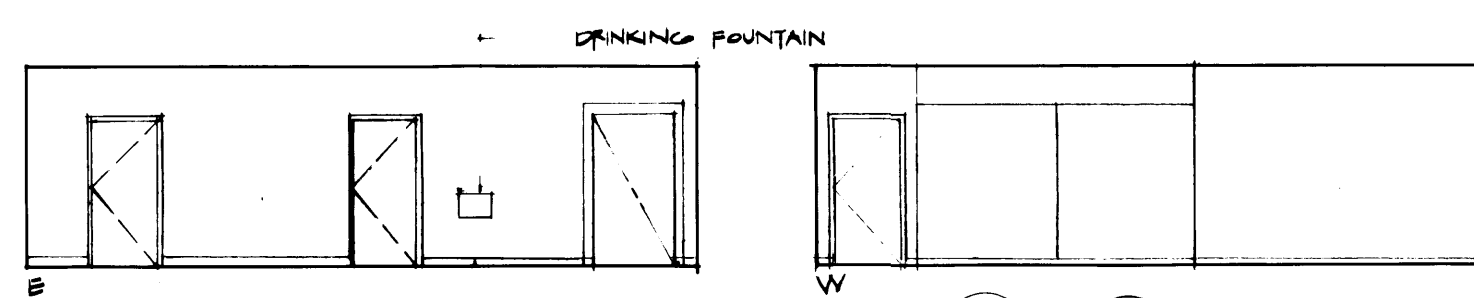

OFFICE 304	FLOOR	BASE	WALL	CEILING
FINISH SCHEDULE	13	20	37	55

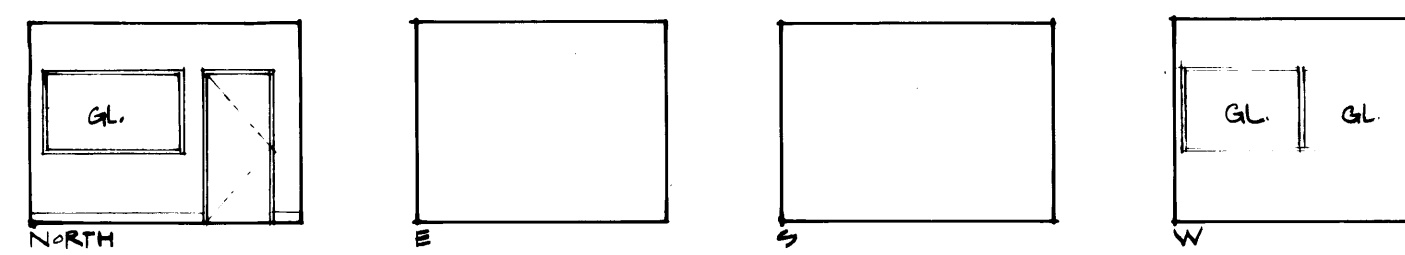

OFFICE 305	FLOOR	BASE	WALL	CEILING
FINISH SCHEDULE	13	20	37	55

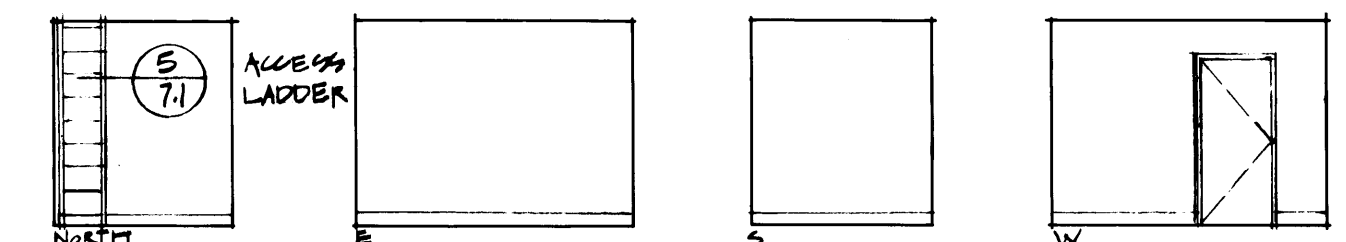

STORAGE 302	FLOOR	BASE	WALL	CEILING
FINISH SCHEDULE	12	20	32	53

SCHEDULE OF MATERIALS

FLOORS

- 10 Concrete Hardener & Sealer
- 11 Concrete - Light Broom Finish
- 12 V.A.T.
- 13 Carpet
- 14 Concrete - Sealer
- 15 Ceramic Tile

BASE


- 20 4" Rubber Base
- 22 Ceramic Tile

WALLS


- 32 Gypsum Wallboard Painted
- 33 Gypsum Wallboard Epoxy
- 34 Acoustic Panels
- 35 Ceramic Tile
- 36 Fiberglass Reinforced Panel
- 37 Gypsum Wallboard Vinyl
- 38 Wood Paneling
- 39 Plywood Painted

CEILING


- 52 Structure Painted
- 53 Gypsum Wallboard Painted/Suspended
- 54 12x12 Acoustic Panels Over Gypsum Wallboard
- 55 24x48 Acoustic Panels Suspended
- 56 Exposed Structure
- 57 Ceramic Tile

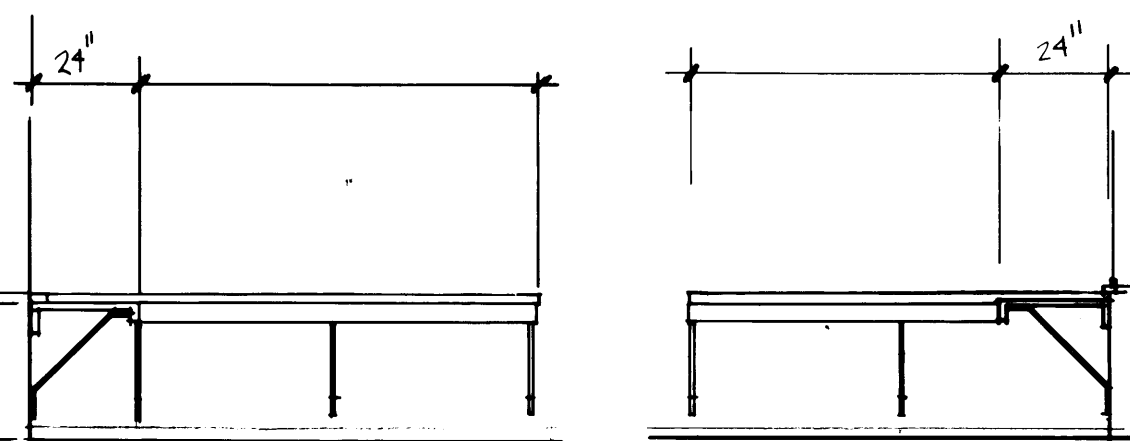


OFFICE COUNTER RM101

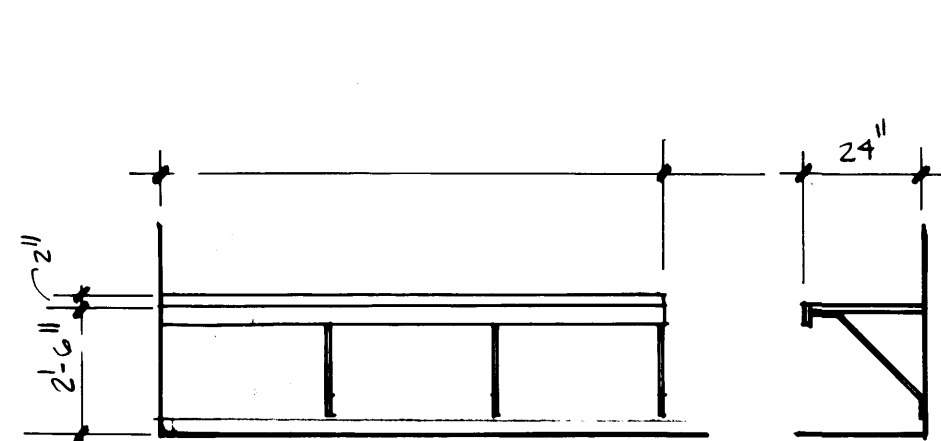


OFFICE COUNTER RM 102

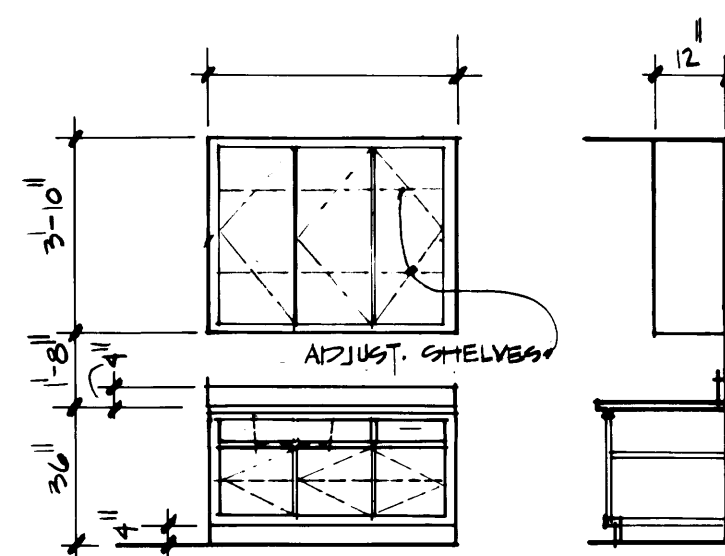


BREAKRM 119 CABINET

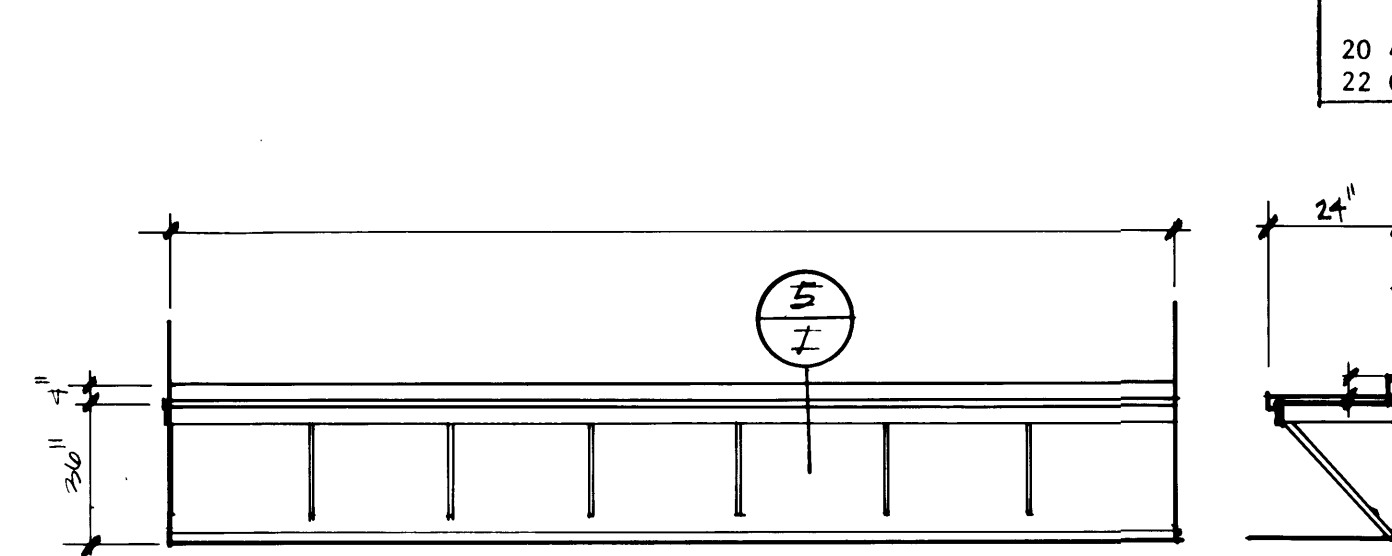


ELEC SHOP COUNTER RM120

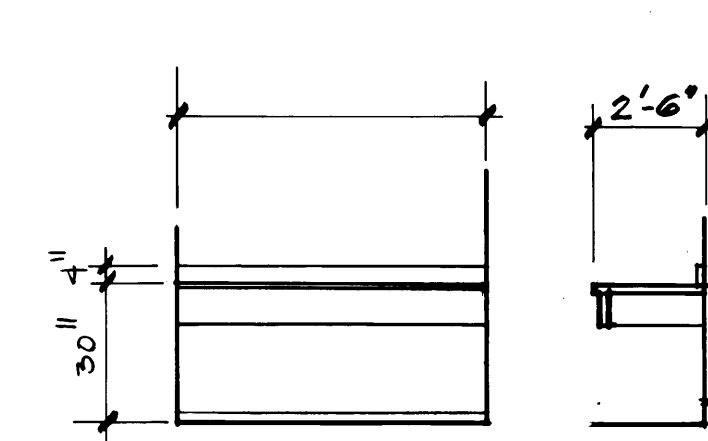


RESTROOM 214 COUNTER

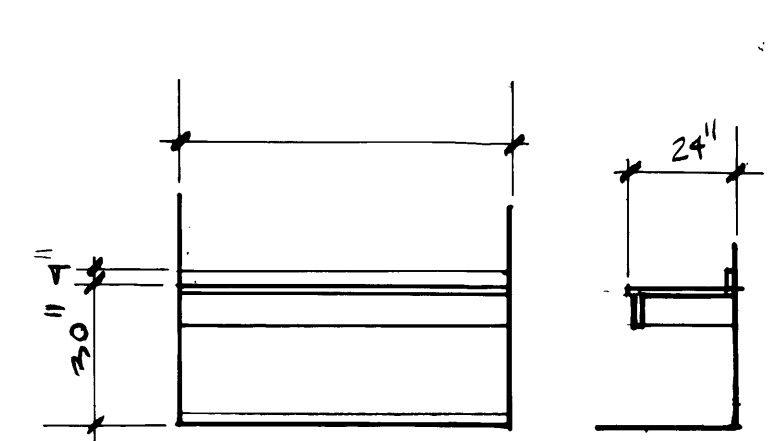

RESTROOM 215 COUNTER

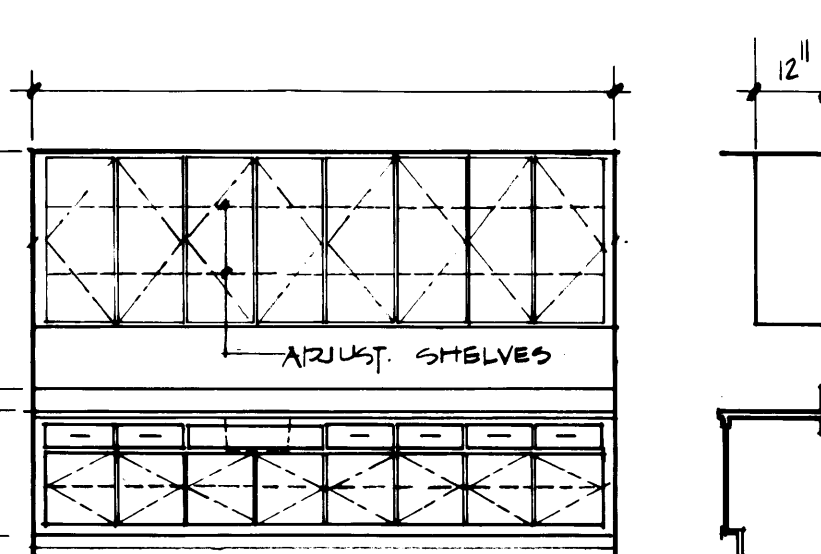


BREAKRM 213 CABINET

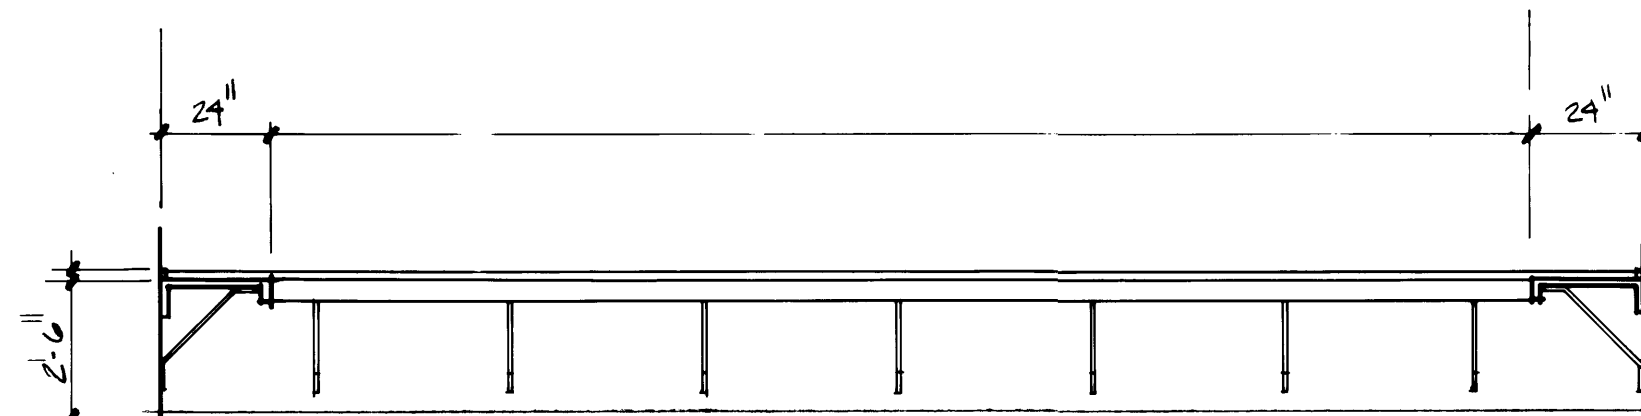


OFFICE 301 COUNTER


COUNTERS IN ROOMS 101, 102, 119, 214, 215
218, 301, 307 & 117 SHALL BE PLASTIC
L.D.

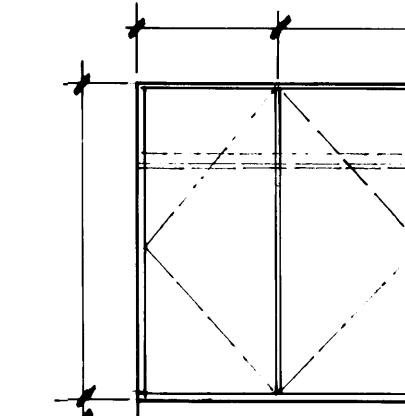



STORAGE CABINET A

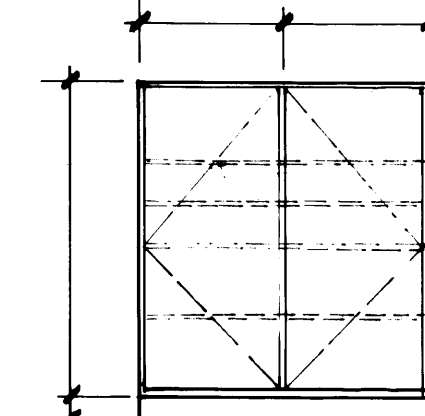


STORAGE CABINET B

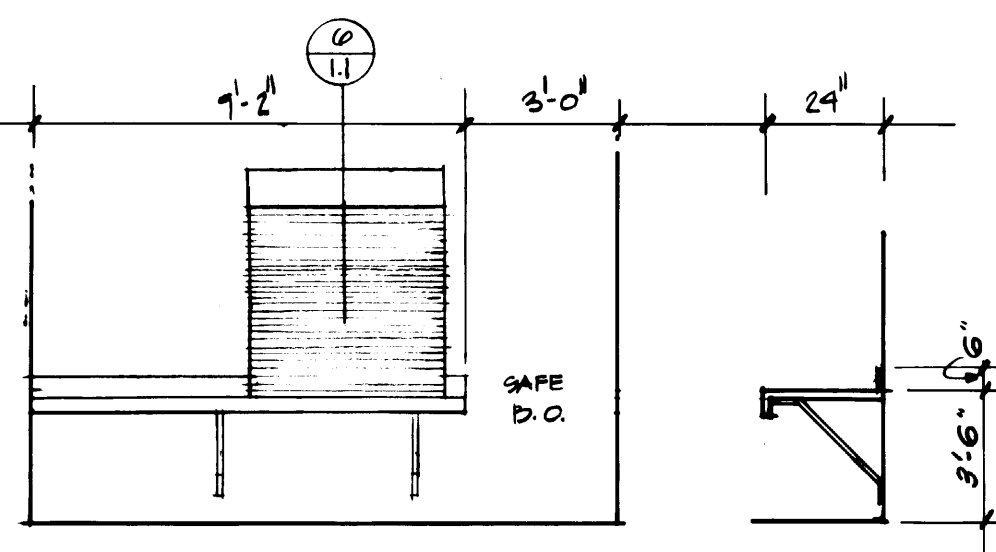


RAYMASTER RM 117 COUNTER

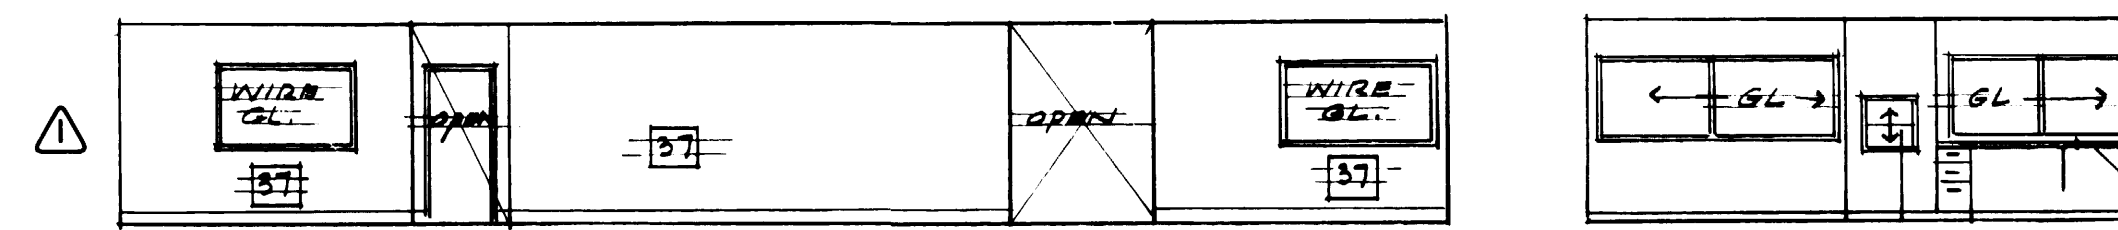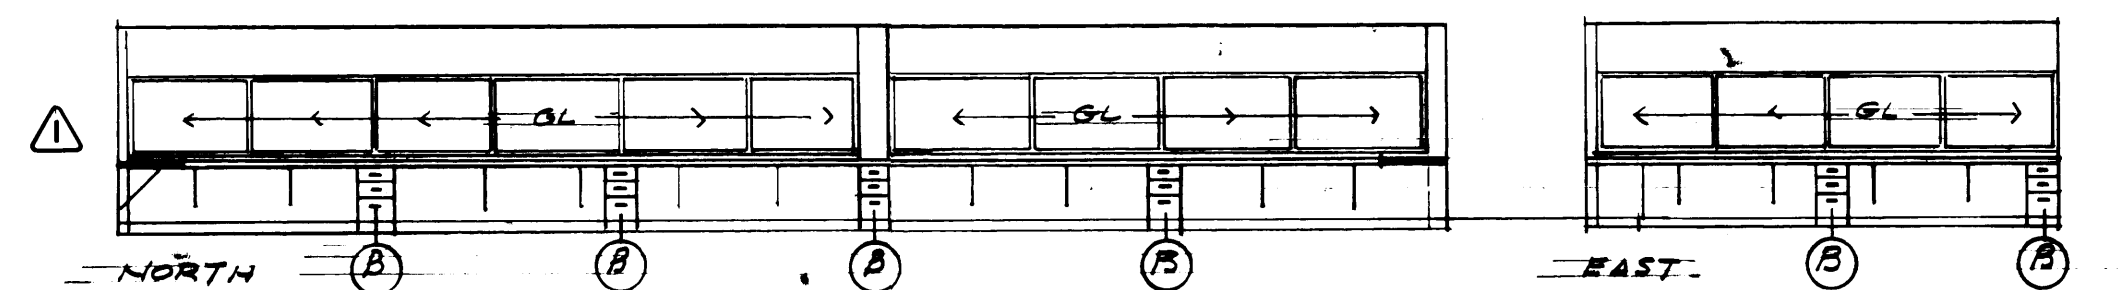


OFFICE 301	FLOOR	BASE	WALL	CEILING
FINISH SCHEDULE	13	20	37	55

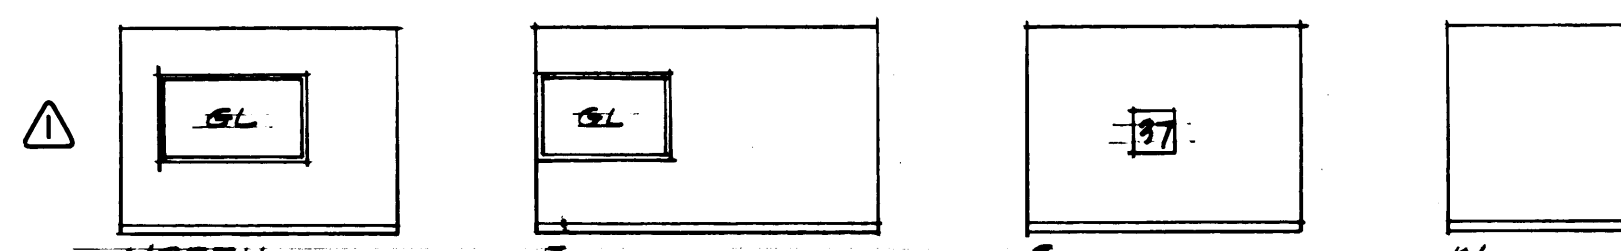


OFFICE 306 A	FLOOR	BASE	WALL	CEILING
FINISH SCHEDULE	13	20	37	55

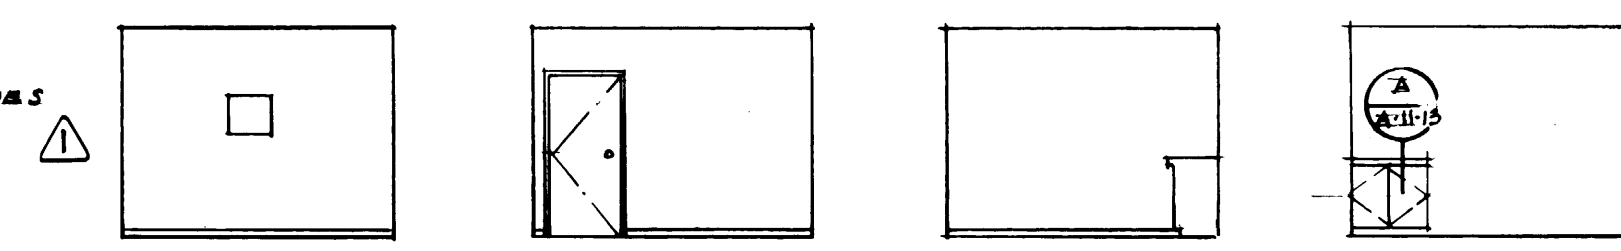

CONF 307	FLOOR	BASE	WALL	CEILING
FINISH SCHEDULE	13	20	37	55

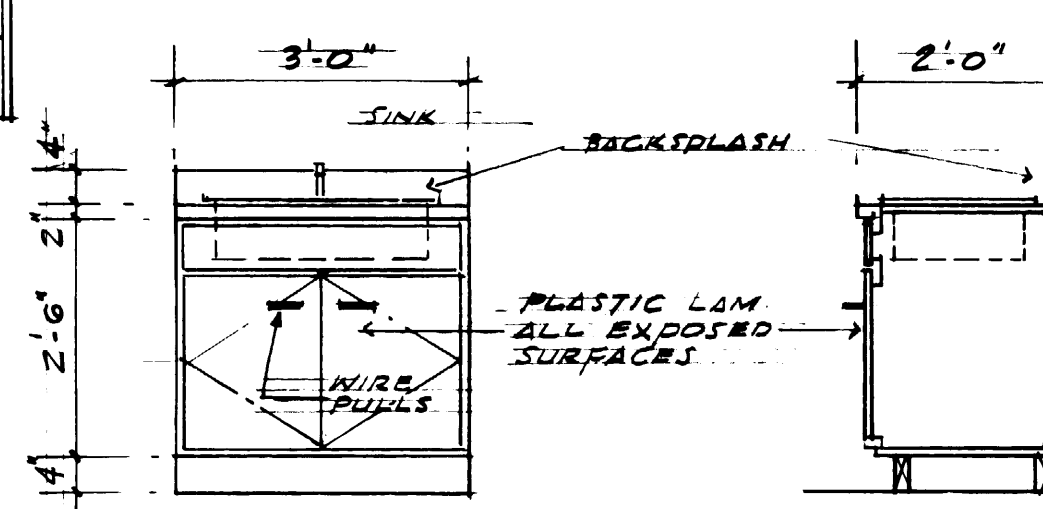

CONFERENCE 307 CABINET
SCALE 1/2" = 1'-0"

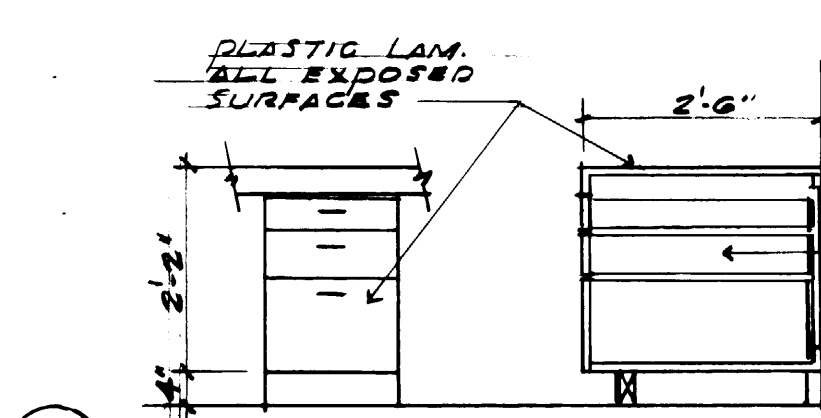

OFFICE 301 FILE CABINET
SCALE 1/2" = 1'-0" UNITS REQ'D

MCGRANAHAN,
MESSENGER
ASSOCIATES

ARCHITECTURE / PLANNING / INTERIORS

MEMBER AMERICAN INSTITUTE OF ARCHITECTS • 9501 PACIFIC AVE. SUITE 300, TACOMA, WA 98402 • (206) 383-3034



REVISION

BY APP. DATE

MARK

DRAWN	EP, MCG
DATE	9-21-84
CHECKED	
DATE	
CHECKED	
DATE	
CONT. NO.	562
FIELD BOOK (S)	
APPROVED	
PROJECT MANAGER	
DATE	9/24/84
DATE	
DATE	

PORT OF TACOMA	
TACOMA TERMINALS, INC.	
MARINE SERVICES BUILDING	
INTERIOR ELEVATIONS & CABINET DETAILS	
DRAWING NO.	EP-3893-23
6-A11-13	
A11-13	13
SHEET	OF 13

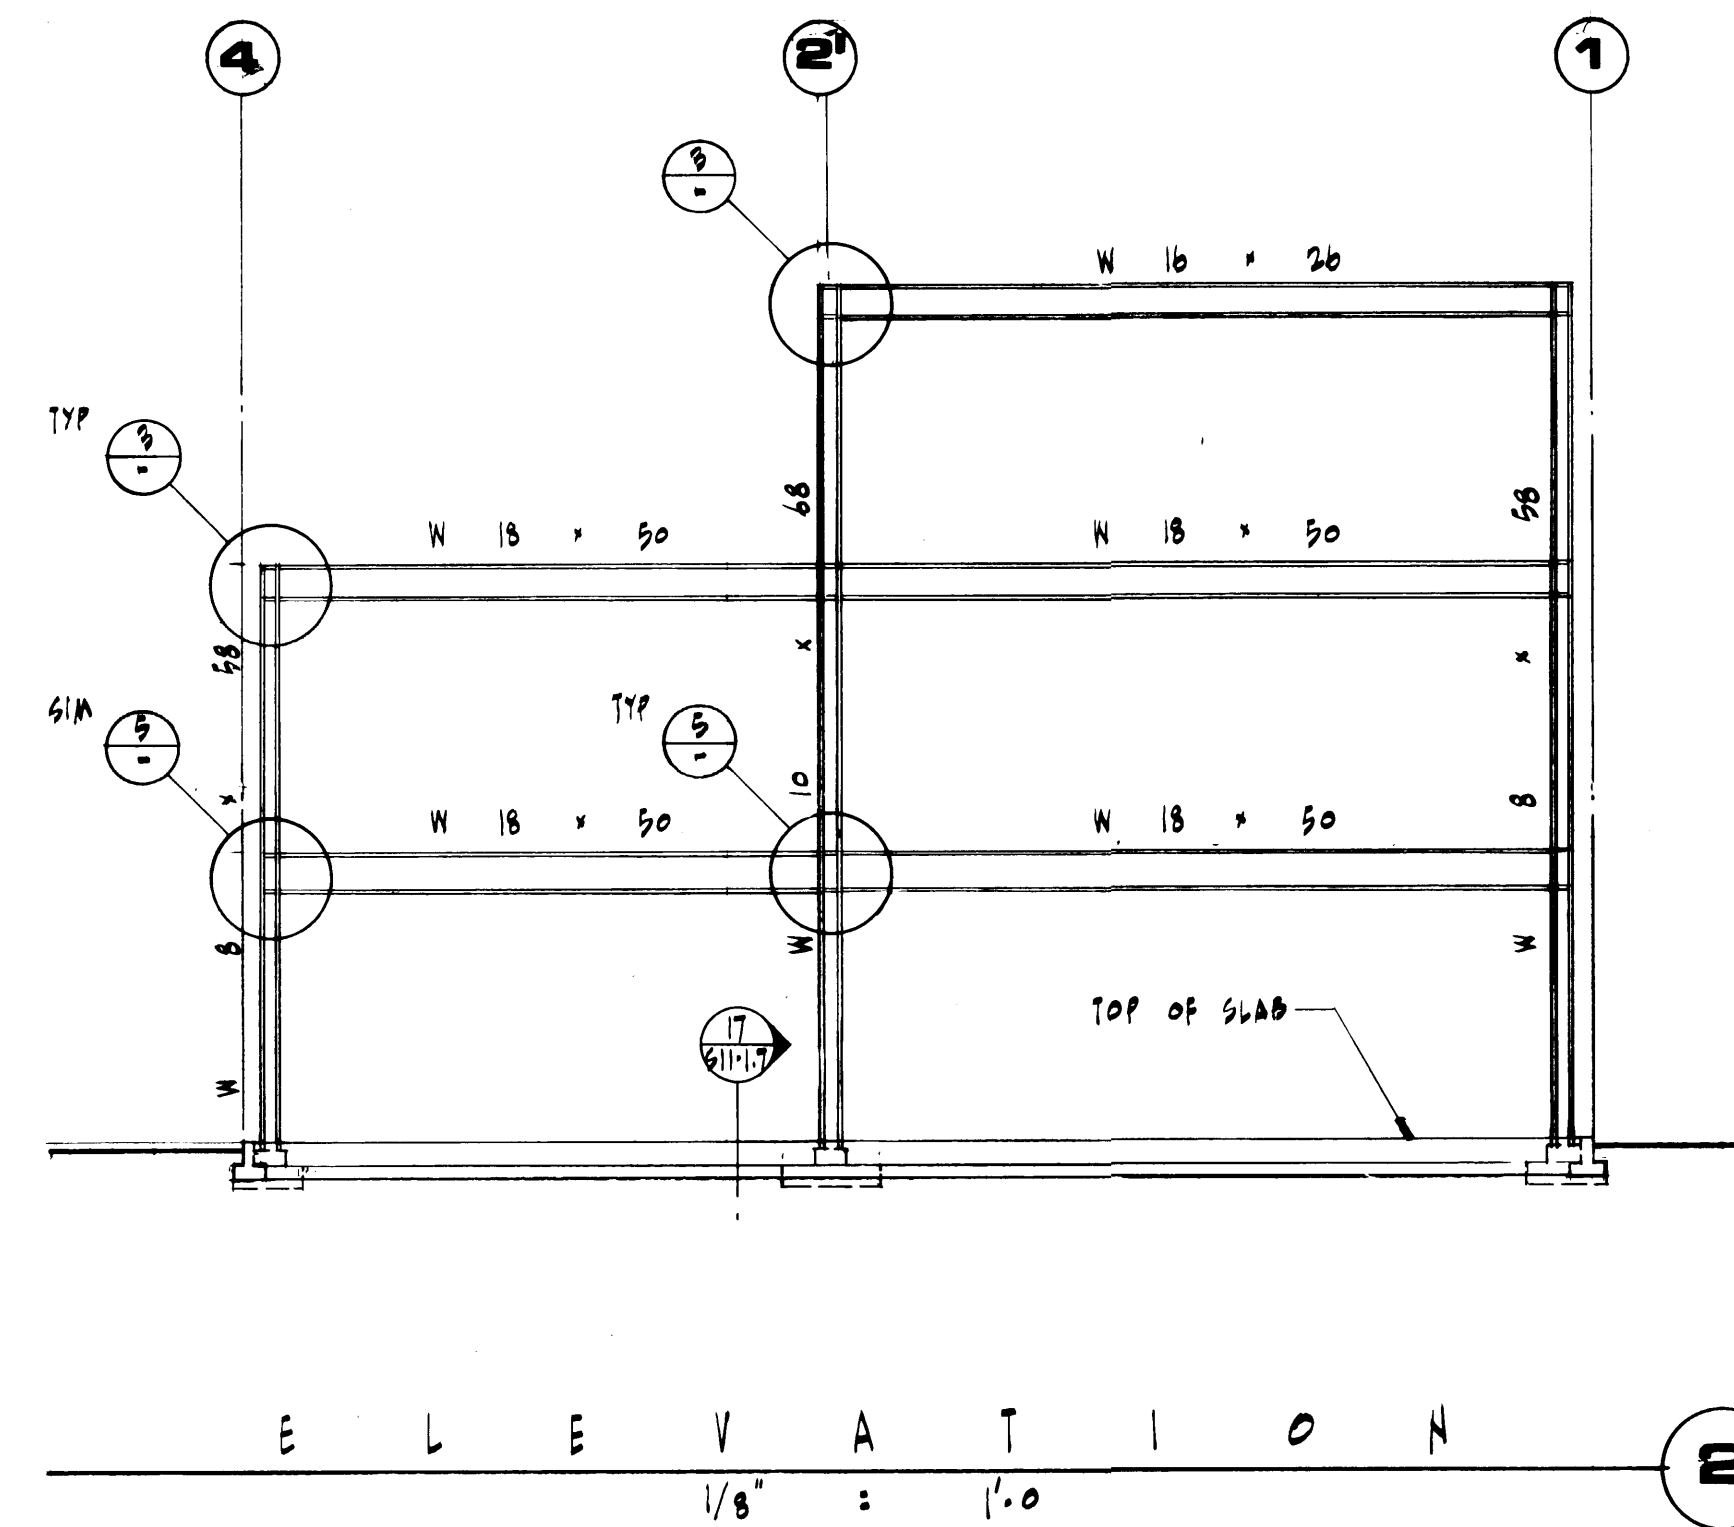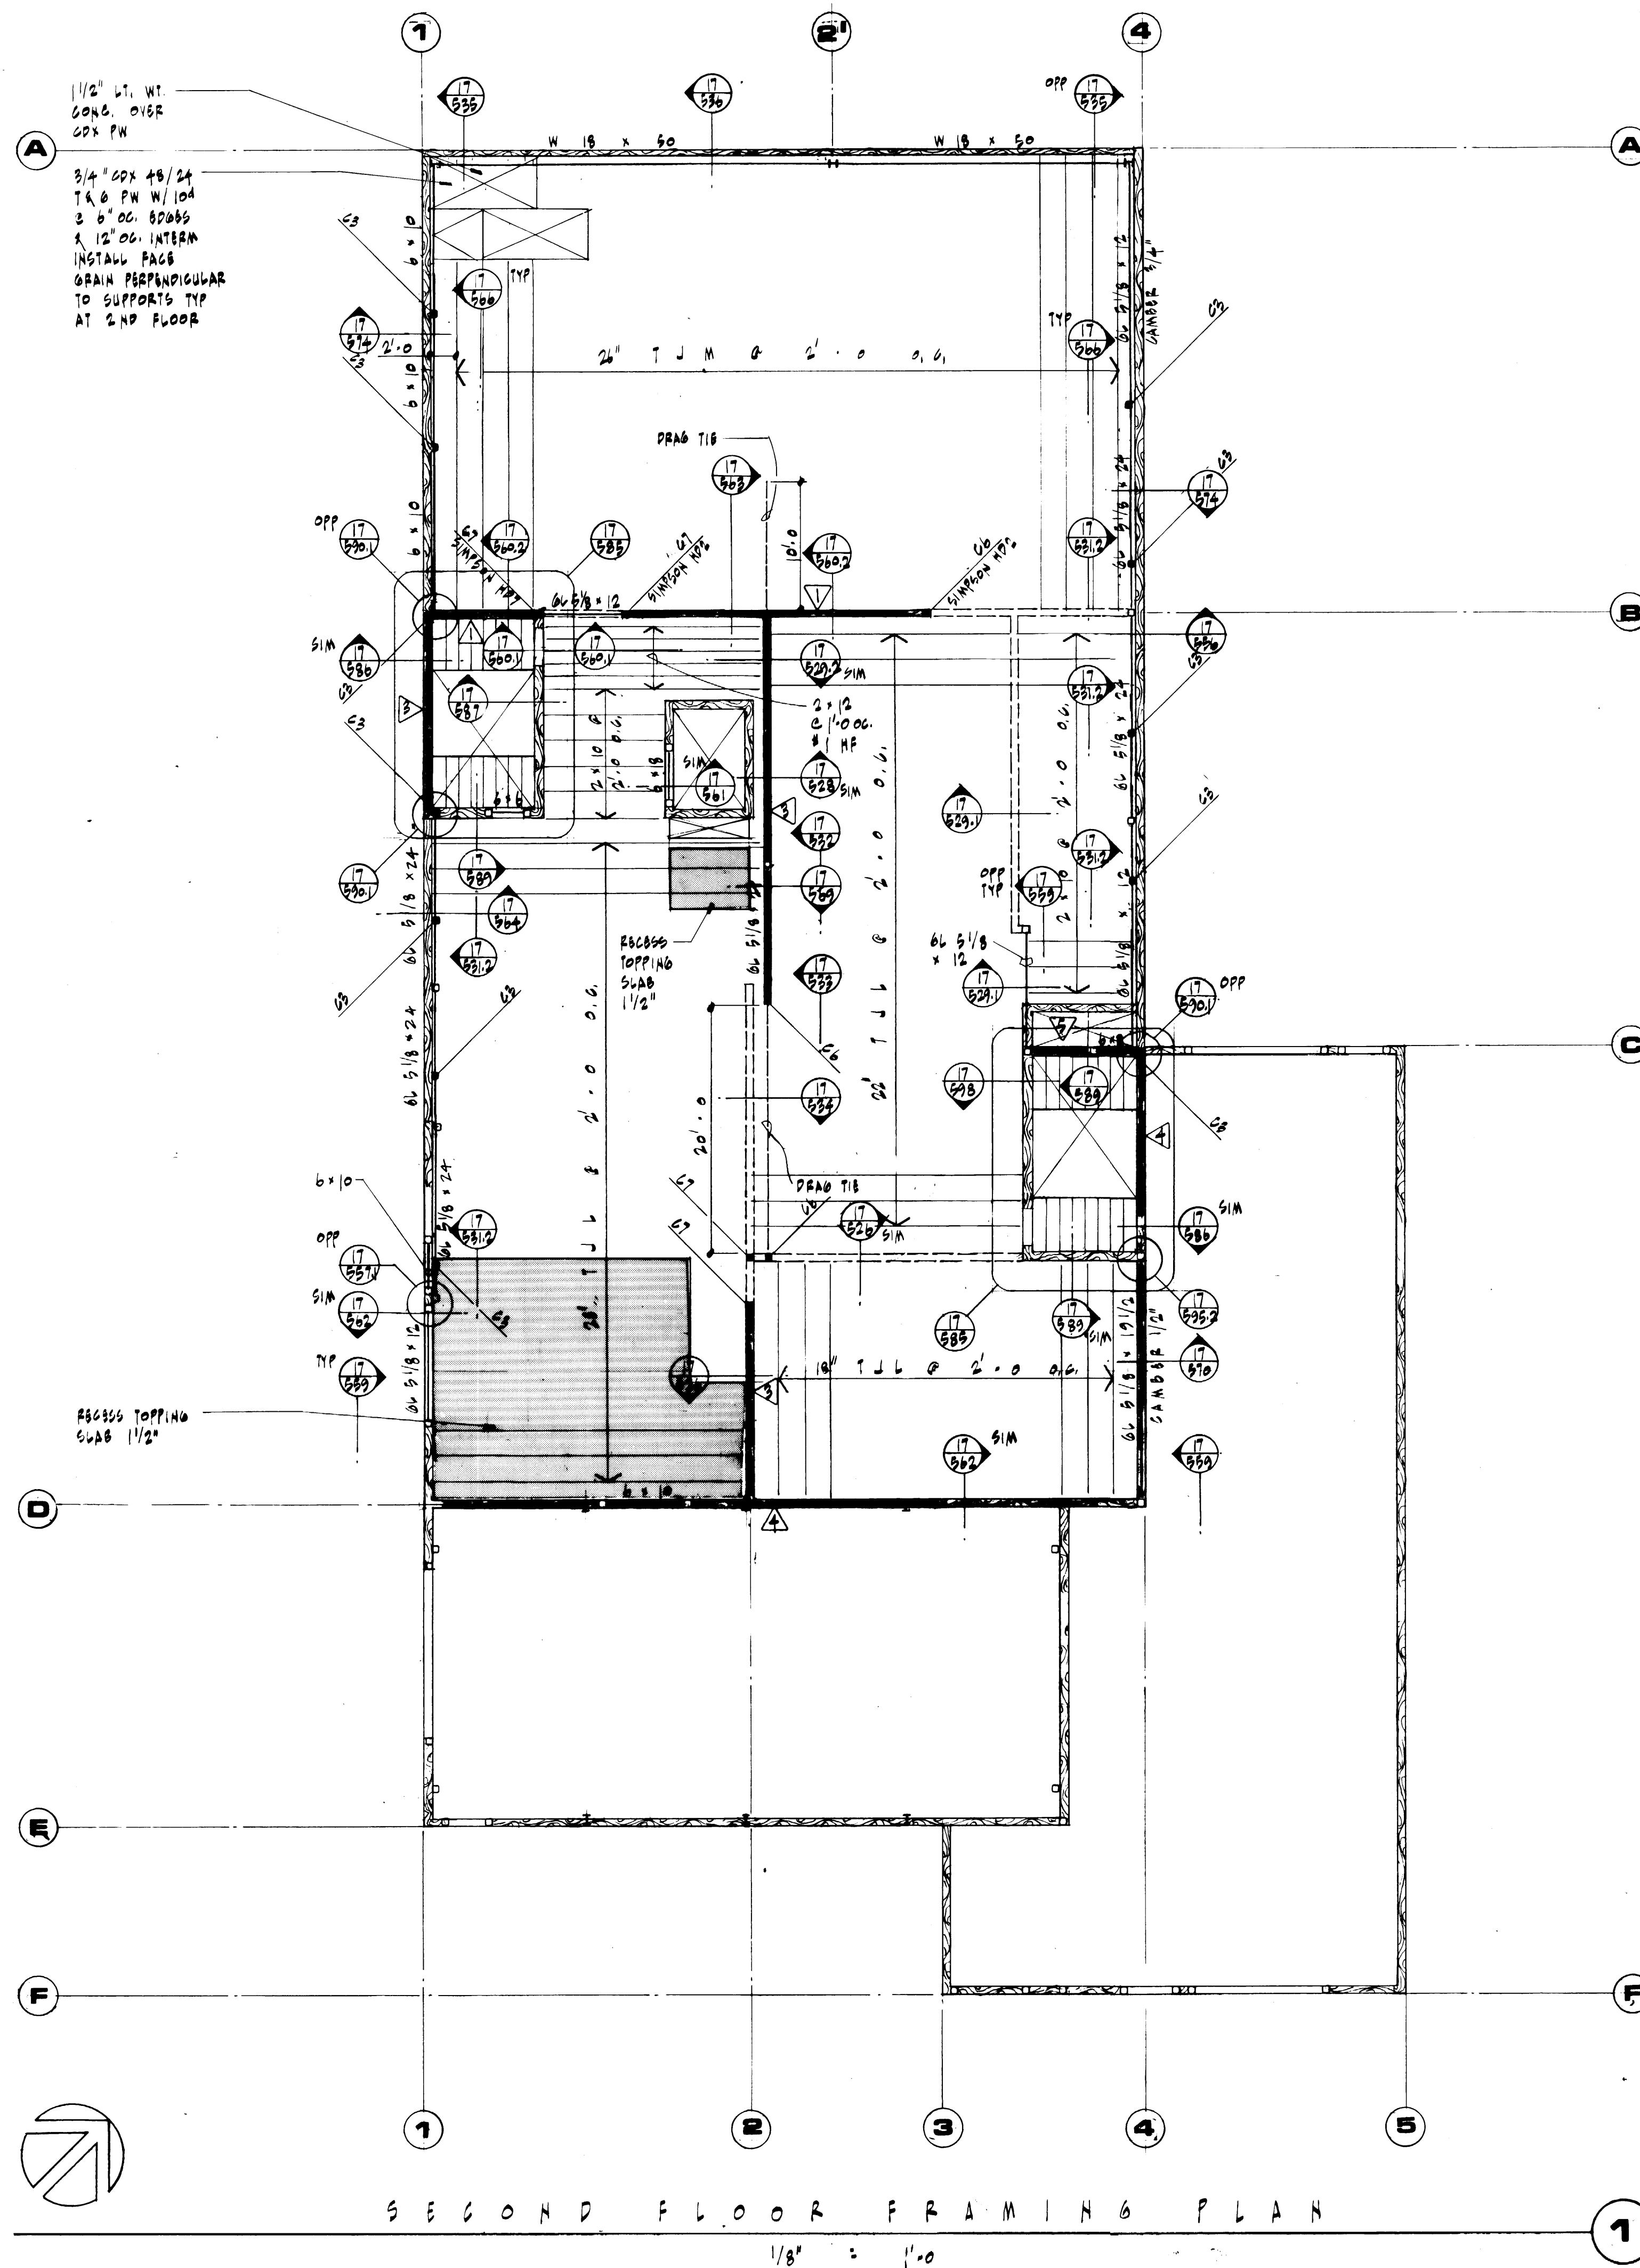


COLUMN SCHEDULE 4		
MARK	COLUMN SECTION	REMARKS
C1	W 8 x 58	
C2	W 10 x 68	
C3	3' Ø STD PIPE COL	
C4	W 8 x 28	
C5	TS 4 x 4 x 1/4	
C6	B.U. COLUMN W/(4) 2 x 6 STUDS	
C7	B.U. COLUMN W/(3) 2 x 6 STUDS	USE 2 x 6, OR 2 x 12 STUDS TO MATCH WALL FRAMING
C8	TS 3 x 3 x 1/4	

- INDICATES COLUMNS BELOW THIS FLOOR LEVEL.
- INDICATES COLUMNS BEARING ON THIS LEVEL.

SHEARWALL SCHEDULE *** 6				
MARK	SHEATHING	NAILING **	A.B. SPACING #	REMARKS
1	1/2" CDX 6A SIDE OF WALL	10d @ 4" OC. EDGES & 10d @ 12" OC. INTERM.	2' 0" O.C.	BLOCK ALL HORIZ. PLYWOOD JOINTS
2	1/2" CDX 6A SIDE OF WALL	10d @ 6" OC. EDGES & 10d @ 12" OC. INTERM.	N/A	DO
3	1/2" CDX (1) SIDE OF WALL	10d @ 4" OC. EDGES & 10d @ 12" OC. INTERM.	4' 0" O.C.	DO
4	1/2" CDX (1) SIDE OF WALL	10d @ 6" OC. EDGES & 10d @ 12" OC. INTERM.	4' 0" O.C.	DO
5	1/2" CDX 6A SIDE OF WALL	10d @ 6" OC. STAGGERED EDGES 10d @ 12" OC. INTERM.	1' 0" O.C.	BLOCK ALL HORIZ. PN JTS PROVIDE PDB STUDS @ VERT. PANEL EDGES

- * PERTAINS TO GROUND FLOOR WALLS. ALL AB TO BE 3/4" Ø J. BOLTS W/ 6" EMBEDMENT.
- ** ALL NAILS TO BE COMMON NAILS.
- *** ALL EXTERIOR WALLS, NOT DESIGNATED SHEAR WALLS, SHALL HAVE PLYWOOD, NAILING & A.B. FOR TYPE 5 BLOCK BLOCKING & HORIZONTAL PN BOARDS NOT REQD.



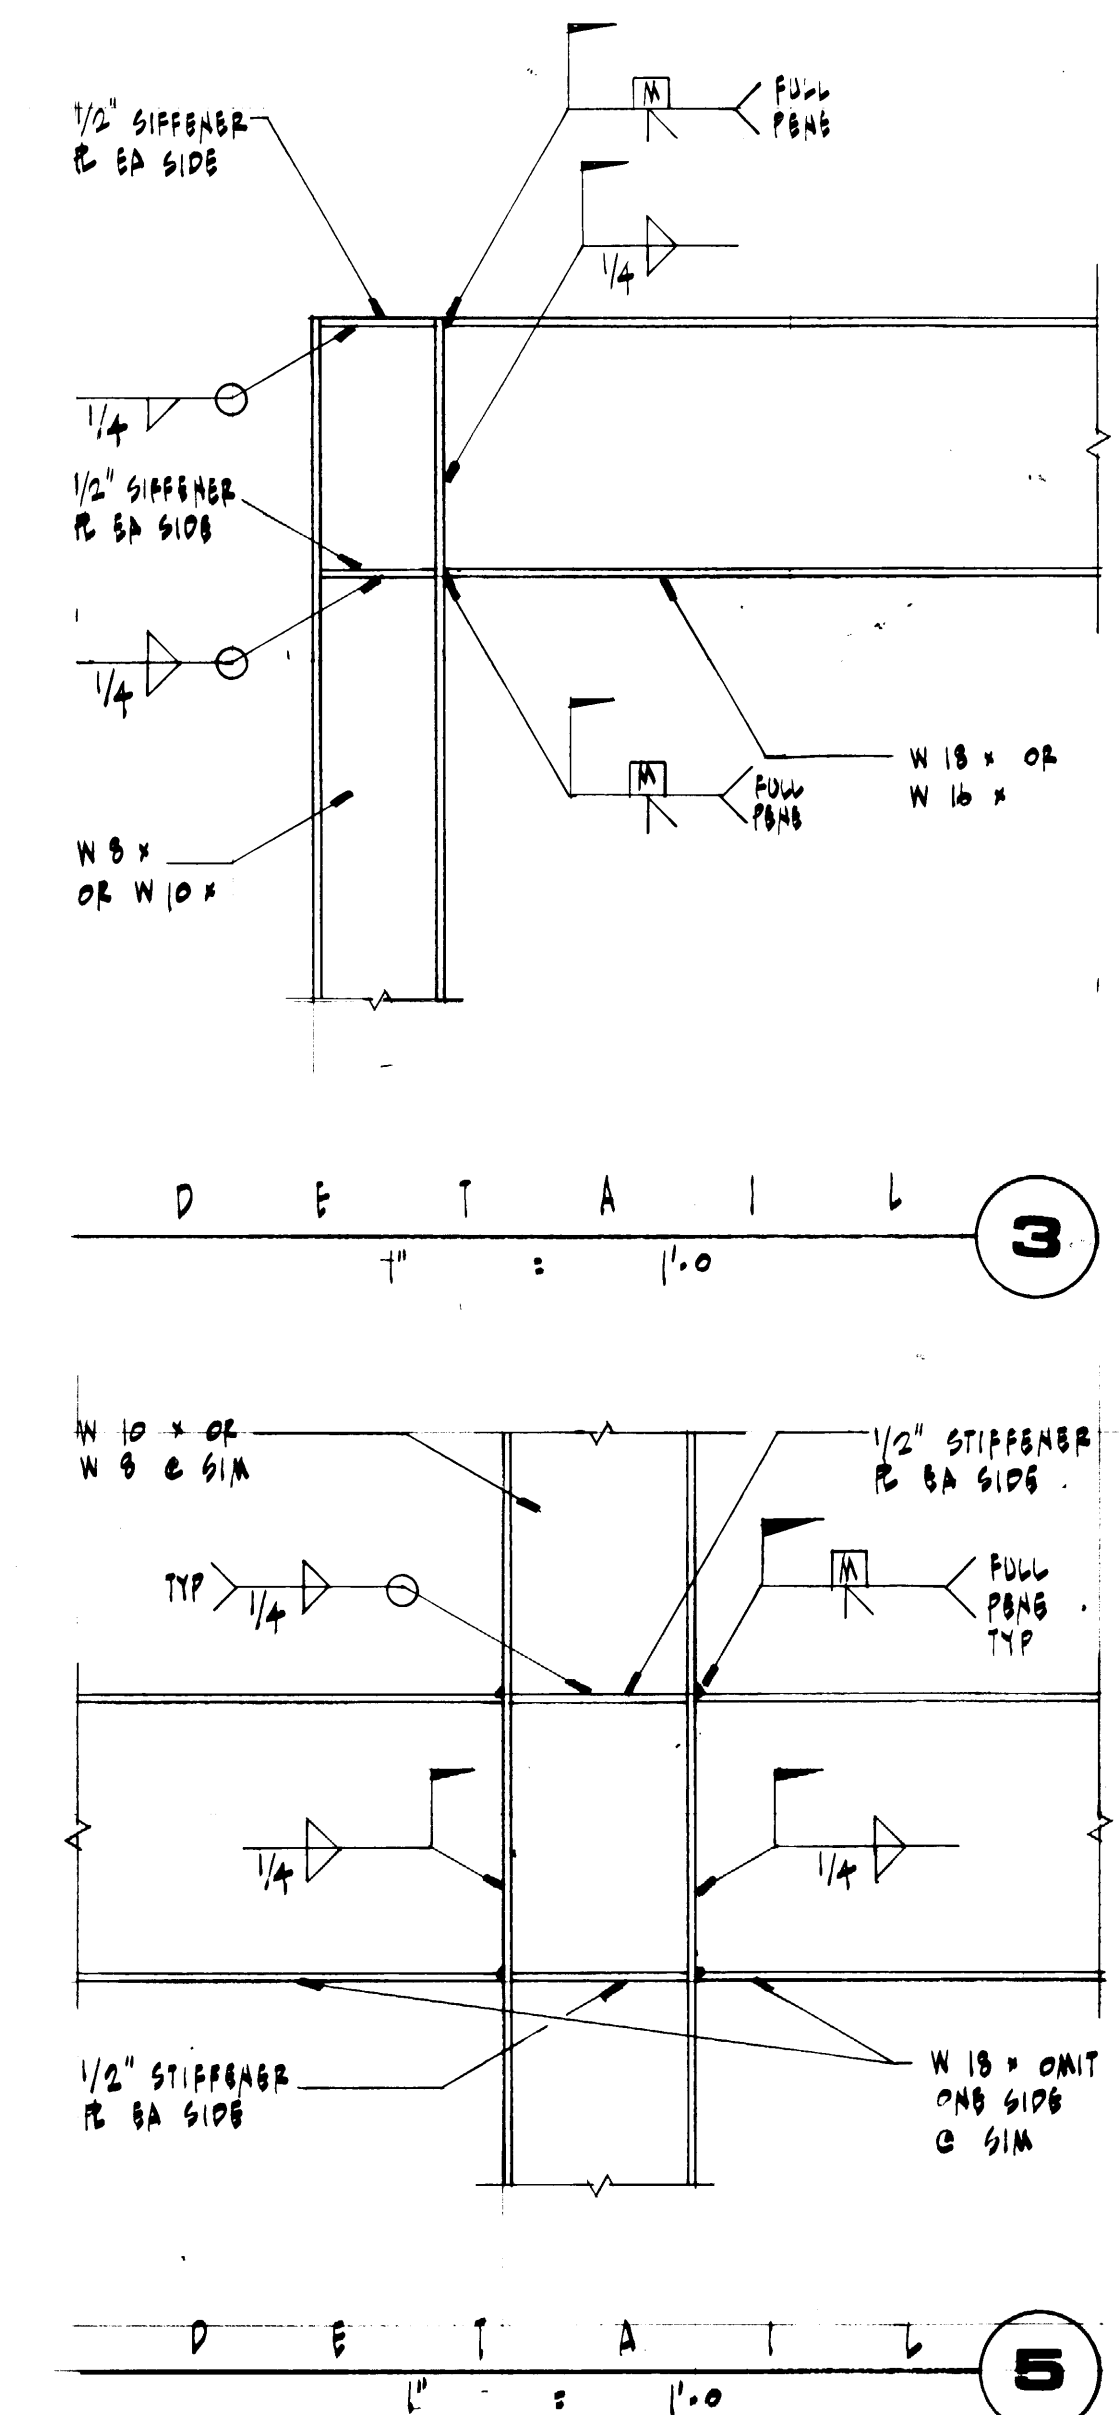


Adams/Hodsdon & ASSOC.
Adams, Hodsdon & Associates, Inc., Structural Engineers
5308 12th Street East • Tacoma, Washington 98424
(206) 922-1600, Seattle (206) 624-4138

DRAWN: 9-24-84		DATE: 9-24-84		SCALE: 1" = 1'-0"	
CHECKED:	DATE:	DRAWING NO. EP-3893-23		SHEET: 511-2 OF 3	
CHECKED:	DATE:	PROJECT: PORT OF TACOMA		TACOMA TERMINALS, INC.	
CHECKED:	DATE:	MARINE SERVICES BUILDING		SECOND FLOOR FRAMING PLAN	
CONT. NO. 582		APPROVED: [Signature]		DATE: 9/24/84	
FIELD BOOK (S):		BY: [Signature]		DATE: 9/29/85	
REVISION:		BY: [Signature]		DATE: 9/29/85	

McGRANAHAN, MESSENGER ASSOCIATES
ARCHITECTURE/PLANNING/INTERIORS
MEMBER AMERICAN INSTITUTE OF ARCHITECTS • 9501 PACIFIC AVE. SUITE 300 • TACOMA, WA 98402 • (206) 363-3084



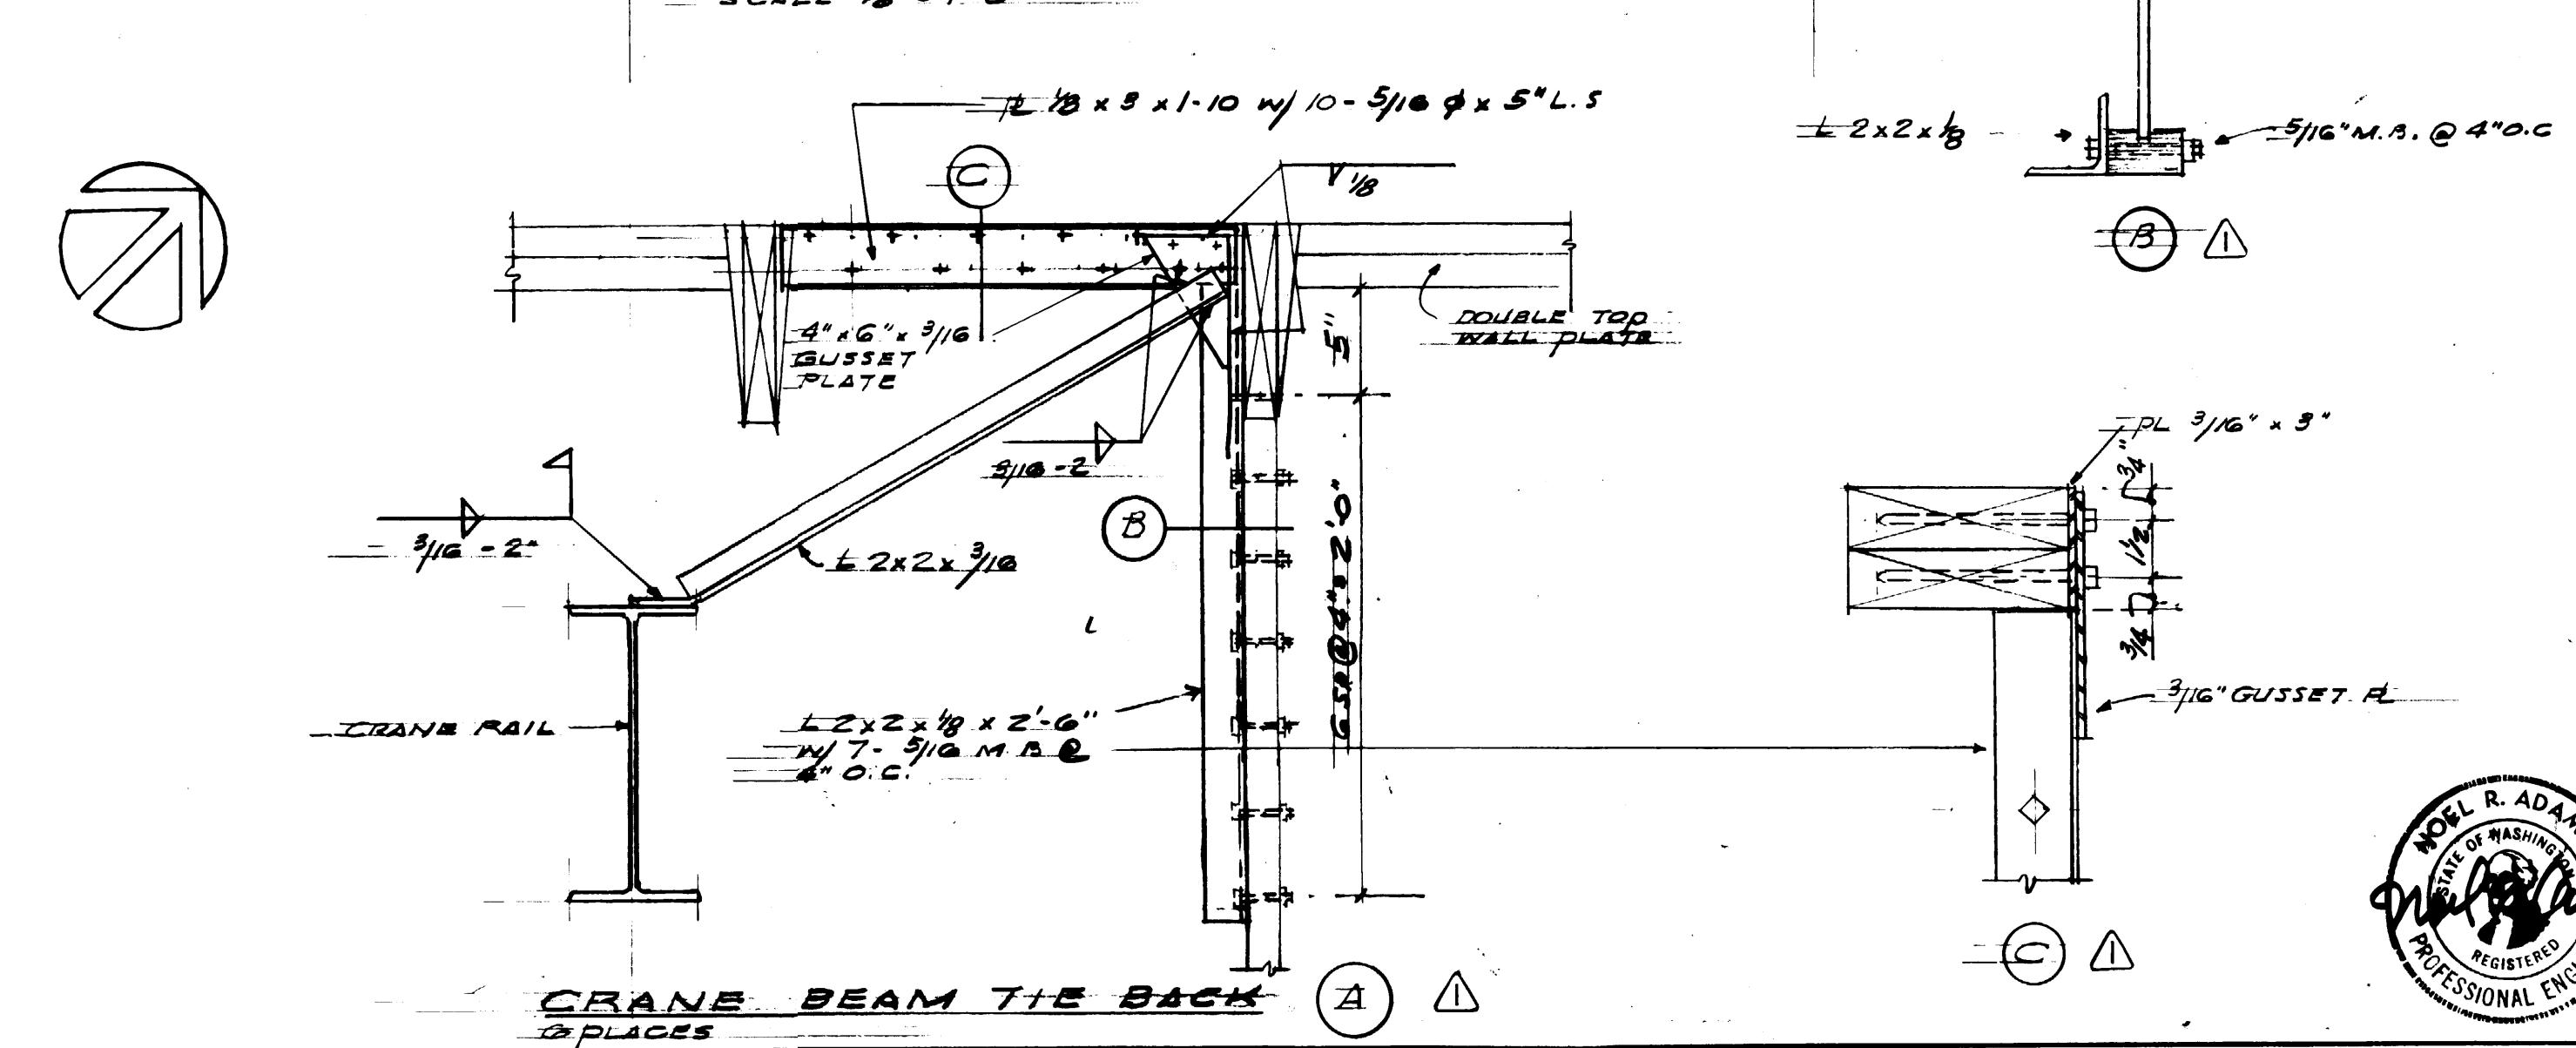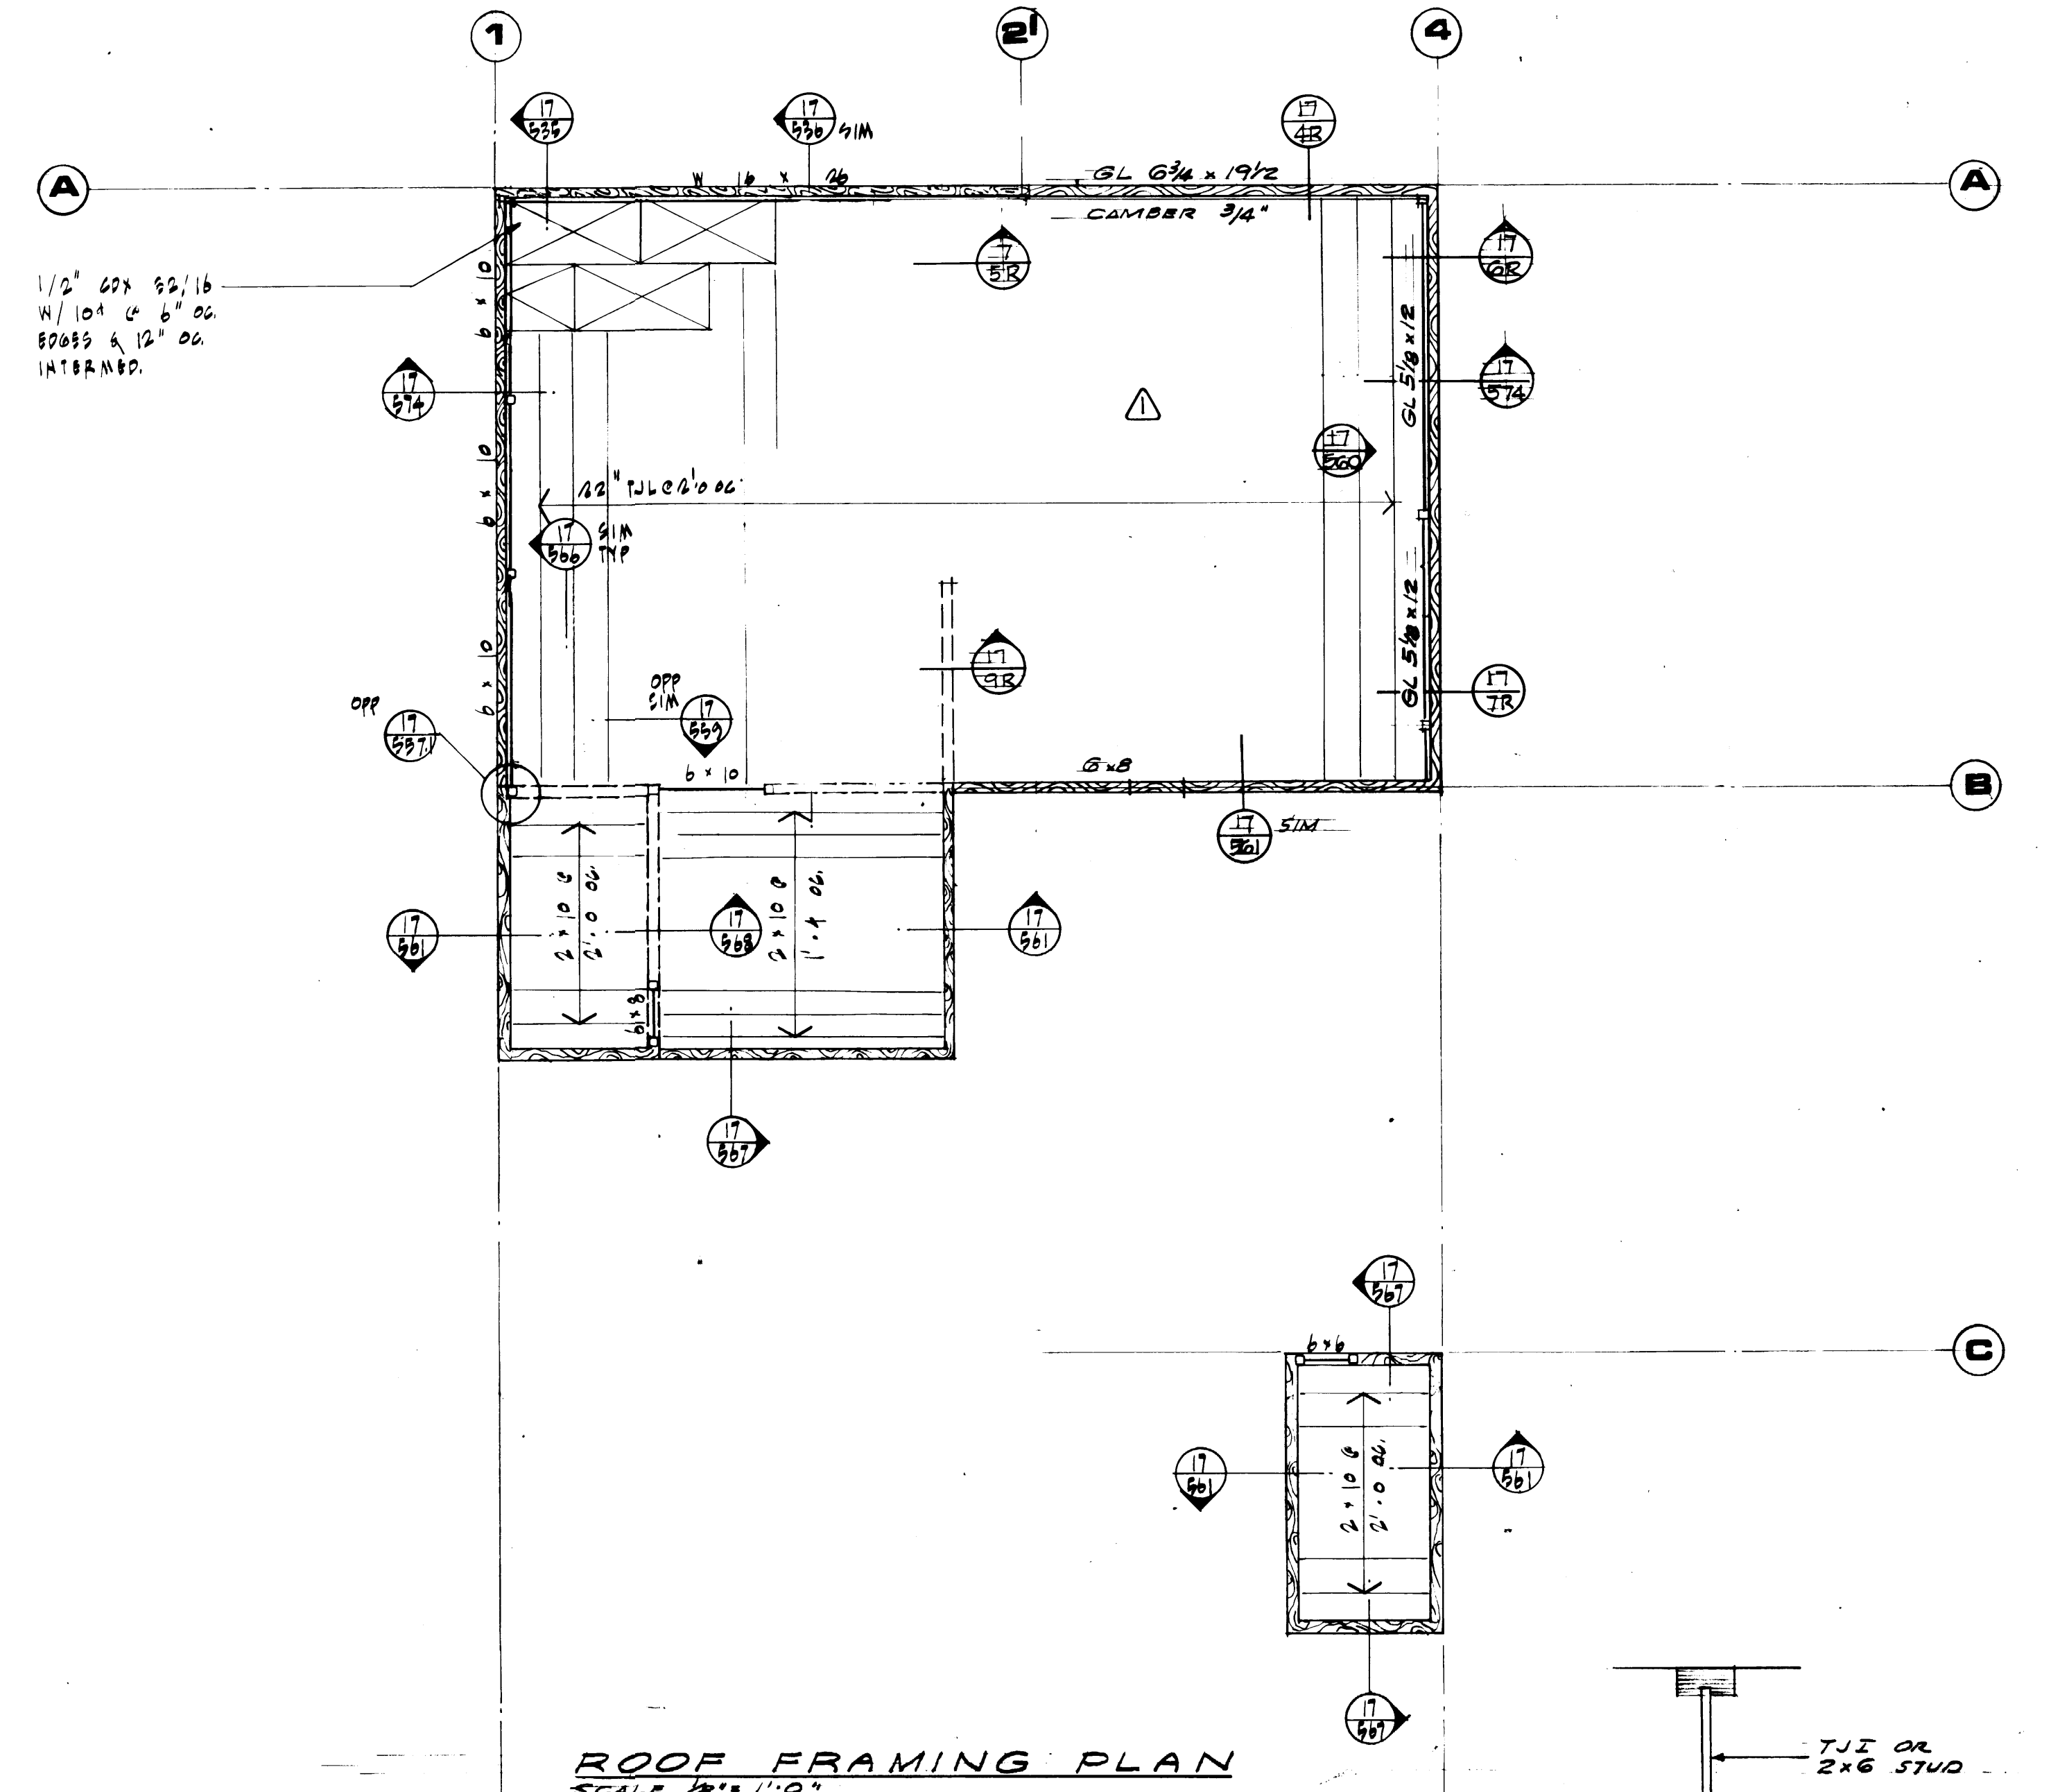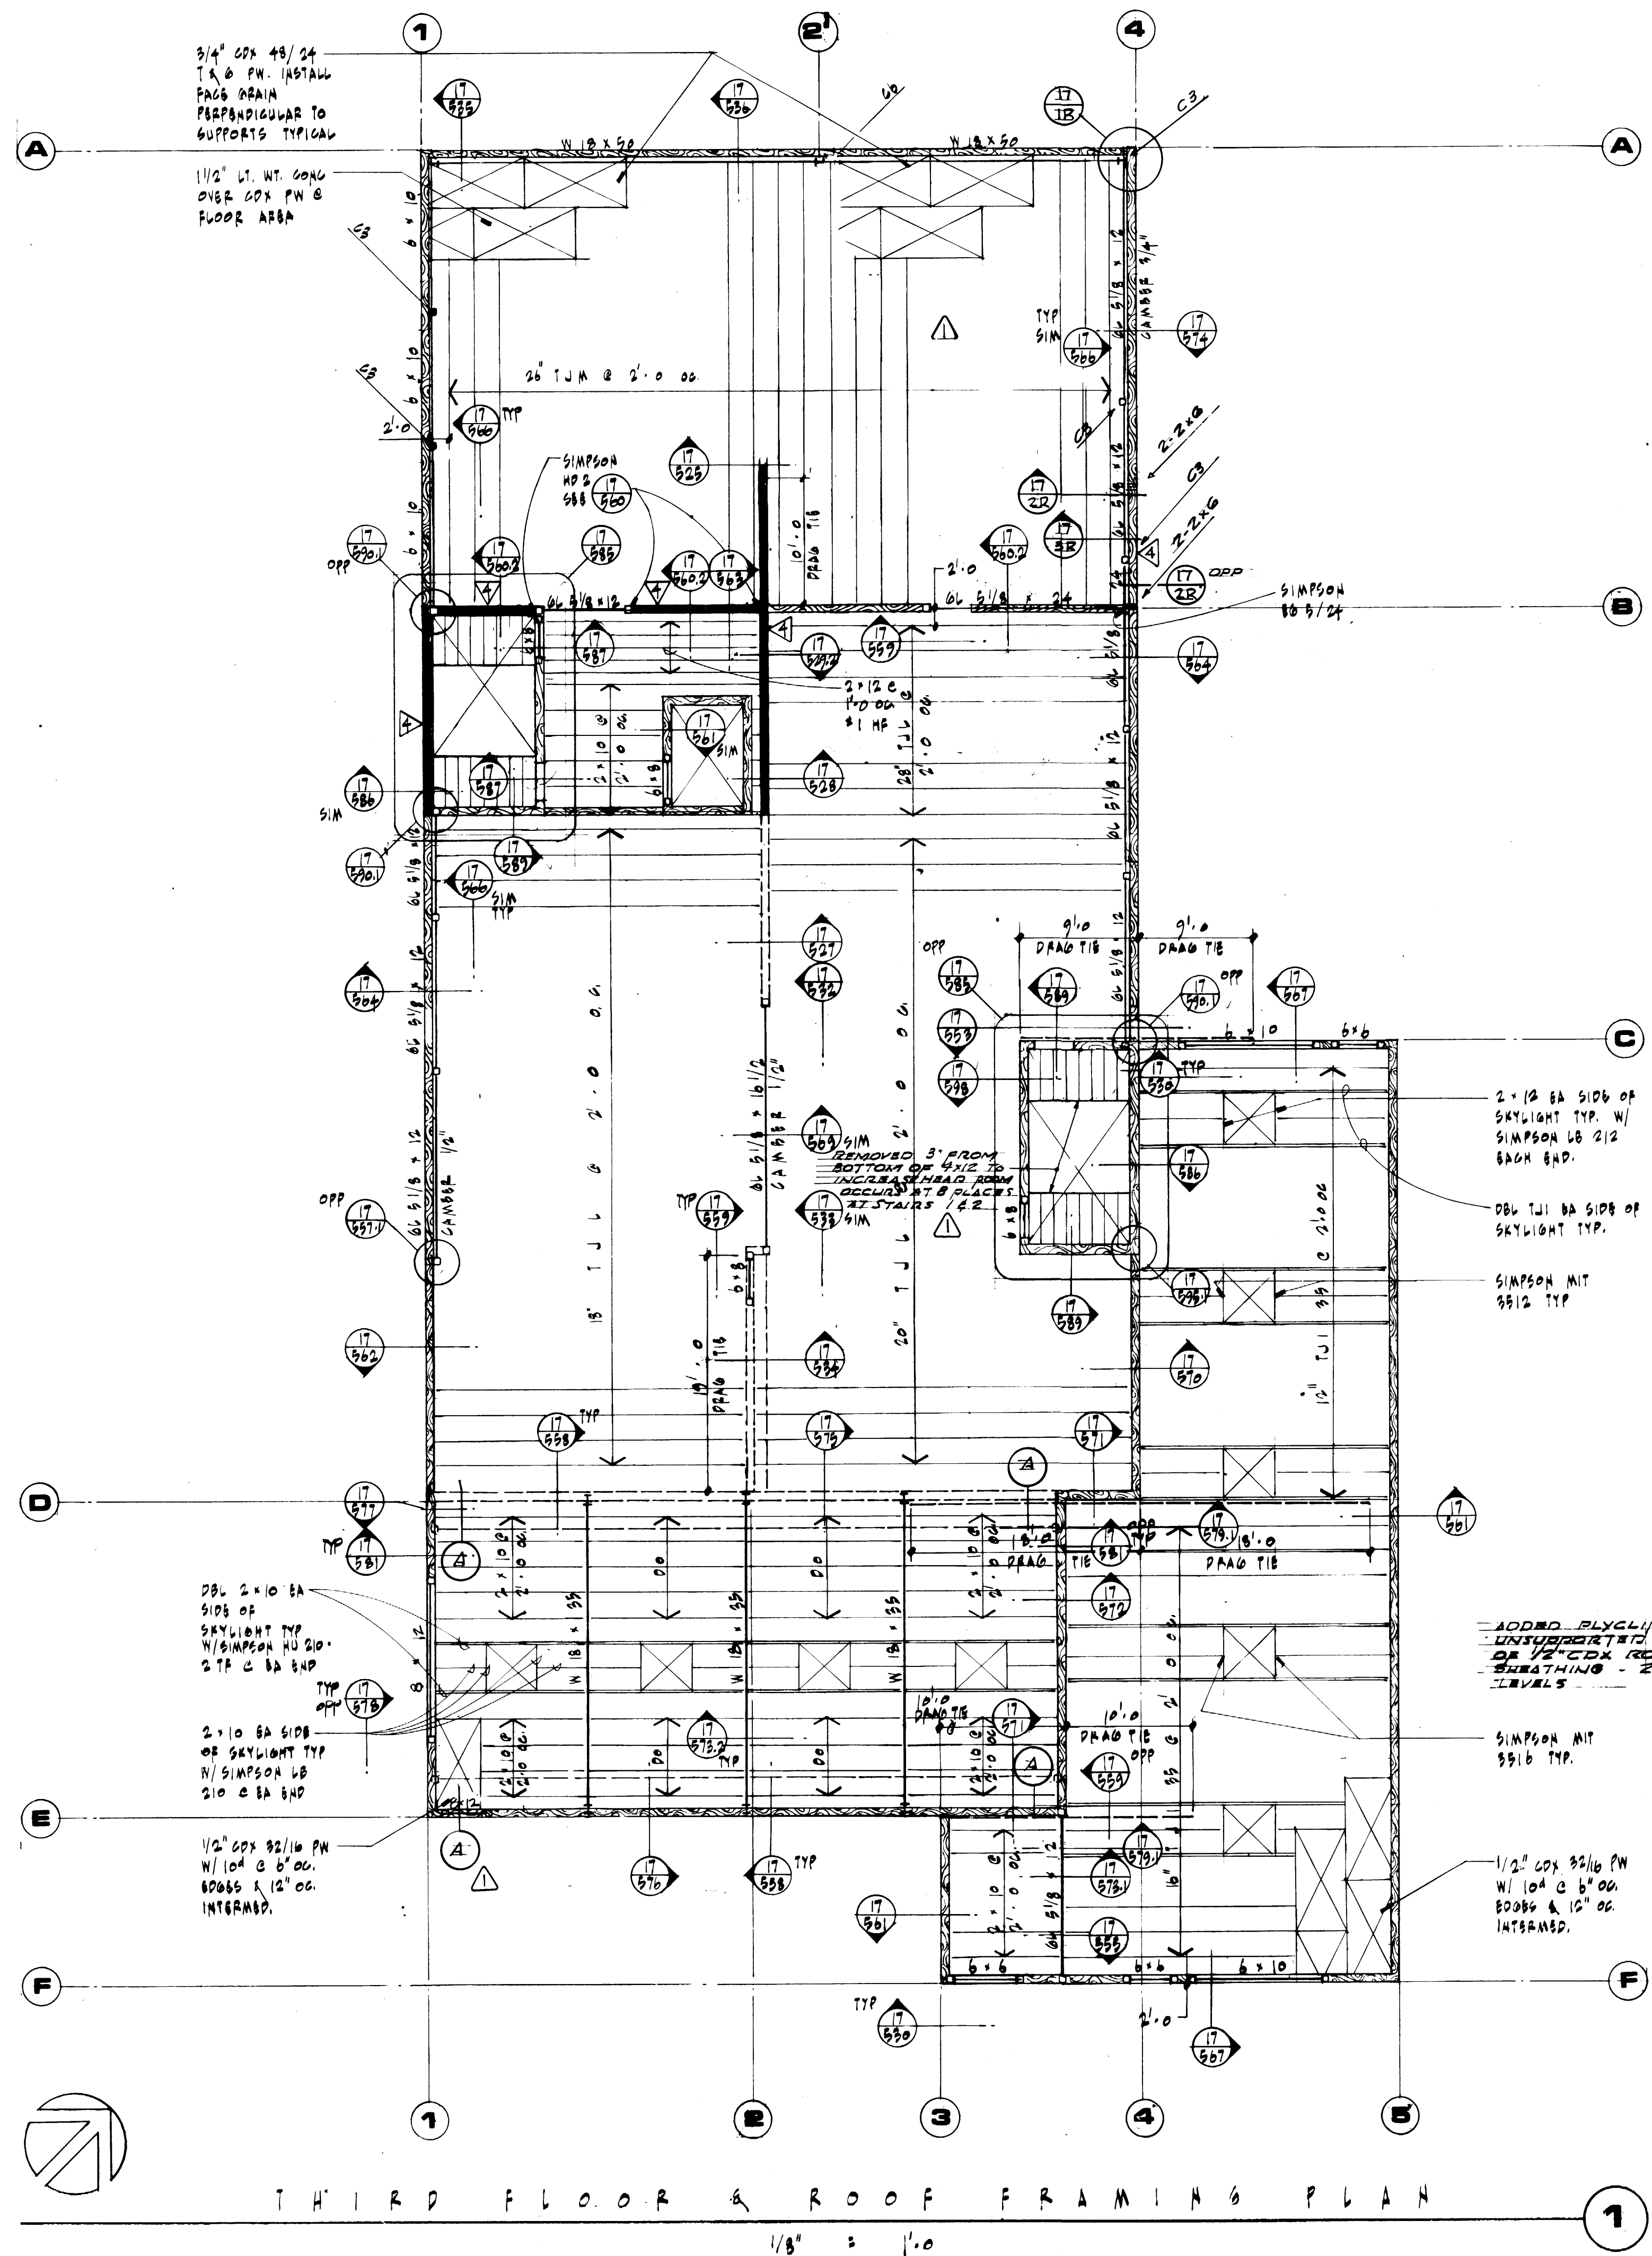

McGRANAHAN, MESSENGER ASSOCIATES

ARCHITECTURE / PLANNING / INTERIORS

MEMBER AMERICAN INSTITUTE OF ARCHITECTS • 9501 AVENUE C, SUITE 300, TACOMA, WA 98402 • (206) 383-3034

Adams/Hodsdon & Assoc.

Adams, Hodsdon & Associates, Inc., Structural Engineers

5308 12th Street East • Tacoma, Washington 98424

(206) 922-1600, Seattle (206) 624-4138


PORT OF TACOMA

TACOMA TERMINALS, INC.


MARINE SERVICES BUILDING

THIRD FLOOR & ROOF FRAMING PLANS

DRAWN: 9-2-84		DATE: 9-2-84		DRAWING NO. EP-3893-23	
CHECKED: [Signature]		DATE: 9-2-84		6-511-3	
CHECKED: [Signature]		DATE: 9-2-84		SHEET 11-3 OF 3	
CONT. NO. 582		FIELD BOOK(S):		SCALE: 1/8" = 1'-0"	
APPROVED: [Signature]		DATE: 9/24/84		CHIEF ENGINEER	
REVISIO		BY		DATE	
REVISIO		BY		DATE	

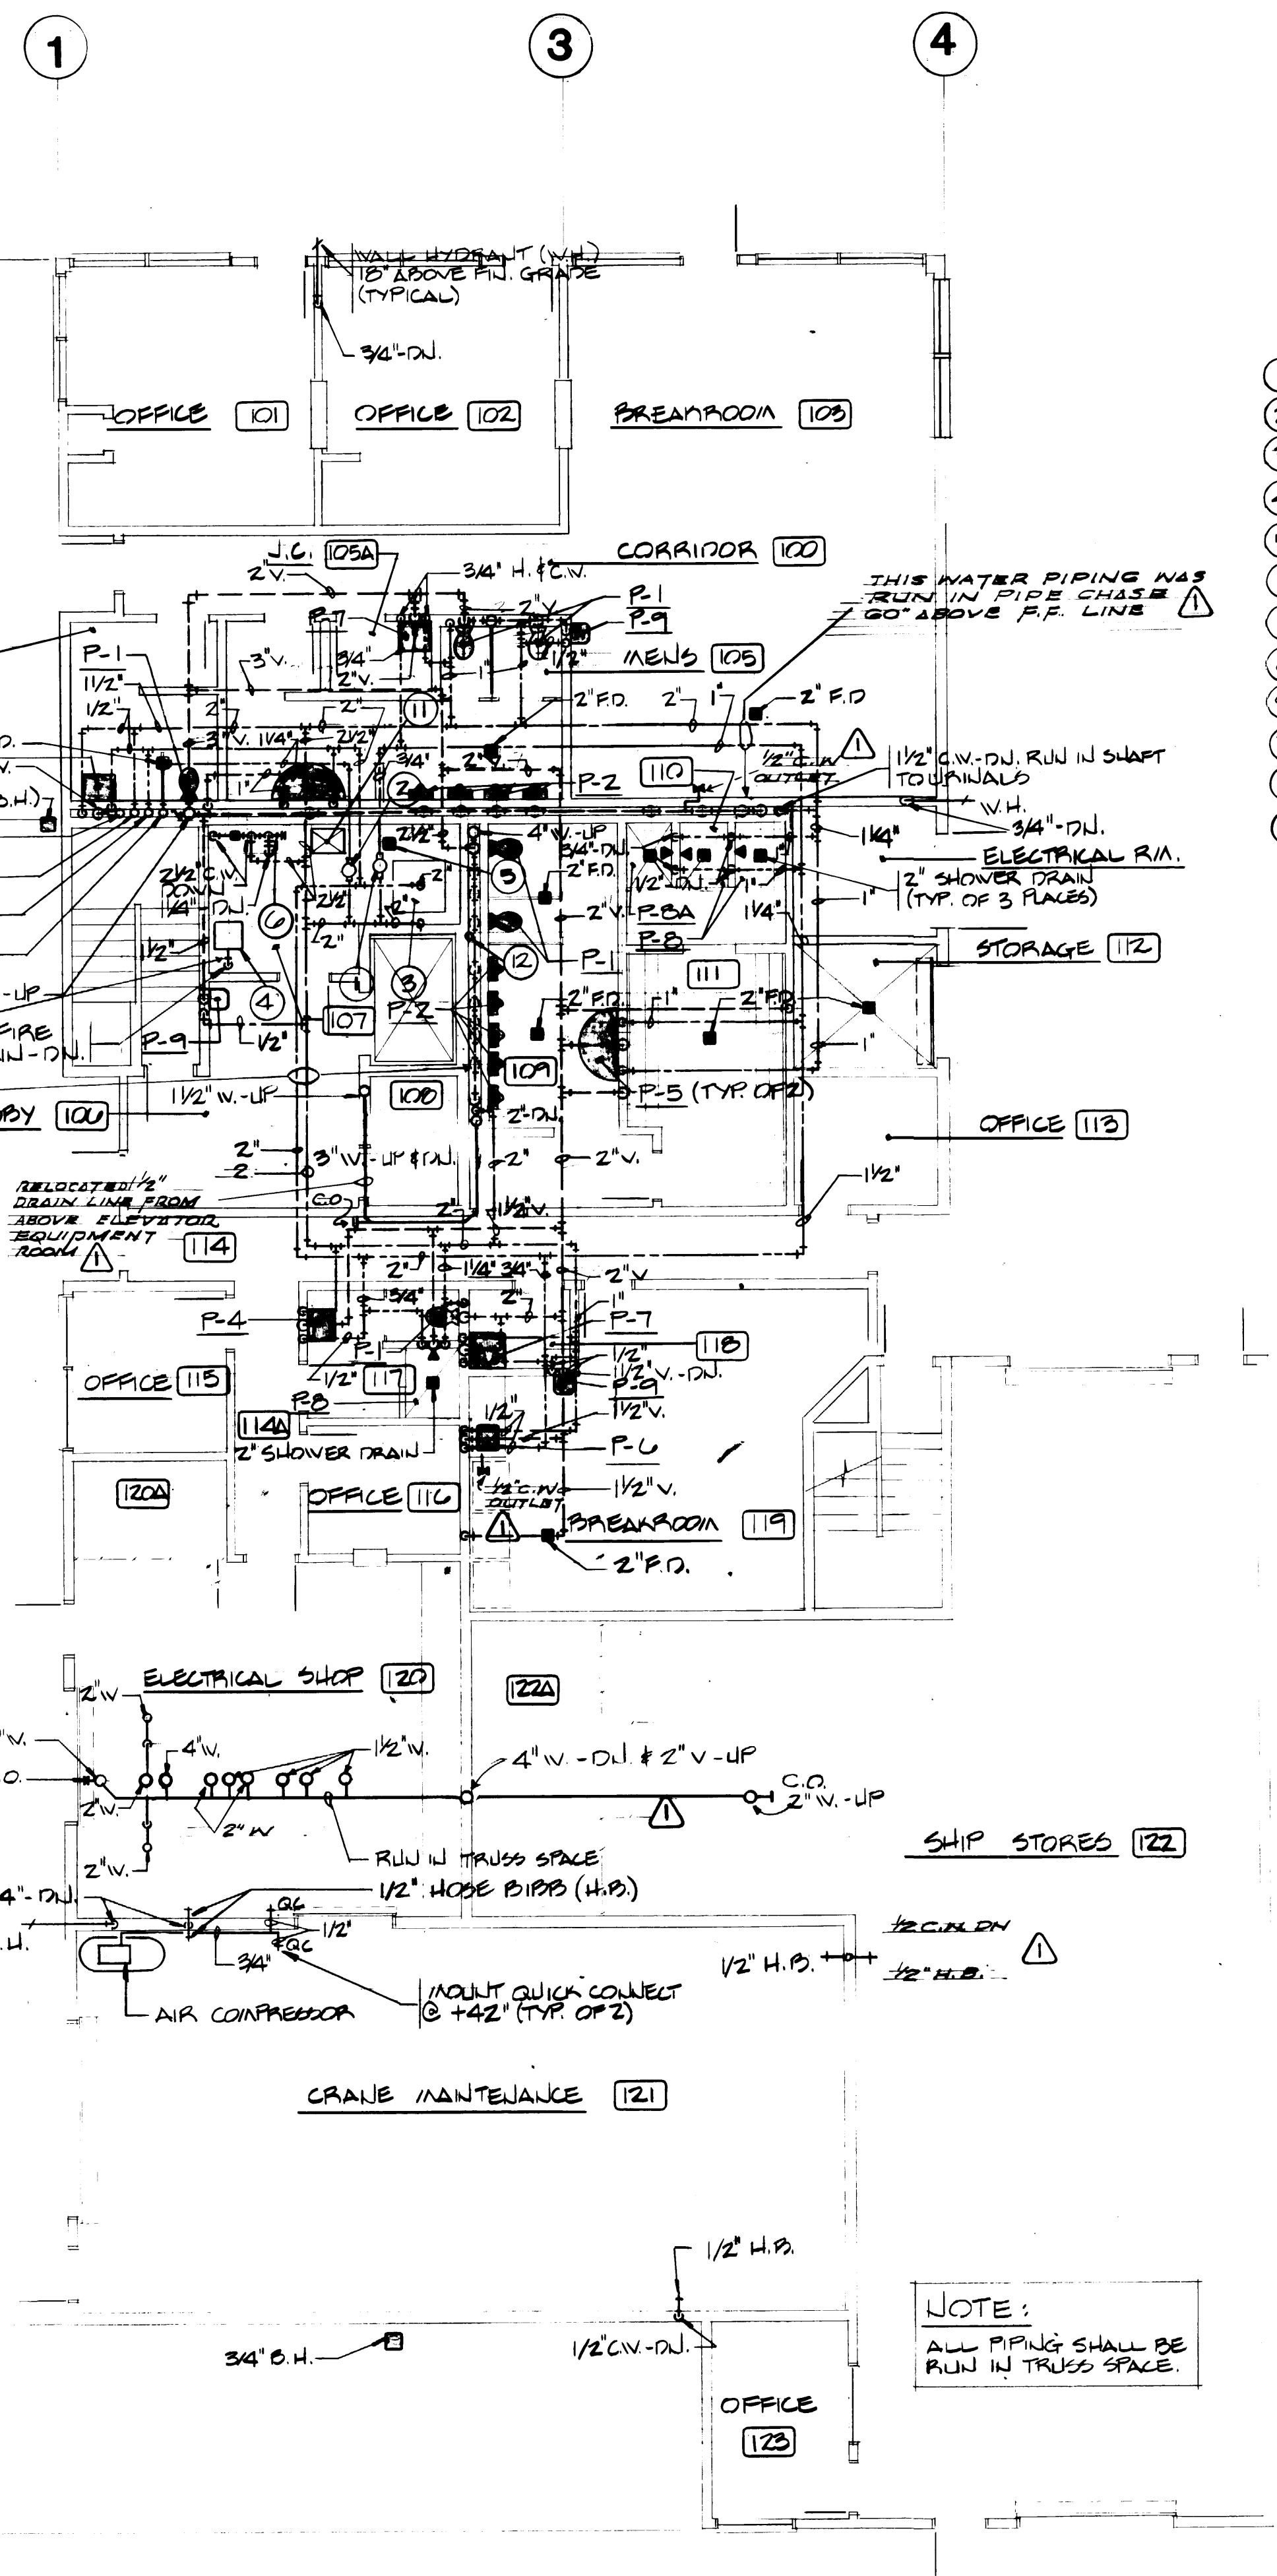


FIRST FLOOR PLAN-PLUMBING
SCALE: 1/8" = 1'-0"

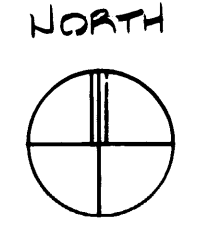


BUBBLE NOTES

- ① HOT WATER CIRCULATING PUMP (HWC-1), 1/2 HP-120V.
- ② HOT WATER CIRCULATING PUMP (HWC-2), 1/2 HP-120V.
- ③ H.W. TANK #1, 250 GALLON (2) 12 KW-480V-3Ø HEATERS
- ④ FIRE SPRINKLING VALVE
- ⑤ 6" FLOOR SINK
- ⑥ COLD WATER HEADER - SEE DETAIL
- ⑦ 1 1/4" H.W.C. - UP
- ⑧ 1 1/2" H.W. - UP
- ⑨ 2" C.W. - UP
- ⑩ 3/4" C.W. - UP & DN.
- ⑪ LOCATION OF AIR COMPRESSOR
- ⑫ 1 1/2" V. - UP & DN.

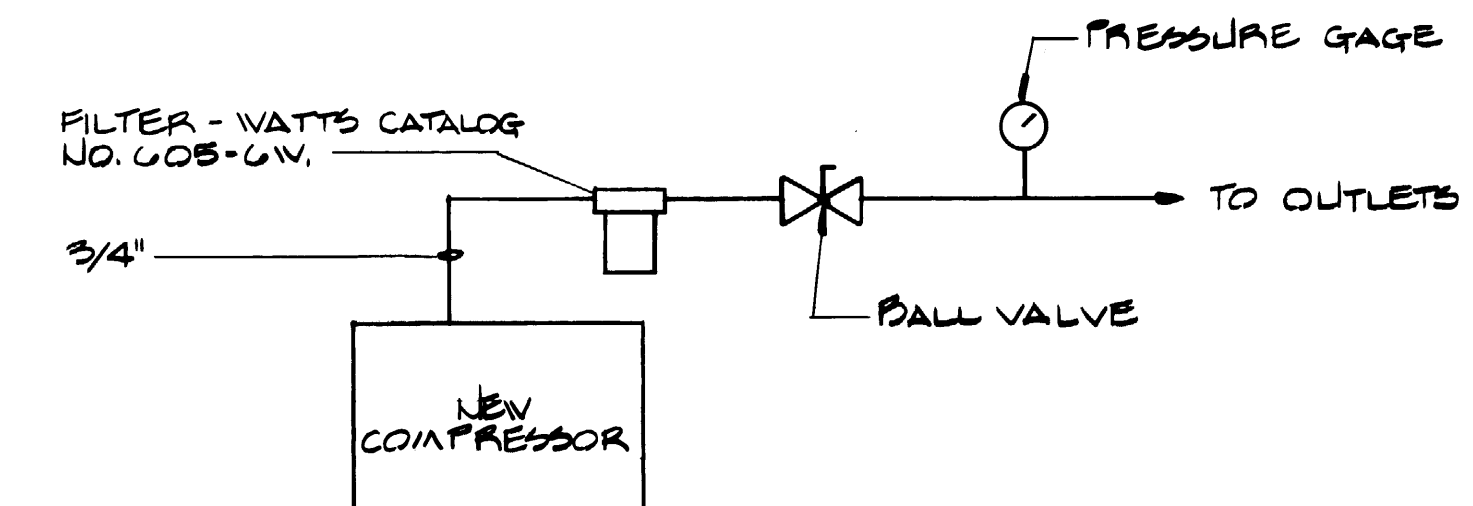


COMPRESSED AIR DIAGRAM
NO SCALE

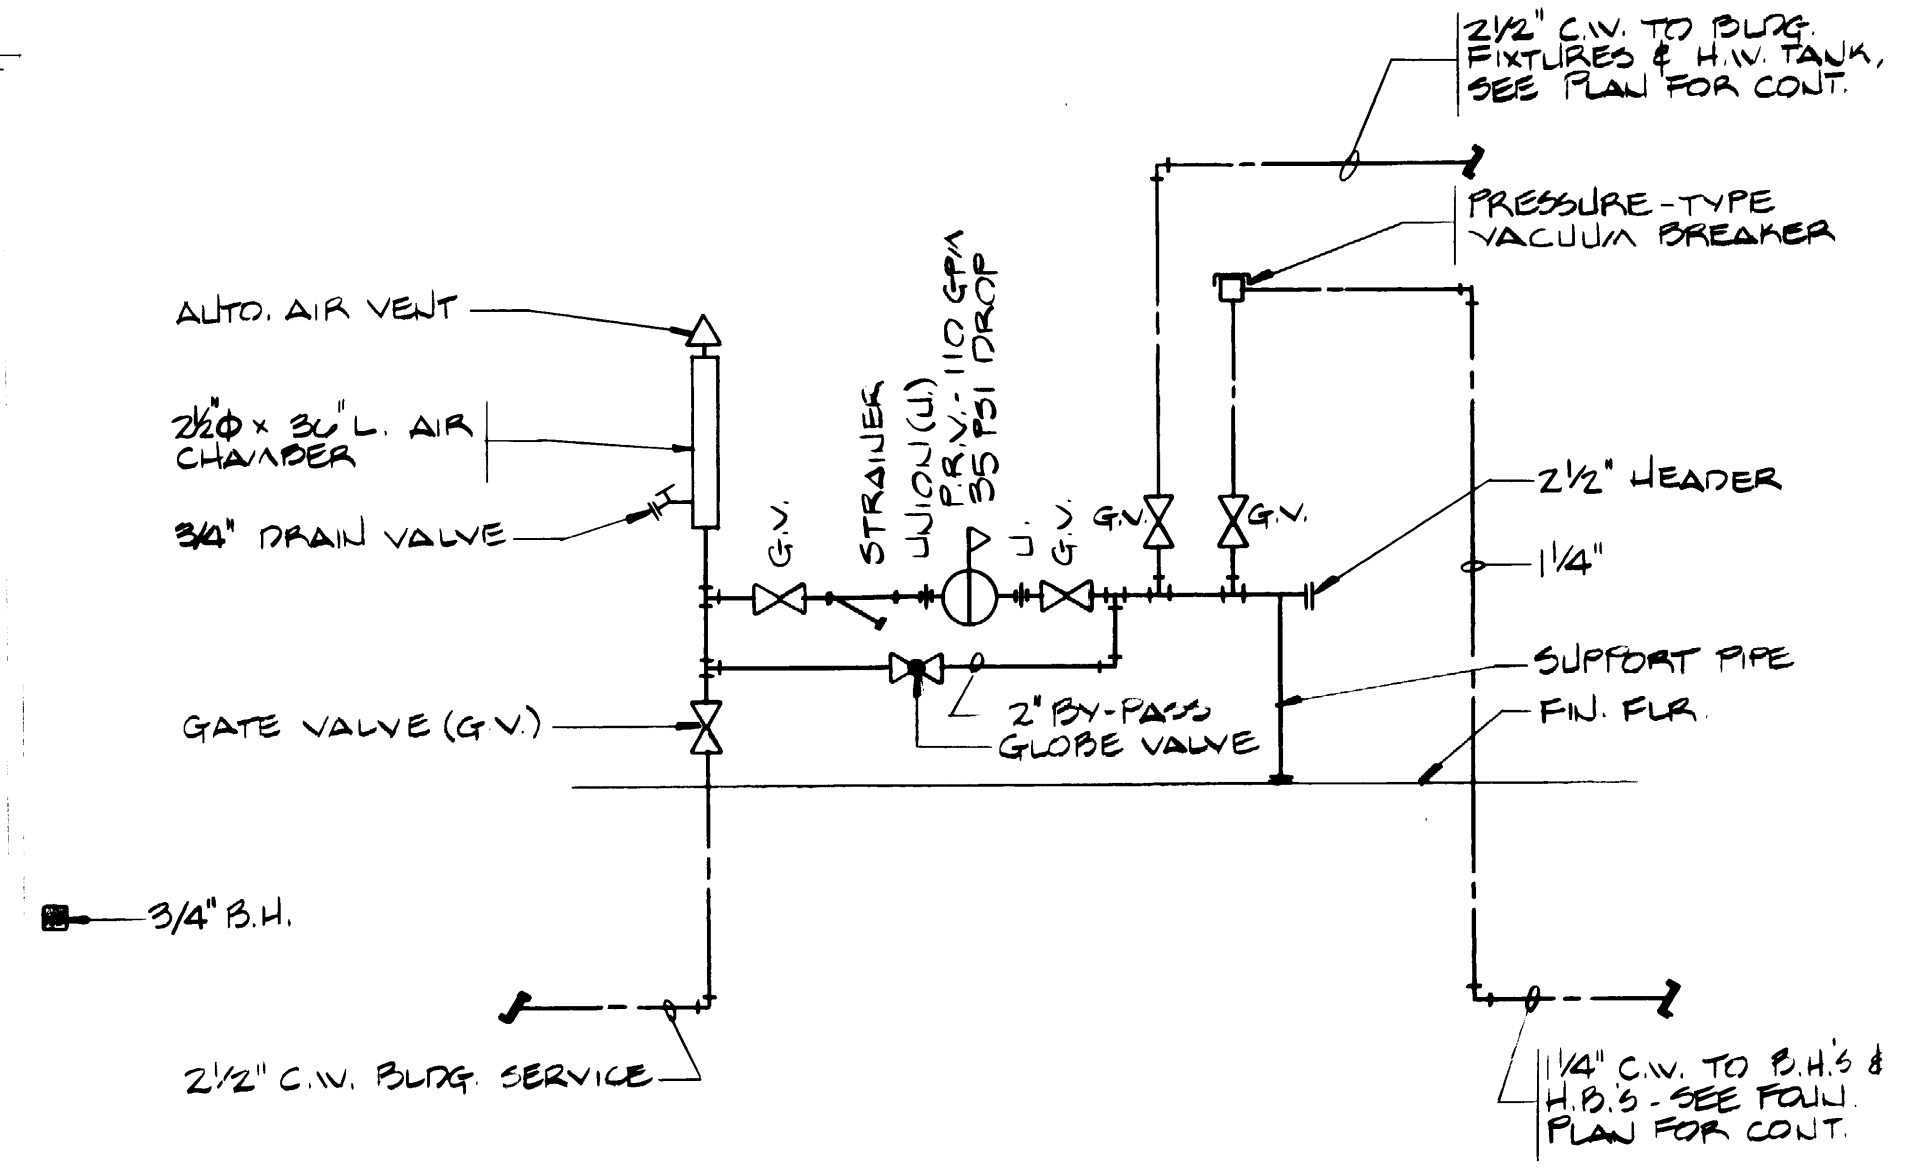

COLD WATER HEADER DETAIL
NO SCALE

PLUMBING FIXTURE SCHEDULE


SYMBOL	FIXTURE	LOCAL PIPING CONNECTIONS				NOTE
		W.	V.	H.W.	C.W.	
P-1	WATER CLOSET	4"	2"	-	1"	FLUSH VALVE WALL MOUNTED
P-2	URINAL	2"	1 1/2"	-	3/4"	FLUSH VALVE WALL MOUNTED
P-3	LAVATORY	1 1/2"	1 1/2"	1/2"	1/2"	COUNTER-TOP OVAL
P-4	LAVATORY	1 1/2"	1 1/2"	1/2"	1/2"	WALL MOUNTED
P-5	WASH FOUNTAIN	2"	1 1/2"	1"	1"	54" SEMI-CIRCLE VENT OF DRAIN
P-5A	WASH FOUNTAIN	2"	1 1/2"	1"	1"	54" CIRCULAR
P-6	SINK	1 1/2"	1 1/2"	1/2"	1/2"	COUNTER-TOP
P-7	SERVICE SINK	3"	2"	3/4"	3/4"	WALL HUNG
P-8	SHOWER	2"	1 1/2"	1/2"	1/2"	STANDARD
P-8A	SHOWER	2"	1 1/2"	1/2"	1/2"	HANDICAPPED
P-9	DRINKING FOUNTAIN	1 1/2"	1 1/2"	-	1/2"	
	FLOOR SINK	4"	2"	-	-	W/ TRAP PRIMER
	FLOOR DRAIN	2"	1 1/2"	-	-	W/ TRAP PRIMER

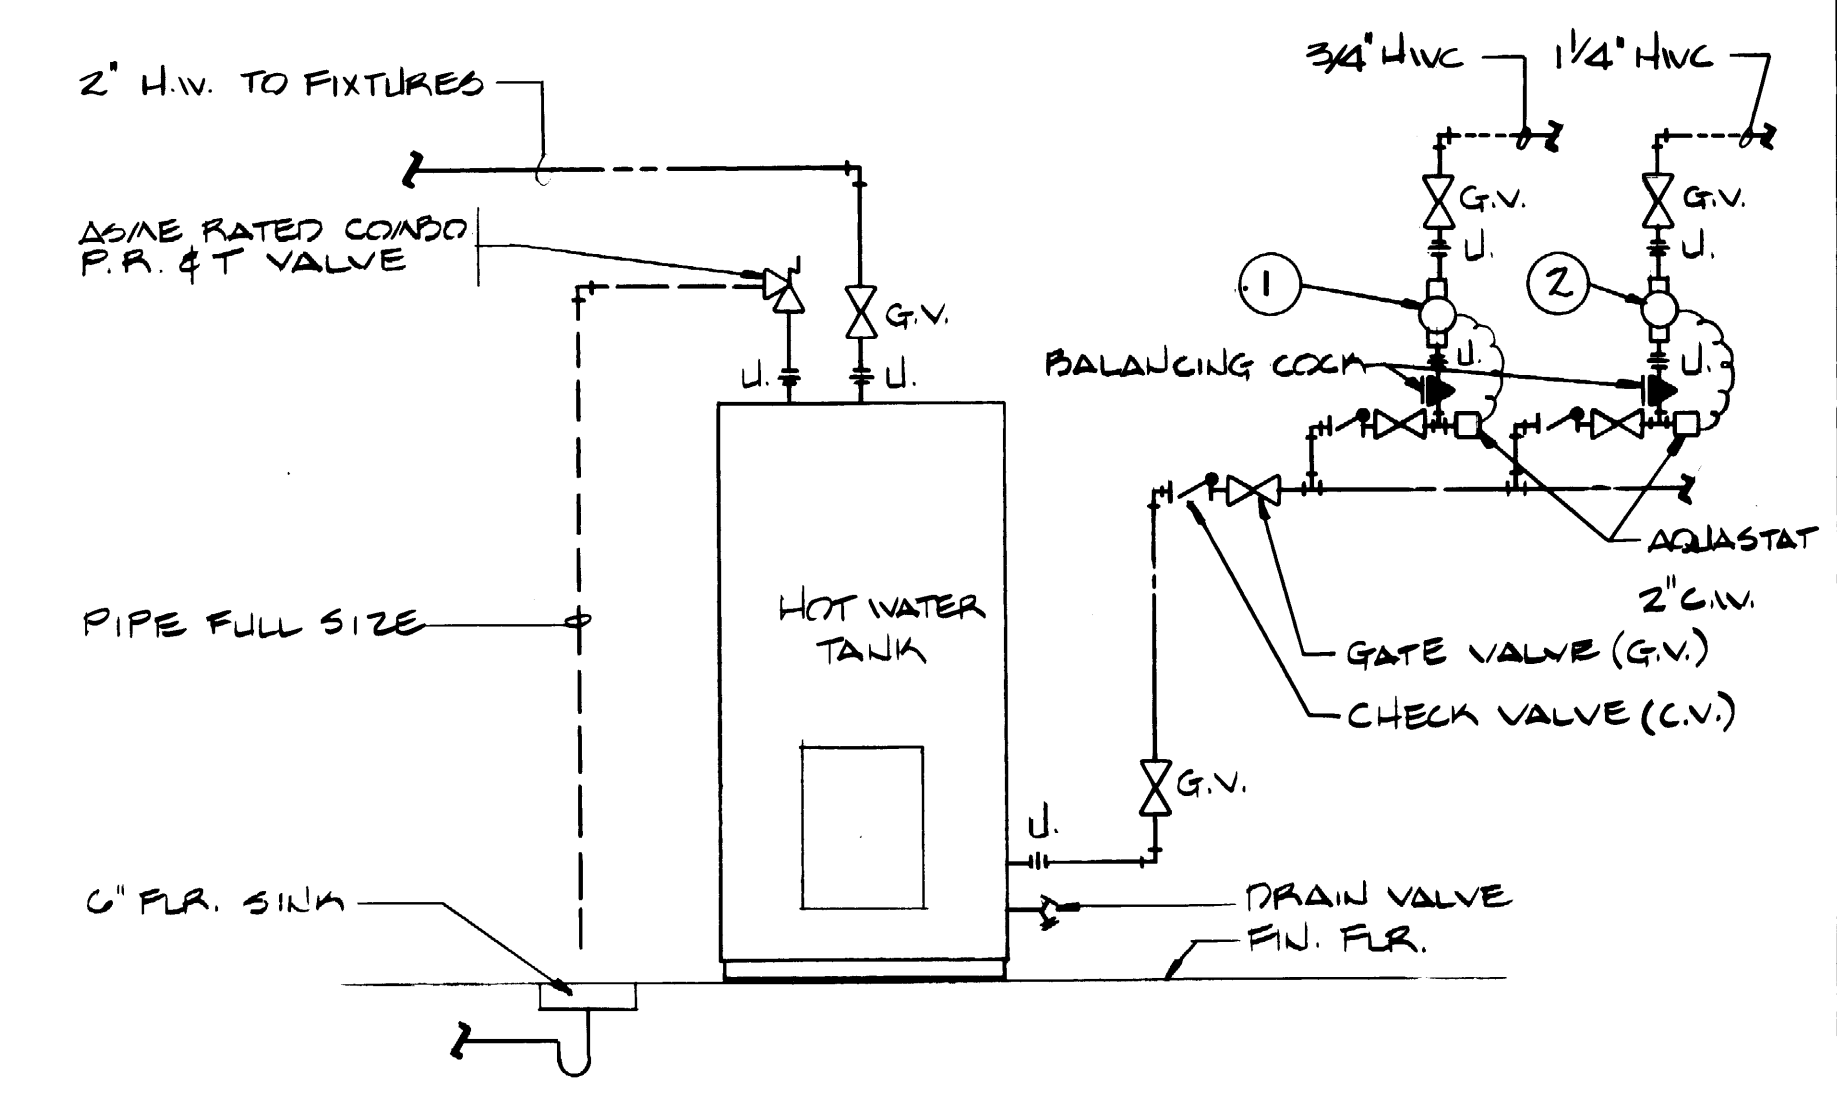

HOT WATER TANK DETAIL
NO SCALE




DRAWN		DATE		APPROVED		DATE	
CHECKED		DATE		PROJECT MANAGER		DATE	
CHECKED		DATE		CHIEF ENGINEER		DATE	
CONT. NO. 222		FIELD BOOK (S)		APPROVED		DATE	
SCALE		DRAWING NO. EP-3883-23		PROJECT NO. 8-M11-2		SHEET M11-2 OF 8	

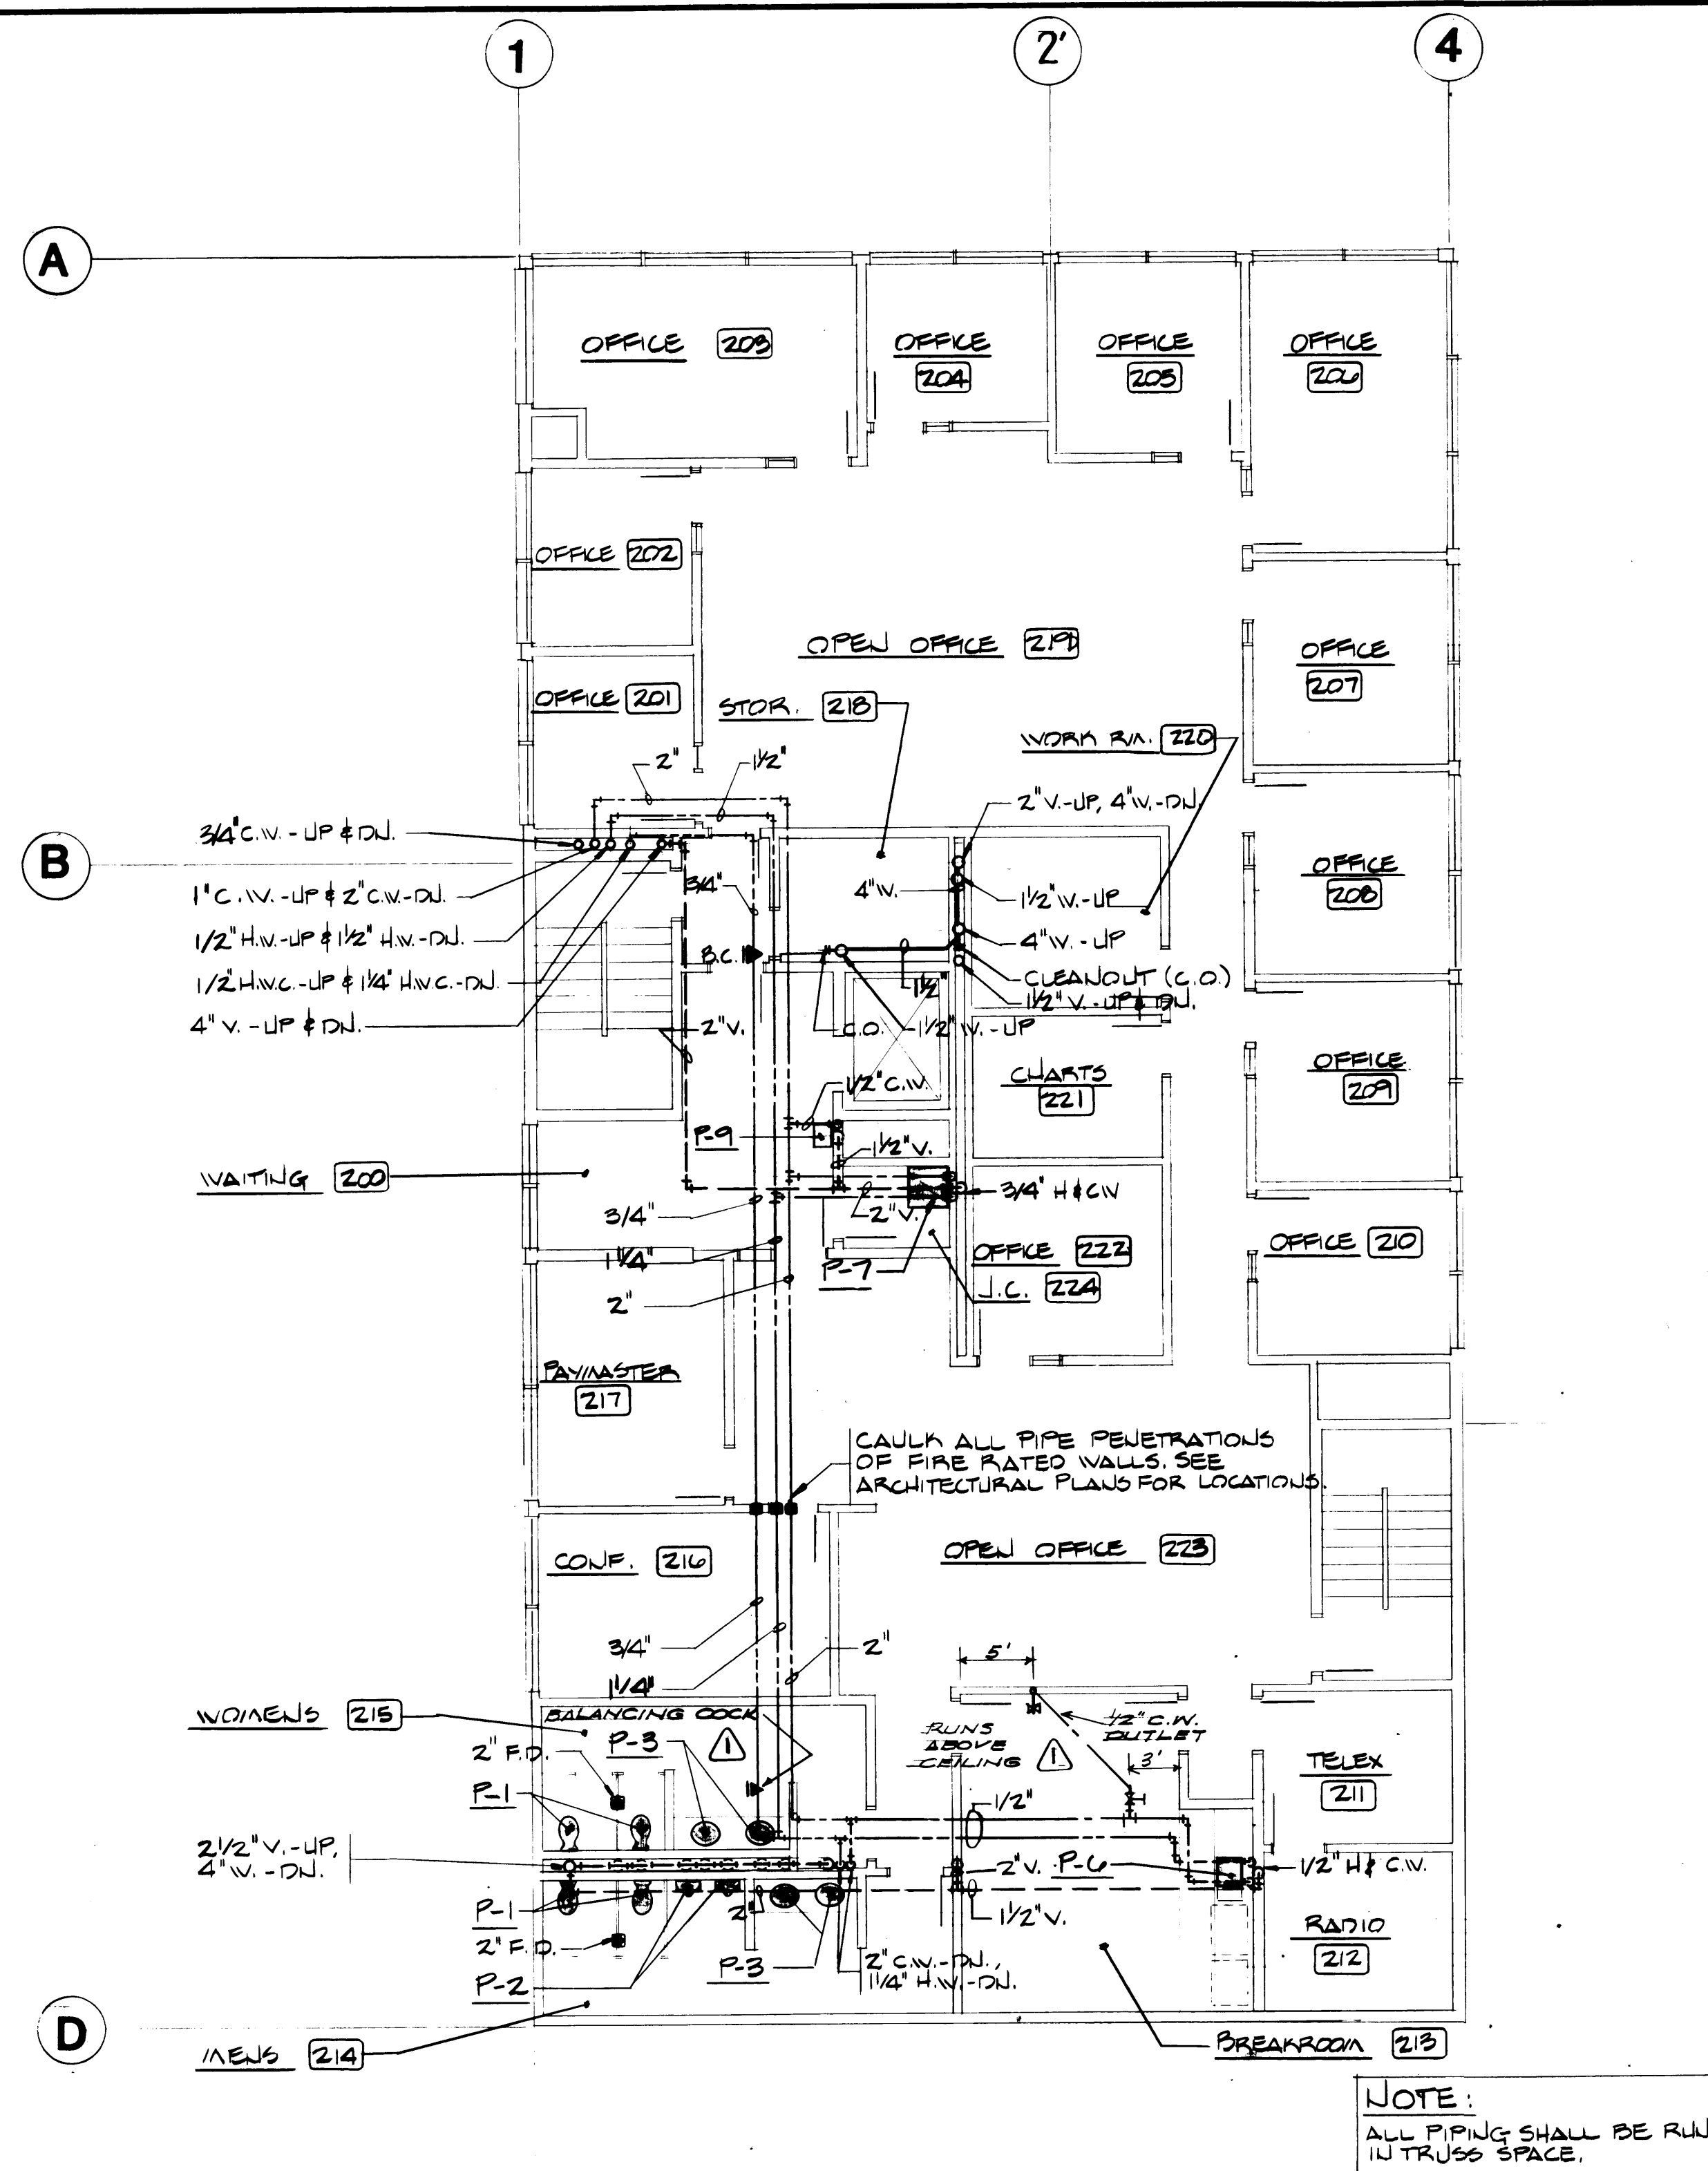

SECOND FLOOR PLAN-PLUMBING

SCALE: 1/8" = 1'-0"

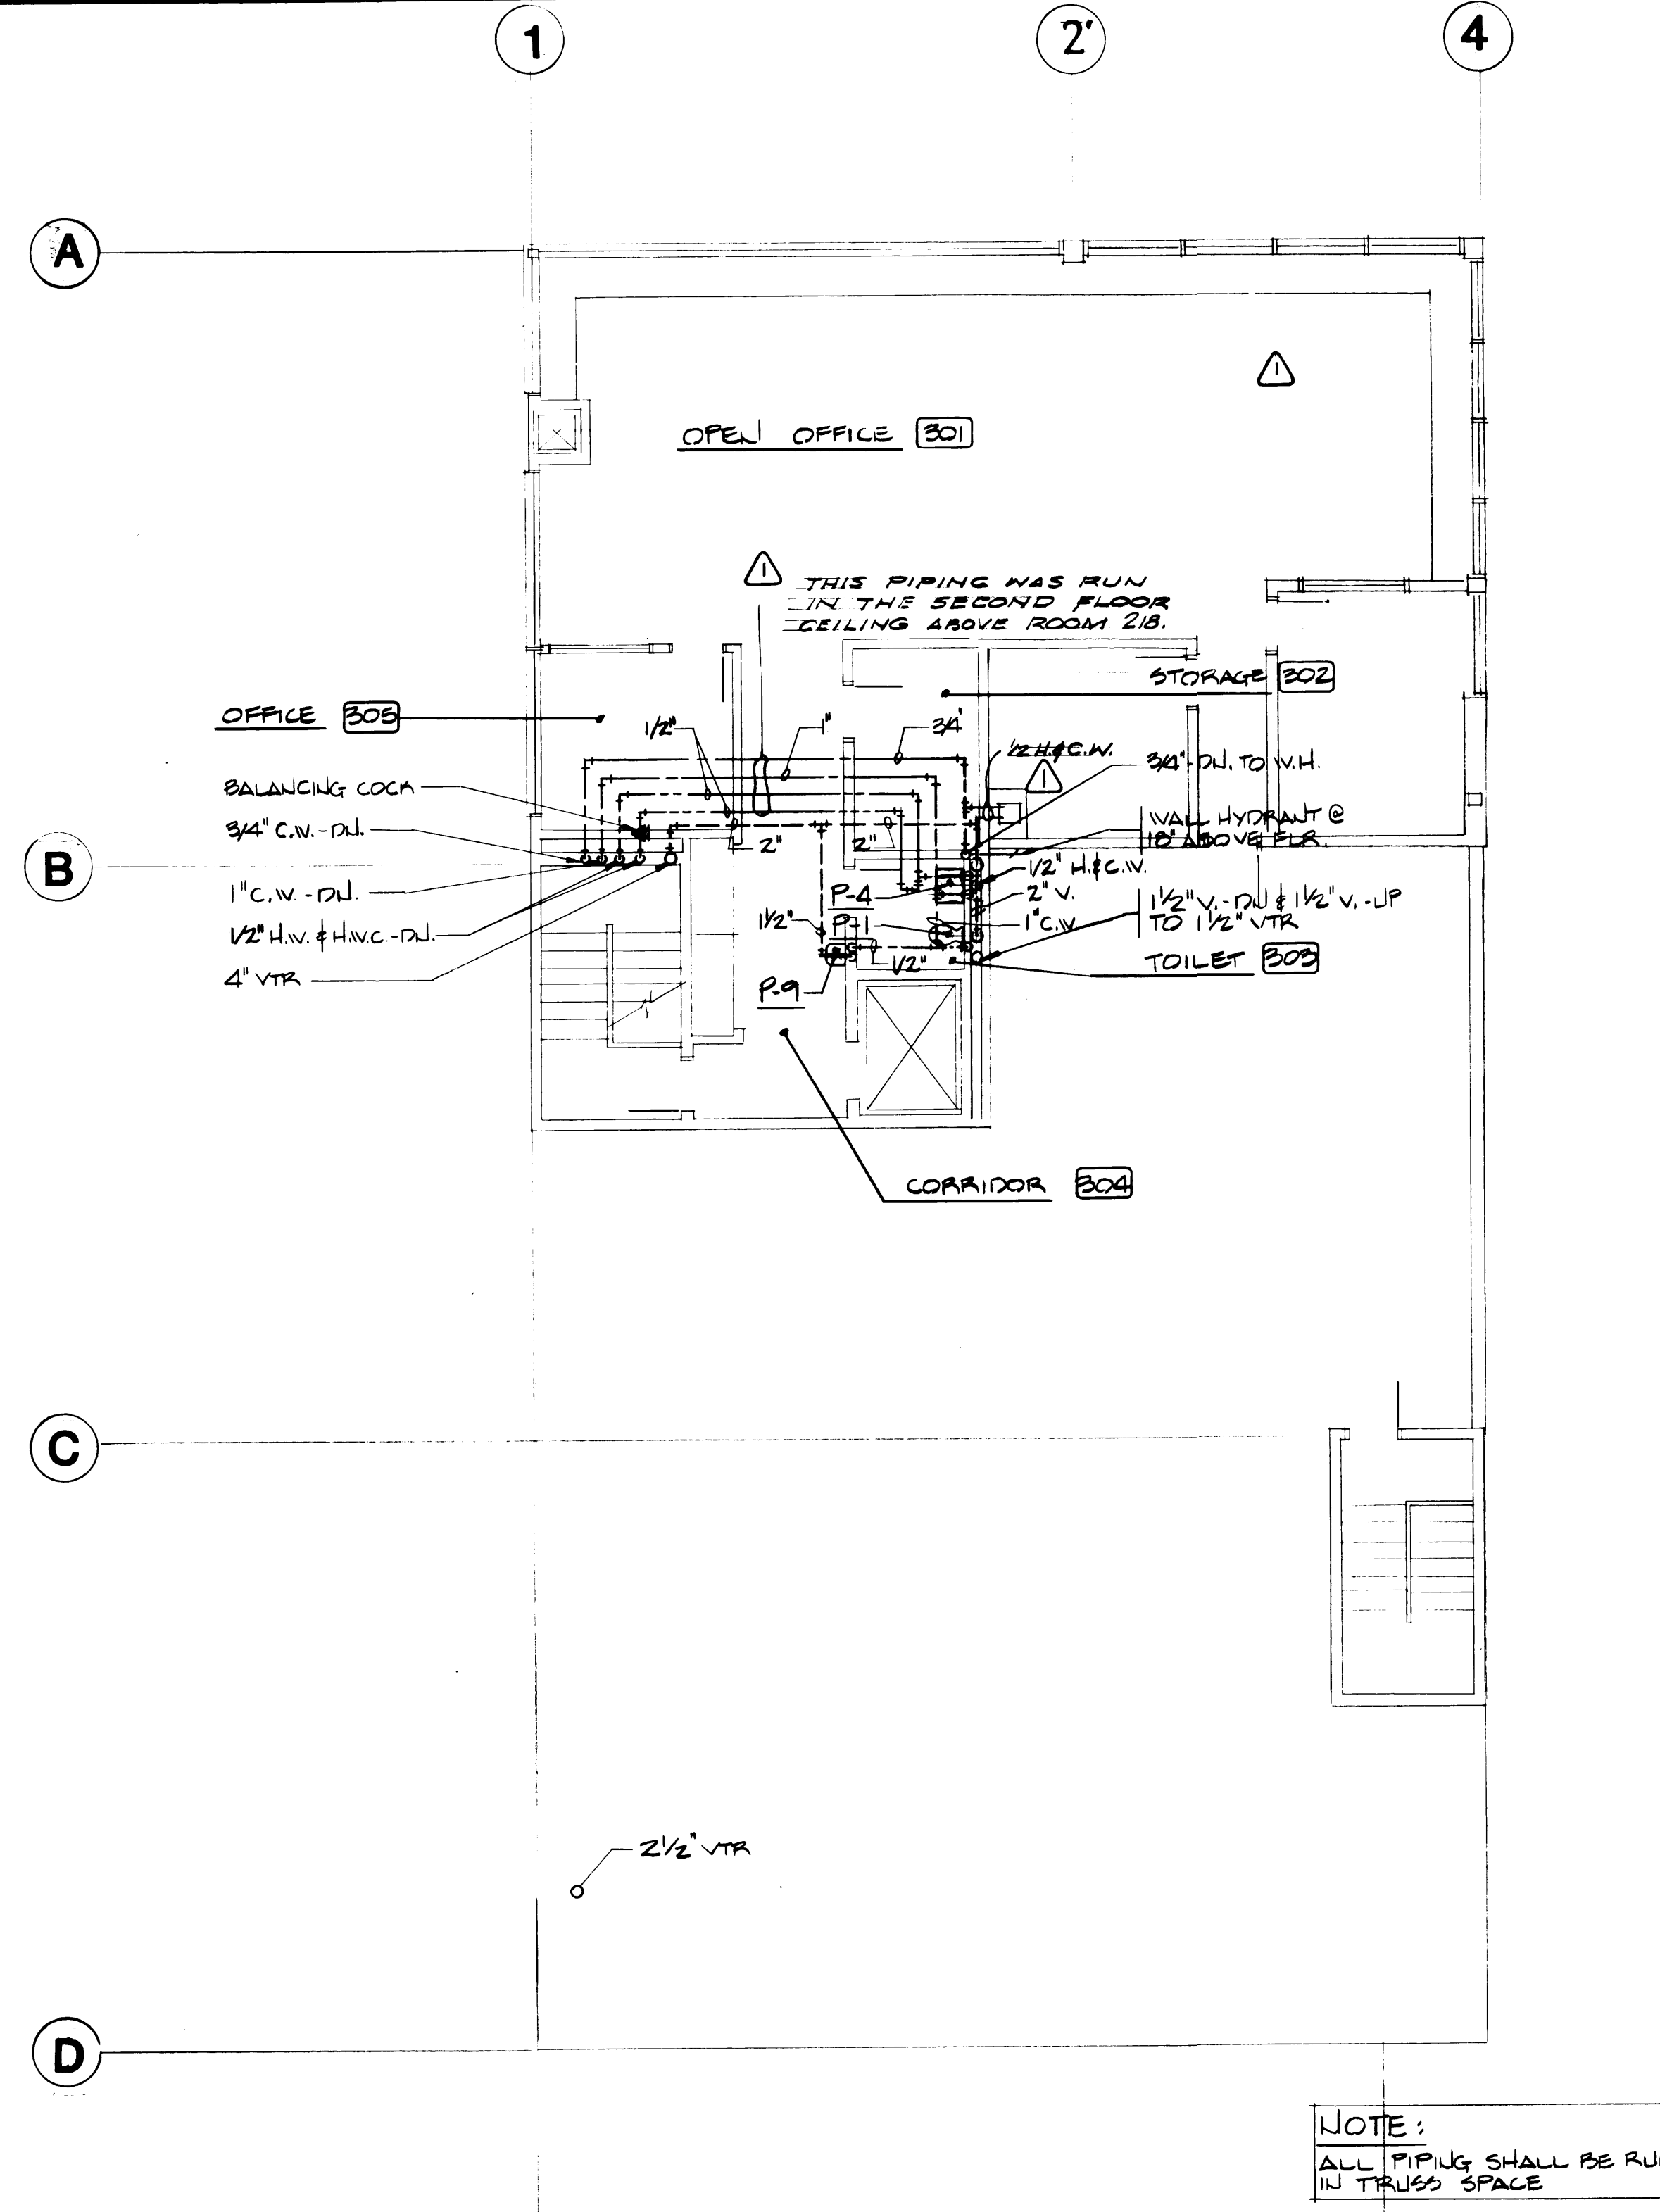

THIRD FLOOR PLAN-PLUMBING

SCALE: 1/8" = 1'-0"



DRAWN		DATE		PORT OF TACOMA	
CHECKED		DATE		TACOMA TERMINALS, INC.	
CHECKED		DATE		MANAGEMENT SERVICES BUILDING	
CHECKED		DATE		SECOND & THIRD FLOOR	
CHECKED		DATE		PLUMBING PLANS	
CONT. NO. 562		FIELD BOOK (S)		SCALE	
APPROVED		DATE		DRAWING NO.	
PROJECT MANAGER		DATE		EP-3893-23	
CHIEF ENGINEER		DATE		6-M11-3	
SHEET		M11-3 OF 8		SHEET	

MARK	REVISION	BY	APP.	DATE
1	REVISED TO AS BUILT	RJS		7-4-84

SCALE: $1/8" = 1' - 0"$




PLAN NOTES

- ① 24/6 T.G. WITH FIRE DAMPER. MOUNT ABOVE DOOR. GRILLE ON BOTH SIDES OF WALL.

[illegible]

HEAT PUMP SCHEDULE																							
UNIT #	AREA SERVED	WFA.	INODEL NO.		COOLING CAPACITY							INTEGRATED HEATING CAPACITY					INDOOR BLOWER			FILTERS NO & SIZE	NOTES		
			INDOOR	OUTDOOR	INDOOR COIL CFM	ENB	EAT	TOTAL COOLING	SENSIBLE COOLING	COMP. OUTDOOR P.P.	O.D. UNIT VOLTS	Φ	OUTDOOR EAT	TOTAL HEAT CAPACITY BTU/Hr	COMPRESSOR WATTS INPUT	AUX. ELECT. HEAT KW/VOLTS	S.P.	MOTOR HP	ELECT. V.			Φ	
1	3RD FLR MARINE SERVICES BULK	TRANS	ENHTR4100A	ENHTR4000	1640	67°	78°	49,500	30,700	5800	95°	460	3	22°	31,300	4.16		40	1/2	230	1	2'-20" x 20" x 1"	

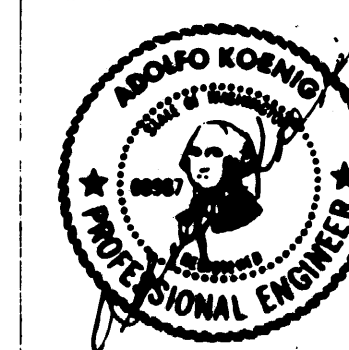

DRAWN _____
DATE _____
CHECKED _____
DATE _____
CHECKED _____
DATE _____
CONT. NO. _____

PORT OF TACOMA

TACOMA TERMINALS, INC.

MARINE SERVICES BUILDING

FIRST FLOOR PLAN - HVAC

FIELD BOOK (S) _____

APPROVED _____
PROJECT MANAGER
TE _____
CHIEF ENGINEER

9/24/84
DATE
11
DATE


SCALE _____

DRAWING NO.
EP-3893-23



6-M11-5

SHEET **M11-5** OF **8**


MARK	REVISION	BY	APP.	DATE

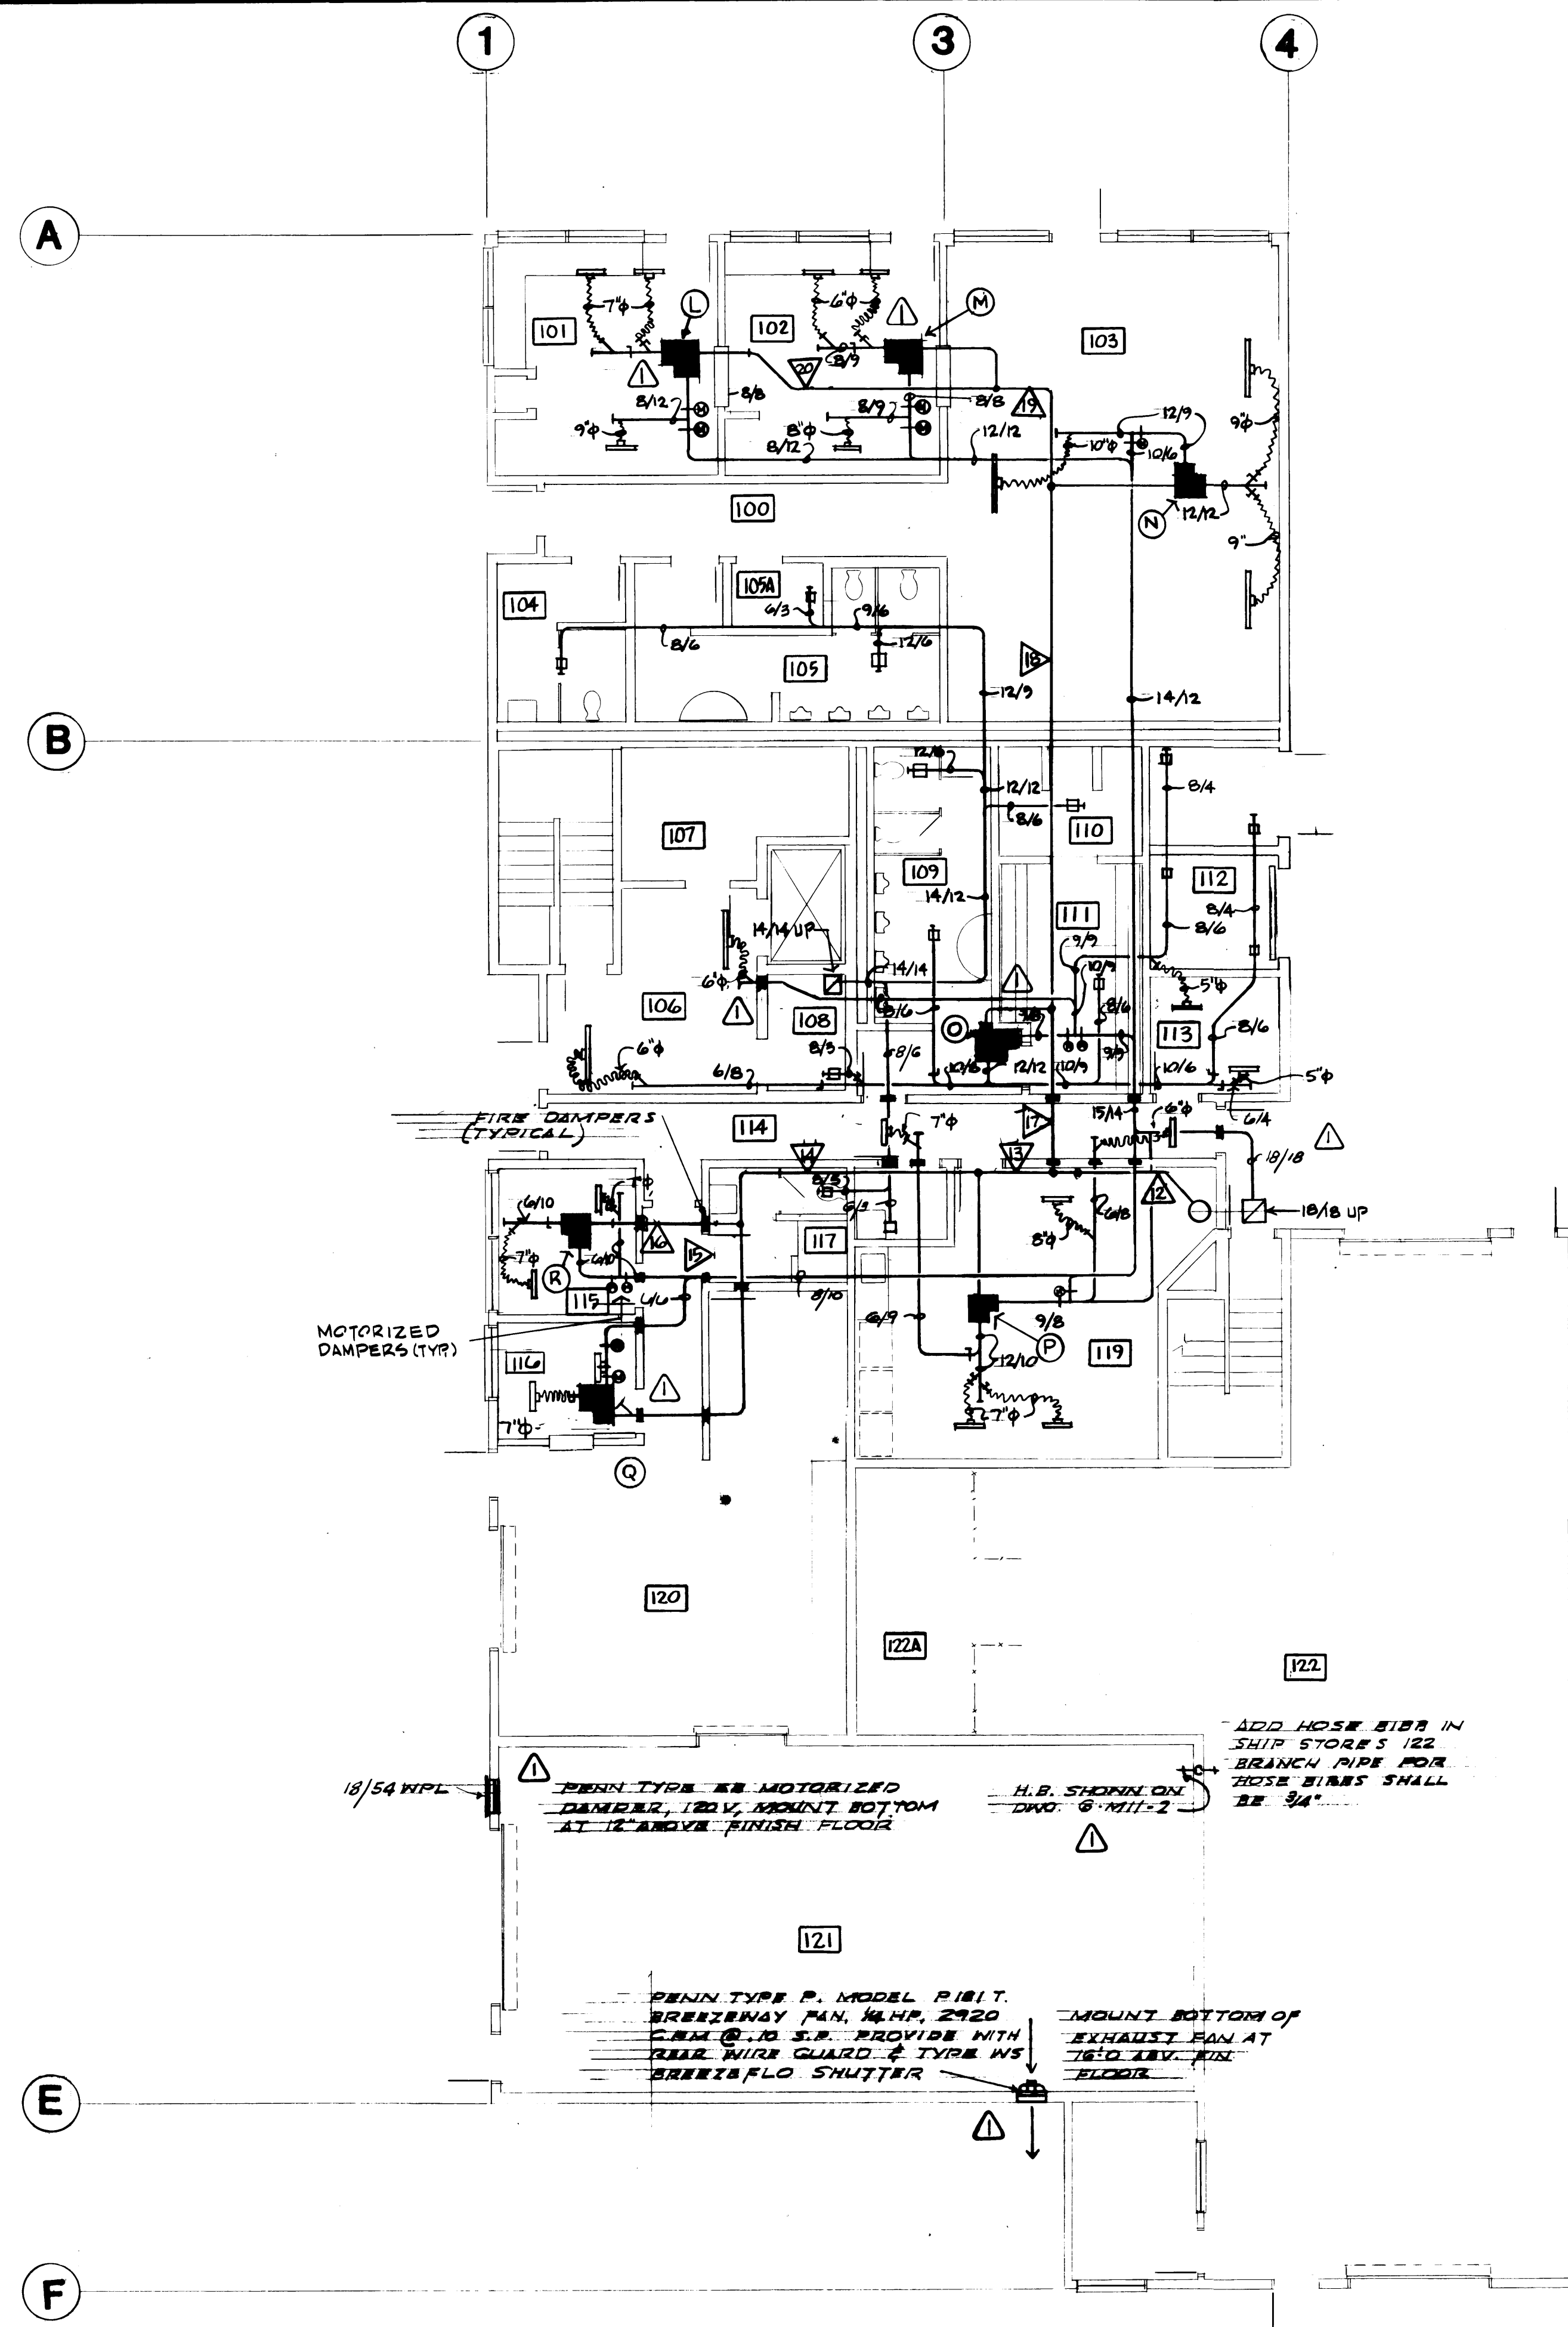


FIRST FLOOR CEILING PLAN
SCALE: 1/8" = 1'-0"

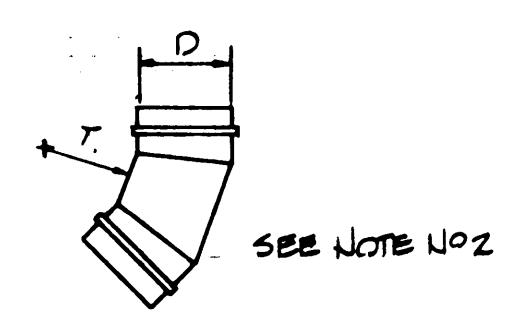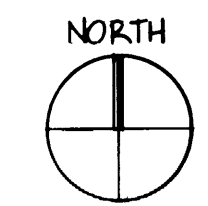


45° ELL

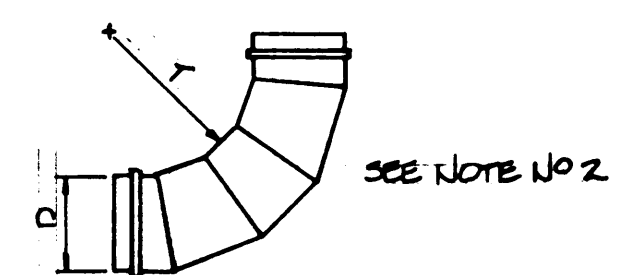


90° ELL

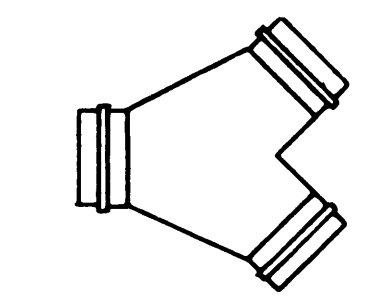

Y-FITTING

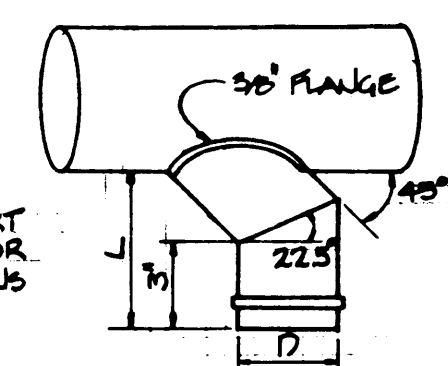

45/90° TEE

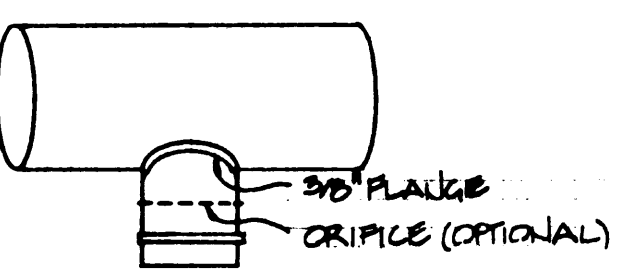


90° TEE


45/90° TEE	90° TEE
12"	12"
14"	14"
16"	16"
18"	18"
20"	20"
22"	22"
24"	24"
26"	26"
28"	28"
30"	30"

NOTES

- USE SLICES INSTEAD OF ROUND-RECTANGULAR-ROUND WHERE D/D IS GREATER THAN 2/3.
- T/D = 1.0 UP TO 14" DIA. T = 1.5 FOR 16" DIA. & LARGER.
- USE INSTEAD OF 90° TEE WHERE TRUNK DUCT VELOCITY EXCEEDS 3000 FT/MIN. 20 GAGE PERFORATED METAL ROUND DUCT FLUSH W/MAIN DUCT 1/2" HOLES ON 1 1/4" CENTERS DIAMETER OF CIRCLE TO FIT MAIN DUCT. 8/5 = DIAMETER OF MAIN DUCT.

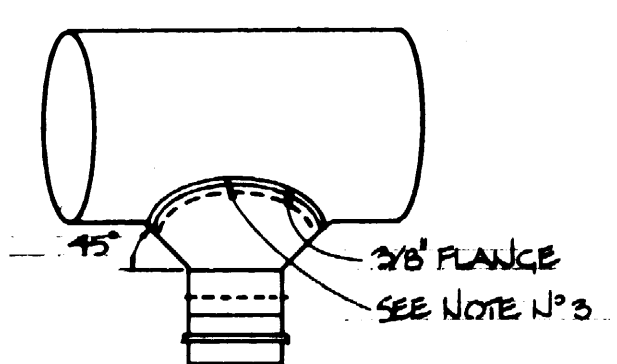


CONICAL 90° TEE

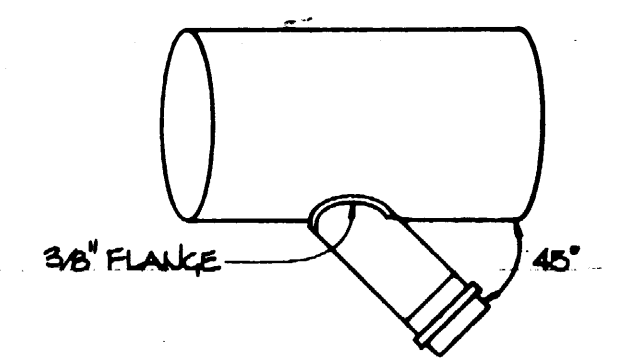


45° TEE


FITTING DIA.	MAT'L GAGE
UP TO 8"	24
9"-14"	22
15"-18"	20

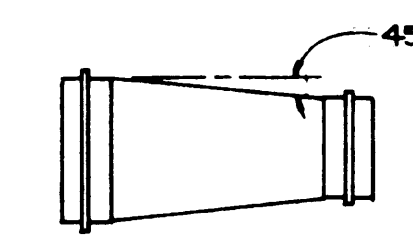

REDUCER

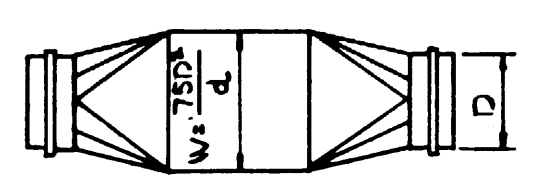


ROUND/RECTANGULAR/ROUND

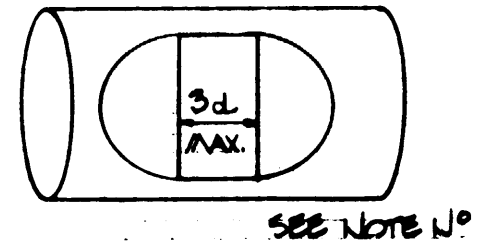


SLICE IN ROUND DUCT

HIGH VELOCITY DUCT DETAILS
NO SCALE

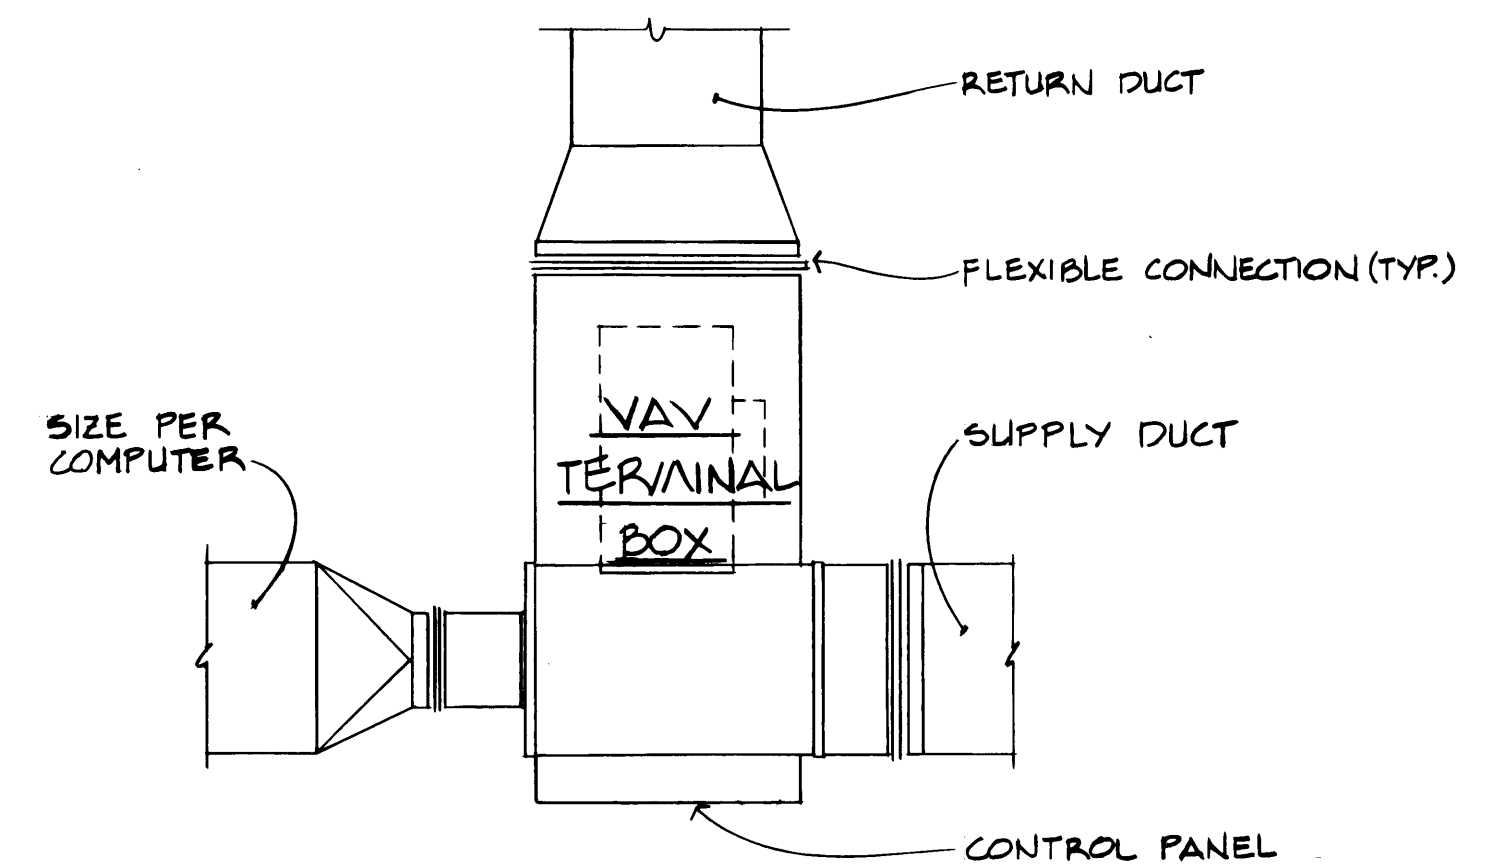

TYPICAL VAV TERMINAL BOX CONNECTIONS
NO SCALE

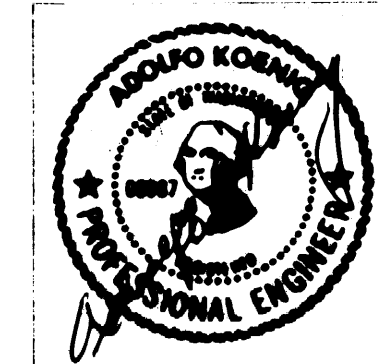

DRAWN _____		DATE _____		CHECKED _____		DATE _____		CHECKED _____		DATE _____		CONT. NO. 882		FIELD BOOK (S) _____		APPROVED _____		DATE 9/24/84		PROJECT MANAGER _____		DATE 11		SHEET M11-6 OF 8	
REVISION		BY		APP.		DATE		REVISION		BY		APP.		DATE		REVISION		BY		APP.		DATE		REVISION	

PORT OF TACOMA
TACOMA TERMINALS, INC.
MARINE SERVICES BUILDING
FIRST FLOOR CEILING PLAN - HVAC

REVISION	BY	APP.	DATE
1	RJS		9-5-88
2			
3			
4			
5			
6			
7			
8			
9			
10			

	REVISED TO AS-BUILT.	R.J.S.	9-5-82	
	REVISION	BY	APP	DATE

SYSTEM LEGEND		
SYMBOL	DESCRIPTION	MOUNTING
	FIRE ALARM HORN	
	OUTDOOR FIRE ALARM HORN 101 #6	
	FIRE ALARM MANUAL PULL STATION	
	INDICATING LIGHT, WP (RED) SIMPLEX 4360 W/GUARD	
	FIXED TEMPERATURE HEAT DETECTOR 190°	CEILING
	RATE OF RISE HEAT DETECTOR	CEILING
	IONIZATION (SMOKE) DETECTOR	
	FIRE ALARM ANNUNCIATOR	
	DOOR HOLDER, 120 VOLT	COORDINATE W/ GENERAL CONTRACTOR
	INFRARED HEATER EMERSON * RDOM - 48, 4KW, 480 VOLT	
	INFRARED HEATER EMERSON * RDO 35-305, 3KW, 480 VOLT METAL SHEATH ELEMENT	
	WALL HEATER, SINGER * 6751-0-WJA12 120V, 750 WATT	SURFACE MT. +2'
	WALL HEATER, EMERSON * AWH-3157, 277V, 1.5 KW, W/T-STAT	SURFACE MT.
	UNIT HEATER, EMERSON * MOH-03-7-MT1, 3KW, 277V, W/T-STAT	WALL MT.
	UNIT HEATER MARKEL * P3P5 110CA1, 1-DCS-253, 1-A 6176	WALL MT.

LEGEND		
SYMBOL	DESCRIPTION	MOUNTING
	BRANCH CIRCUIT HOME RUN TO PANEL BOARD.	
	CROSS LINES INDICATE NUMBER OF (*12 MIN.) CONDUCTORS IN ADDITION TO GROUND. CONDUCTOR SIZE CONDUIT PER NEC	
	CONDUIT TURNED UP CONDUIT TURNED DOWN	
	CONDUIT & WIRING CONCEALED IN OR UNDER FLOOR	
	CONDUIT EXPOSED	
	CONDUIT & WIRING CONCEALED IN WALLS & CEILING	
	CONDUIT STUBBED-OUT AND CAPPED	
	MAIN DISTRIBUTION PANEL OR SWITCHBOARD	
	LIGHTING OR POWER PANEL	
	SWITCHES, SINGLE POLE, 3 WAY, 277 VOLT	+48"
	SWITCH W/ PILOT LIGHT, 277 VOLT	
	DUPLEX RECEPTACLE, 120V, 15 AMP	+24" SHOP AREA +12' OFFICE AREA
	20AMP RECEPTACLE	SEE SPECIFICATION
	GROUND FAULT RECEPTACLE	SEE SPEC.
	FLOOR BOX WITH RECEPTACLE SURFACE FITTING WALKER 800 SERIES W/ BRASS COVER PLATE & CARPET RING	FLOOR
	480V, WELDING OUTLET, 30 AMP. PYLE NATIONAL #	+48"
	240V OUTLET, 30 AMP 1 PHASE	+48"
	50 AMP, AIR COMPRESSOR OUTLET 480V 3PHASE	
	30 AMP 120V OUTLET	+24"
	WIRE MOLD 2000 W/ RECEPTACLE 18" ON CENTER	
	FLOOR BOX FOR TELEPHONE/COMPUTER DATA SERVICE WALKER 800 SERIES W/ BRASS COVER PLATE & CARPET RING	FLOOR
	TELEPHONE OUTLET W/ 3/4"C. STUB UP TO CEILING SPACE OR AS SHOWN.	
	COMPUTER DATA OUTLET W/ 3/4"C. STUB UP TO CEILING SPACE OR AS SHOWN.	
	3 POLE UNFUSED DISCONNECT SWITCH	
	FUSED DISCONNECT SWITCH FUSE AS REQUIRED BY MANUFACTURER	
	COMBINATION MOTOR CONTROLLER	
	MOTOR CONNECTION	
	WEATHER PROOF	
	EXPLOSION PROOF	
	MECHANICAL CONTRACTOR	
	ELECTRICAL CONTRACTOR	
	JUNCTION BOX W/ COVER PLATE.	
	EQUIPMENT SYMBOL - MECHANICAL EQUIPMENT	
	MACHINE TOOL & SHOP EQUIPMENT	
	START-STOP PUSHBUTTON CONTROL STATION	+48"
	220V 30AMP OUTLET	
	FRACTIONAL HORSEPOWER MANUAL STARTERS W/MELTING ALLOY	

LIGHTING FIXTURE SCHEDULE			
SYMBOL	DESCRIPTION	LAMP	MOUNTING
A	HI-TEK TH 400 SALW-277-SF UPH-UPC	400 WATT HPS	SEE DETAIL DWG. 10/2
B	APPLETON *ASB-1550	150A19	SURFACE +48"
D	PRESCOLITE WB-2	100 WATT A-19	SURFACE CEILING
E	DUAL-LITE ALC-X-36-2-277V-ACON	-	SURFACE
F2a	LITHONIA - 2GP 240 A12.125-GLR-SL-ES-277V	2-F40 LW	GWB CEILING
F2	LITHONIA - 2GP 240 A12.125-GLR-SL-ES-277V	2-F40 LW	T-BAR
F3	LITHONIA - 2GP 340 A12.125-GLR-SL-ES-277V	3-F40 LW	T-BAR
F4	LITHONIA - 2GP 440 A12.125-GLR-SL-ES-277V	4-F40 LW	T-BAR
FA	LITHONIA - M240 MA12.125-GLR-SL-ES-277V	2-F40 LW	SURFACE
FB	LITHONIA - AF 240-GLR-ES-277V	2-F40 LW	PENDENT
FC	LITHONIA - AF 296-GLR-ES-277V	2-F40 LW	PENDENT
FD	LITHONIA DL-240A-277V-CW-R W/ BATTERY PAD	2-F40 LW	SURFACE
FE	LITHONIA DD-240A-277V-CW-R	2-F40 LW	SURFACE
FX	MORRIS KURTZON X12-B-40-L	2-F40 T12	SURFACE
FT	LITHONIA GP 240 A12.125-GLR-SL-ES-277V		GWB CEILING
FS	LITHONIA - 2PMGB 440-32-277VOLT, ES	4-F40 LW	T-BAR
G	HUBBELL PVL-01505-110, 480 VOLT	150 WATT HPS	SURFACE WALL
H	DEVINE B422-250 HPS-LX1-277V	250 WATT HPS	SURFACE CEILING
M	HI-TEK 18 HA A15150RS C73T 24-277V	150 WATT HPS	SURFACE CEILING
W	HI-TEK *TWP 1005, 480 VOLT	100 W HPS	SURFACE WALL
FI	MORRIS KURTZON *SUV2440 W/ POLYCARBONATE LENS	4-F40 LW	SURFACE MTD IN METAL BRACKET FURNISH BY GENERAL CONTRACTOR
TL	HUBBELL *QL503 W/ WIRE GUARD, PROVIDE LIGHTING SWITCH PER DETAIL DWG.	500 WATT QUARTZ	SEE DETAIL DWG. 05/13.1
TS	LAKEHORE MARKERS R-LB-4	2-60A	SURFACE
P	PRESCOLITE CF-2	100 WATT A19	CEILING SURFACE
EX	DUAL-LITE ALC-X-36-277V		WALL MOUNTED
X	DUAL LITE X-2100 4X-277V		WALL MOUNTED





NOTE: NOT ALL OF THE LIGHTING
FIXTURES NOTED IN THE ABOVE
SCHEDULE WERE USED ON THIS PROJECT

McGRANAHAN,
MESSENGER
ASSOCIATES
ARCHITECTURE / PLANNING / INTERIORS
MEMBER AMERICAN INSTITUTE OF ARCHITECTS • 180 FARMCOTT BLVD. SUITE 300, TACOMA, WA 98402 • (206) 263-3034

REVISION TO AS BUILT
BY DATE
REVISION BY DATE




DRAWN	DATE	APPROVED PROJECT MANAGER DATE 9/24/02 CHIEF ENGINEER	PORT OF TACOMA TACOMA TERMINALS, INC. ELECTRICAL SCHEDULES SCALE: NONE DRAWING NO. EP-3893-23 SHEET E0-1 OF 1
CHECKED	DATE		
CHECKED	DATE		
CONT. NO.	DATE		
FIELD BOOK (S)	APPROVED	DATE	

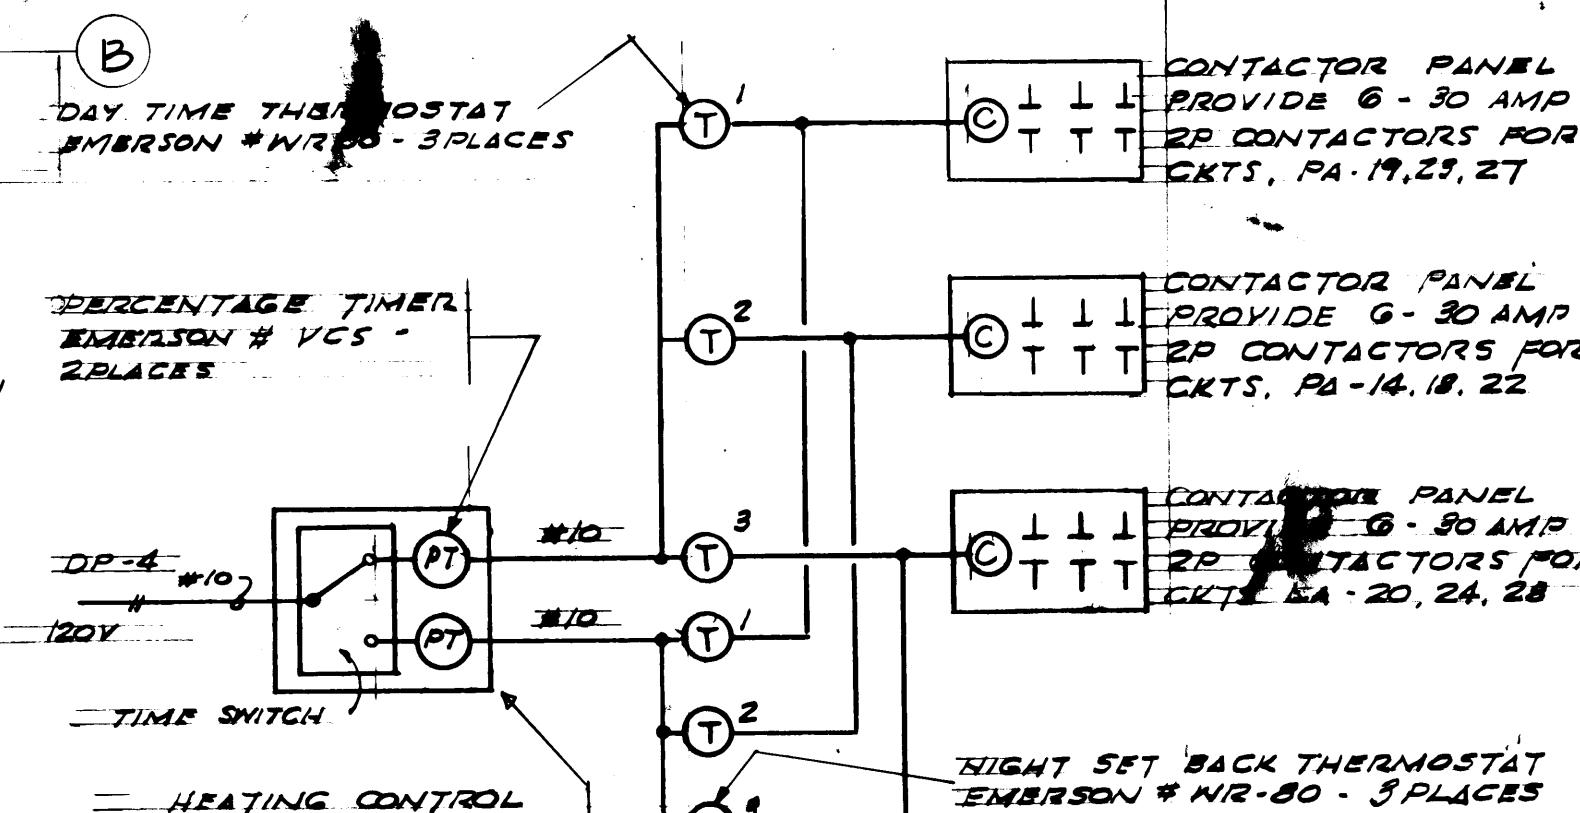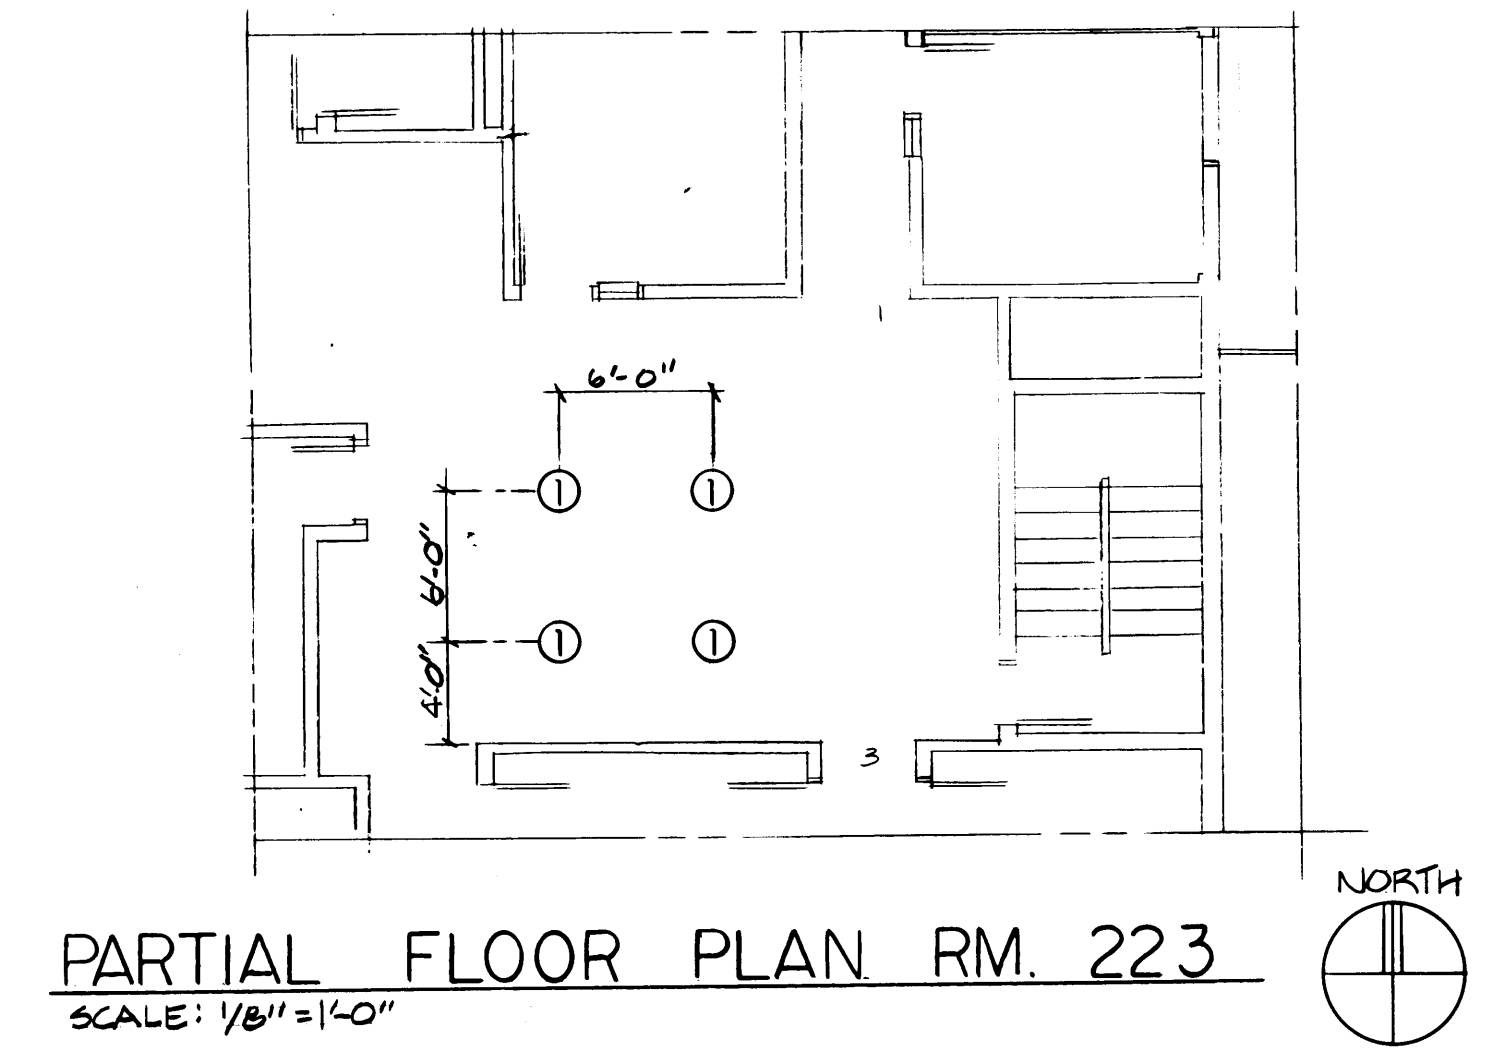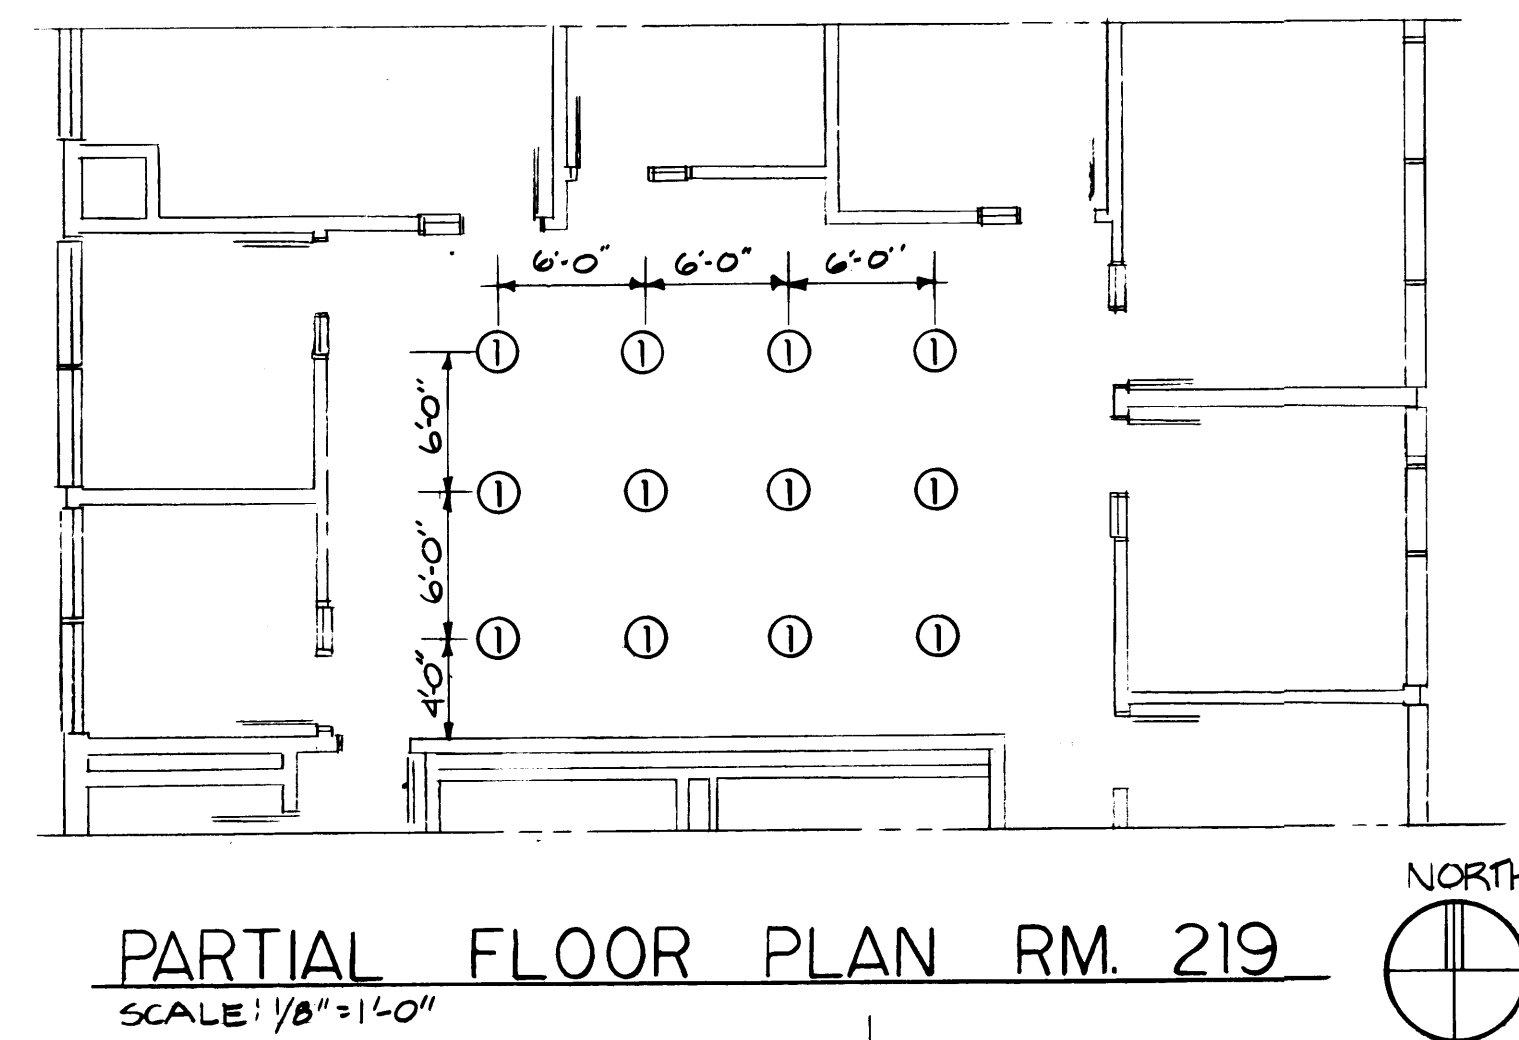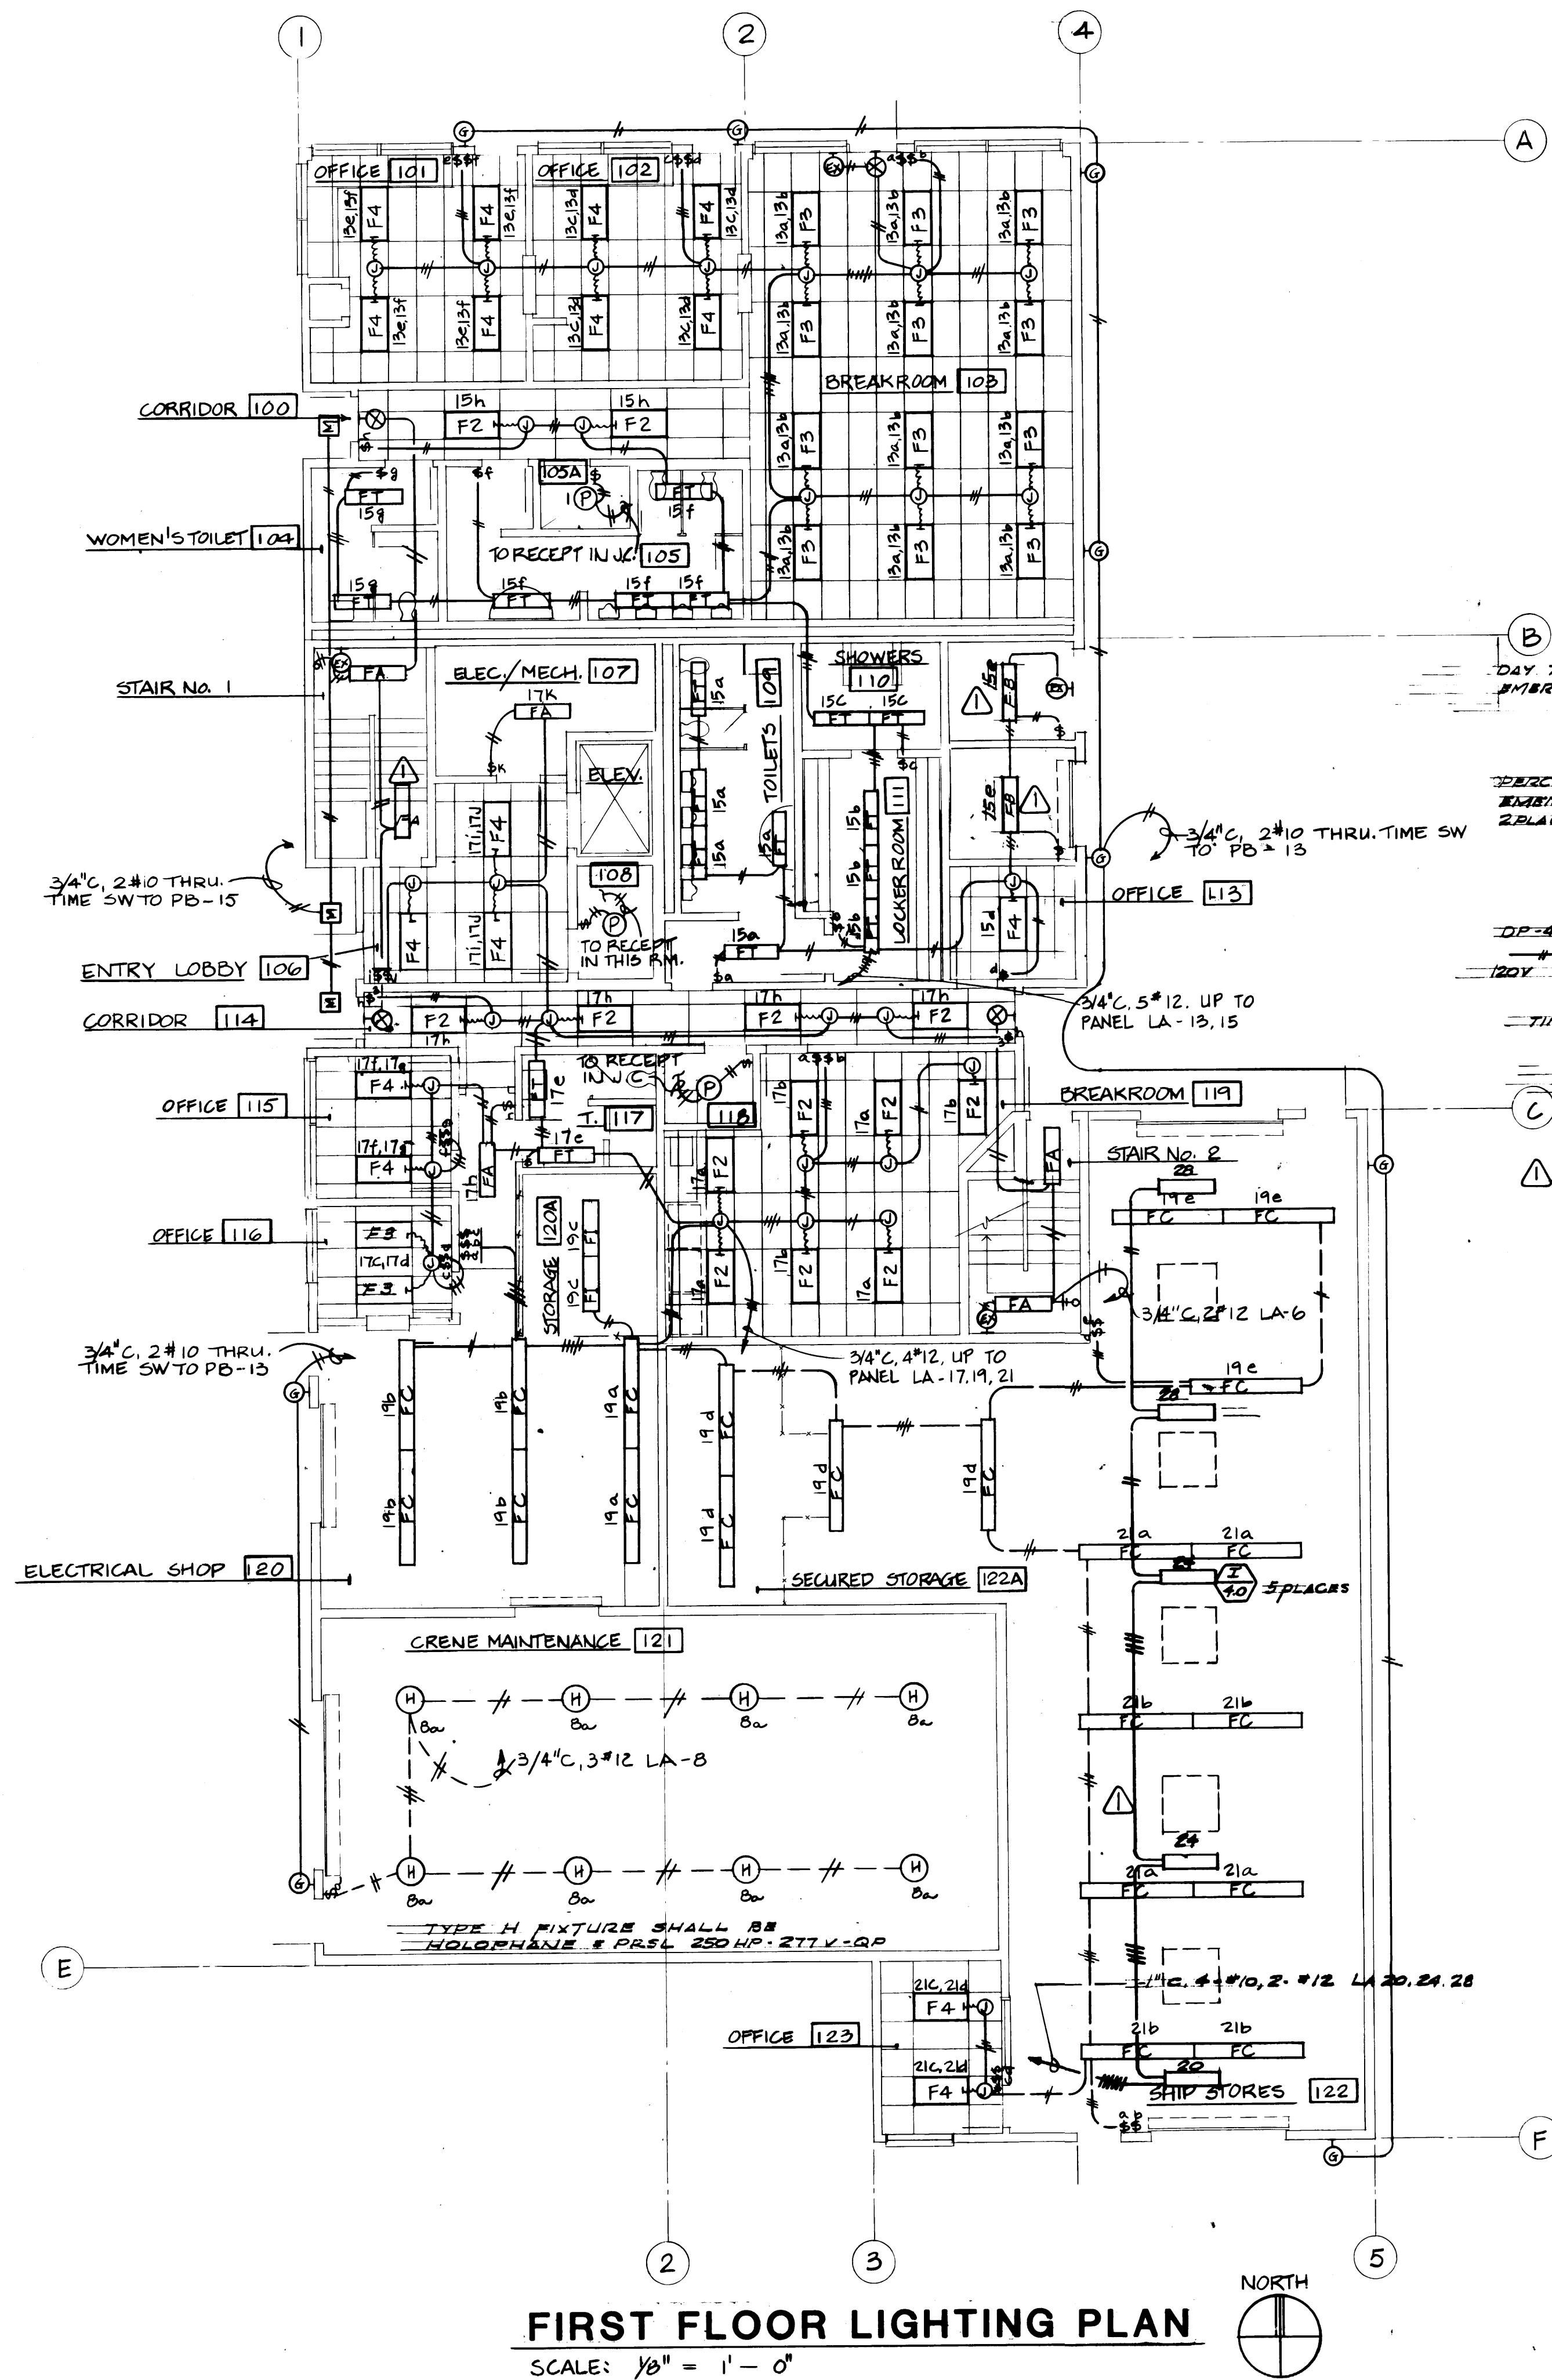


- ## FLOOR BOXES & NOTES
- ① PROVIDE
- I DUPLEX FLOOR OUTLET (SEE NOTE ①)
 - I CRT FLOOR OUTLET (SEE NOTE ②)
 - I TELEPHONE FLOOR OUTLET (SEE NOTE ③)

- ## NOTES
- ① PROVIDE CONDUIT & WIRING FROM DUPLEX FLOOR OUTLET (FLOOR J-BOX) TO PANEL "RA" FOR ROOM 219 AND TO PANEL "RA" FOR ROOM 223 MAXIMUM OF 2 FLOOR BOXES PER CIRCUIT AND HOME RUN. (3/4" C, 2" X 12, 1" X 12 GROUND).
 - ② PROVIDE 3/4" CONDUIT FROM CRT FLOOR BOX (J-BOX) TO CEILING SPACE. GROUP CONDUITS IN ONE SPACE.
 - ③ PROVIDE CONDUIT FROM TELEPHONE FLOOR BOX (J-BOX) TO TELEPHONE CABINET MAXIMUM 2 TELEPHONE FLOOR BOXES PER 1" C HOME RUN.
 - + ALL DRY TYPE TRANSFORMERS SHALL BE EQUIPPED WITH ELECTROSTATIC SHIELDS.


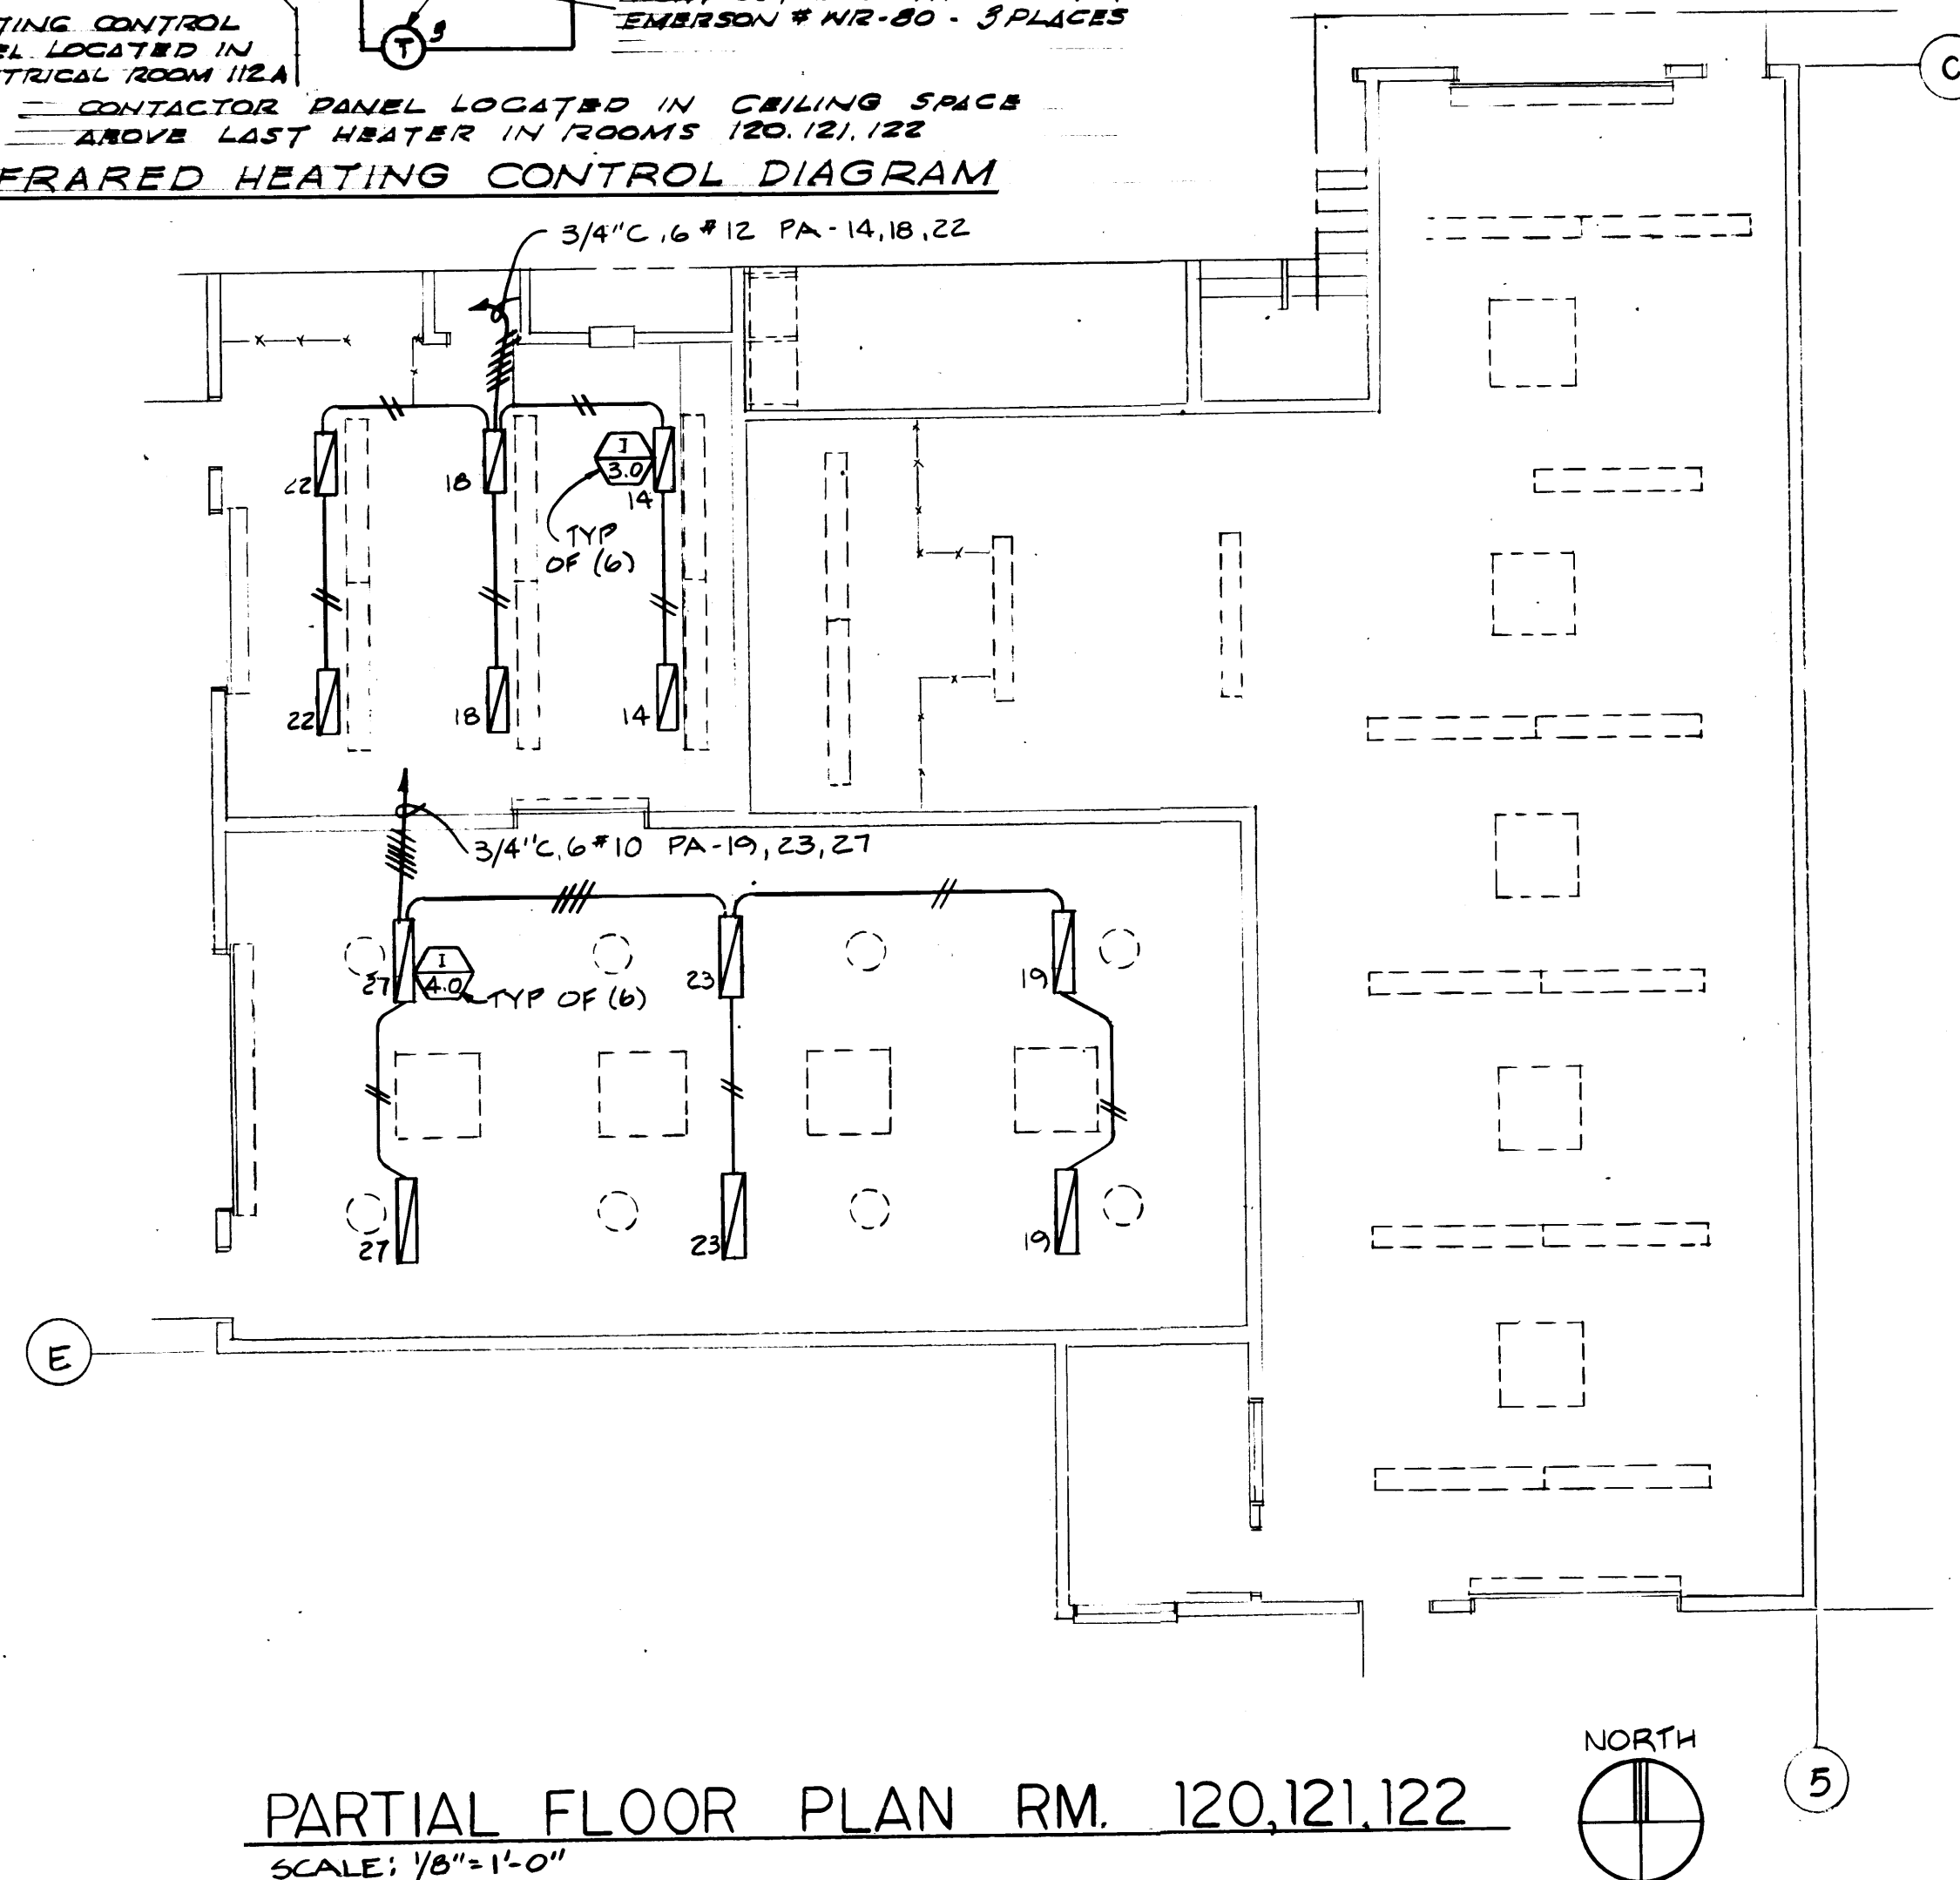


A circular professional engineer seal for Charles M.K. Li. The outer ring contains the text "CHARLES M.K. LI" at the top and "MECHANICAL ENGINEER" at the bottom. Inside the ring is a portrait of a man. To the left of the portrait is the year "1865" and to the right is the text "LICENSED". The words "STATE OF WASHINGTON" are arched above the portrait. The seal is stamped over a signature that appears to be "Charles M.K. Li".


DRAWN _____		PORT OF TACOMA TACOMA TERMINALS, INC. MARINE SERVICES BUILDING FIRST FLOOR LIGHTING PLAN	
DATE _____			
CHECKED _____			
DATE _____			
CHECKED _____			
DATE _____			
CONT. NO. 502			
FIELD BOOK (S) _____		SCALE _____	
APPROVED _____		DRAWING NO. EP-3893-23	
_____ PROJECT MANAGER		6-E11-1	
_____ CHIEF ENGINEER		SHEET E11-1 OF 6	

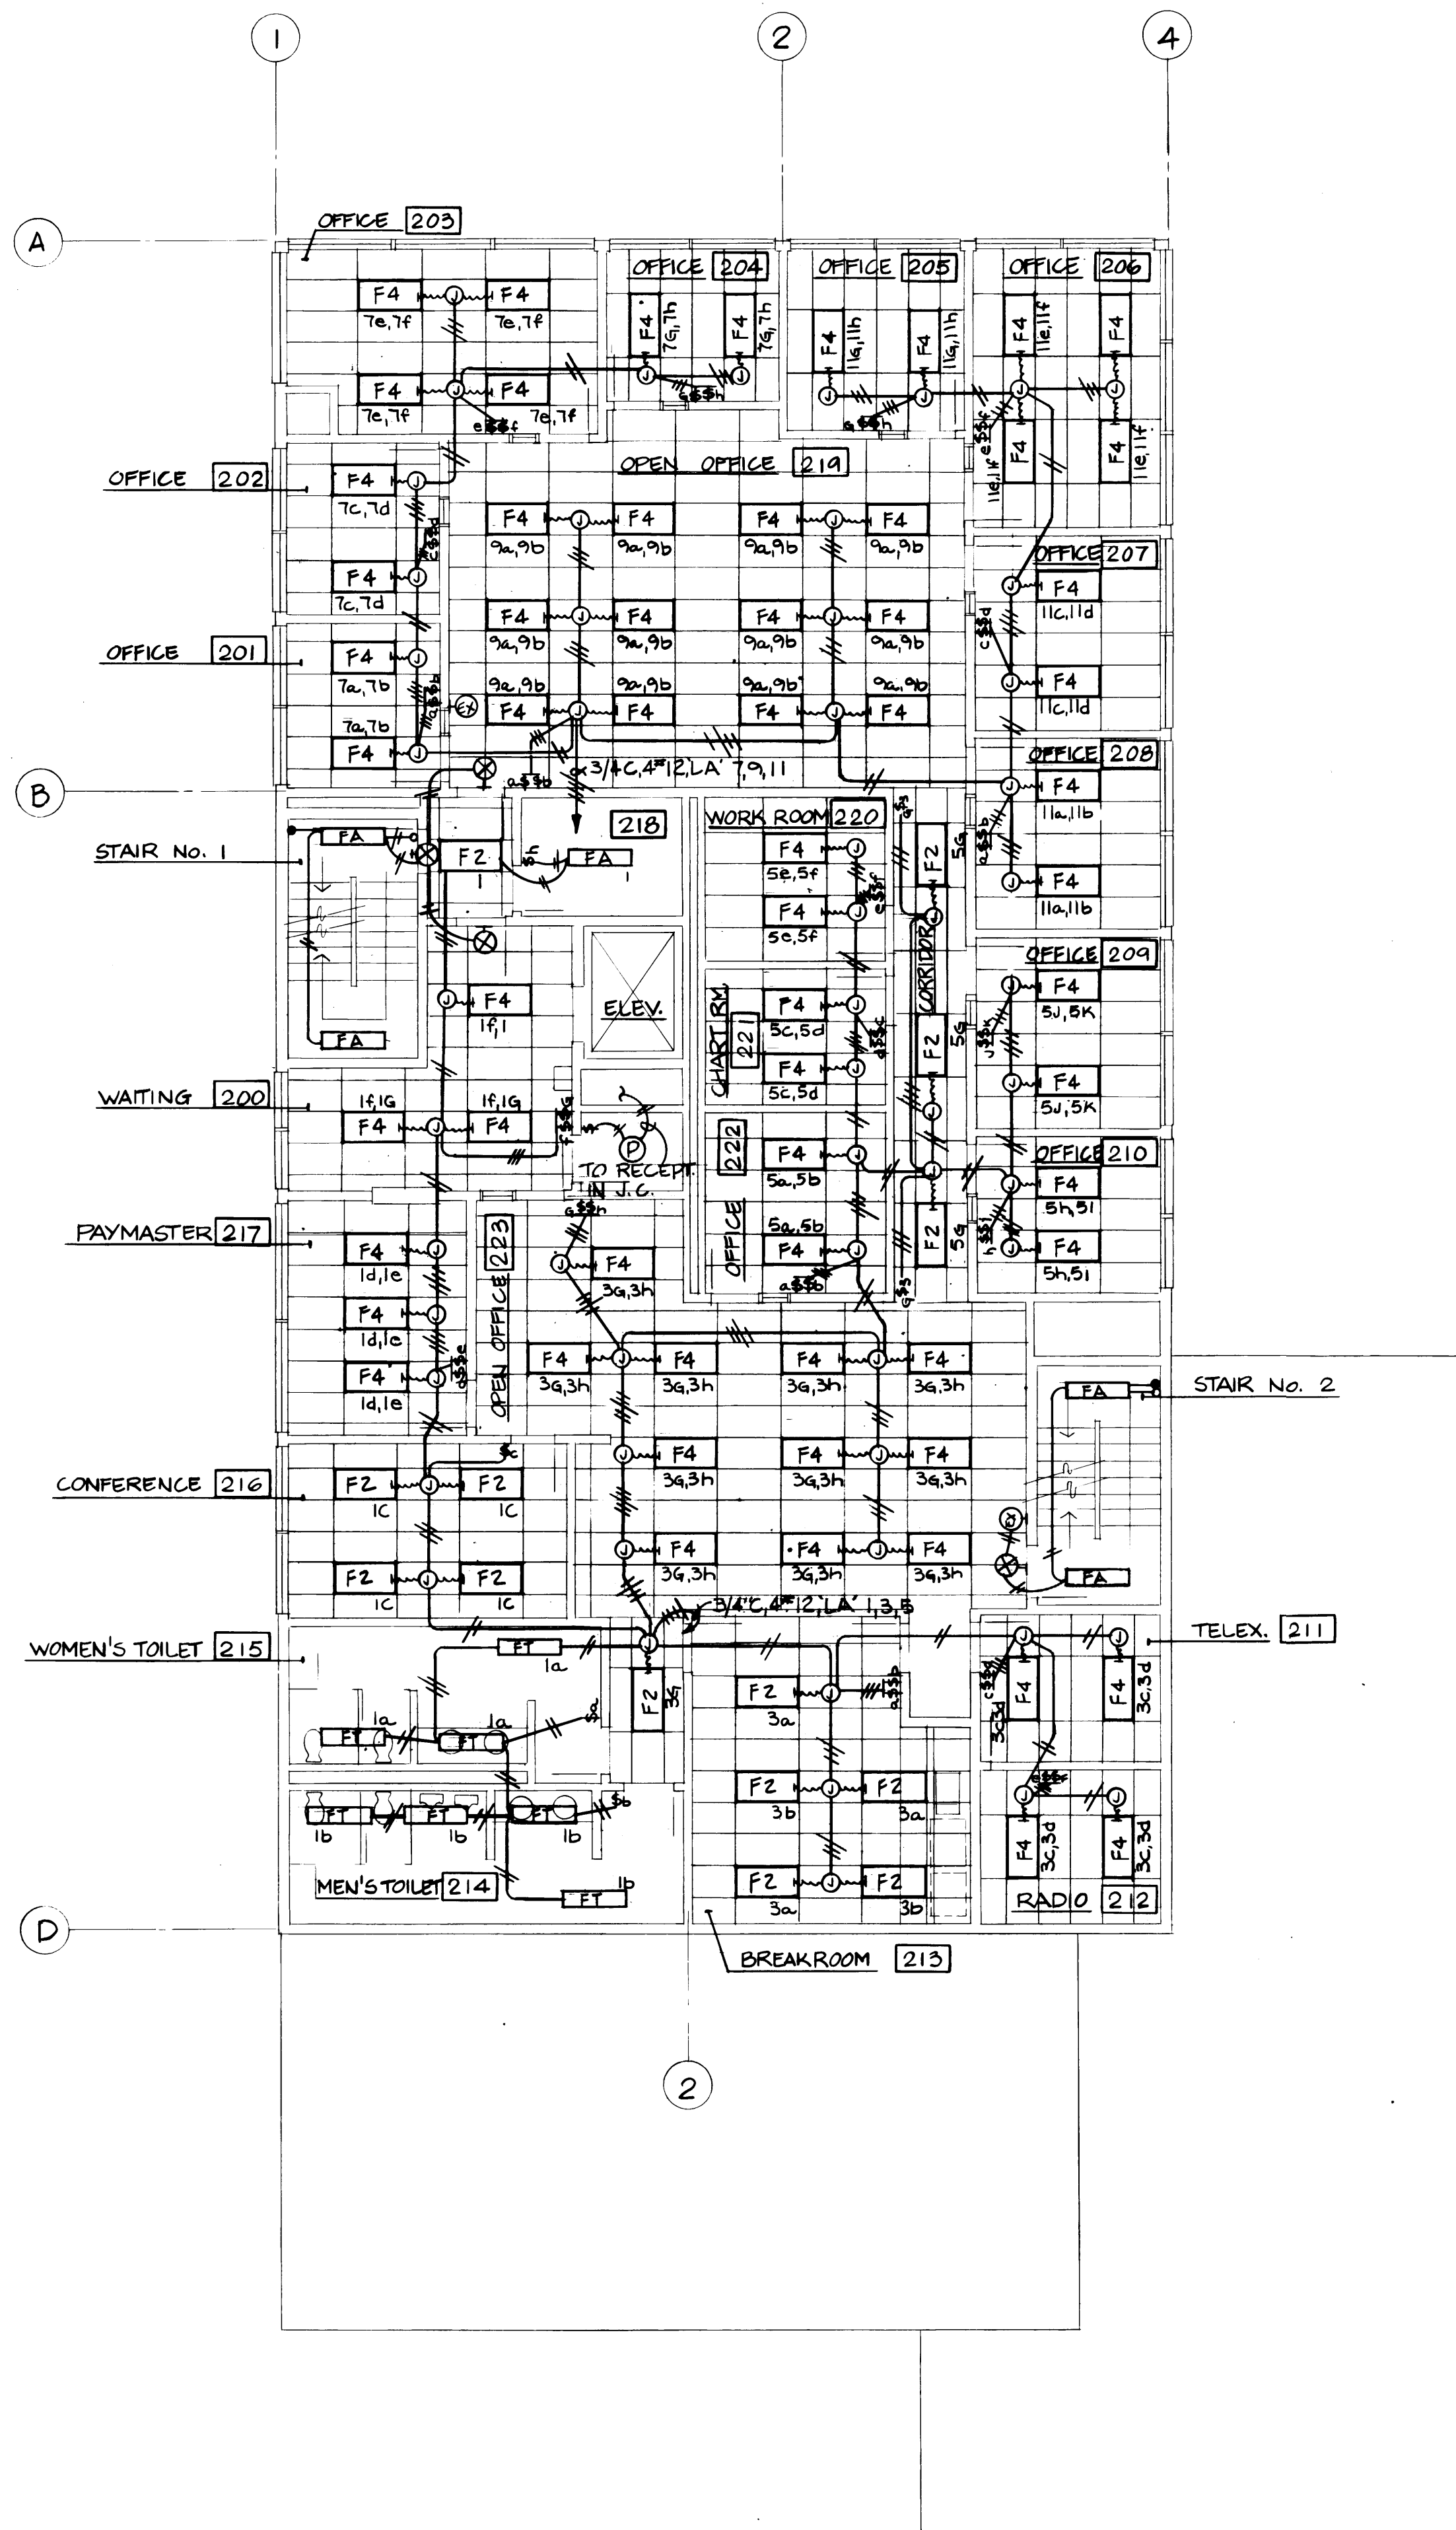


SECOND FLOOR LIGHTING PLAN
SCALE: 1/8" = 1' - 0"

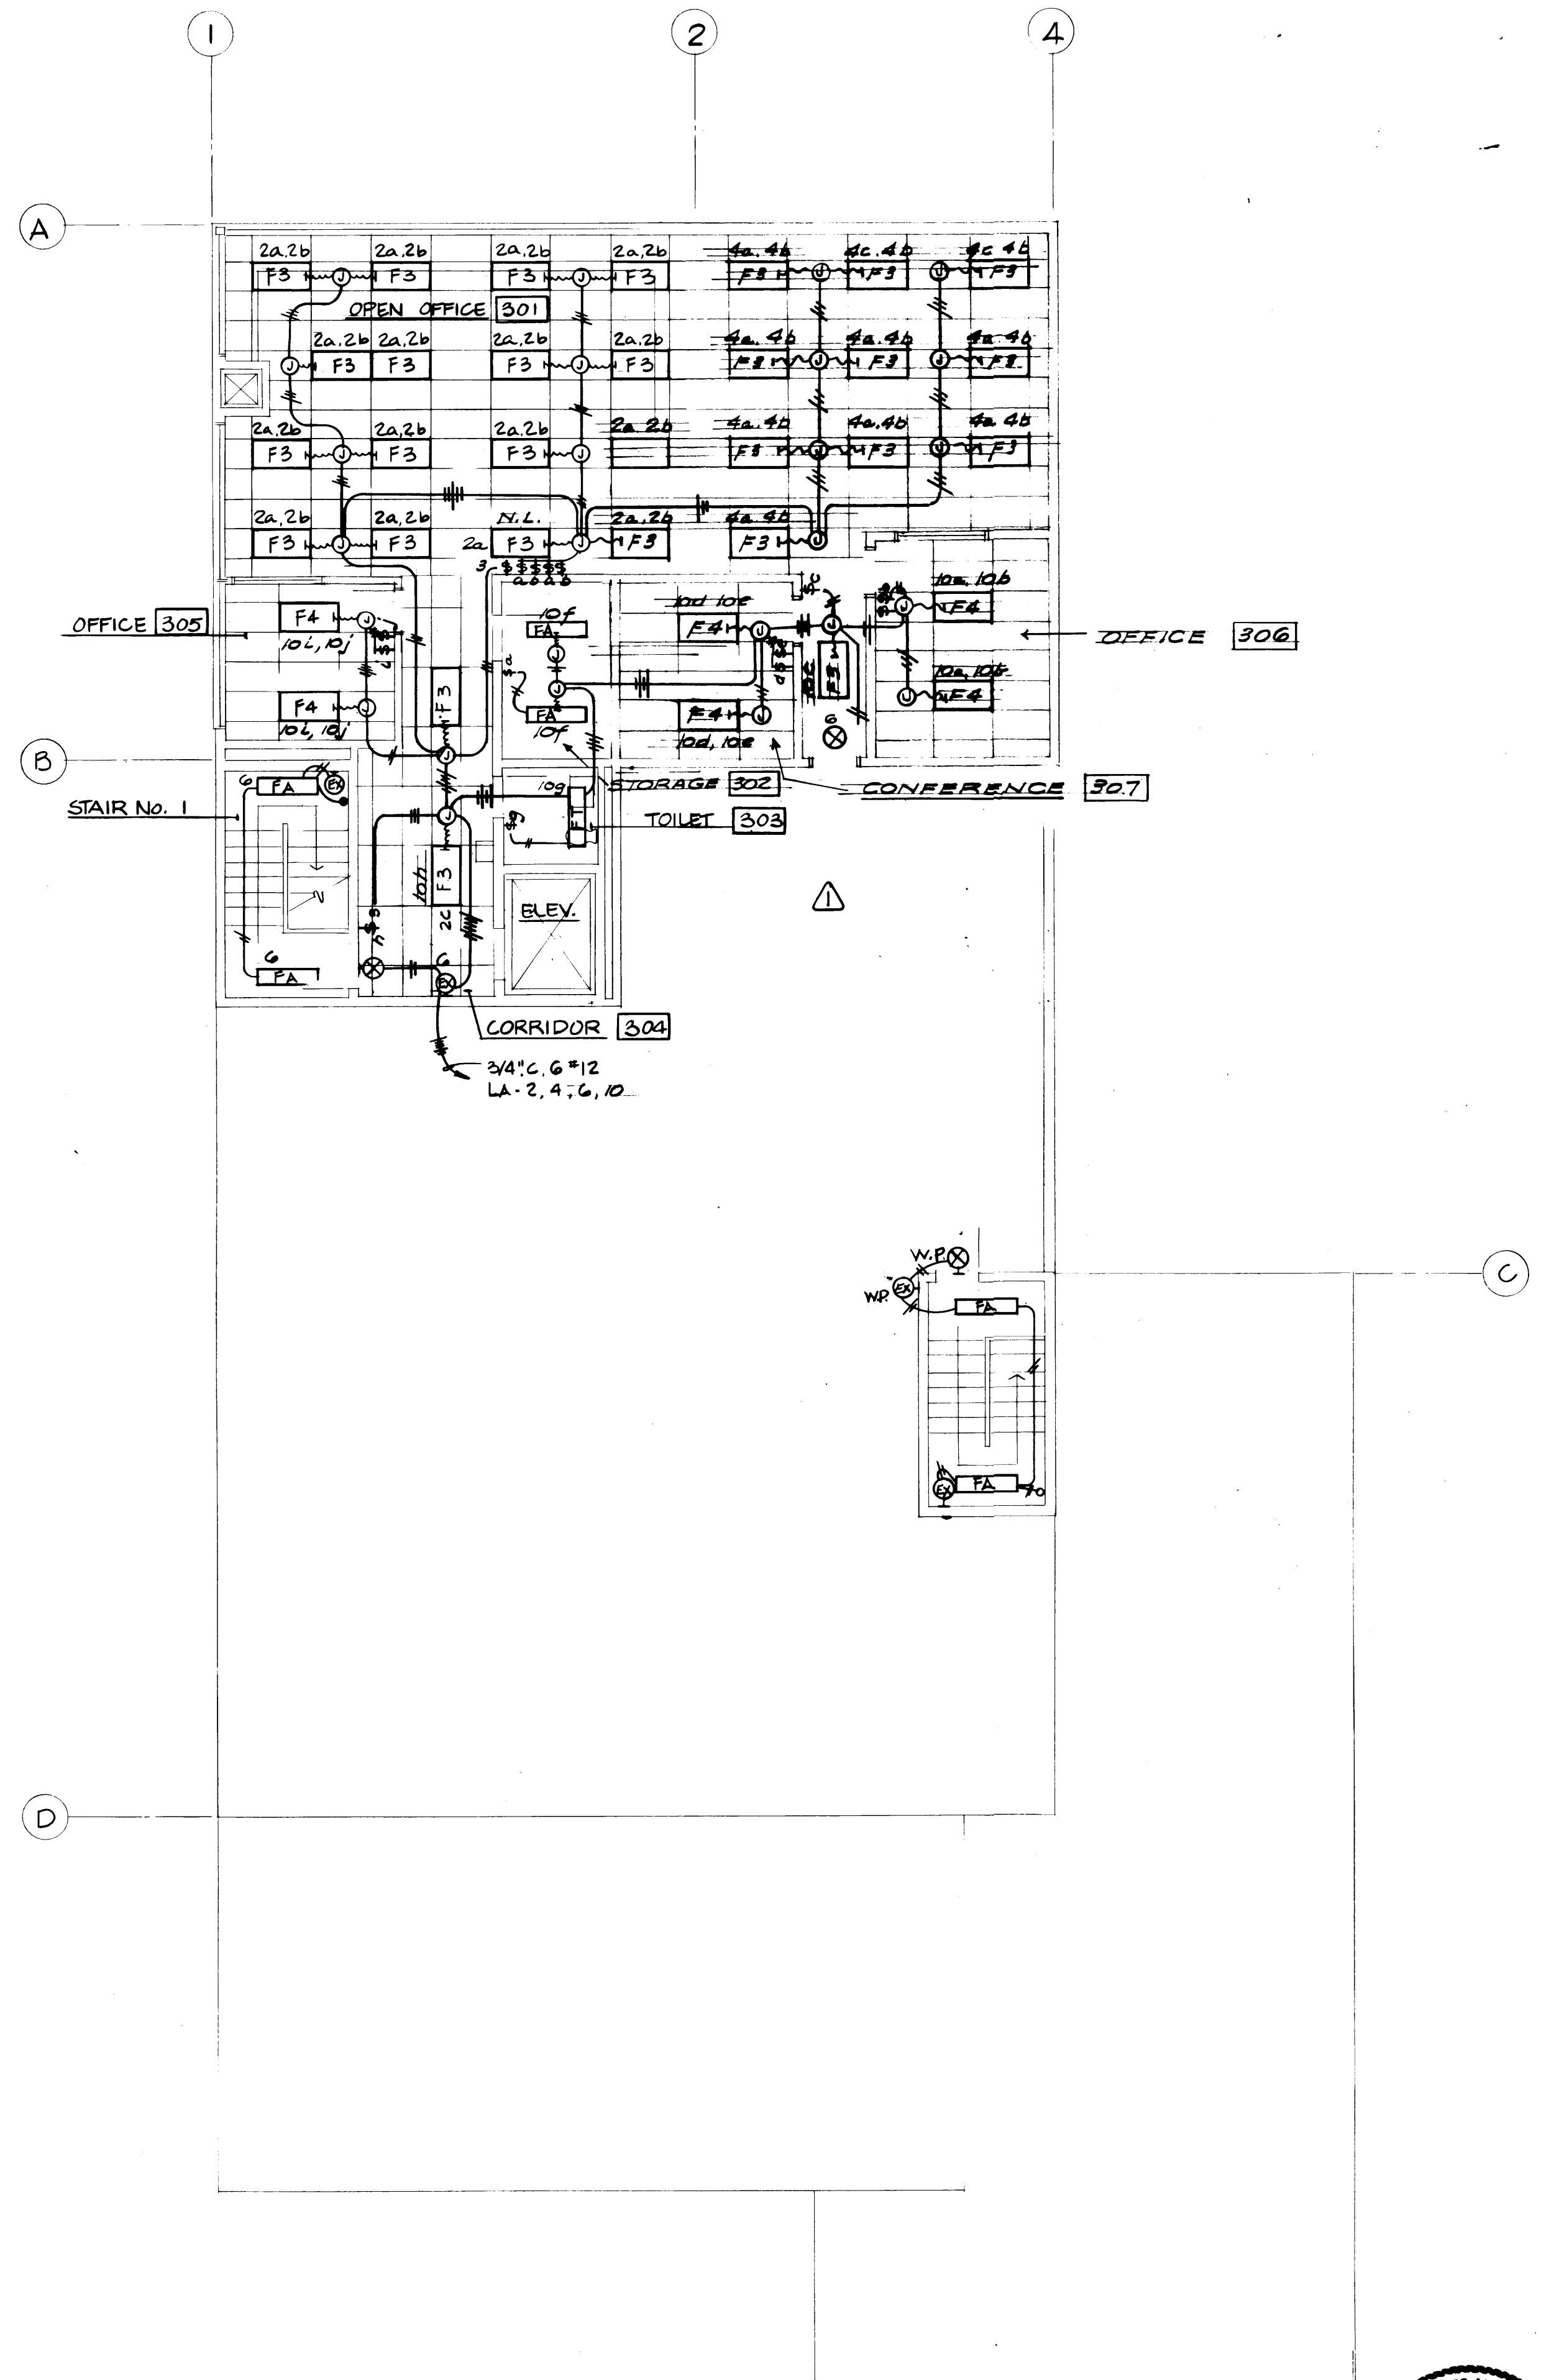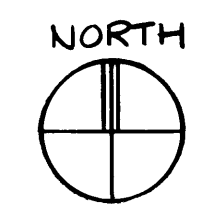

THIRD FLOOR LIGHTING PLAN
SCALE: 1/8" = 1' - 0"

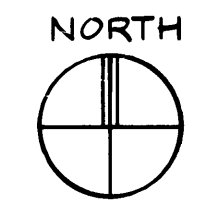

PORT OF TACOMA TACOMA TERMINALS, INC. MARINE SERVICES BUILDING SECOND & THIRD FLOOR LIGHTING PLANS	
DRAWN _____ DATE _____ CHECKED _____ DATE _____ CHECKED _____ DATE _____ CONT. NO. 602	FIELD BOOK (S) _____ APPROVED _____ PROJECT MANAGER _____ CHIEF ENGINEER _____ DATE 9/24/84
REVISION _____ BY _____ APP. _____ DATE _____	DRAWING NO. EP-3893-23 6-E11-2 SHEET E11-2 OF 8

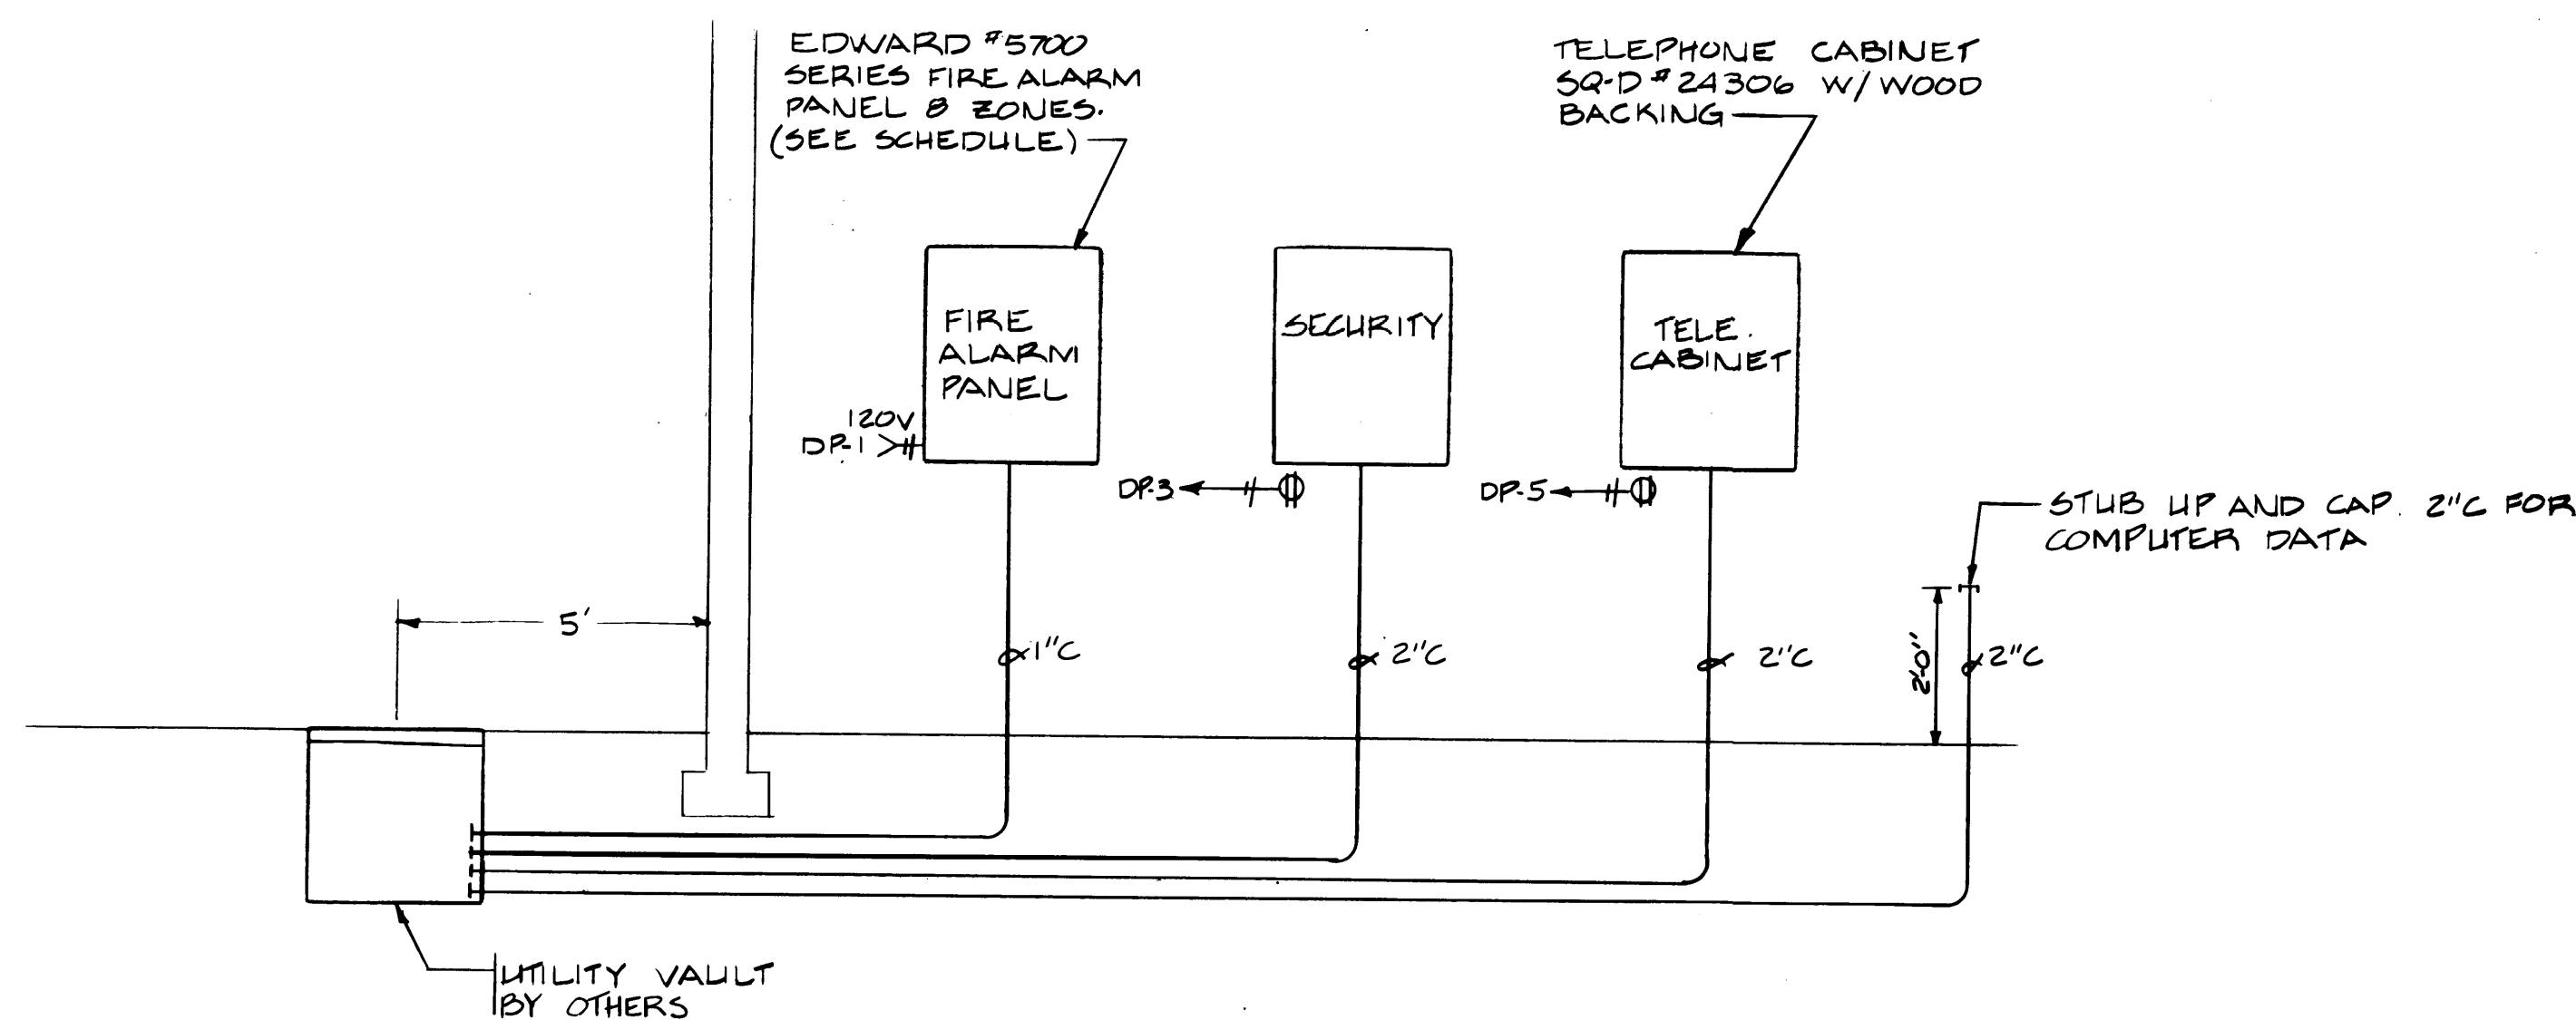



SYSTEM RISER DIAGRAM
NOT TO SCALE

FIRE ALARM SCHEDULE

FLOOR	ZONE	DEVICE NO	REMARKS
1	1	1 THRU 31	
1	2	37 THRU 44	
2	3	50 THRU 61	
3	4	67 THRU 76	

LOAD CALCULATIONS

LOAD	CONNECTED LOAD (KVA)	DEMAND LOAD (KVA)	DEMAND AMPERE	FEEDER REQ'D	FEEDER SPECIFIED
HVAC #1	43	43	52	65	85
PANEL 'LA'	24	24	29	36	100
PANEL 'PB'	81	81	98	123	205
PANEL 'PA'	192	154	186	232	410
ELEVATOR	28	28	34	43	85
H.W. TANK	24	24	29	36	50
PANEL 'RA'	14	13	36	45	100
PANEL 'RB'	26	18	50	63	155
PANEL 'RC'	23	18	49	61	100
PANEL 'RD'	17	15	42	53	100
PANEL 'DP'	82	46	128	160	360
TOTAL	474	400	482	603	810

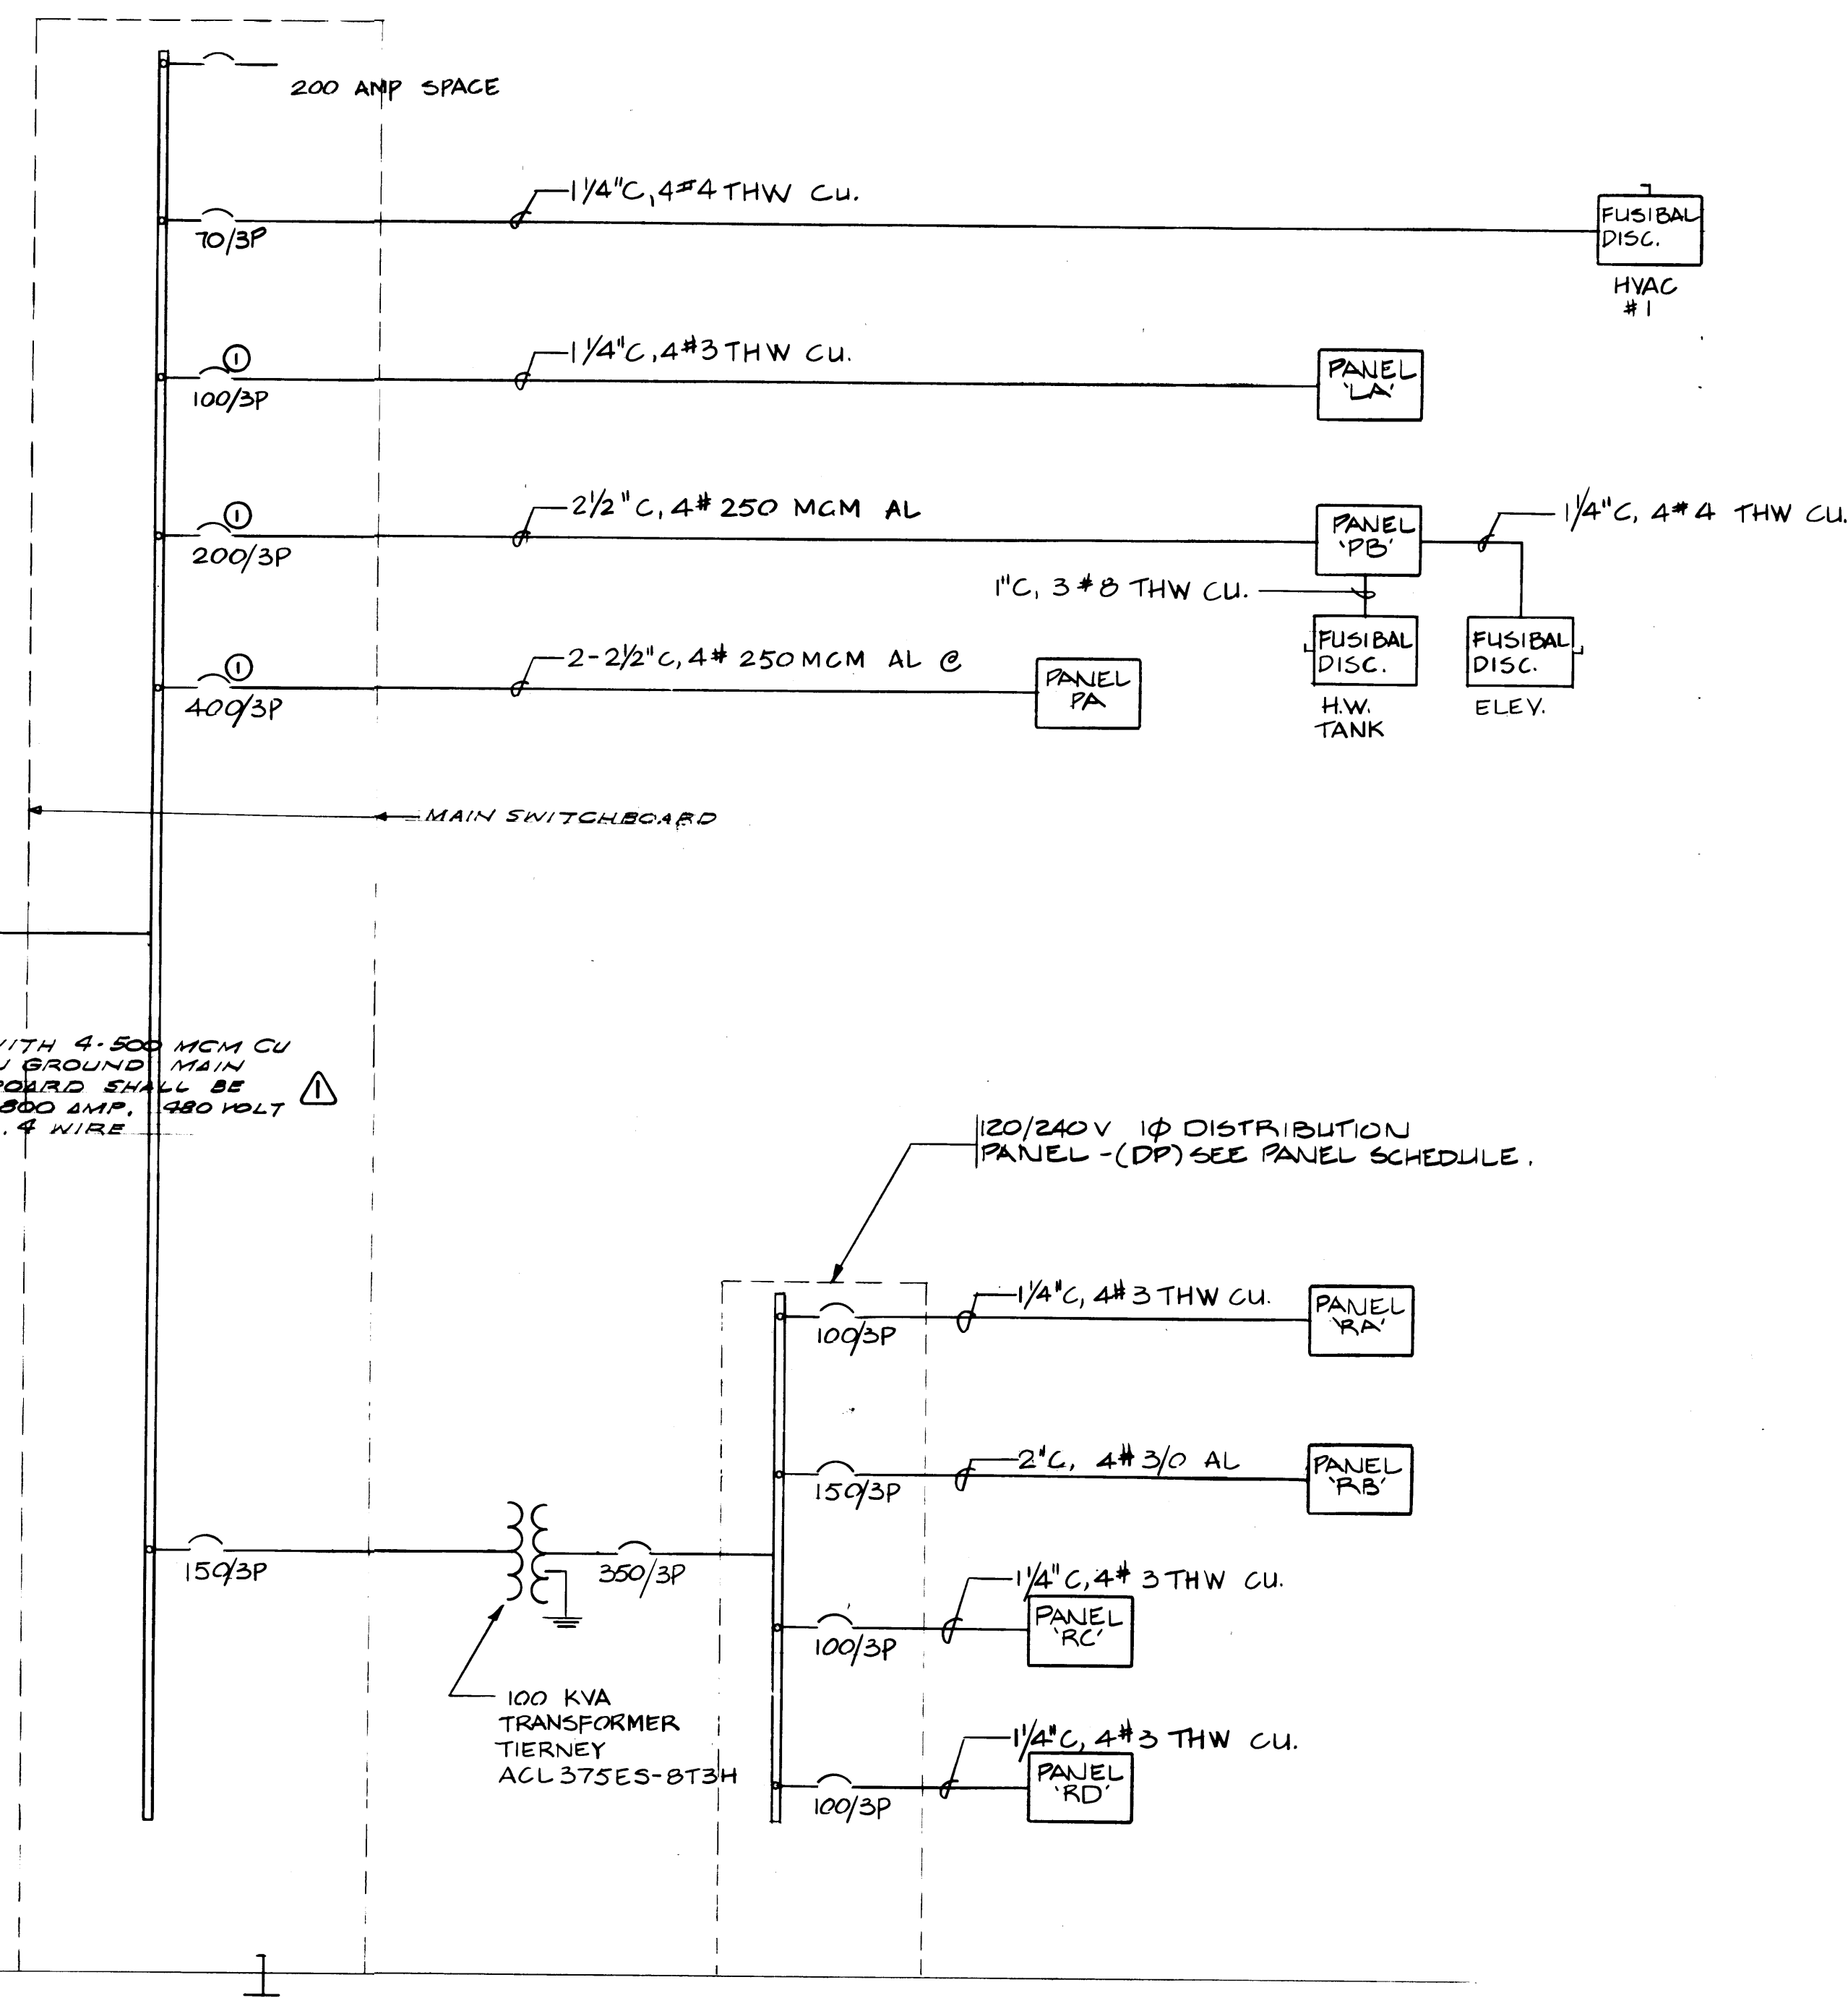
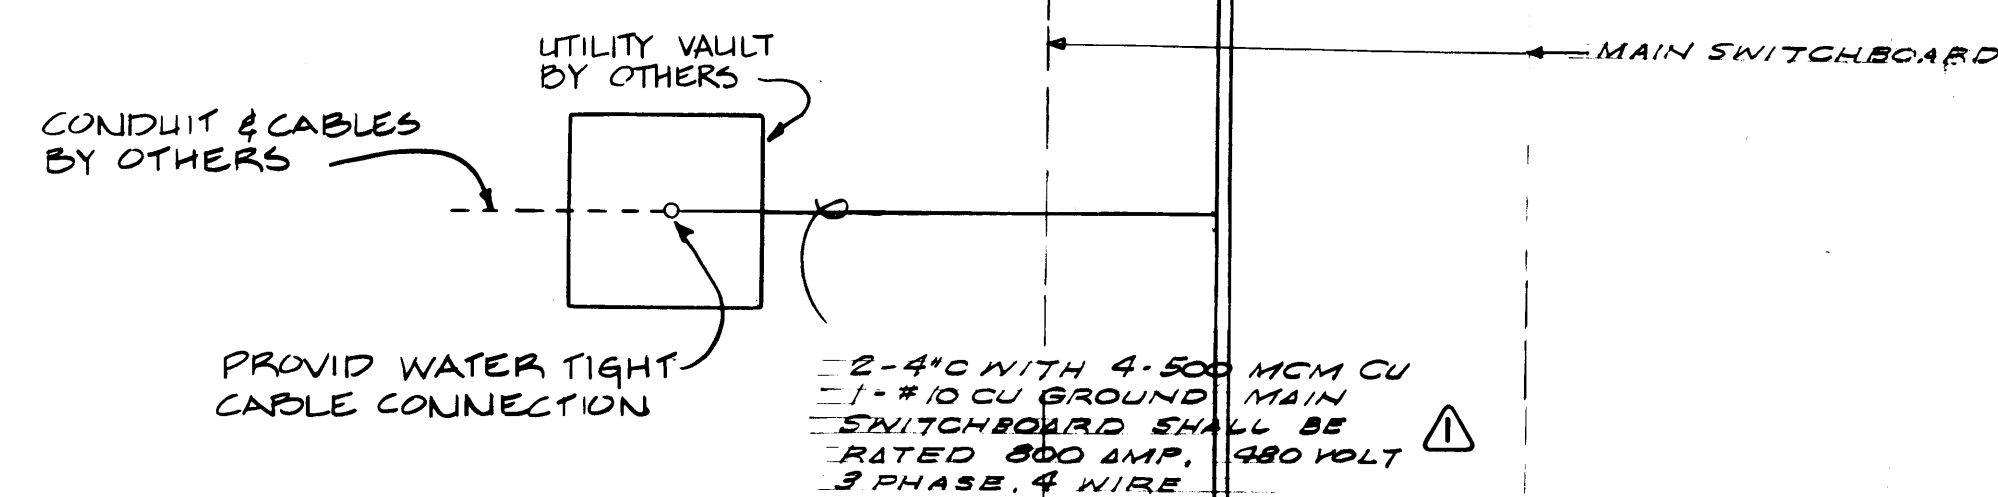


ONE LINE DIAGRAM

NO SCALE:

NOTES:

- PROVIDE CURRENT LIMITING CIRCUIT BREAKER
- PROVIDE MAIN SWITCHBOARD WITH 75,000 AIC RATING

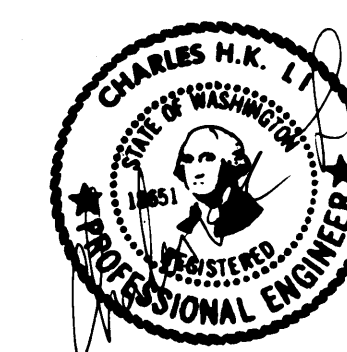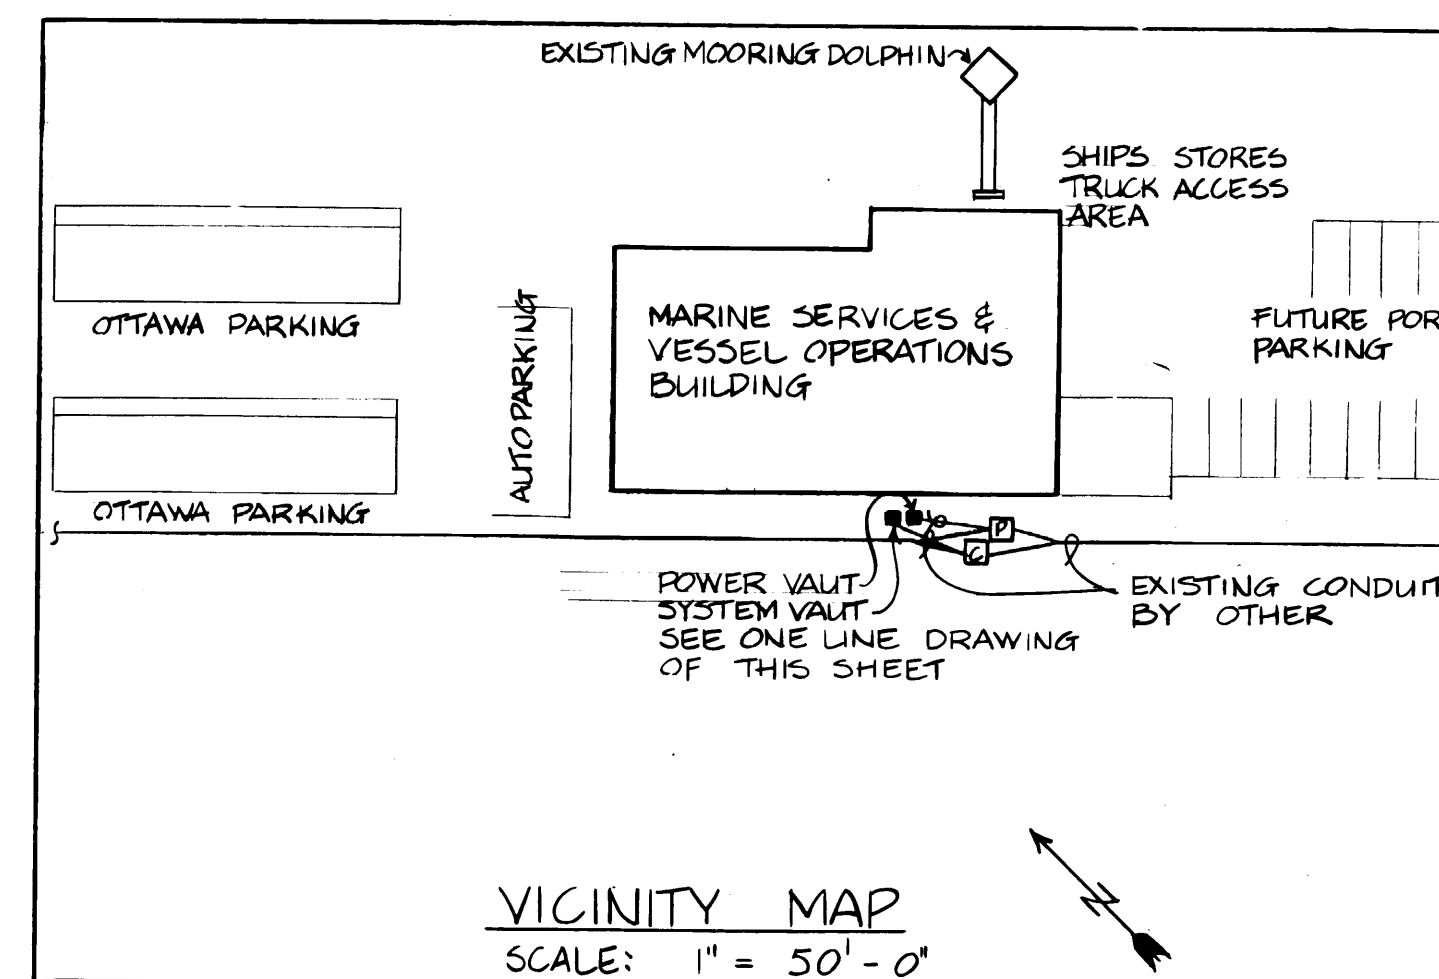

DRAWN		DATE		CHECKED		DATE		CHECKED		DATE		CONT. NO. 502		FIELD BOOK (S)		SCALE	
APPROVED		DATE		PROJECT MANAGER		DATE		CHIEF ENGINEER		DATE		DRAWING NO. EP-3893-23		SHEET E11-5 OF 5		6-E11-5	

MARK	REVISION	BY	APP.	DATE
1	REVISED TO AS BUILT	R.J.S.		9/11/85